
 


Roof Plan

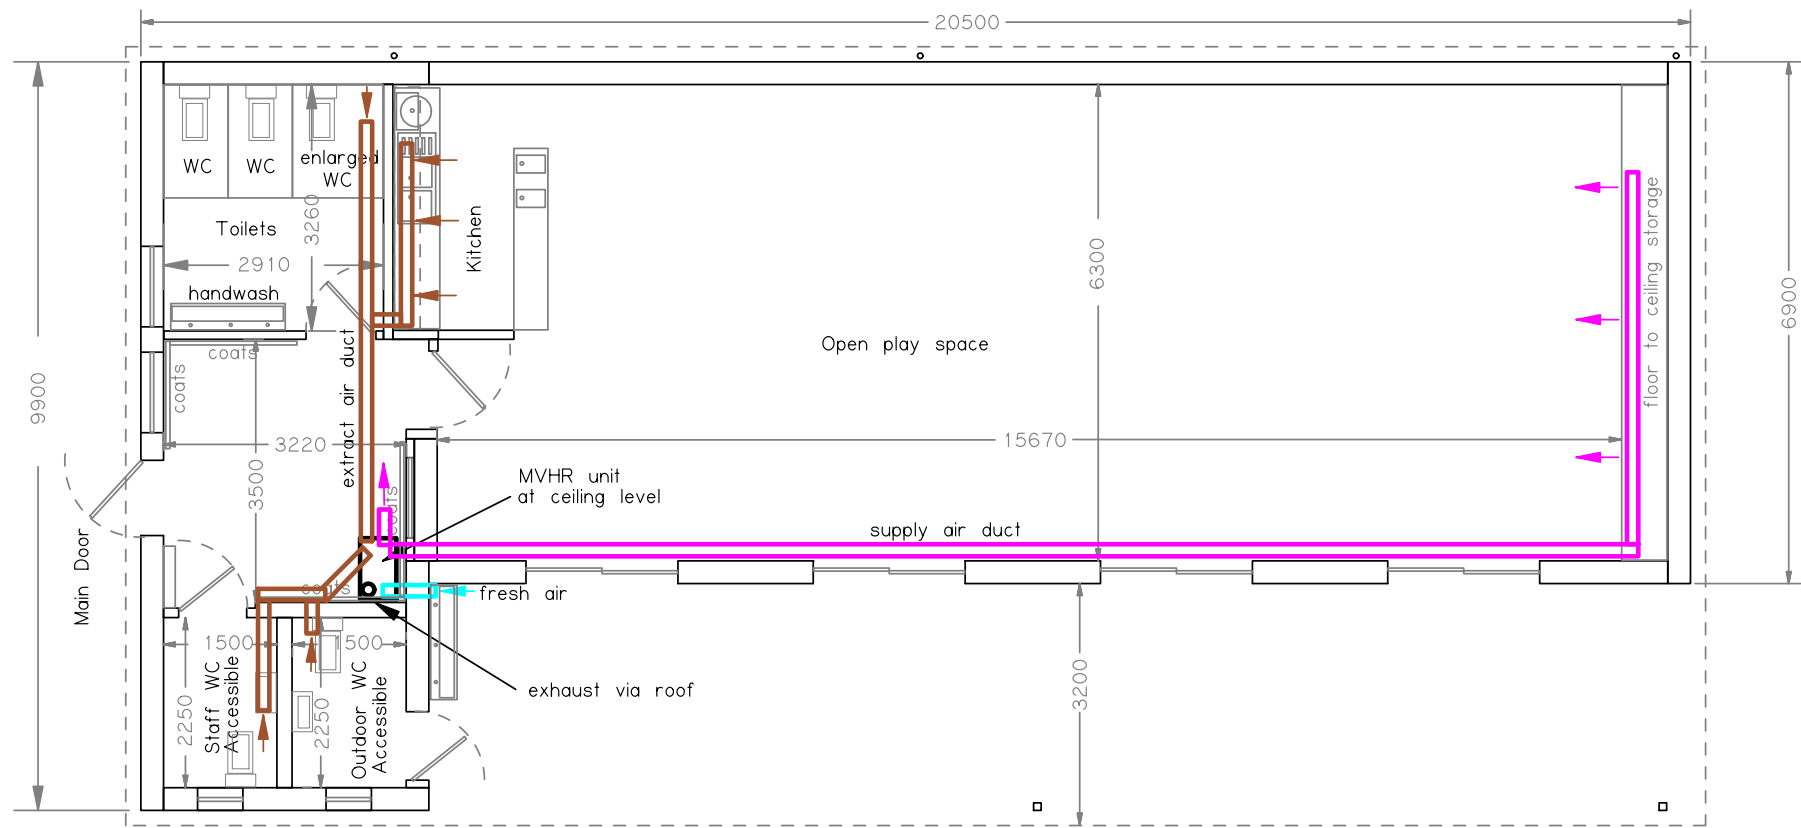

Ventilation Duct Route Plan



P1 - original preliminary

Toby Hartley

Cornerstone's Nursery  
Blairgowrie

Client

New Facility

Cornerstone's Nursery  
Blairgowrie

Project

Proposed Plans  
Roof and Ventilation

( Scale 1 : 100 )

1110/22

Drawing Number

KELLSTON DEVELOPERS LTD

P1

Revision