


Location plan  
Scale 1:1000

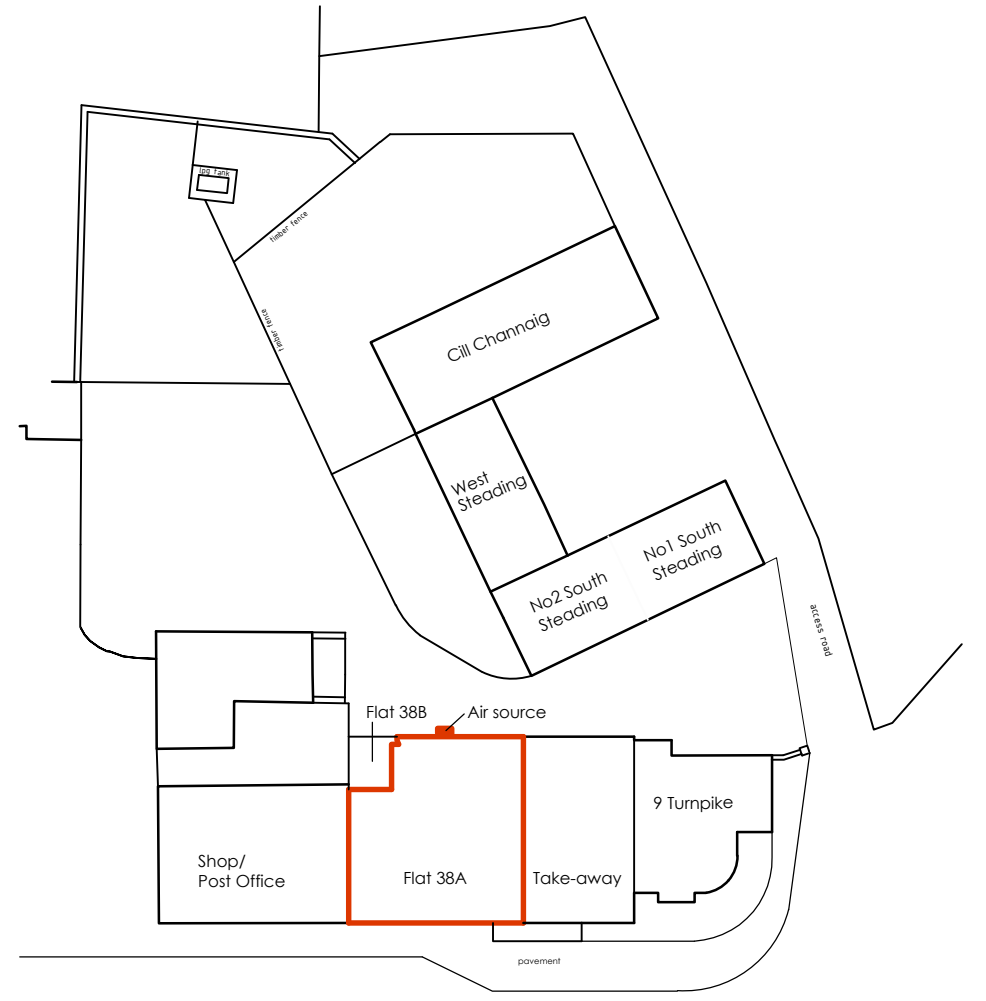

Site plan  
Scale 1:500

38a North Deeside Road  
Kincardine O Neil  
Aberdeenshire  
AB34 5AA

Proposed Air source heat pump

Site plan and Location

Date : Oct 2021  
Scale : 1:100  
Drawn : PST

Drawing No.  
2021-118/P01

**Gerry Robb**  
architectural design services

Bridgend  
Bridgeview Road  
Aboyne  
Aberdeenshire  
AB34 5HB  
(013398) 86359  
info@gerryrobb.co.uk