
 

 


 
 
 

 
 
 






 
 

 

 




 
 

 





 
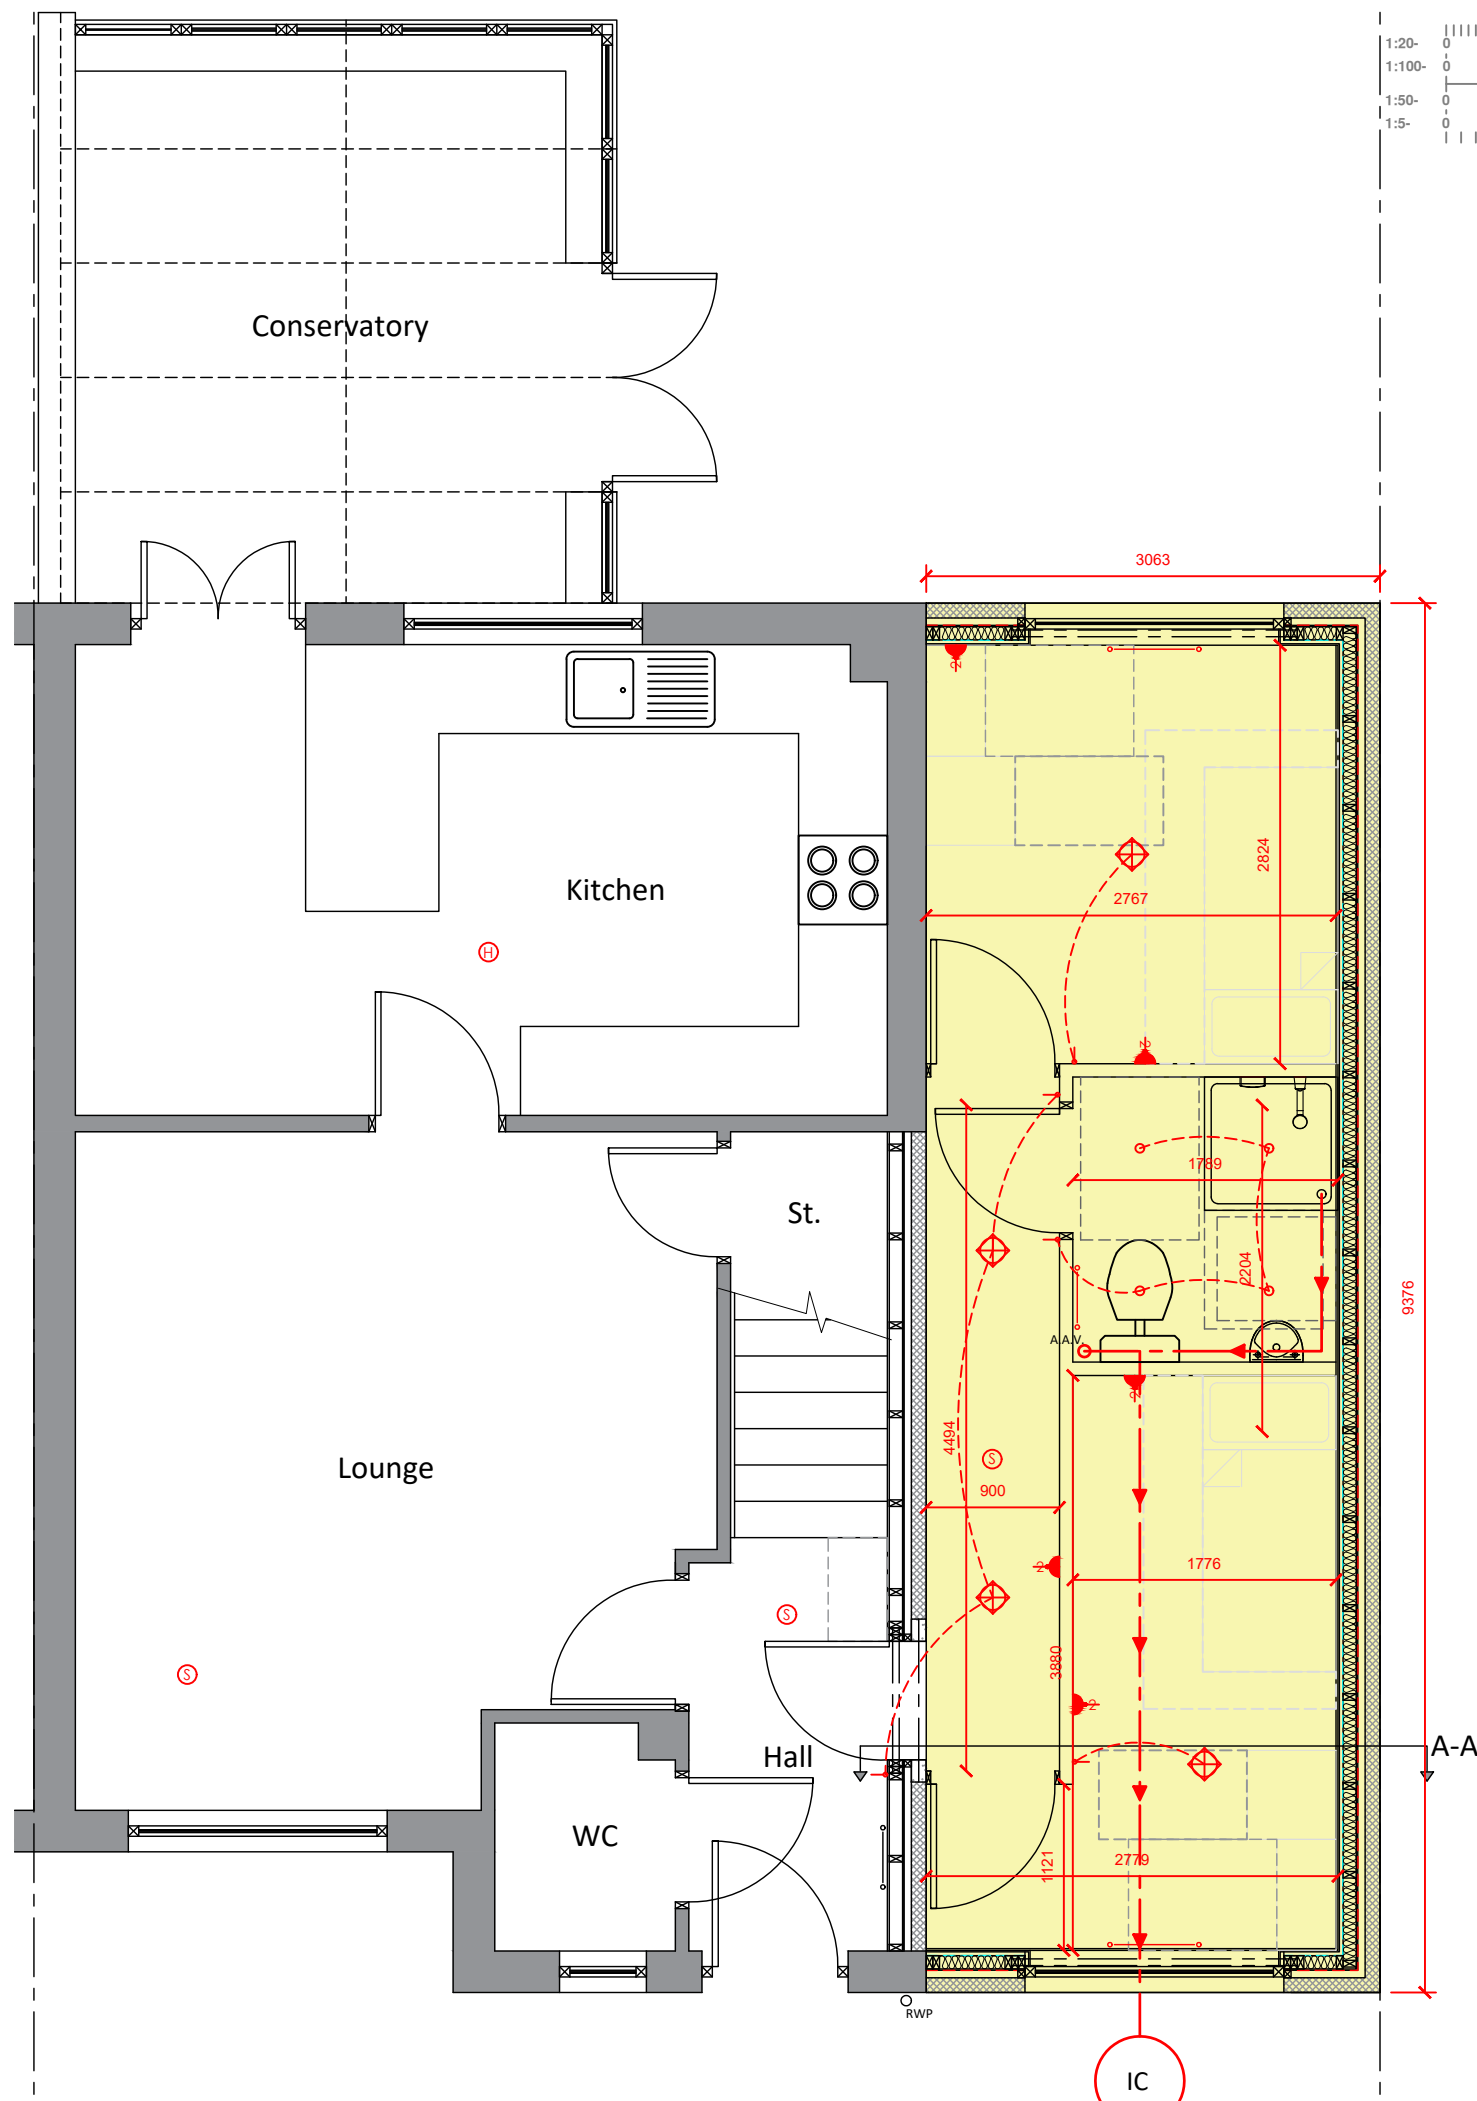


KEY SYMBOL

-  SINGLE SWITCHED WALL SOCKET
-  DOUBLE SWITCHED WALL SOCKET
-  SINGLE SWITCHED WALL SOCKET 1200MM ABOVE FLOOR LEVEL
-  DOUBLE SWITCHED WALL SOCKET 1200MM ABOVE FLOOR LEVEL
-  SINGLE SWITCHED FUSE SPUR BELOW WORKTOP LEVEL
-  FUSE SPUR FOR TOWEL RAIL
-  SINGLE SWITCHED FUSE SPUR AT HIGH LEVEL FOR EXTRACT FAN
-  DOUBLE SWITCHED FLOOR SOCKETS
-  1 GANG LIGHT SWITCH
-  2 GANG LIGHT SWITCH
-  3 GANG LIGHT SWITCH
-  1 GANG 2 WAY LIGHT SWITCH
-  2 GANG 2 WAY LIGHT SWITCH
-  1 GANG 3 WAY LIGHT SWITCH
-  2 GANG 3 WAY LIGHT SWITCH
-  1 GANG PULL CORD LIGHT SWITCH
-  EXTERNAL LIGHT
-  EXTERNAL LIGHT - BULKHEAD TYPE
-  RECESSED DOWNLIGHTER
-  WALL LIGHT
-  LIGHT POINT - PENDANT HOLDER (4 INCH)
-  LIGHT POINT - PENDANT HOLDER (6 INCH)
-  LIGHT POINT - BATTEN HOLDER
-  FLUORESCENT STRIP LIGHT
-  TV AERIAL POINT
-  MECHANICAL EXTRACT FAN
-  THERMOSTAT
-  SECURITY ALARM
-  CONSUMER UNIT
-  TELEPHONE POINT
-  CAT 5 or 6 DATA SOCKET
-  COOKER SWITCH
-  MECHANICAL EXTRACT FAN COOKER HOB HOOD
-  COMBINED HEAT DETECTOR AND FIRE ALARM SOUNDER
-  SMOKE DETECTOR AND FIRE ALARM SOUNDER
-  CARBON MONOXIDE DETECTOR ALARM SOUNDER
-  RADIATOR
-  BOILER





**Fairgrove**  
Main Street  
Skinflats  
FK2 8NU  
07977611679

info@fairgrovearchitecturalservices.co.uk  
www.fairgrovearchitecturalservices.co.uk

Client: Mr & Mrs Shankly

Project Title: Erection of Side Extension to Dwelling for Planning Approval

Drawing Title: Proposed Floor Plan @ 3 Whitacres Road, Glasgow, G53 7NL

Date: 6 <sup>th</sup> October 2021	A3
Scale: 1:50	
Drawn By: SF	
Drawing No.: SHANKLY.04	
Rev.	