 



Helmingham Hall water leak repairs - retrospective planning site plan - Location Plan

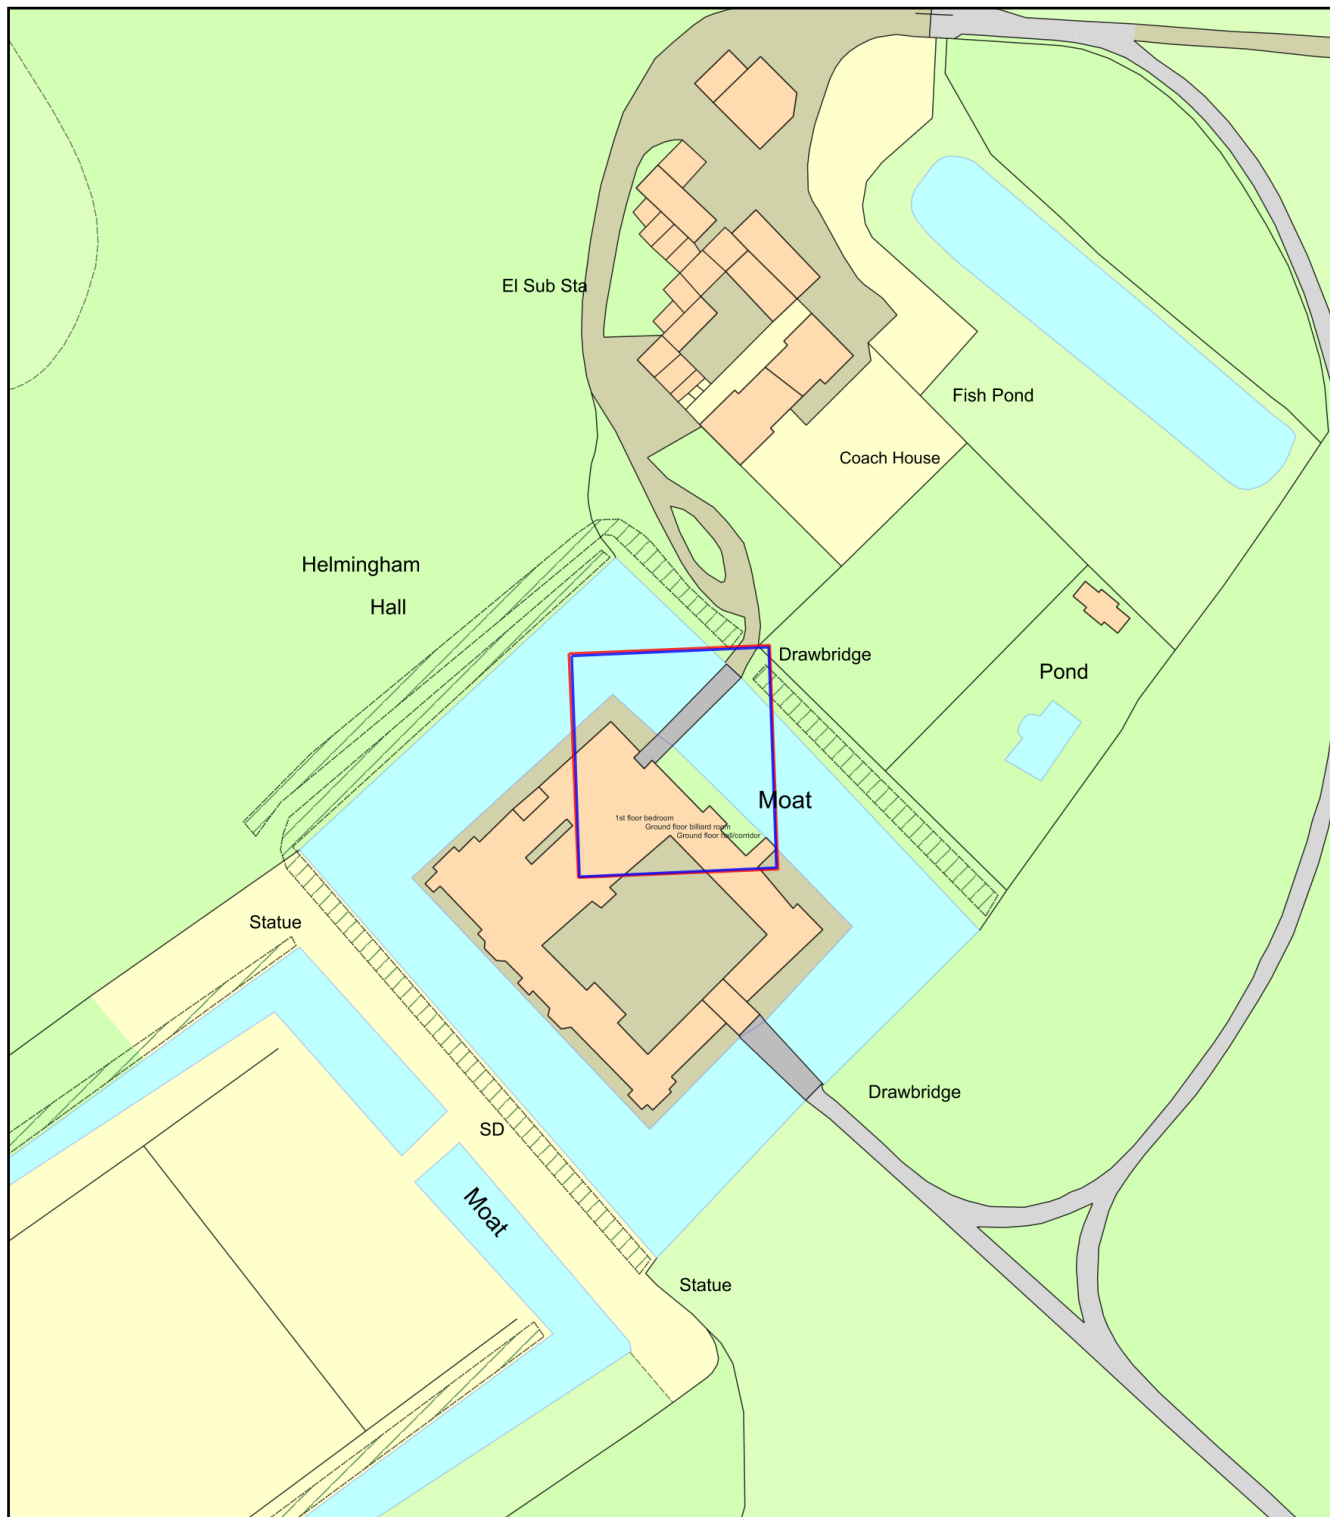

Plan Produced for: Farcroft/Edward Tollemache

Date Produced: 27 Oct 2021

Plan Reference Number: TQRQM21300222338648

Scale: 1:1250 @ A4