 
 



Helmingham Hall water leak repairs - retrospective planning site plan

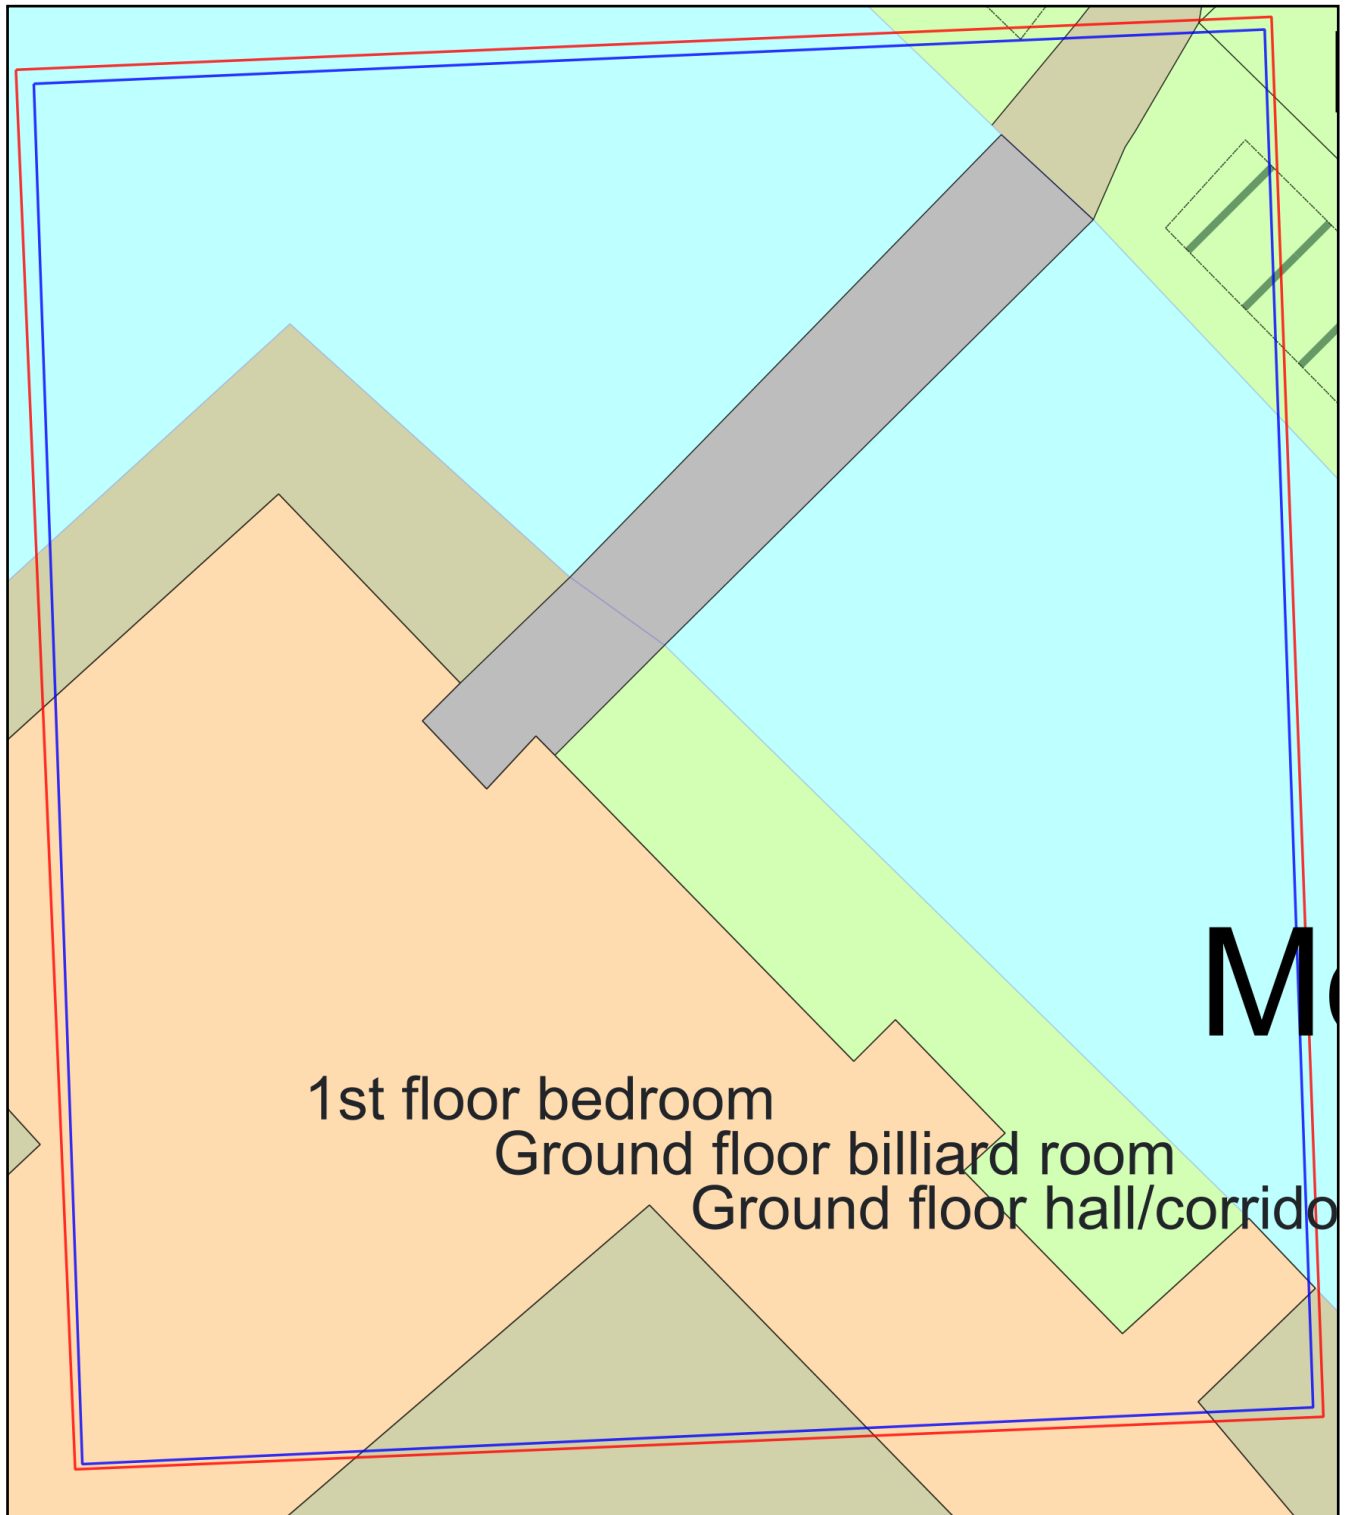

Plan Produced for: Farcroft/Edward Tollemache
Date Produced: 27 Oct 2021
Plan Reference Number: TQRQM21300221810872
Scale: 1:200 @ A4