



Site Plan showing location of proposed air source heat pump marked in red

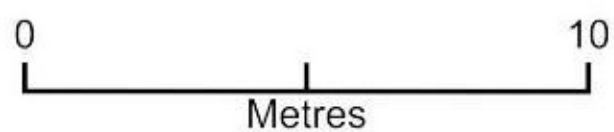

Plan Produced for:

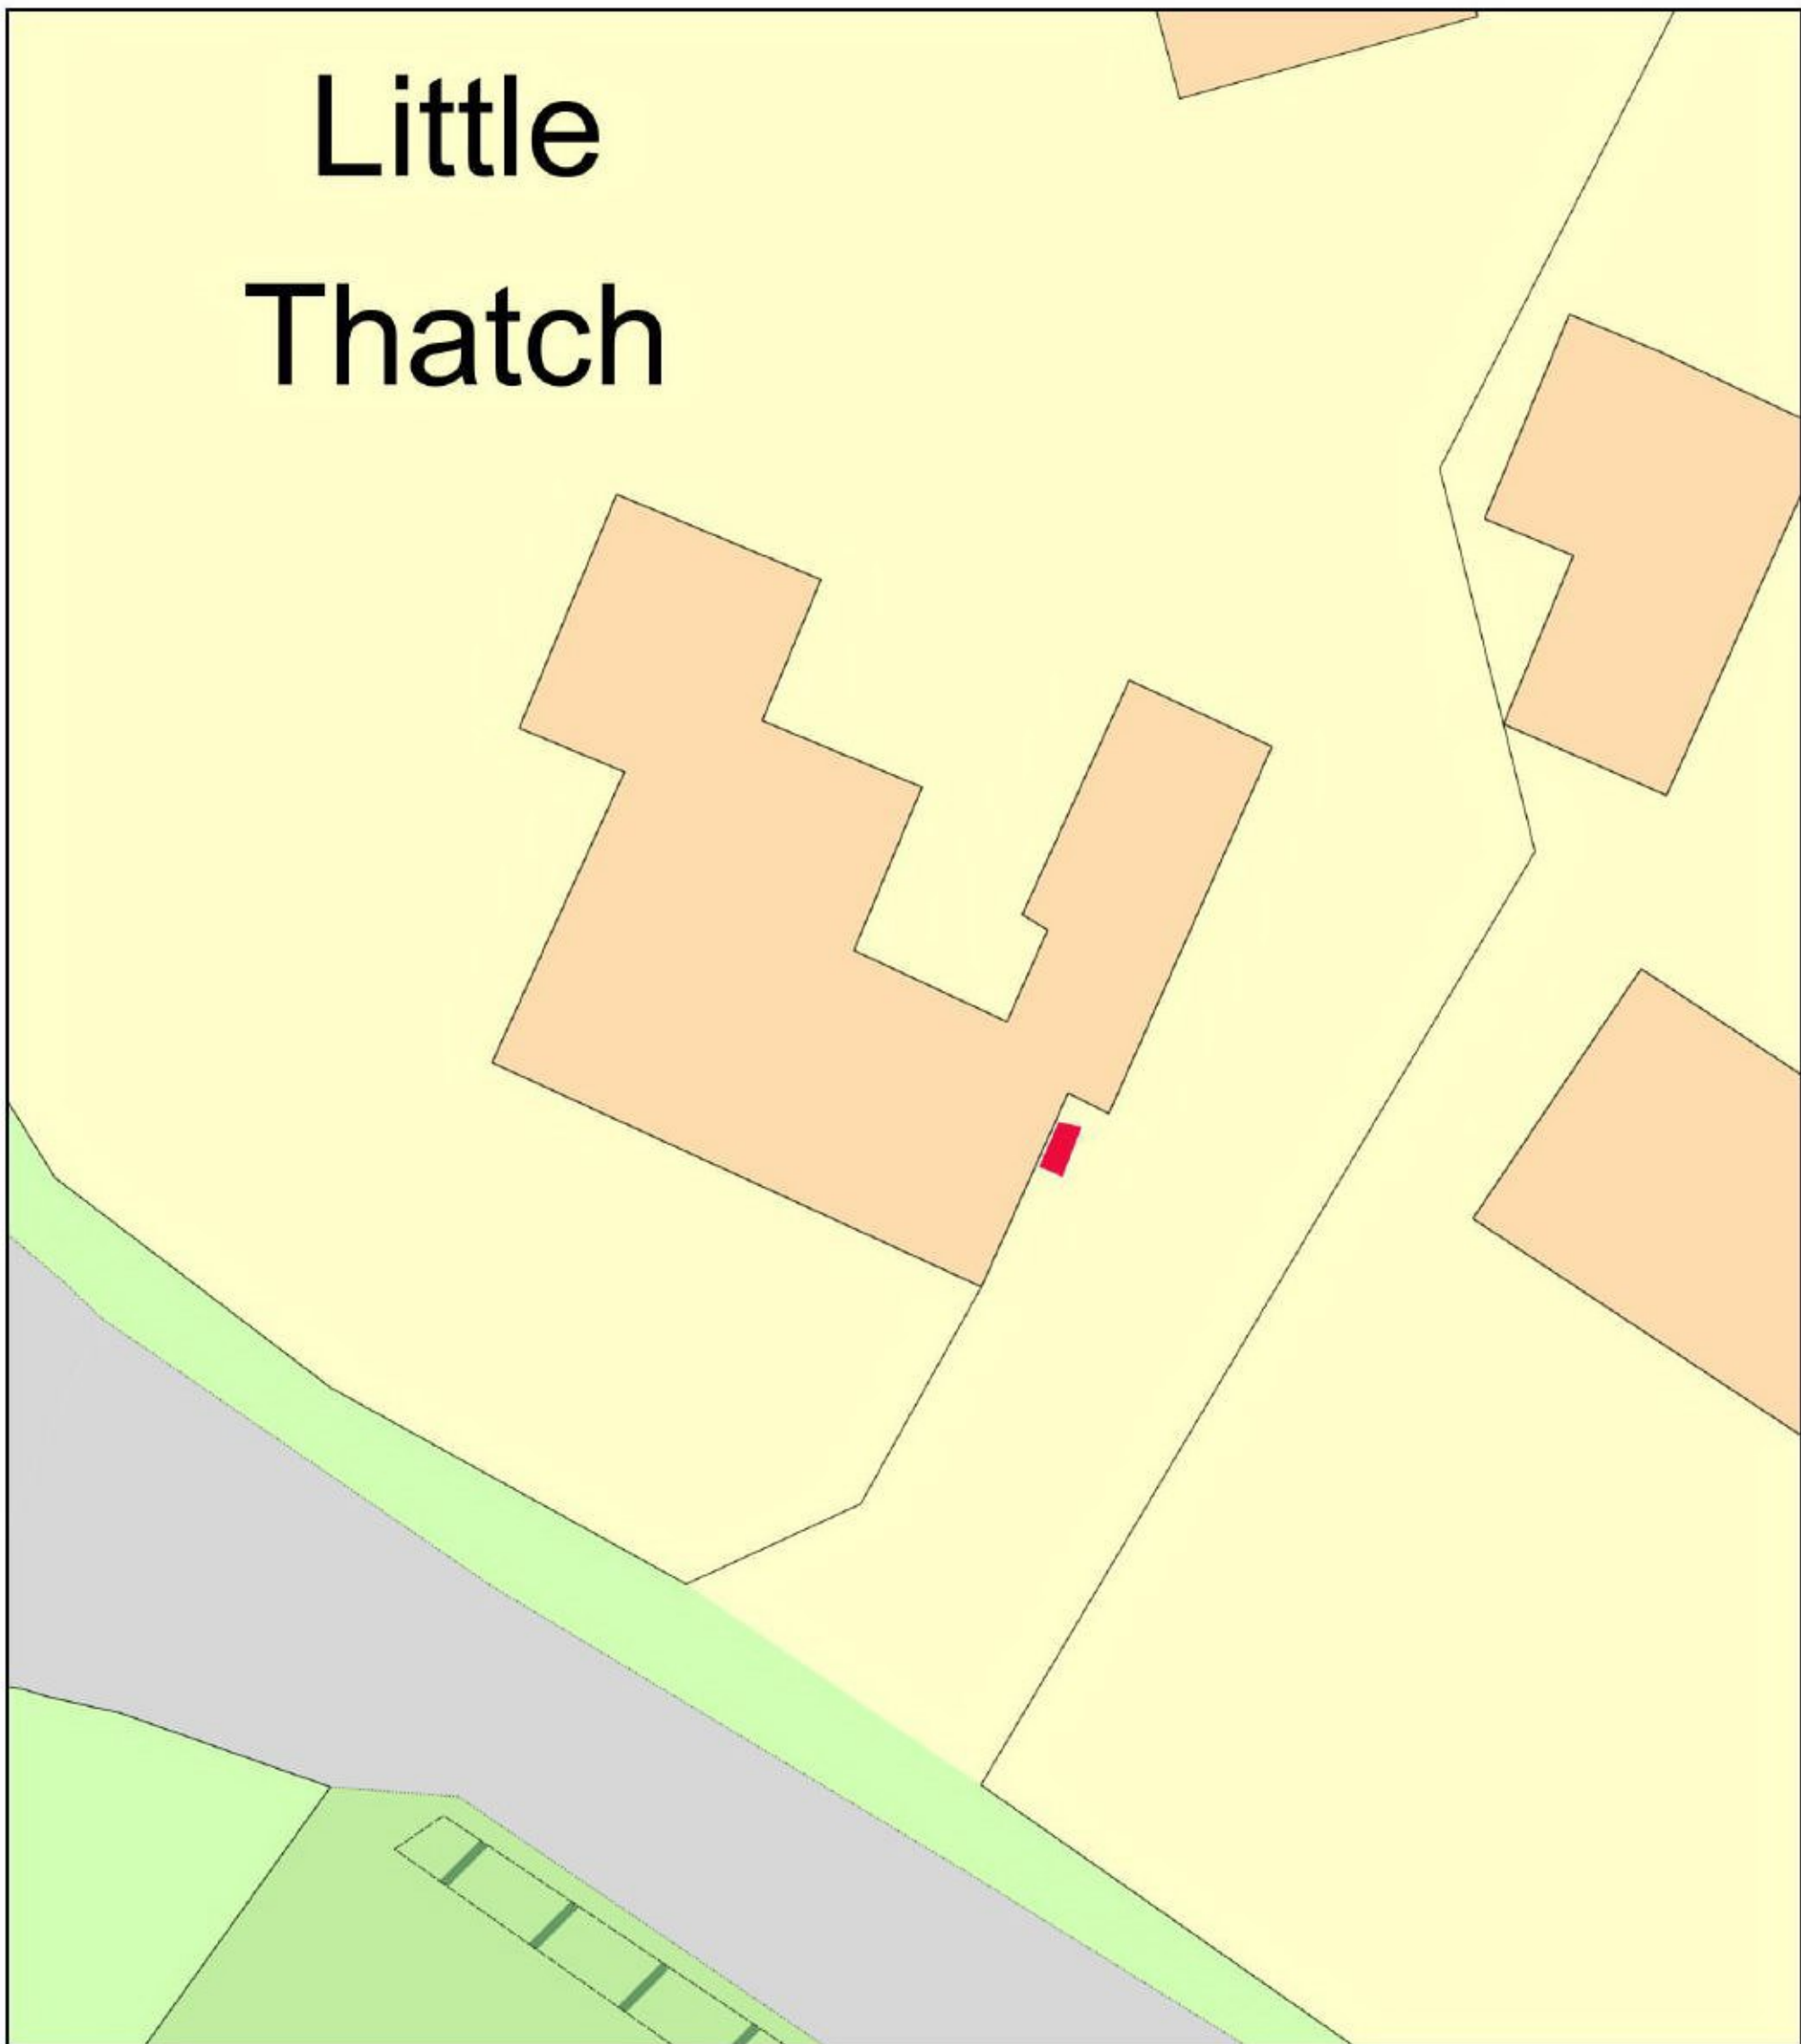

Date Produced: 09 Nov 2021

Plan Reference Number: TQRQM21313145759117

Scale: 1:200 @ A4