 



ELECTRICAL & WATER MAINS FROM HOUSE


DEDICATED SUPPLY FORM HYDRANT FOR FIRE SUPPRESSION SPRINKLER SYSTEM

WATER AND ELECTRICAL MAINS

**03 SERVICES AND DRAINAGE**  
SCALE 1:200

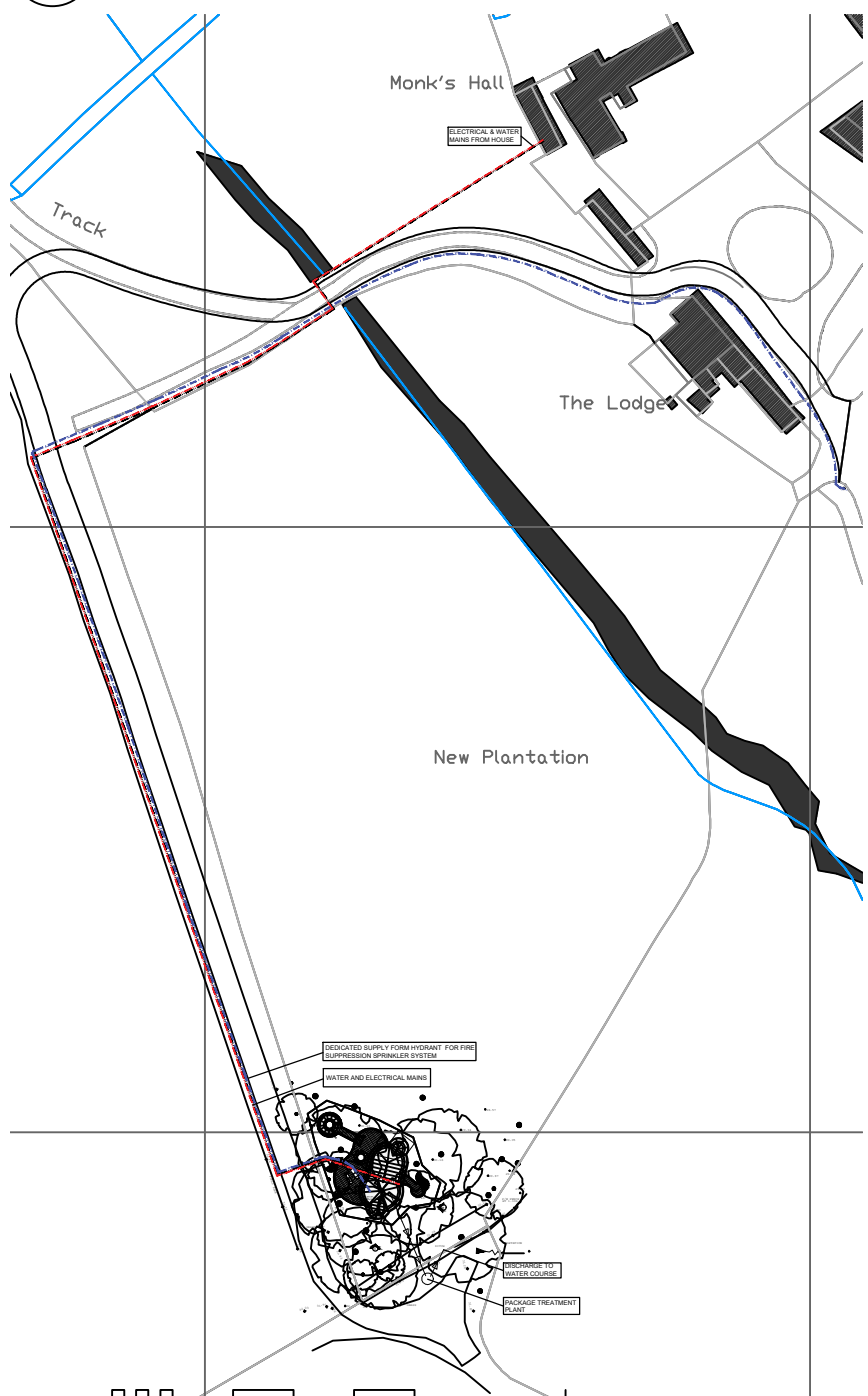

**01 SITE PLAN**  
SCALE 1:1250

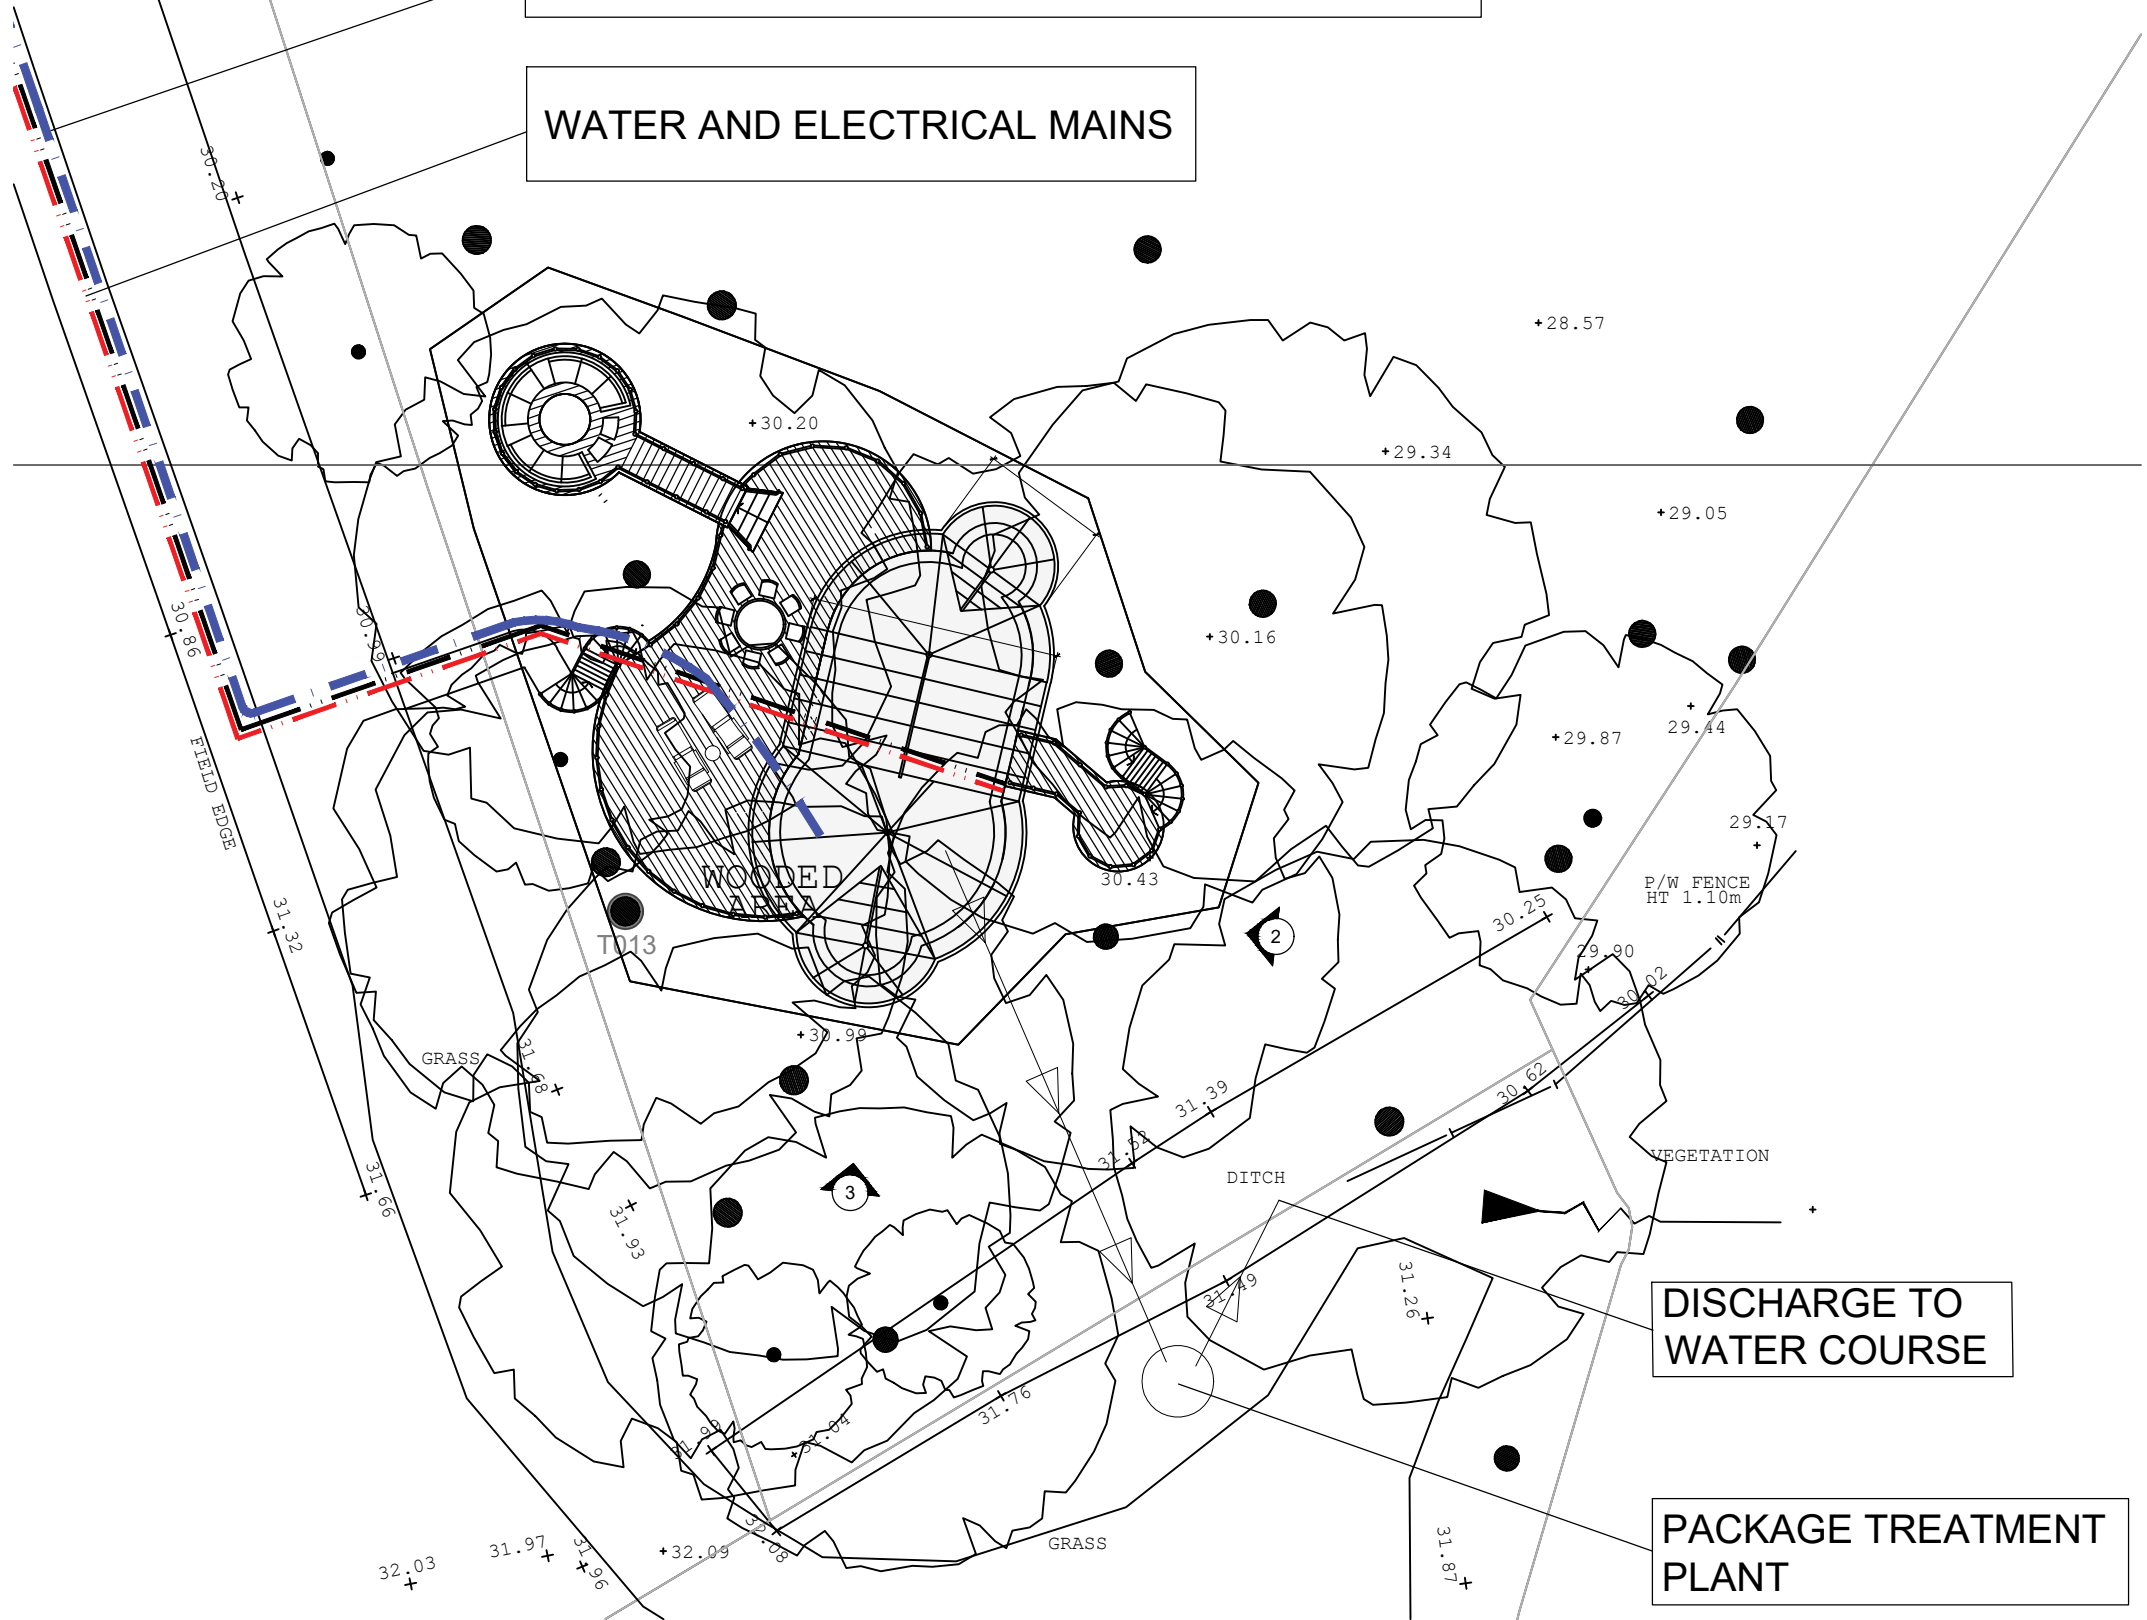

**02 SERVICES AND DRAINAGE**  
SCALE 1:200

Accommodation Schedule	
Room / Deck	M2/Lm
Tree House Internal	55.11
Main Deck	55.19
Upper Deck & Bridge	17.78
Rear Deck	7.66



Blue Forest (UK) Limited  
The Studio  
Bensfield Farm  
Beech Hill  
Wadhurst  
East Sussex  
TN5 6JR, UK  
t: +44 (0)1892 75 00 90  
e: info@blueforest.com  
w: www.blueforest.com

All dimensions are to be checked on site. Any discrepancies or variations are to be reported to Blue Forest (UK) Limited before work commences. Figured dimensions are only to be taken from this drawing. This drawing is to be read in conjunctions with all relevant consultants' and/or specialists drawings/documents and any discrepancies or variations are to be notified to Blue Forest (UK) Limited before the affected work commences. Copyright © Blue Forest (UK) Limited.

Rev	Date	Description
A	11/12/11	Services Adjusted
B	11/12/11	Services Adjusted

Client	GRI
Project Title	Monks Hall Treehouse
Drawing Title	Services and Drainage

Drawn by:	RSH	Client Number:	942	Drawing Number:	180
Checked By:	-	Drawing status:	PL	Revision:	B
Date:	22.10.21	Scale:	1:200	Format:	A3

NOTE : All dimensions are in millimetres.