

GENERAL NOTES


ALL DIMENSIONS TO BE CHECKED ON SITE PRIOR TO COMMENCEMENT OF WORKS - PLEASE REPORT ERRORS OR OMISSIONS TO THE ARCHITECT.

THIS DRAWING HAS BEEN PRODUCED FOR THE PURPOSES OF PLANNING AND BUILDING REGULATIONS APPROVALS ONLY AND IS NOT INTENDED TO BE A FULL WORKING DRAWING.

THIS DRAWING IS TO BE READ IN CONJUNCTION WITH ANY WRITTEN SPECIFICATIONS, SCHEDULES OF WORK AND STRUCTURAL ENGINEERS DETAILS AS APPROPRIATE.

THIS DRAWING IS THE COPYRIGHT OF PUMP HOUSE DESIGNS AND ANY FURTHER REPRODUCTION OF THE PLAN IS NOT PERMITTED WITHOUT OBTAINING PRIOR CONSENT.

© CROWN COPYRIGHT - LICENCE NO. 100032237

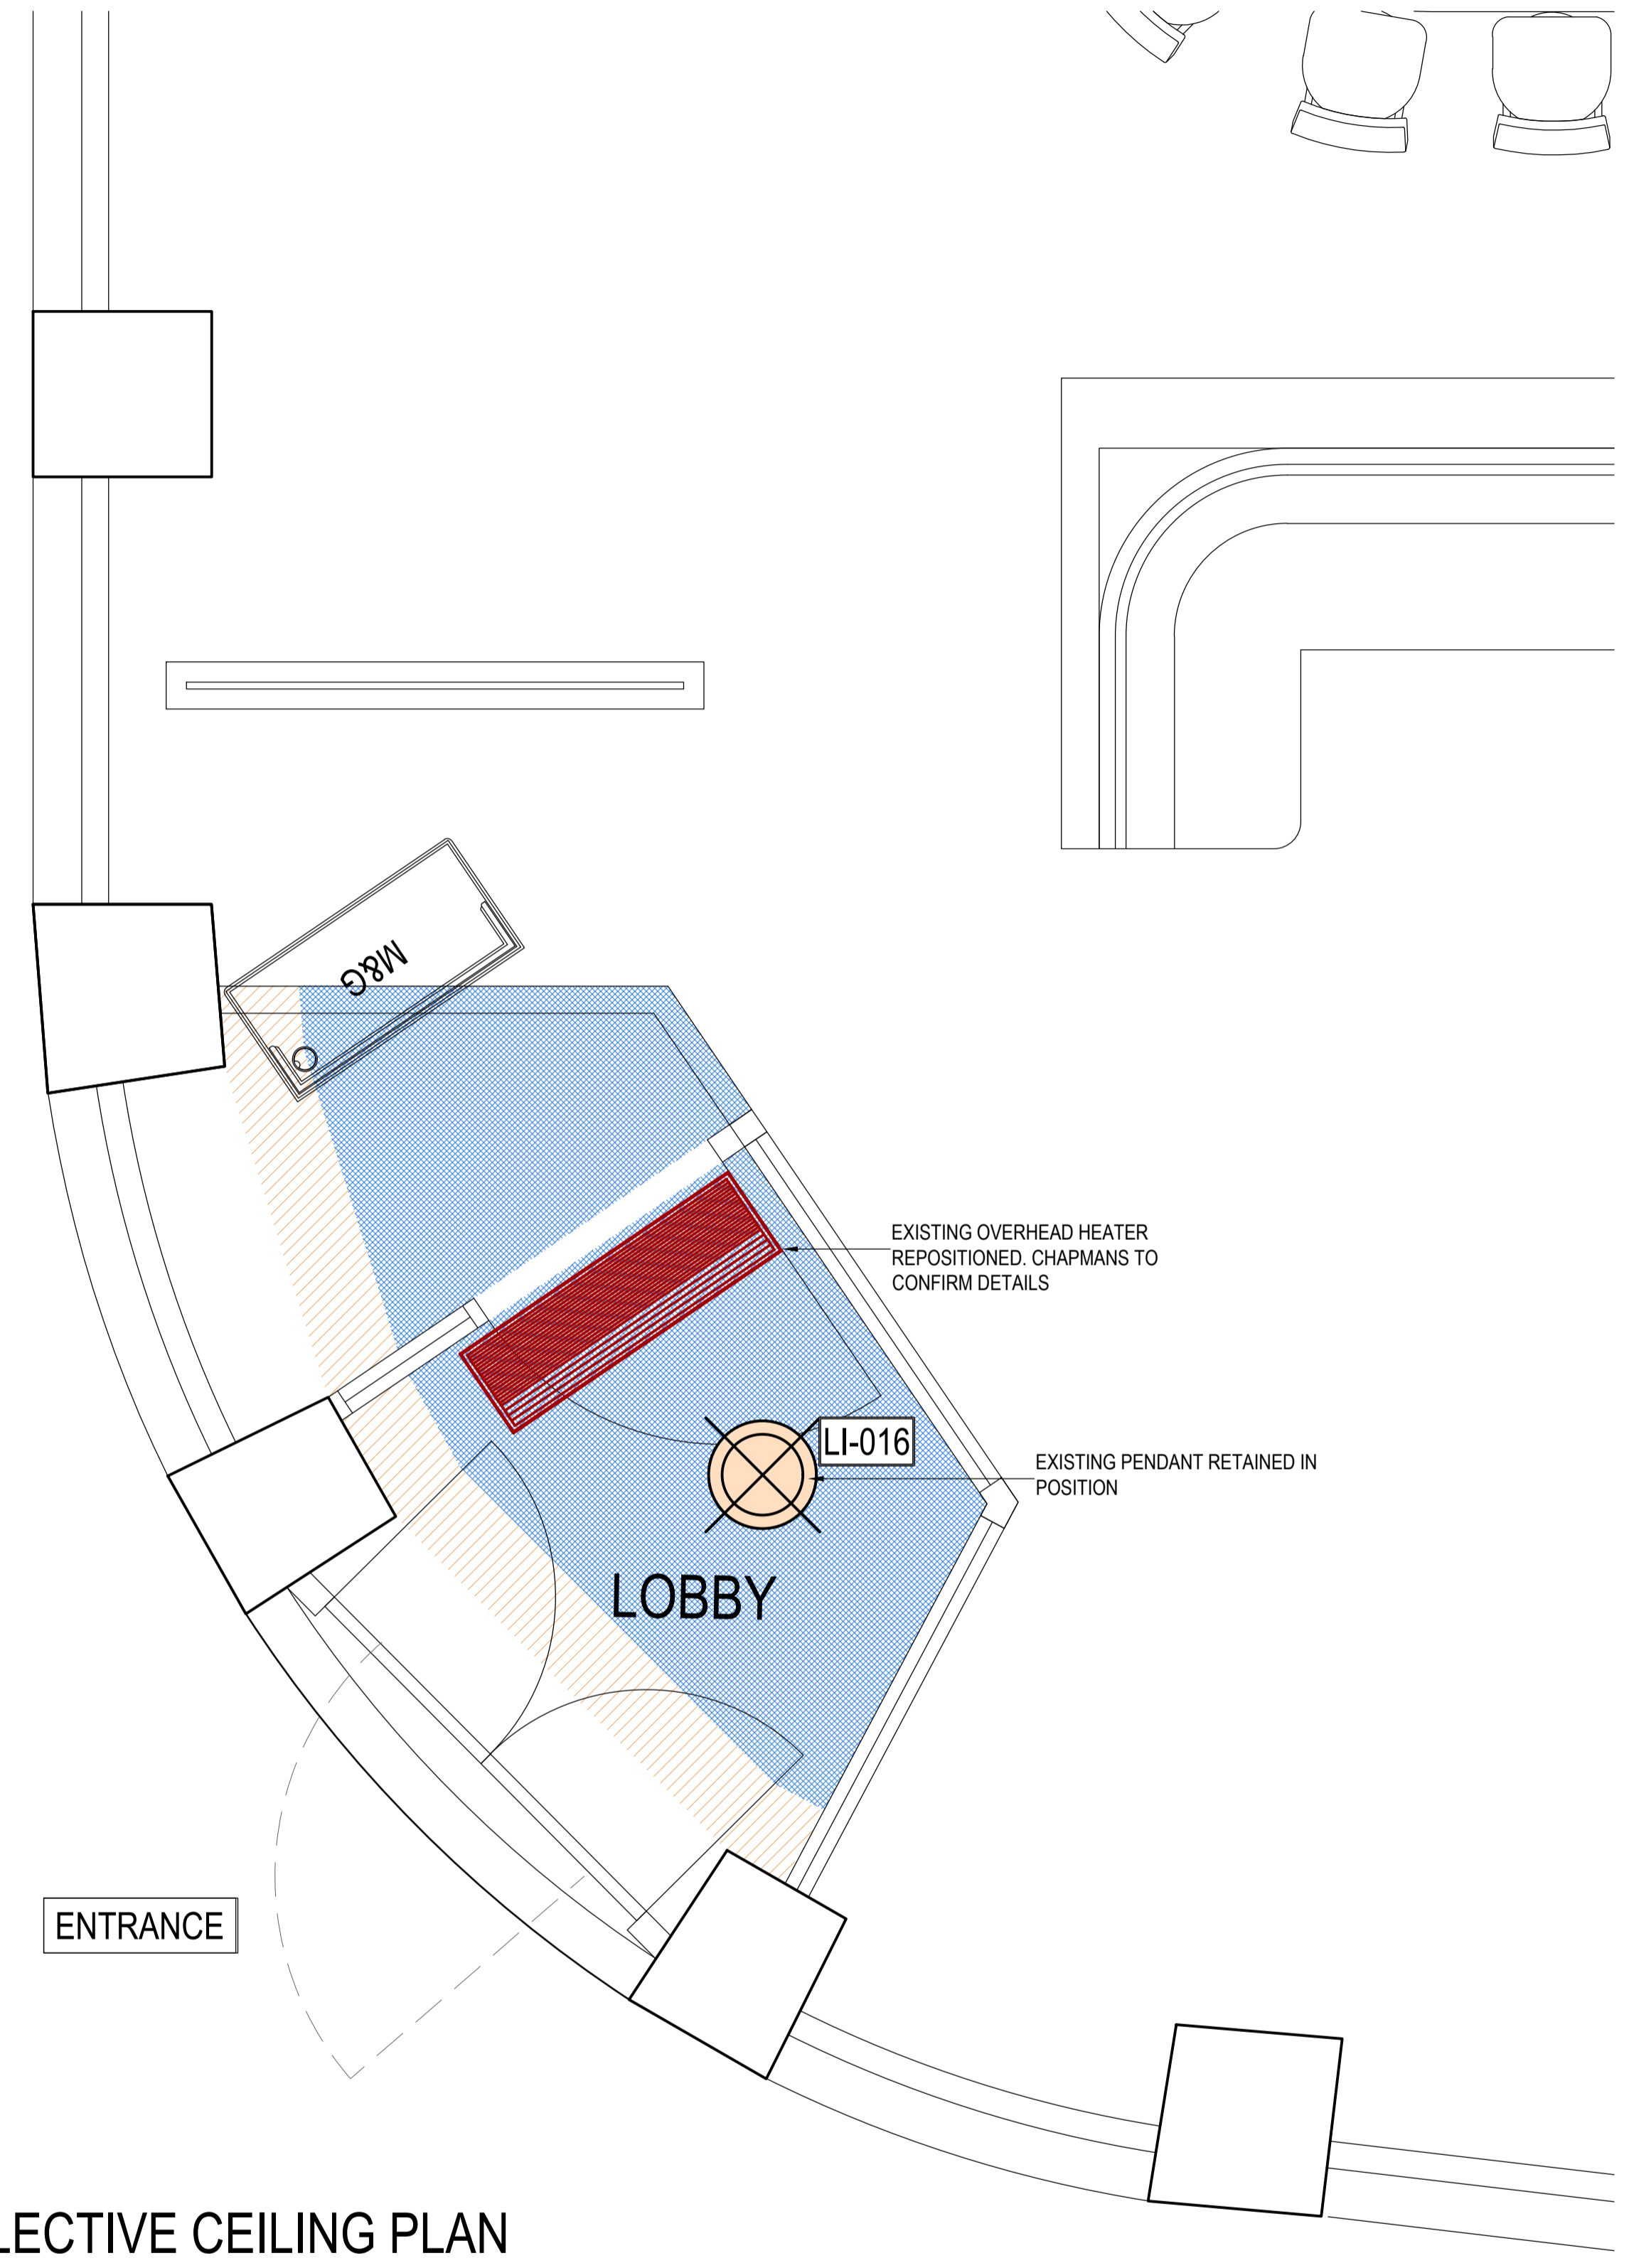


CEILING LEGEND - HEIGHTS IN RED
 ALL NEW GRILLES, SPEAKERS, CAMERAS, EMERGENCY LIGHTS & EMERGENCY DETECTION TO BE IN LINE WITH LIGHTING LAYOUT

SYMBOL	SPECIFICATION
	EXISTING FOH CEILING MADE GOOD WHERE LOBBY REMOVED, REFURBISHED TO MATCH EXISTING COLOUR: FARROW & BALL "WHITE TIE" TBC
	CORNICE TO BE MADE GOOD / INFILLED TO MATCH EXISTING COLOUR: FARROW & BALL "WHITE TIE" TBC

LIGHTING LEGEND
 REFER TO LIGHTING SCHEDULE FOR ALL LIGHTING DETAILS

SYMBOL	DESCRIPTION	SPEC REF
	ENTRANCE - PENDANT MOUNT EXISTING	LI-016

PROPOSED PART REFLECTIVE CEILING PLAN

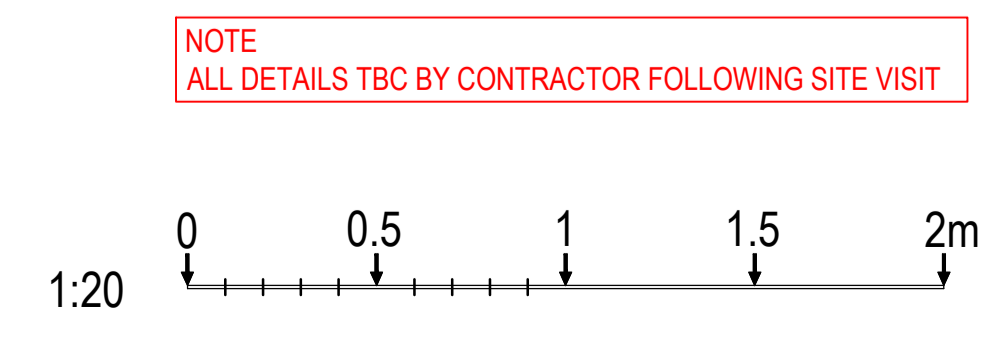

PumpHouse
 DESIGNS
 Architectural & Interior
 Design Consultants

Pump House Yard
 The Green
 Sedlescombe
 East Sussex
 TN33 0QA
 info@pumphousedesigns.co.uk
 www.pumphousedesigns.co.uk

T: 01424 871120

F			
E			
D			
C			
B			
A			
YORK 2 ST HELENS SQUARE YORK YO1 8QP			
PROPOSED REFLECTIVE CEILING PLAN			
DRAWN BY - P BATEHUP DATE - AUG 2021 SCALE - 1:20 @ A1			
DRAWING No. 4322 / 539 / 301			