


This drawing is copyright. Contractors must check all dimensions on site. Only figured dimensions are to be worked from. Discrepancies must be reported immediately to the engineer before proceeding. Preliminary drawings must not be used for construction purposes.

- NOTES**
- THIS DRAWING IS TO BE USED FOR EXTERNAL WORKS AND BELOW GROUND DRAINAGE ONLY. FOR SETTING OUT OF BUILDINGS AND EXTERNALS REFER TO THE RELEVANT ARCHITECT'S DRAWINGS.
 - ABOVE GROUND DRAINAGE INCLUDING STACK PIPE POSITIONS & SPECIFICATION SHALL BE TAKEN FROM ARCHITECT'S DRAWINGS.
 - RWPS ARE SHOWN INDICATIVELY ONLY. THE POSITION & SIZES OF ALL RWPS ARE TO BE PROVIDED & CONFIRMED BY THE ARCHITECT.
 - ALL SURFACE WATER DRAINAGE TO BE 100MMØ UNLESS NOTED OTHERWISE.
 - ALL PRIVATE FOUL DRAINAGE TO BE 100MMØ UNLESS NOTED OTHERWISE.
 - REFER TO UTILITY SURVEY FOR EXISTING SERVICES - ALL SITE OPERATIVES SHALL CARRY OUT APPROPRIATE INVESTIGATIONS PRIOR TO COMMENCING ANY EXCAVATIONS / WORKS
 - DRAINAGE TO DIVERTED SHOWN INDICATIVELY ONLY - ROUTES SUBJECT TO DETAILED DESIGN REVIEW OF LEVELS, CAPACITIES & CONDITION OF BELOW GROUND DRAINAGE.
 - ALL STACK PIPES TO HAVE RODDING ACCESS POINTS AT NO HIGHER THAN 1.5M ABOVE FFL.
 - VENTILATION TO BE PROVIDED AT THE HEAD OF EACH FOUL DRAINAGE RUN IN ACCORDANCE WITH BUILDING REGULATIONS.
 - IF OFFSITE DRAINAGE IS REQUIRED, THIS SHALL BE OFFERED TO SWW UNDER AN ADOPTION AGREEMENT DUE TO LOCATION WITHIN ADOPTED HIGHWAY. ALTERNATIVELY SWW MAY BE APPOINTED TO CARRY OUT THE OFFSITE DRAINAGE WORKS UNDER A REQUISITION AGREEMENT.
 - THE CONTRACTOR IS REQUIRED TO MAKE SECTION 106 APPLICATION TO COMMUNICATE TO SWW TO MAKE NEW CONNECTIONS TO THE EXISTING PUBLIC SEWER MANHOLE AT EX111. THIS WORK MUST BE INSPECTED AND APPROVED BY THE SWW INSPECTOR.
 - TO CARRY OUT WORK ON THE PUBLIC HIGHWAY THE CONTRACTOR WILL BE REQUIRED TO APPLY FOR A ROAD OPENING PERMIT.
 - LEVELS OF EXISTING MANHOLES TO BE CONFIRMED ON SITE PRIOR TO COMMENCEMENT OF DRAINAGE WORKS.
- DISCHARGE RATES AND OUTFALL LOCATION SUBJECT TO CONFIRMATION BY SWW AND LLFA - TO BE CONFIRMED

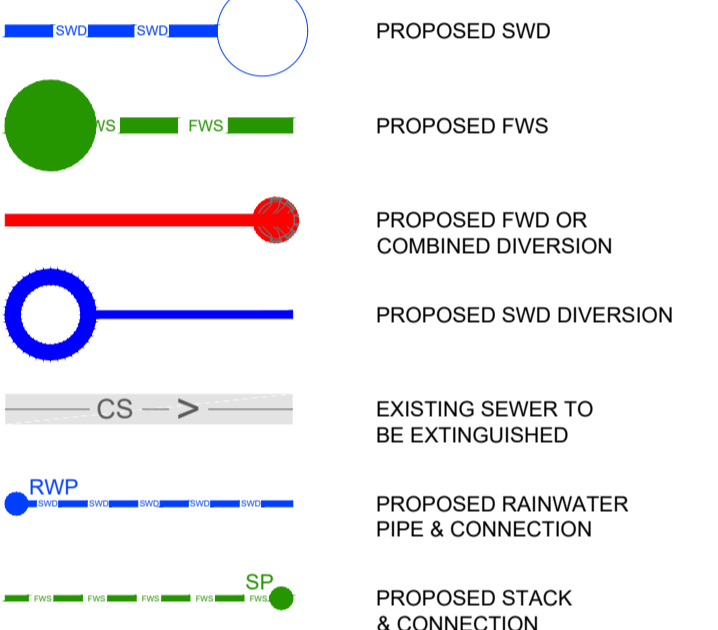

P2	14.05.21	GENERAL LAYOUT UPDATE	CN	SC
P1	27.04.21	PRELIMINARY ISSUE	CN	SC
REV.	DATE	NOTE	BY	CHK.

AIREY COLES CONSULTING ENGINEERS

1st FLOOR, ASHLEIGH COURT
 ASHLEIGH WAY
 LANGAGE BUSINESS PARK
 PLYMPTON
 PL7 5JX
 Tel: 01752 229119
 Fax: 01752 222115
 admin@aireyandcoles.co.uk

PROJECT
**WEST CORNWALL HOSPITAL
 NEW OUTPATIENT DEPARTMENT**

DRAWING TITLE
INDICATIVE DRAINAGE LAYOUT

SCALE	DATE	DRAWN BY	CHECKED
AS NOTED	APR 21	CN	SC

INTERNAL REFERENCE	REVISION
11242 - FRA3	P2

PROJ-VOLUME-LEVEL-ROLE-ORIG-FILETYPE-CLASSIFICATION-NUMBER

**PLANNING ISSUE
NOT FOR CONSTRUCTION**

**PROPOSED DRAINAGE LAYOUT AND
 EXISTING DRAINAGE TO BE DIVERTED**
 SCALE 1:100

