



○ BOWKER SADLER PARTNERSHIP LIMITED  
 ■ THIS DRAWING IS THE SUBJECT OF COPYRIGHT WHICH VESTS IN BOWKER SADLER PARTNERSHIP LIMITED. IT IS AN INFRINGEMENT OF COPYRIGHT TO REPRODUCE THIS DRAWING BY WHATEVER MEANS, INCLUDING ELECTRONIC, WITHOUT THE EXPRESS WRITTEN CONSENT OF BOWKER SADLER PARTNERSHIP LIMITED WHICH RESERVES ALL ITS RIGHTS.  
 BOWKER SADLER PARTNERSHIP LIMITED ASSERTS ITS RIGHTS TO BE IDENTIFIED AS THE AUTHOR OF THIS DESIGN.  
 ■ DRAWING NOT TO BE SCALED.  
 ■ REPORT ERRORS & OMISSIONS TO ARCHITECT.  
 ■ CHECK ALL DIMENSIONS ON SITE.  
 ■ DRAWING TO BE READ IN CONJUNCTION WITH THE HEALTH AND SAFETY PLAN AND ALL RELEVANT RISK ASSESSMENTS

Open Sided Car Barn

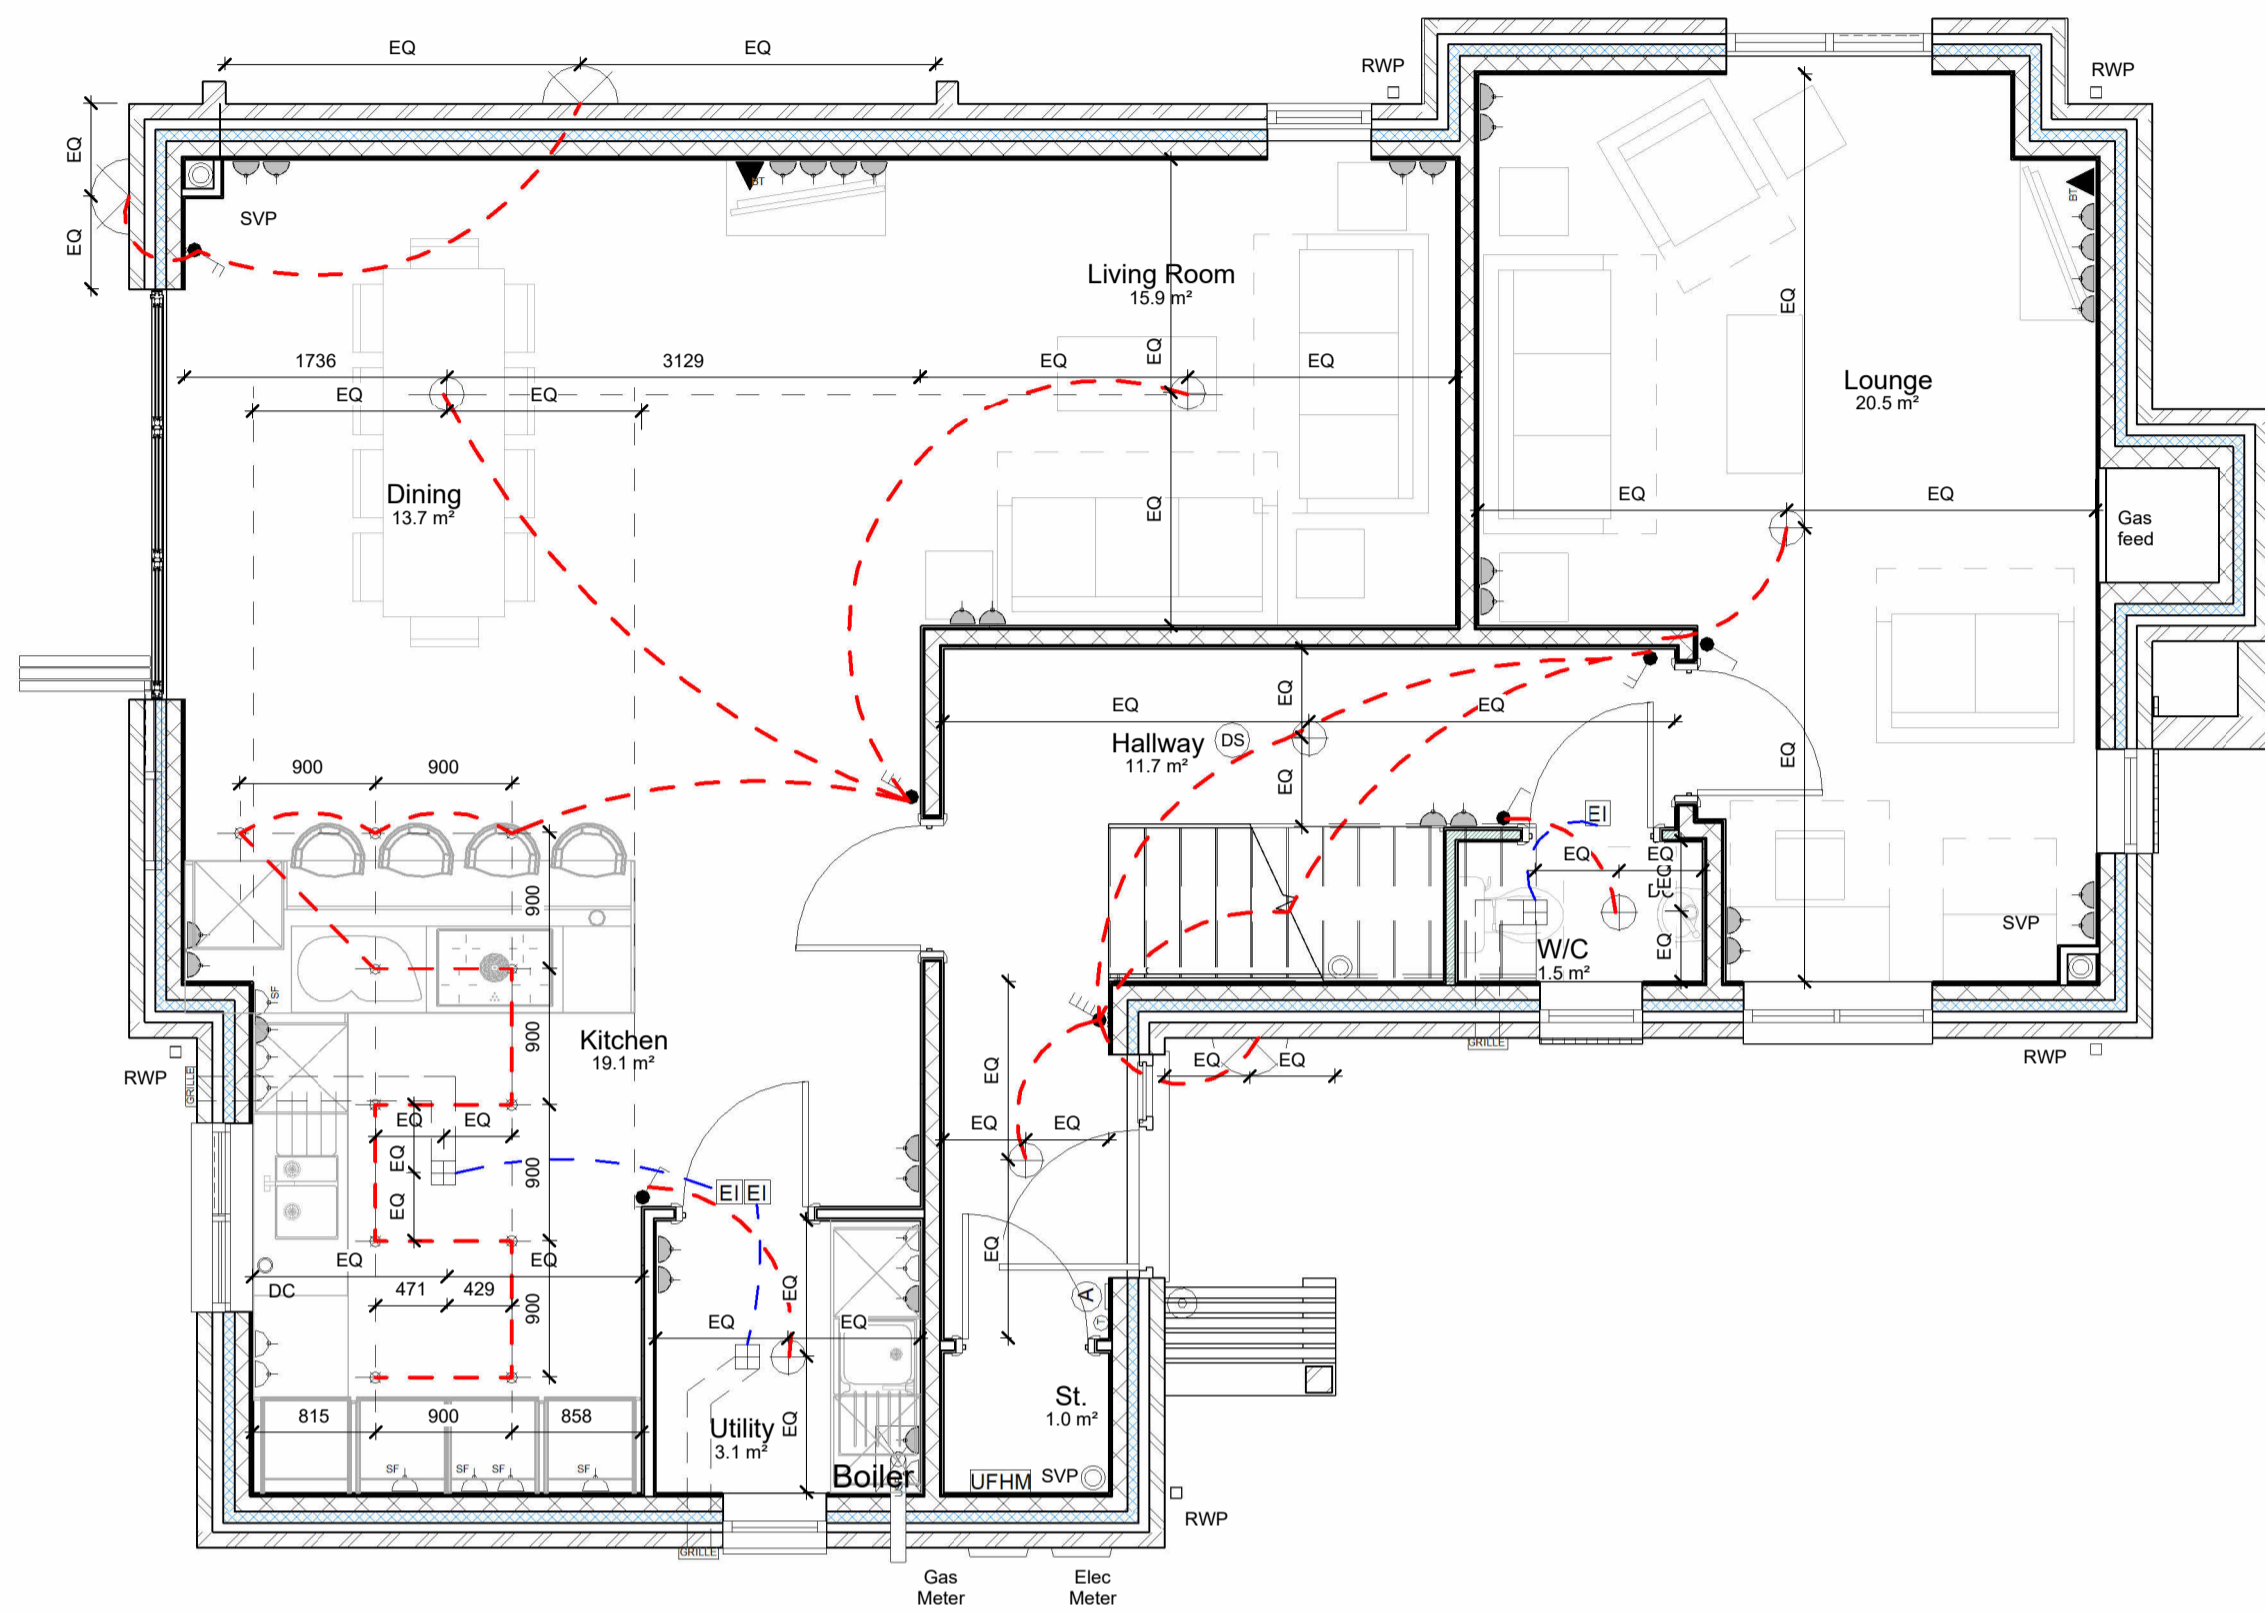

**Ground Floor Plan**  
1 : 50

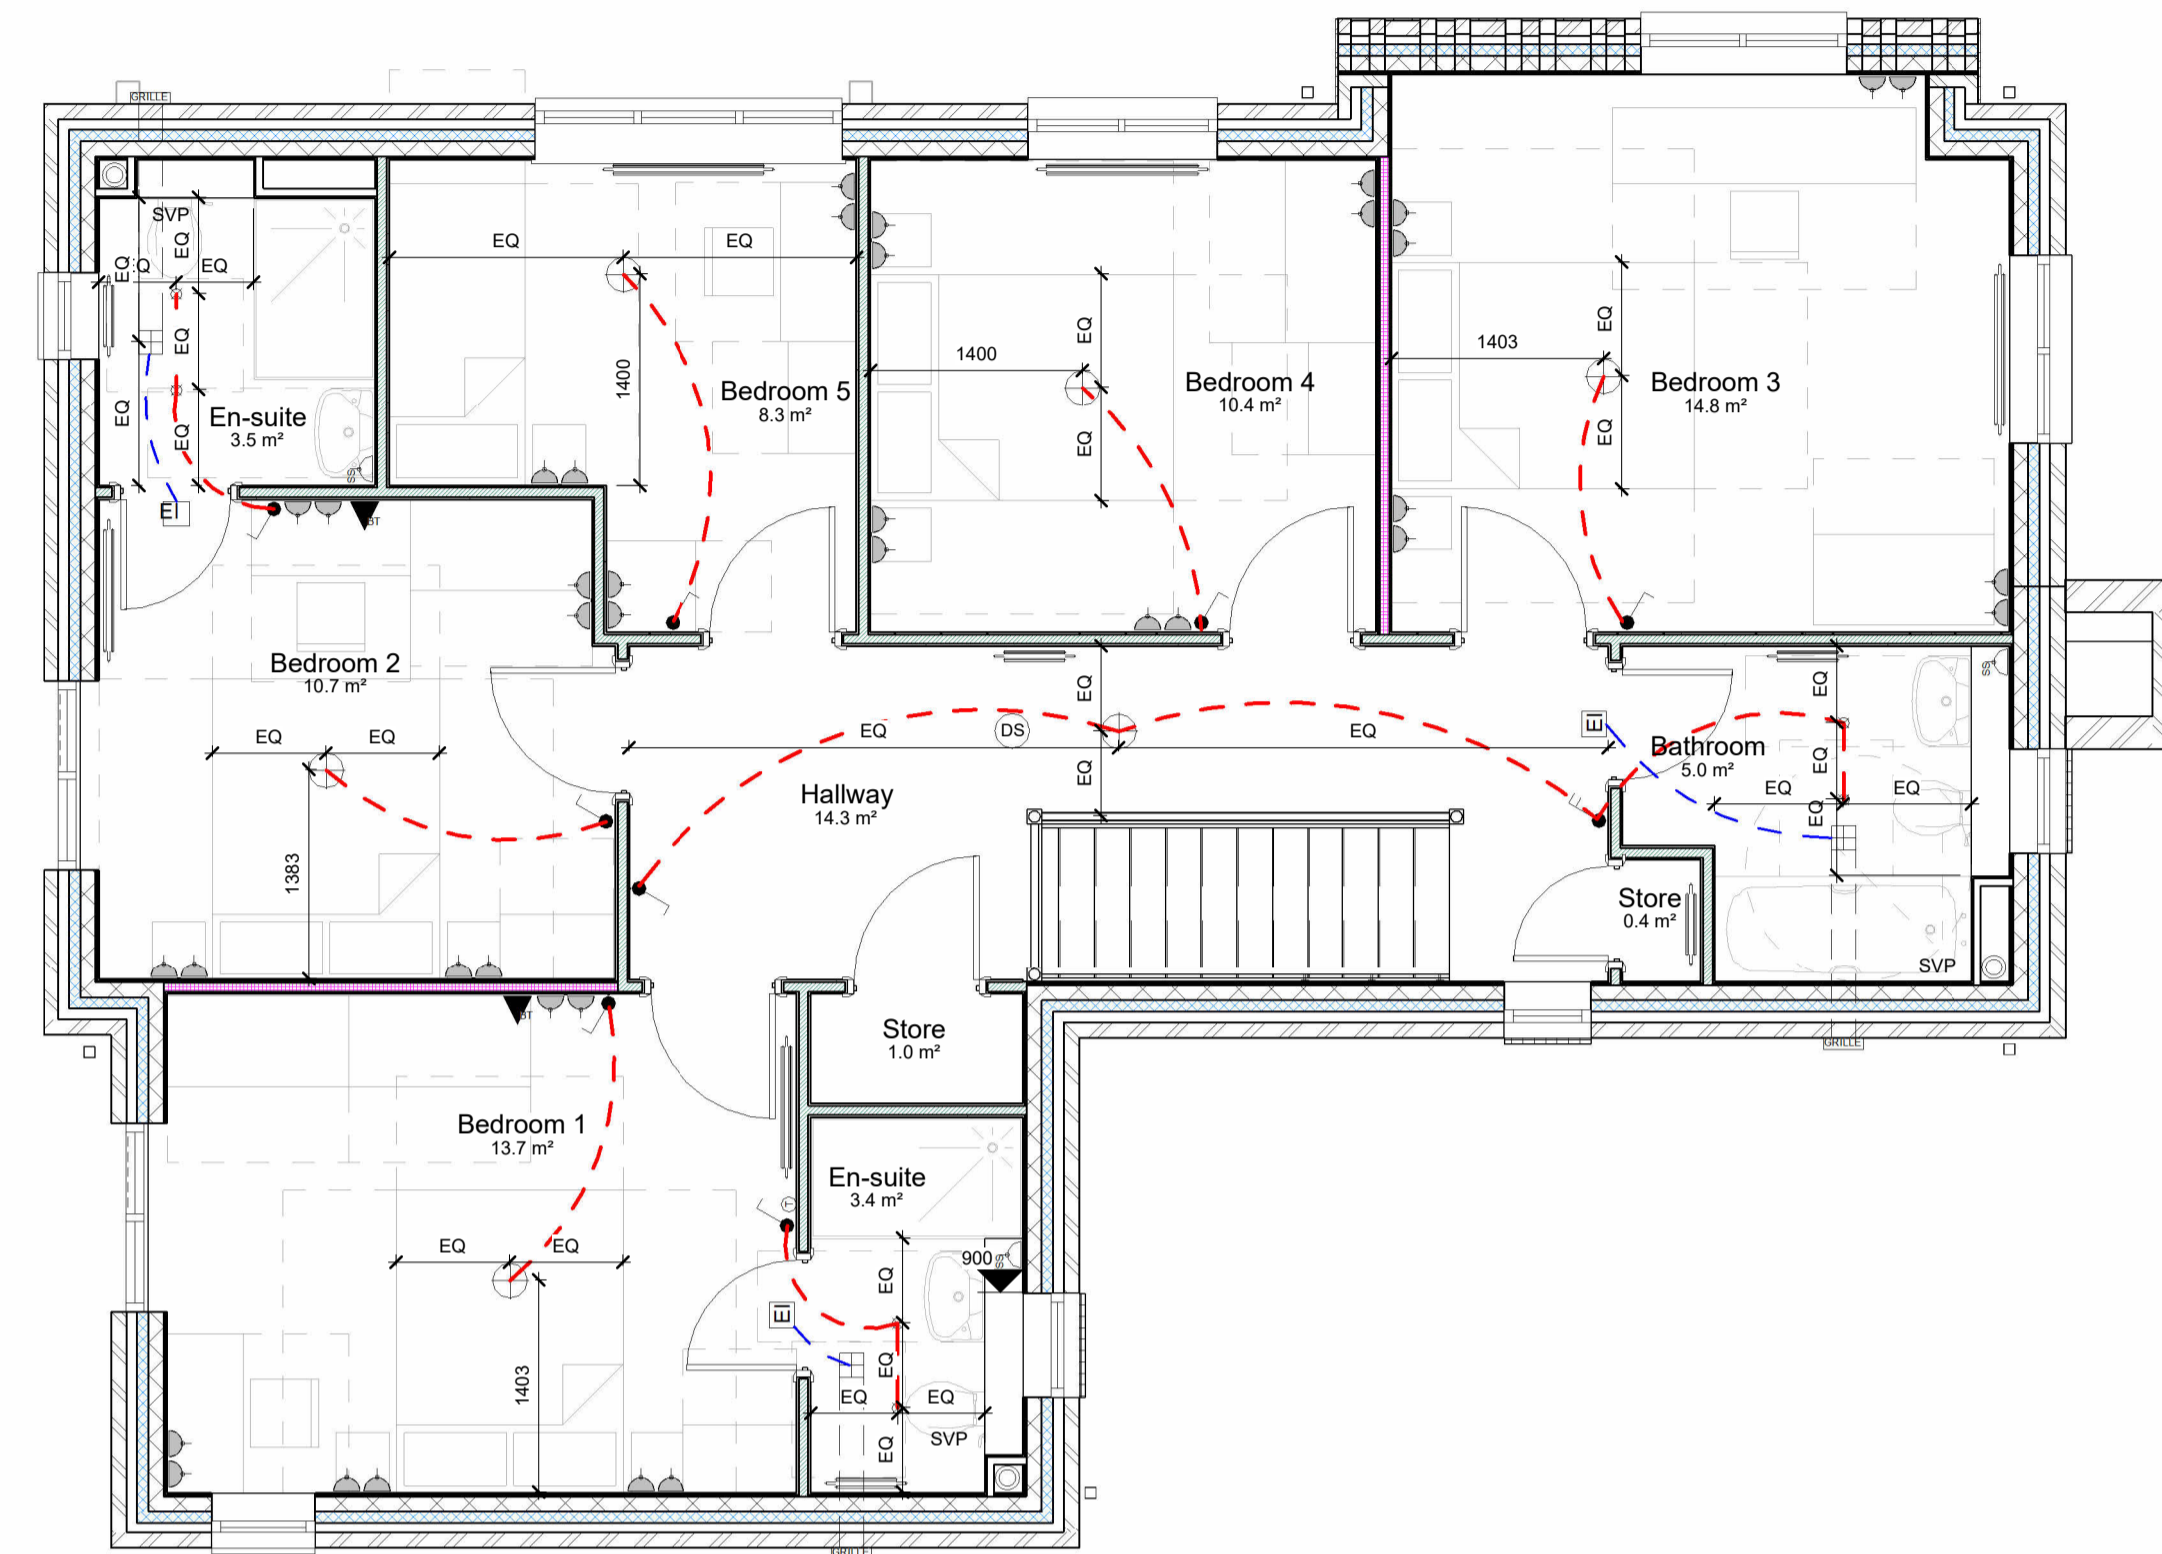

**First Floor Plan**  
1 : 50

REV.	DATE	DRN.	CHKD.
D	9/11/21	KM	Minor amendments to suit client comments.
C	21/10/21	KM	Revision to ground floor WC and related living room space.
B	29/09/21	KM	Minor amendments to suit client comments.
A	21/09/21	KM	Minor amendments to suit client comments.

PROJECT: Panflora Nurseries

CLIENT: Edgefold Homes Ltd.

DRAWING: Plot 5 - M&E Plans

SCALE: As indicated

SHEET SIZE: @ A1

DRAWN: KS

CHECKED: KLM

DATE: 12/08/21

JOB No: 18062


DRAWING No: 2038

REVISION: D

STATUS: Building Regulations

Electrical Symbols Legend	
1 Gang Switch	Low Level Single Switched Socket
2 Gang Switch	High Level Single Switched Socket
3 Gang Switch	Low Level Double Switched Socket
4 Gang Switch	High Level Double Switched Socket
Switched Fuse Spur	Extract Isolator Switch
Unswitched Fuse Spur	TVIBT Point
External Lighting Fixture	Ceiling Mounted Extract Fan With Duct Run
Standard Light Pendant	Light Switch Cable Run
Down Light Can	Extract Isolator Cable Run
'Grace' light to kitchen manufacturer's details	
	Dual Voltage Shaver Socket
	External Wall Mounted Grille
	Consumer Unit
	UFHM Under Floor Heating Manifold
	Smoke detector to top and bottom of stairs to be linked together and connected to mains supply to BS5446-2:2003 Part 1 for smoke alarms and part 2 for heat alarms. All with battery backup.
	Ceiling Mounted Heat Detector
	Ceiling Mounted Carbon Monoxide Detector
	Alarm Key Pad
	Doorbell

**Miscellaneous Electrical Fittings**

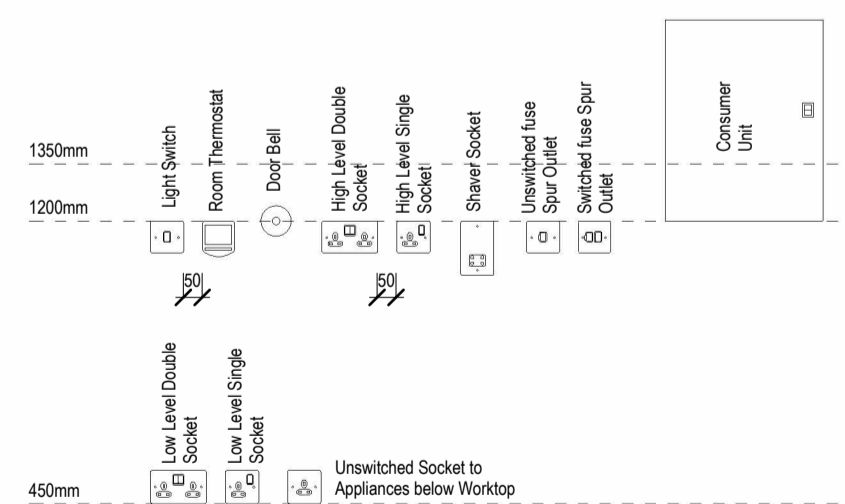

**M&E Electrical Key**  
1 : 50

**Electrical Setting Out**  
1 : 20

