



○ BOWKER SADLER PARTNERSHIP LIMITED  
 ■ THIS DRAWING IS THE SUBJECT OF COPYRIGHT WHICH VESTS IN BOWKER SADLER PARTNERSHIP LIMITED. IT IS AN INFRINGEMENT OF COPYRIGHT TO REPRODUCE THIS DRAWING BY WHATEVER MEANS, INCLUDING ELECTRONIC, WITHOUT THE EXPRESS WRITTEN CONSENT OF BOWKER SADLER PARTNERSHIP LIMITED WHICH RESERVES ALL ITS RIGHTS.  
 BOWKER SADLER PARTNERSHIP LIMITED ASSERTS ITS RIGHTS TO BE IDENTIFIED AS THE AUTHOR OF THIS DESIGN.  
 ■ DRAWING NOT TO BE SCALED.  
 ■ REPORT ERRORS & OMISSIONS TO ARCHITECT.  
 ■ CHECK ALL DIMENSIONS ON SITE.  
 ■ DRAWING TO BE READ IN CONJUNCTION WITH THE HEALTH AND SAFETY PLAN AND ALL RELEVANT RISK ASSESSMENTS

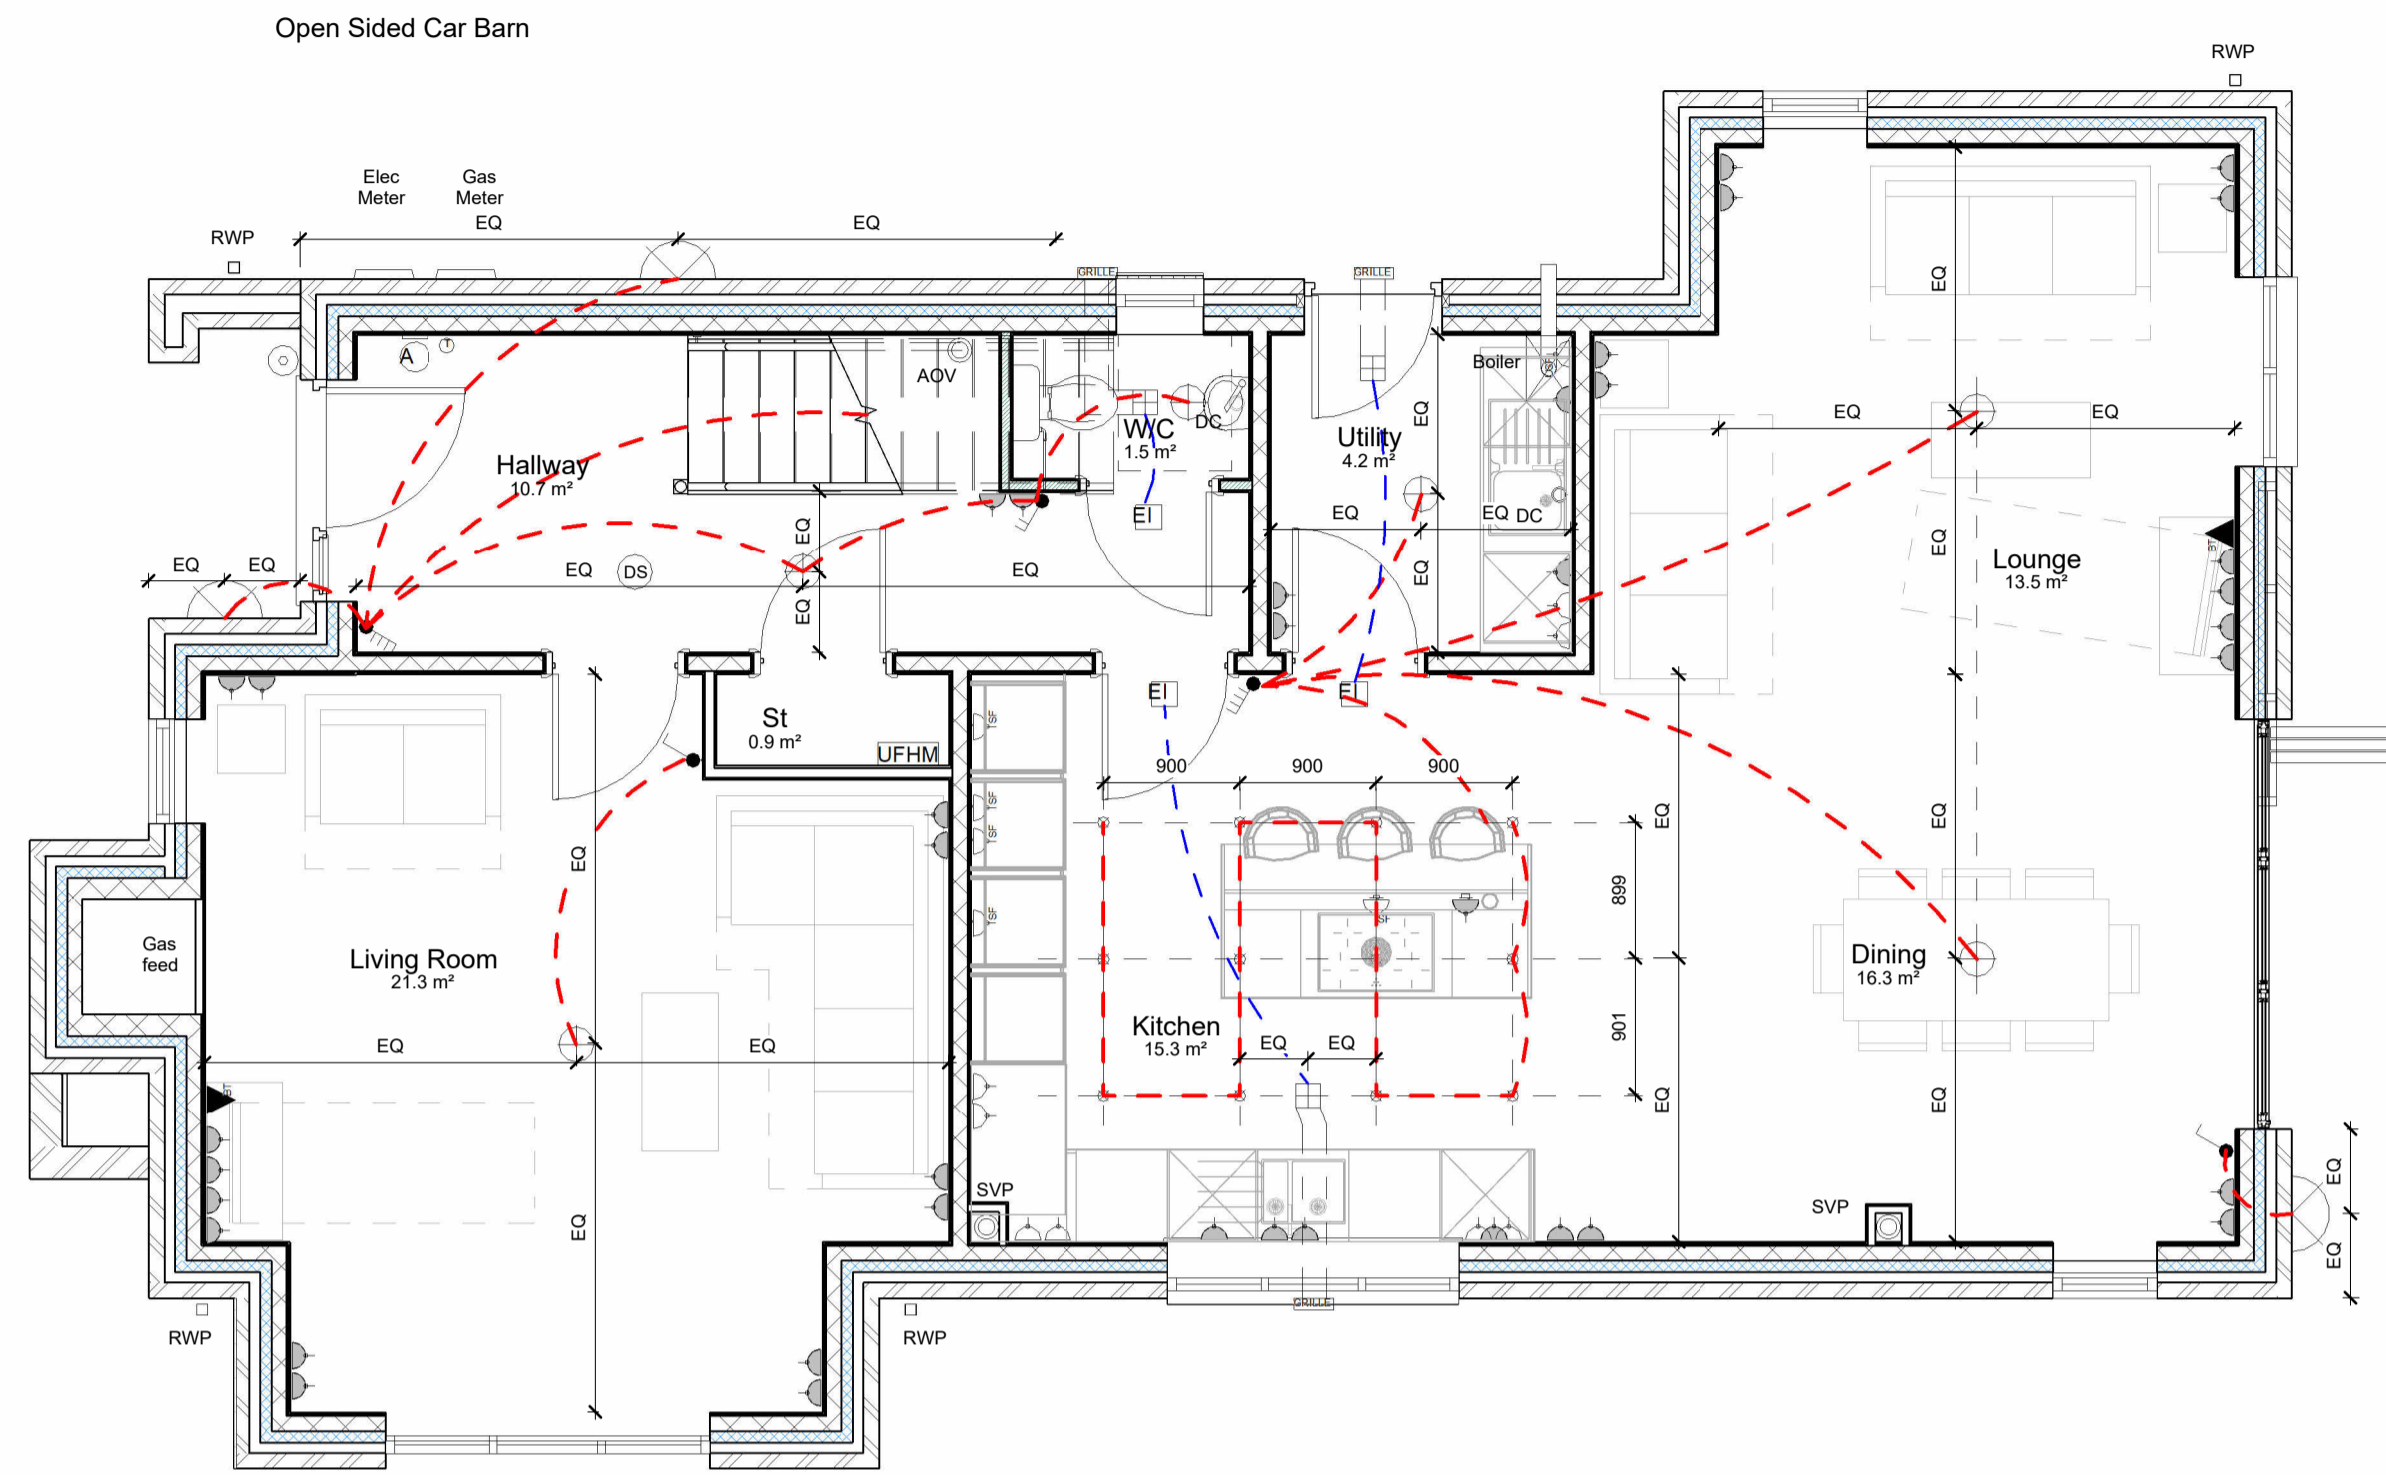

**Ground Floor Plan**  
1 : 50

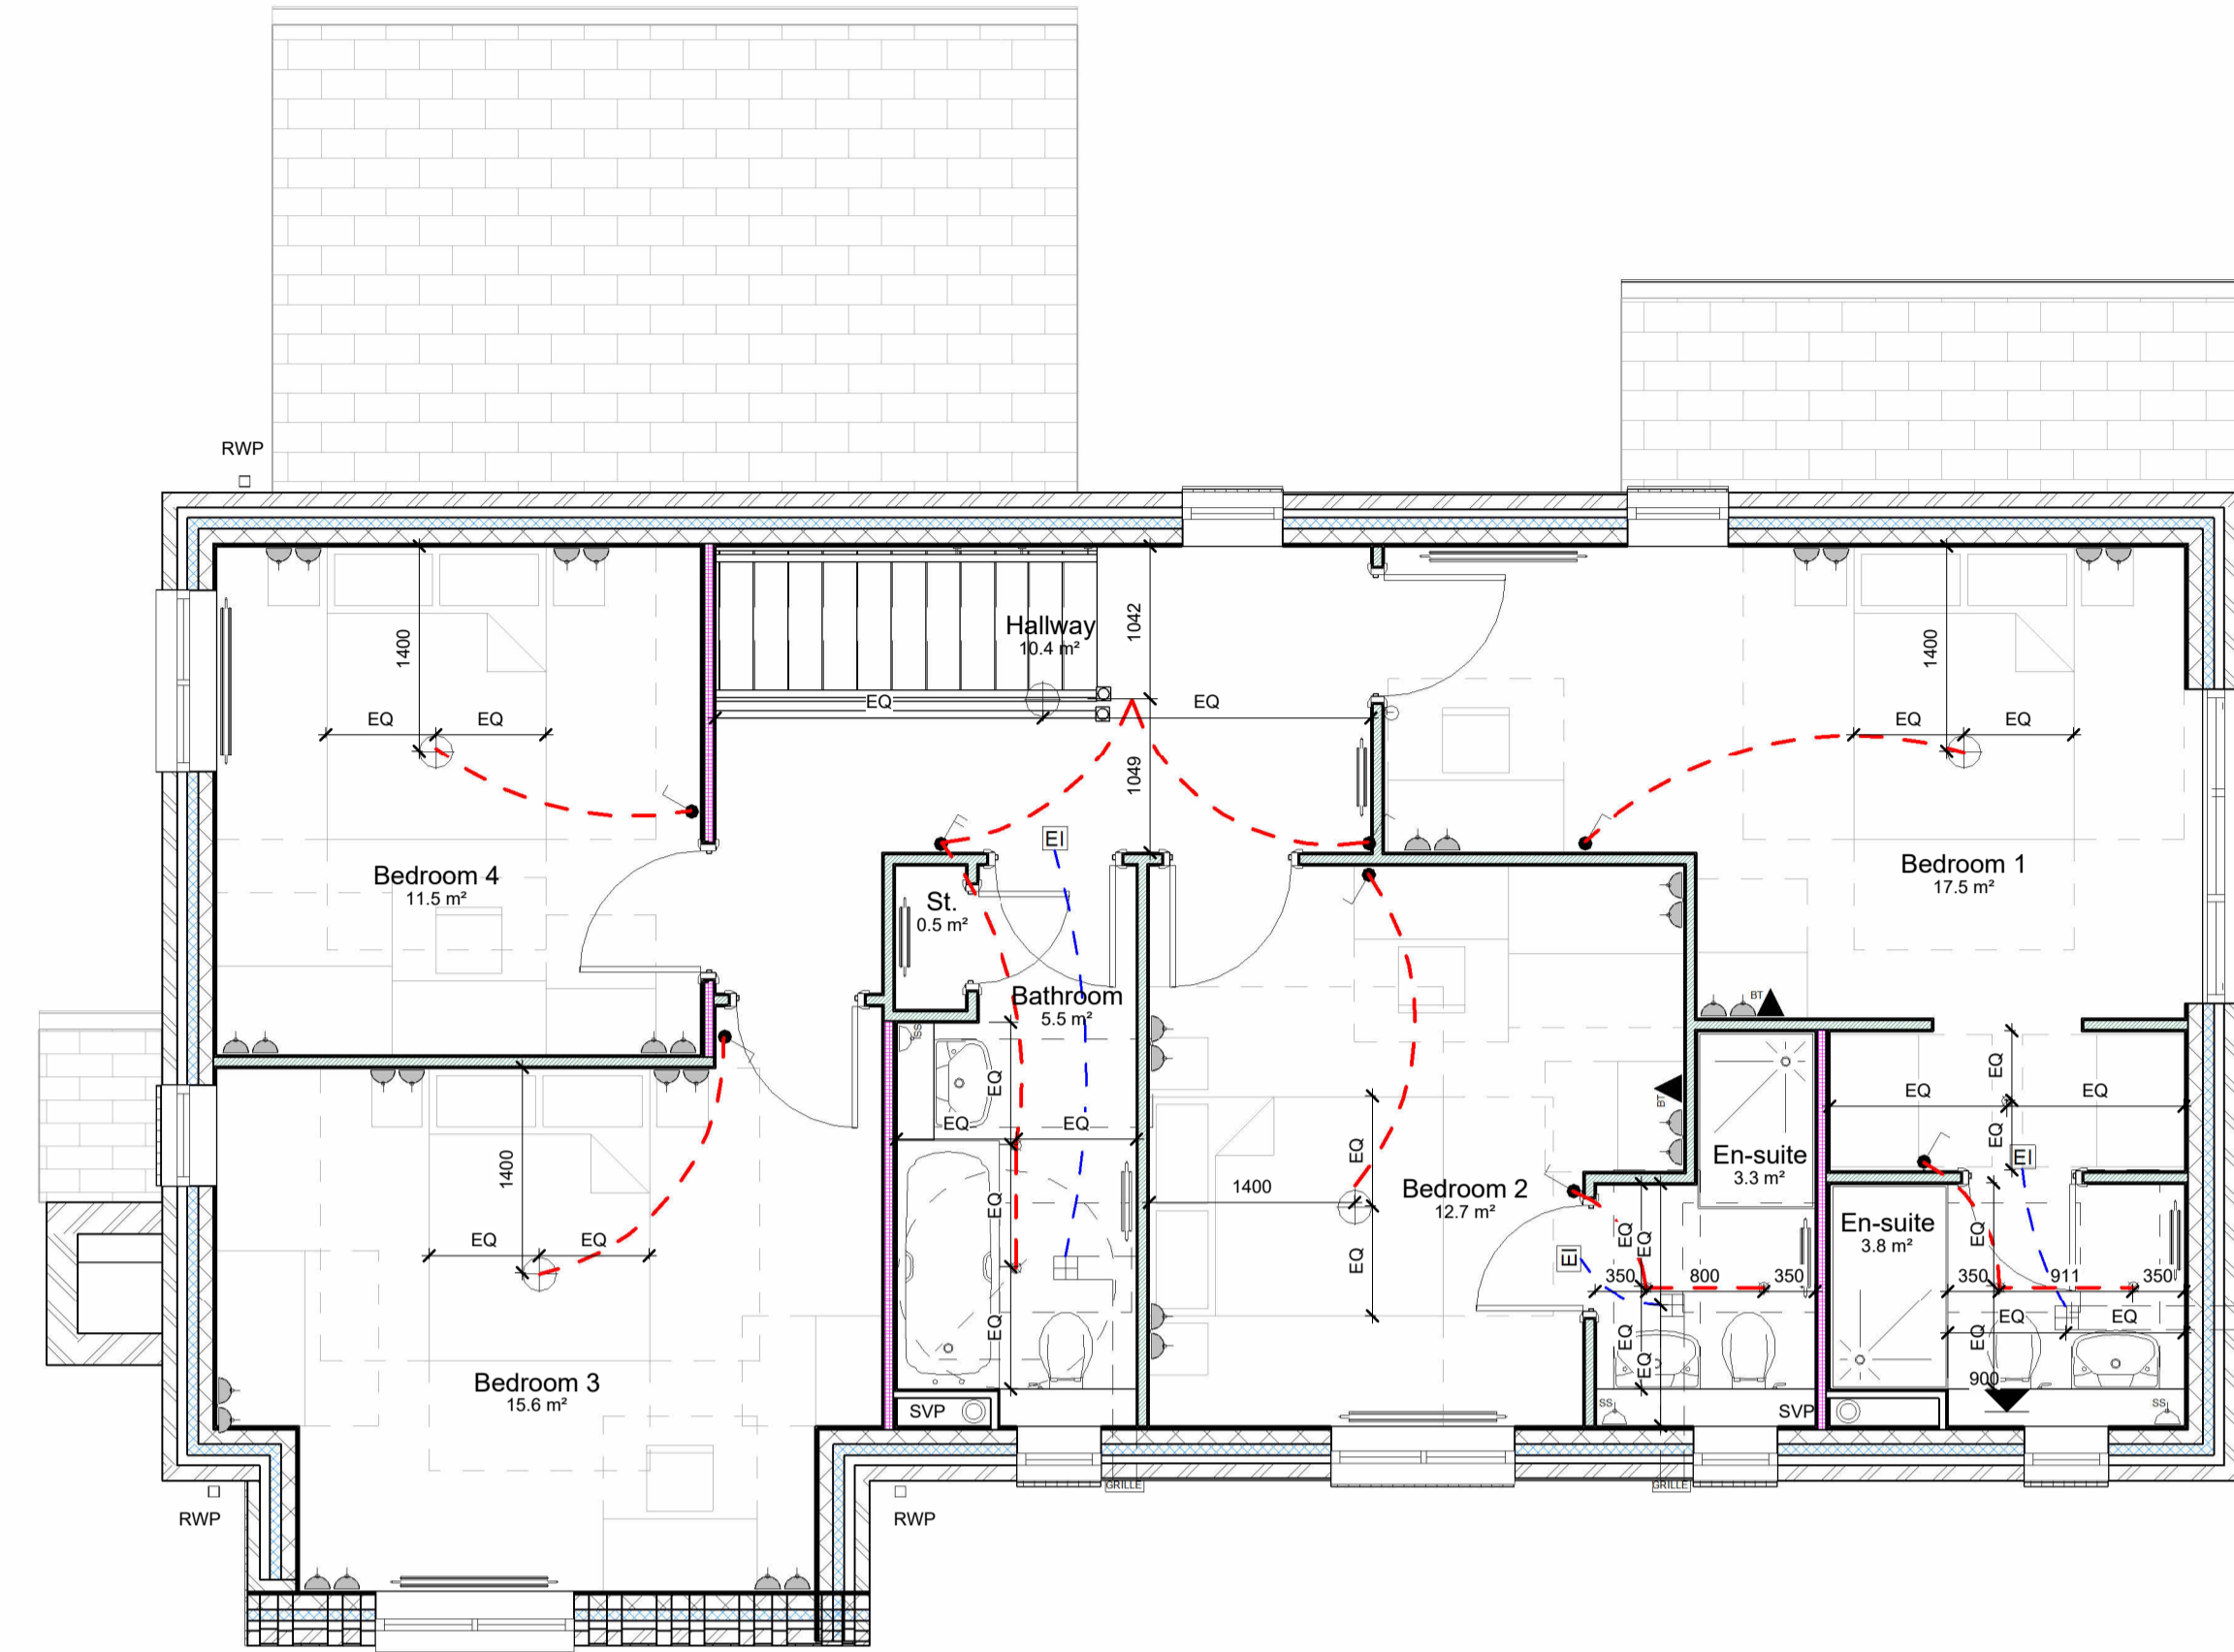


**First Floor Plan**  
1 : 50

Electrical Symbols Legend		
1 Gang Switch	Low Level Single Switched Socket	Dual Voltage Shaver Socket
2 Gang Switch	High Level Single Switched Socket	External Wall Mounted Gille
3 Gang Switch	Low Level Double Switched Socket	Consumer Unit
4 Gang Switch	High Level Double Switched Socket	UUFHM Under Floor Heating Manifold
Switched Fuse Spur	Extract Isolator Switch	DS Smoke detector to top and bottom of stairs to be linked together and connected to mains supply to BS5446-2:2003 Part 1 for smoke alarms and part 2 for heat alarms. All with battery backup.
Unswitched Fuse Spur	TV/BT Point	CH Ceiling Mounted Heat Detector
External Lighting Fixture	Ceiling Mounted Extract Fan With Duct Run	CM Ceiling Mounted Carbon Monoxide Detector
Standard Light Pendant	Light Switch Cable Run	A Alarm Key Pad
Down Light Can	Extract Isolator Cable Run	D Doorbell
Notes: 'G' indicates light to kitchen manufacturer's details.		

**M&E Electrical Key**  
1 : 50

**Miscellaneous Electrical Fittings**

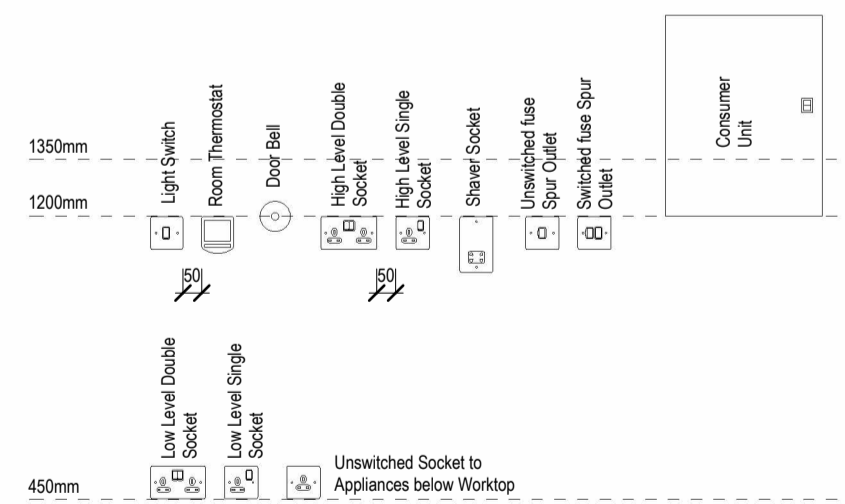

**Electrical Setting Out**  
1 : 20

REV.	DATE	DRN.	CHKD.
B	9/11/21	KM	Minor amendments to suit client comments.
A	20/09/21	KM	Minor amendments to suit client comments.

REV.	DATE	DRN.	CHKD.
------	------	------	-------

PROJECT  
**Panflora Nurseries**

CLIENT  
**Edgefold Homes Ltd.**

DRAWING  
**Plot 6 - M&E Plans**

SCALE	SHEET SIZE	DRAWN	CHECKED	DATE
As indicated	@ A1	KS	KLM	13/08/21

**BOWKER SADLER ARCHITECTURE**  
 A: Hatherlow House, Hatherlow, Romiley, Stockport SK6 3DY  
 T: 0161 406 7333  
 E: office@bowker-sadler.co.uk  
 W: www.bowker-sadler.co.uk

JOB No	DRAWING No	REVISION
18062	2040	B

STATUS  
**Building Regulations**

