




#REF	System	Manufacturer	Model	Electrical supply	Phase	Fuse Rating (amp)	No. of Power Cable Cores	Input Power (Watt)	FLC (amp)	Start Current (amp)	Sound Pressure level dB(A)	Weight (Kg)	No. Interconnecting Cable Cores	CONTROLLER POSITION	COMMENTS
01	KITCHEN DUCTED AC UNIT 14Kw	MITSUBISHI ELECTRIC	PEAD-M100JA	220 - 240v, 50Hz	Single	-	-	-	-	-	38@3m	39	3+E (1.5mm)	G/F GLASS WASH	POWER VIA OUTDOOR
02	KITCHEN DUCTED AC UNIT 20Kw	MITSUBISHI ELECTRIC	PEA-M200LA	220 - 240v, 50Hz	Single	6	3	350w	3.1	-	43@3m	87	3+E (1.5mm)	G/F GLASS WASH	POWER VIA OUTDOOR
03	KITCHEN SUPPLY FAN	FLAKT WOODS	56JM	380 - 415v, 50Hz	3ph	-	4	1320w	6.7	13.5	58@3m	38	-	VIA CHHETAH SYSTEM	POWER TO FAN
04	SUPPLY AIR PRESSURE SWITCH	-	-	-	-	-	-	-	-	-	-	-	2	WIRED INTO INTERLOCK	screened 2 pair 0.25mm
05	D.H.W CYLINDER	ALBION	ULTRASTEEL AUI300	2 x 220 - 240v, 50Hz	Single	-	2 x 3	2 x 3000	-	-	-	360	-	N/A	POWER TO UNIT
06	D.H.W BOILER	WORCESTER BOSCH	GREENSTAR LIFE 40Kw	220 - 240v, 50Hz	Single	5	3	-	-	-	-	-	-	-	-
07	PUB HEATING BOILER 1	WORCESTER BOSCH	GREENSTAR LIFE 30Kw	220 - 240v, 50Hz	Single	5	3	-	-	-	-	-	-	-	-
08	EXISTING BOTTLE STORE CONDENSER	-	-	-	-	-	-	-	-	-	-	-	-	-	-
09	KITCHEN DUCTED AC CONDENSER 20Kw	MITSUBISHI ELECTRIC	PUZ-M200YKA	380 - 415v, 50Hz	3ph	25	5	6590w	22.5	5	60@1m	129	-	N/A	POWER TO UNIT
10	KITCHEN DUCTED AC CONDENSER 14Kw	MITSUBISHI ELECTRIC	PUZ-M140YAR1	380 - 415v, 50Hz	3ph	16	5	4760w	11.5	7	57@1m	85	-	N/A	POWER TO UNIT
11	EXISTING GLYCOL CONDENSER	-	-	-	-	-	-	-	-	-	-	-	-	-	-
12	EXISTING GLYCOL CONDENSER	-	-	-	-	-	-	-	-	-	-	-	-	-	-
13	EXISTING CELLAR COOLING CONDENSER	-	-	-	-	-	-	-	-	-	-	-	-	-	-
14	EXISTING FRIDGE CONDENSER	-	-	-	-	-	-	-	-	-	-	-	-	-	-
15	EXISTING FREEZER CONDENSER	-	-	-	-	-	-	-	-	-	-	-	-	-	-
16	TRADE AREA DUCTED AC CONDENSER 20Kw	MITSUBISHI ELECTRIC	PUZ-M200YKA	380 - 415v, 50Hz	3ph	25	5	6590w	22.5	5	60@1m	129	-	N/A	POWER TO UNIT
17	TRADE AREA DUCTED AC CONDENSER 20Kw	MITSUBISHI ELECTRIC	PUZ-M200YKA	380 - 415v, 50Hz	3ph	25	5	6590w	22.5	5	60@1m	129	-	N/A	POWER TO UNIT
18	TRADE AREA DUCTED AC CONDENSER 20Kw	MITSUBISHI ELECTRIC	PUZ-M200YKA	380 - 415v, 50Hz	3ph	25	5	6590w	22.5	5	60@1m	129	-	N/A	POWER TO UNIT
19	STAIRWELL EXTRACT FAN	VENT AXIA	TX12WL	220 - 240v, 50Hz	Single	-	3	105w	-	-	49@3m	10.86	4+E	G/F GLASS WASH	POWER TO CONTROLLER
20	TRADE AREA DUCTED AC UNIT 20Kw	MITSUBISHI ELECTRIC	PEA-M200LA	220 - 240v, 50Hz	Single	6	3	350w	3.1	-	43@3m	87	3+E (1.5mm)	G/F GLASS WASH	POWER VIA OUTDOOR
21	TRADE AREA DUCTED AC UNIT 20Kw	MITSUBISHI ELECTRIC	PEA-M200LA	220 - 240v, 50Hz	Single	6	3	350w	3.1	-	43@3m	87	3+E (1.5mm)	G/F GLASS WASH	POWER VIA OUTDOOR
22	TRADE AREA DUCTED AC UNIT 20Kw	MITSUBISHI ELECTRIC	PEA-M200LA	220 - 240v, 50Hz	Single	6	3	350w	3.1	-	43@3m	87	3+E (1.5mm)	G/F GLASS WASH	POWER VIA OUTDOOR
23	TRADE AREA EXTRACT FAN	ELTA SELECT	SEL355/4-1AC	220 - 240v, 50Hz	Single	13	3	150w	0.7	-	45@3m	14	3+E	G/F GLASS WASH	POWER TO CONTROLLER

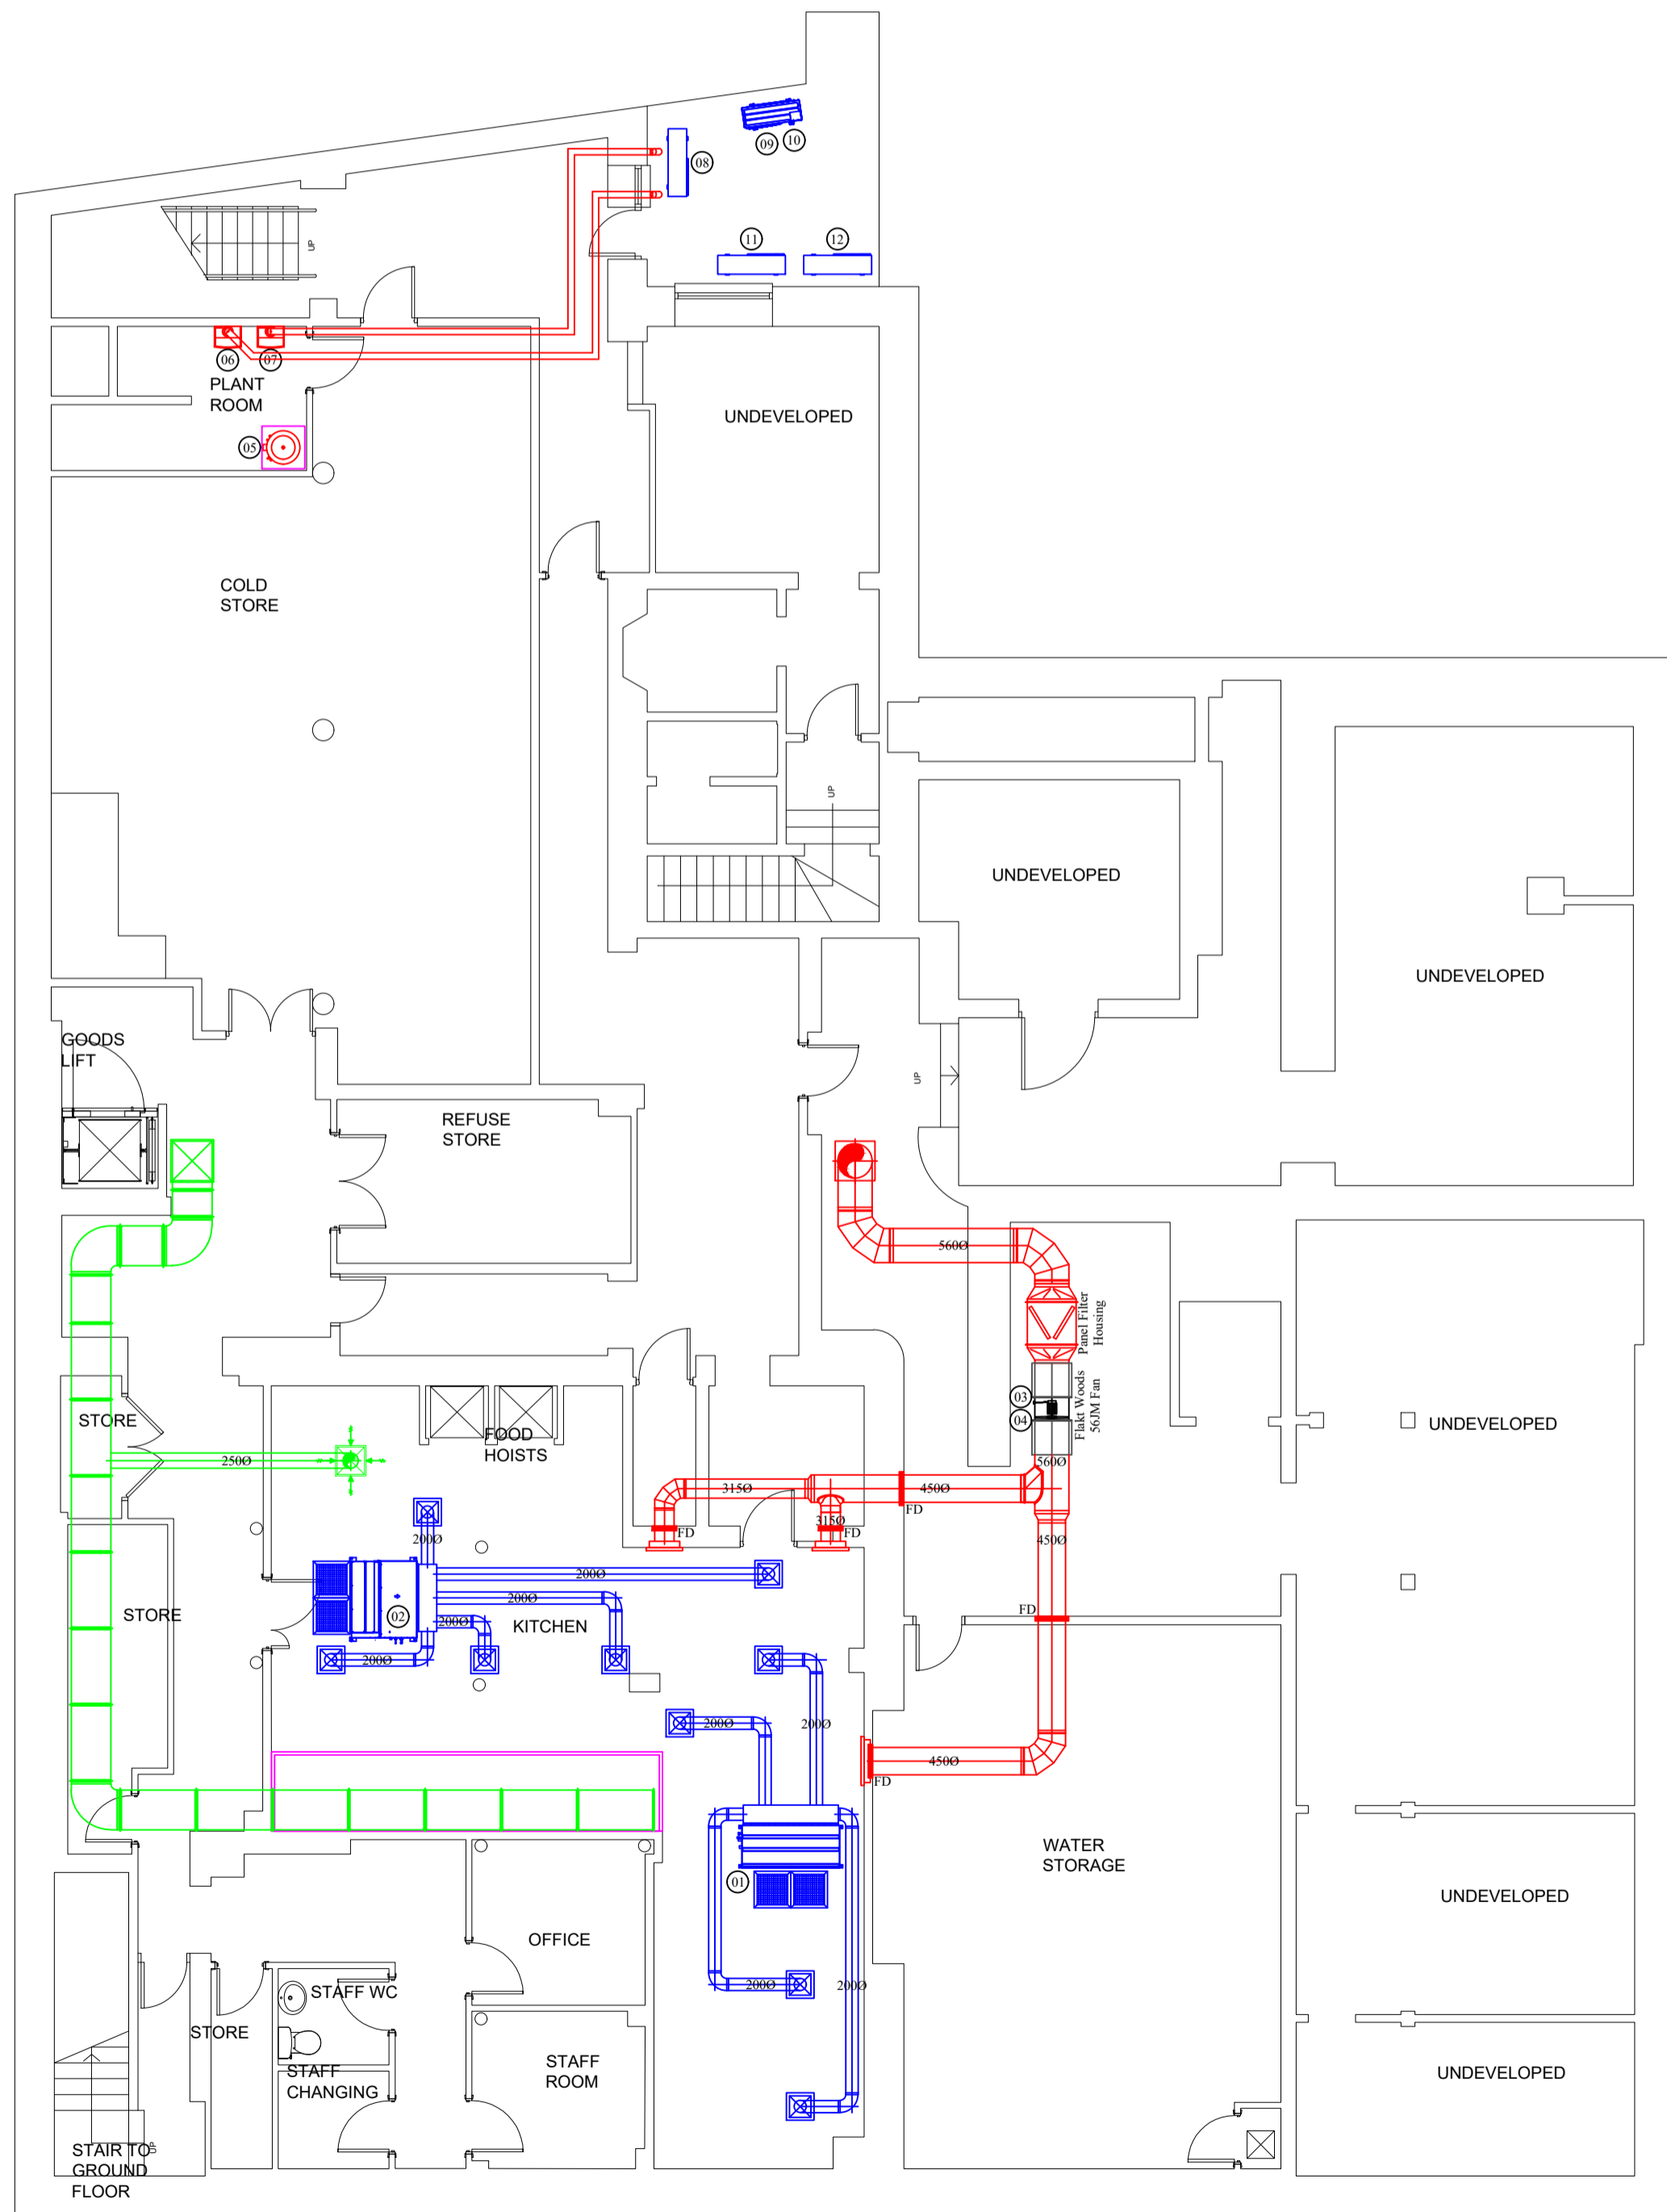


BASEMENT

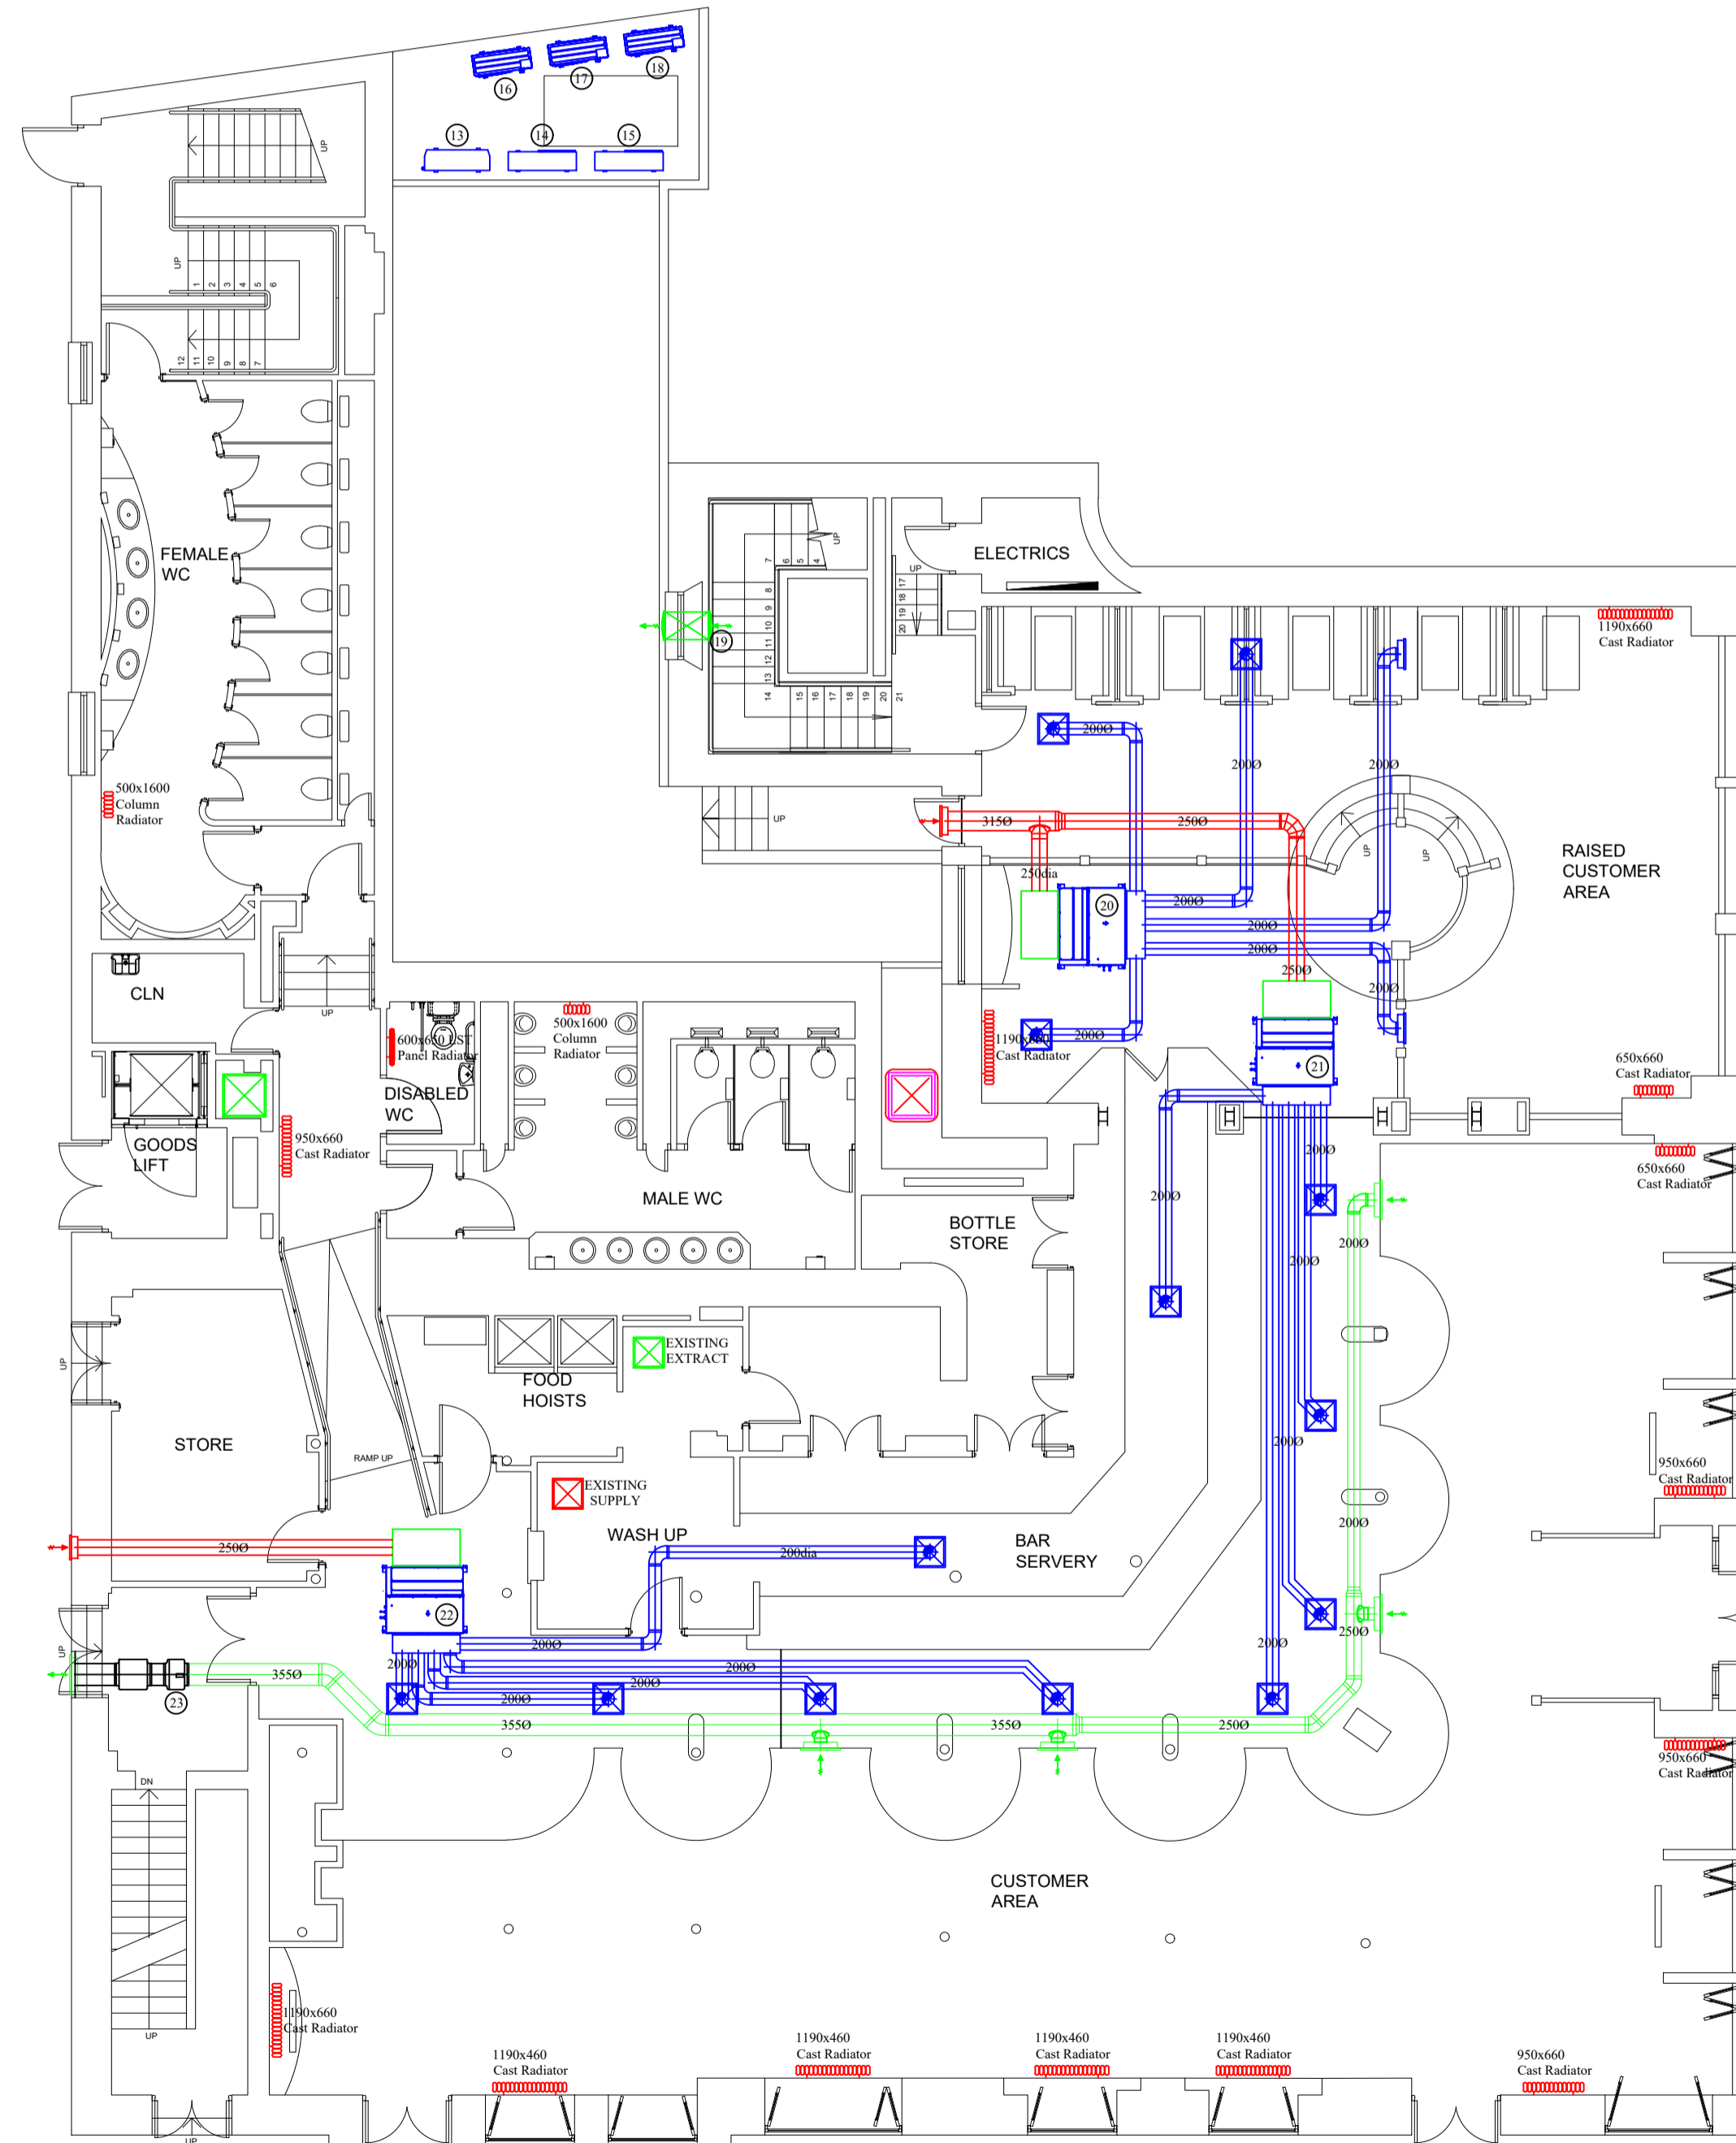

GROUND FLOOR

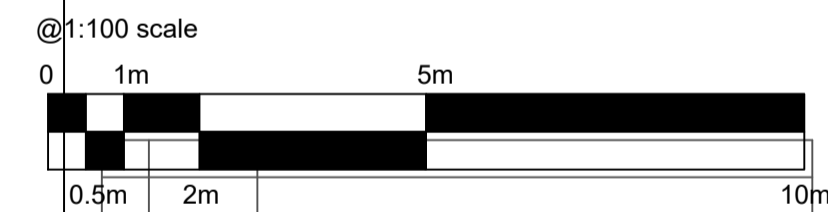

A 01.12.2021 UPDATED BY HI AS PER PLANNERS REQUEST	
Rev	Date Description
Client: JD WETHERSPOON	
Job Title: THE HENGLERS CIRCUS 351-363 SAUCHIEHALL ST GLASGOW G2 3HU	
Dwg Title: PROPOSED BASEMENT & GROUND FLOOR MECHANICAL LAYOUT PLAN	
Date: 08/11/21	Drawn By: DB
Scale: 1:100@A1	Checked By: SH
Dwg No: 1903-00	Rev: -

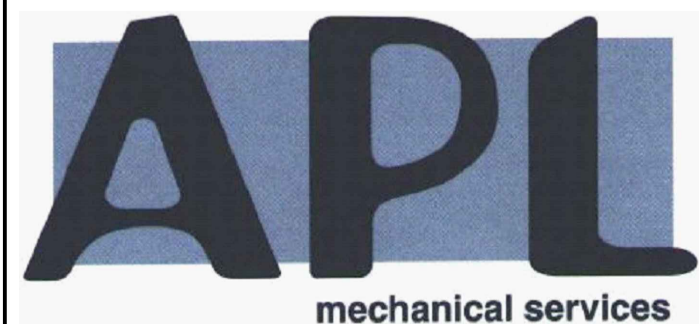

Abbey Plumbing Ltd
3 Whitehills Drive
Whitehills Business Park
Blackpool, FY4 5LW
Tel: 01253 698 159
Email: admin@aplmechanical.co.uk