

DO NOT SCALE FROM THIS DRAWING.
 Except for planning purposes. All dimensions must be verified by the main contractor before the commencement on site of any item of work or the preparation of shop drawings for their own work or that of sub-contractor or suppliers.
 This drawing is to be read in conjunction with all relevant documents. Any queries or discrepancies must be reported immediately to the architect.
 This document is copyright of Studio Hudson Ltd

Home Electric Vehicle charger point



Rolec Type 2, Mode 3 charging sockets are to be installed in locations shown and to be installed in accordance with manufacturer's requirements:

- i. BASICCHARGE : EV Freestanding pedestal charging unit
3.6kW, 16A with built-in 20A, 30mA Type A (DC Sensitive) RCBO By Rolec or Similar
- ii. WALLPOD: EV Wall mounted charging unit
3.6kW, 16A with built-in 20A, 30mA Type A (DC Sensitive) RCBO By Rolec or Similar


The base of the pedestal charging post features a cut out at surface level. The cut out is sufficient to allow suitably sized and rated Steel Wire Armoured (SWA) cable to access the Mount to supply the charging unit. SWA to be ducted below ground to the internally located isolator or as required by the Electrical Engineer

Wall mounted unit to be located as illustrated on the layouts and ducted via the sub-floor from the internal consumer unit.

The electrical supply shall be provided from the proposed plots installation consumer unit incorporating 30mA RCD protection in locations illustrated on the electrical layouts.

Key

	Planning Application Boundary
	Site Ownership Boundary
	Line of existing building
	Outline of existing trees to be retained
	T1, T2 etc Outline of tree to be removed
	Outline of new proposed hedge and tree screening

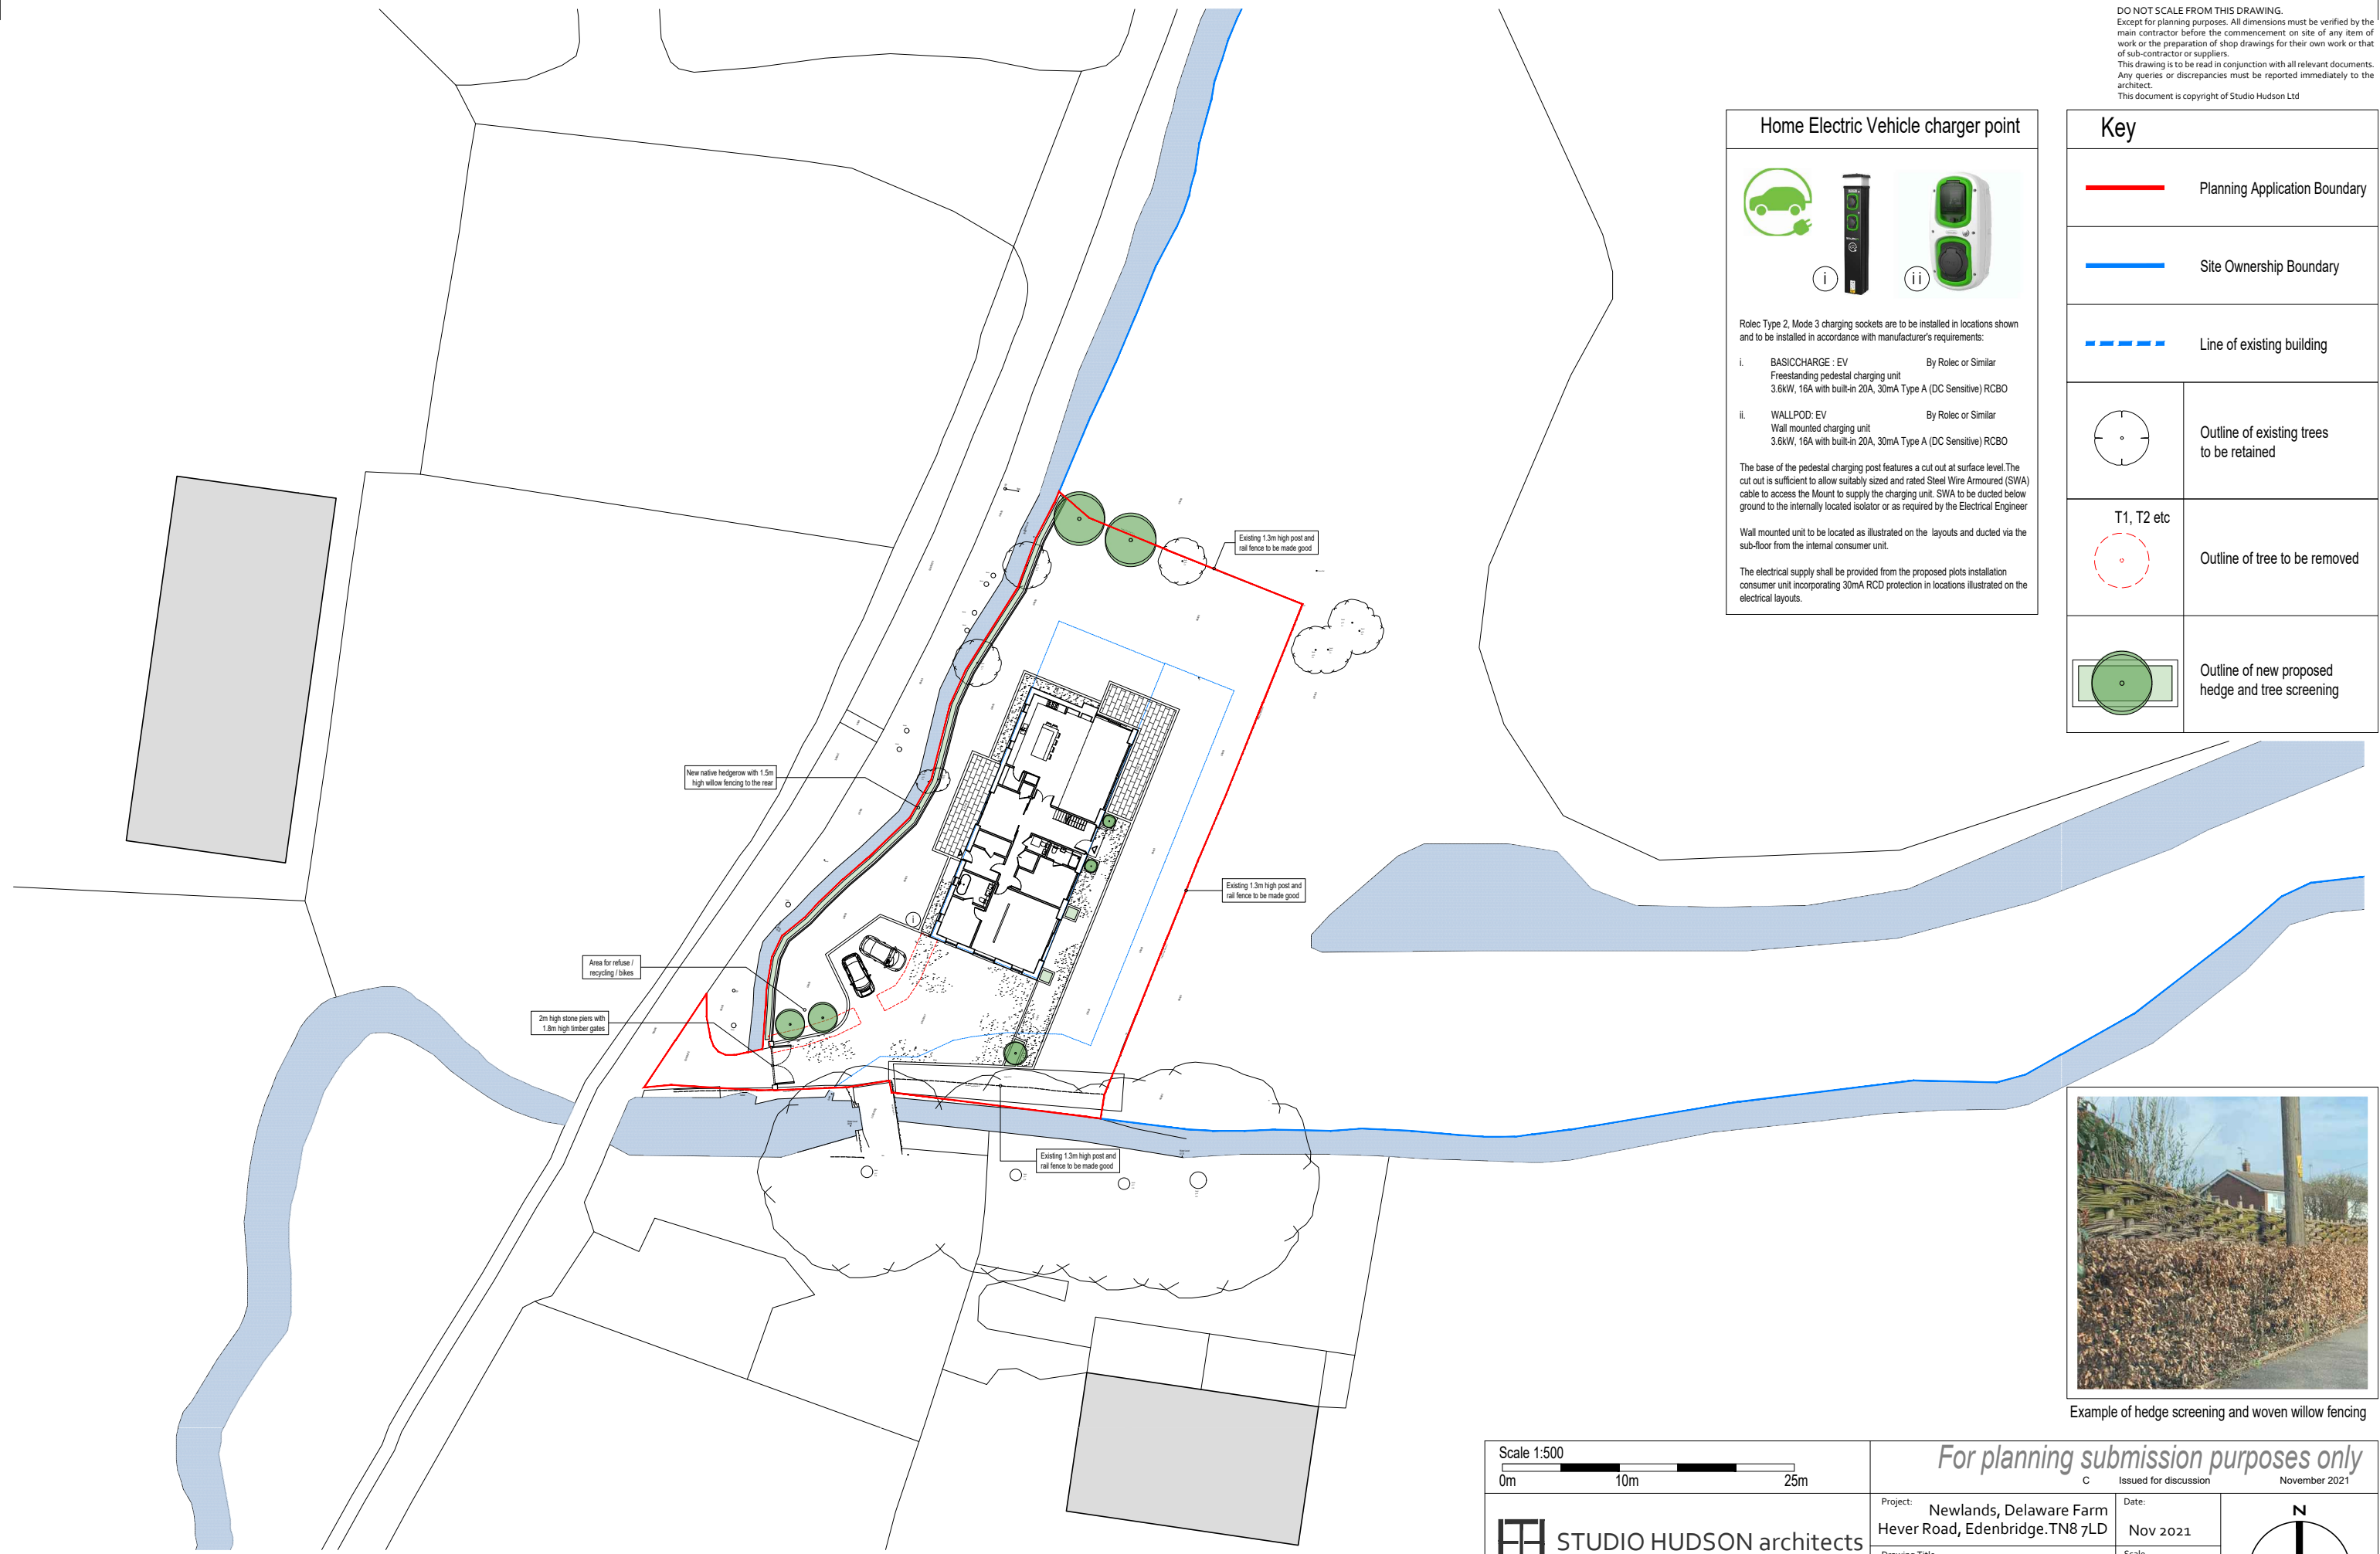

Example of hedge screening and woven willow fencing

Scale 1:500
 0m 10m 25m

STUDIO HUDSON architects

Studio Hudson Ltd. 2 Wilman Road, Royal Tunbridge Wells, Kent. TN4 9AJ
 t: 01892 673 158 e: info@studio-hudson.co.uk
 www.studio-hudson.co.uk

For planning submission purposes only

C Issued for discussion November 2021

Project: Newlands, Delaware Farm Hever Road, Edenbridge. TN8 7LD	Date: Nov 2021
Drawing Title: Proposed Site Plan	Scale: Noted @A3
Drawing Number: 20017a-P-200	Rev: C