

**Notes**



- ALL DIMENSIONS ARE SHOWN IN MILLIMETRES (mm), UNLESS NOTED OTHERWISE.
- ALL LEVELS ARE SHOWN IN METRES (m) RELATIVE TO AOD, UNLESS NOTED OTHERWISE.

**Key to symbols**

- HV ELECTRIC OVERHEAD 9m EXCLUSION ZONE
- TREE CANOPY
- AREA OF SET ASIDE FOR NEW FLOOD STORAGE COMPENSATION VOLUME
- TREE
- GRASS AREAS
- NEW STONE ROADWAY
- NEW CONCRETE ROADWAY
- NEW CONCRETE FOOTPATH
- NEW GROUND LEVEL DRAWPIT CHAMBER
- NEW GROUND LEVEL MH CHAMBERS
- NEW ASSETS

**Reference drawings**

ET38-MMB-00-XX-DR-T-00101 PLANNING LOCATION PLAN  
 ET38-MMB-00-XX-DR-T-00102 PLANNING EXISTING SITE PLAN SHEET 1 OF 2  
 ET38-MMB-00-XX-DR-T-00103 PLANNING EXISTING SITE SECTIONS  
 ET38-MMB-00-XX-DR-T-00104 PLANNING NEW SITE PLAN SHEET 1 OF 2  
 ET38-MMB-00-XX-DR-T-00105 PLANNING NEW SITE SECTIONS  
 ET38-MMB-00-XX-DR-T-00106 PLANNING NEW SITE LAYOUT VEHICLE SWEEP PATH  
 ET38-MMB-00-XX-DR-T-00107 PLANNING NEW HSAF'S ELEVATIONS  
 ET38-MMB-00-XX-DR-T-00108 PLANNING NEW PST DESLUDGE PS ELEVATIONS  
 ET38-MMB-00-XX-DR-T-00109 PLANNING NEW MCC KIOSK PLAN AND ELEVATIONS  
 ET38-MMB-00-XX-DR-T-00111 PLANNING EXISTING SITE PLAN SHEET 2 OF 2  
 ET38-MMB-00-XX-DR-T-00112 PLANNING NEW SITE PLAN SHEET 2 OF 2

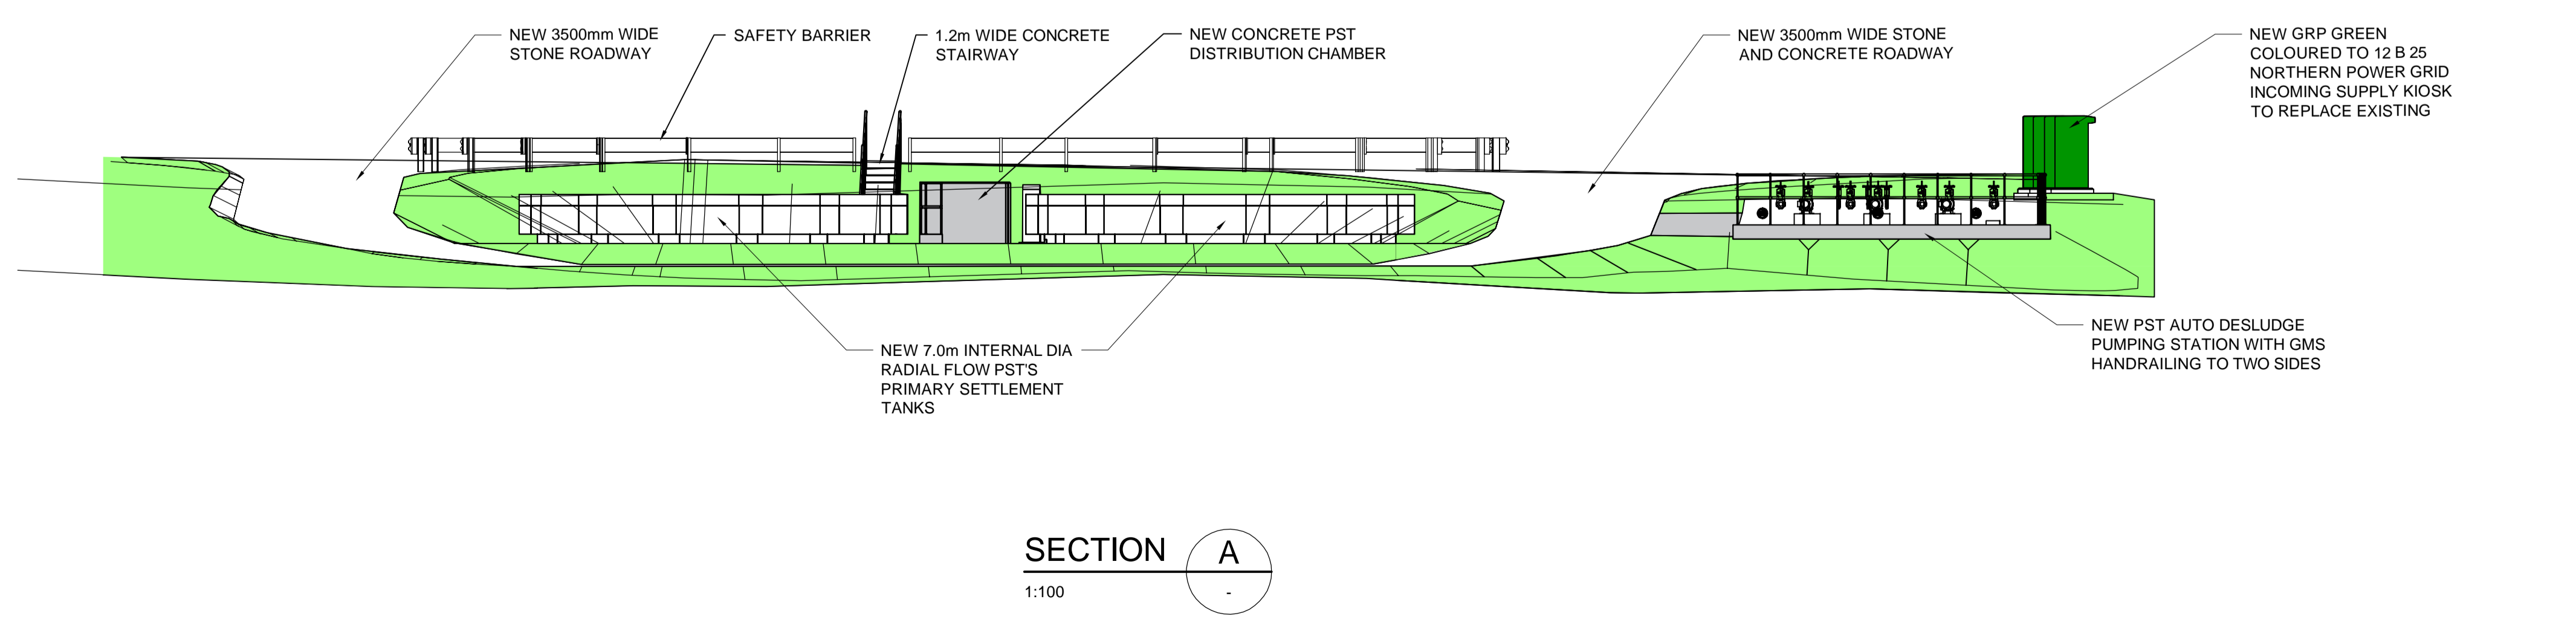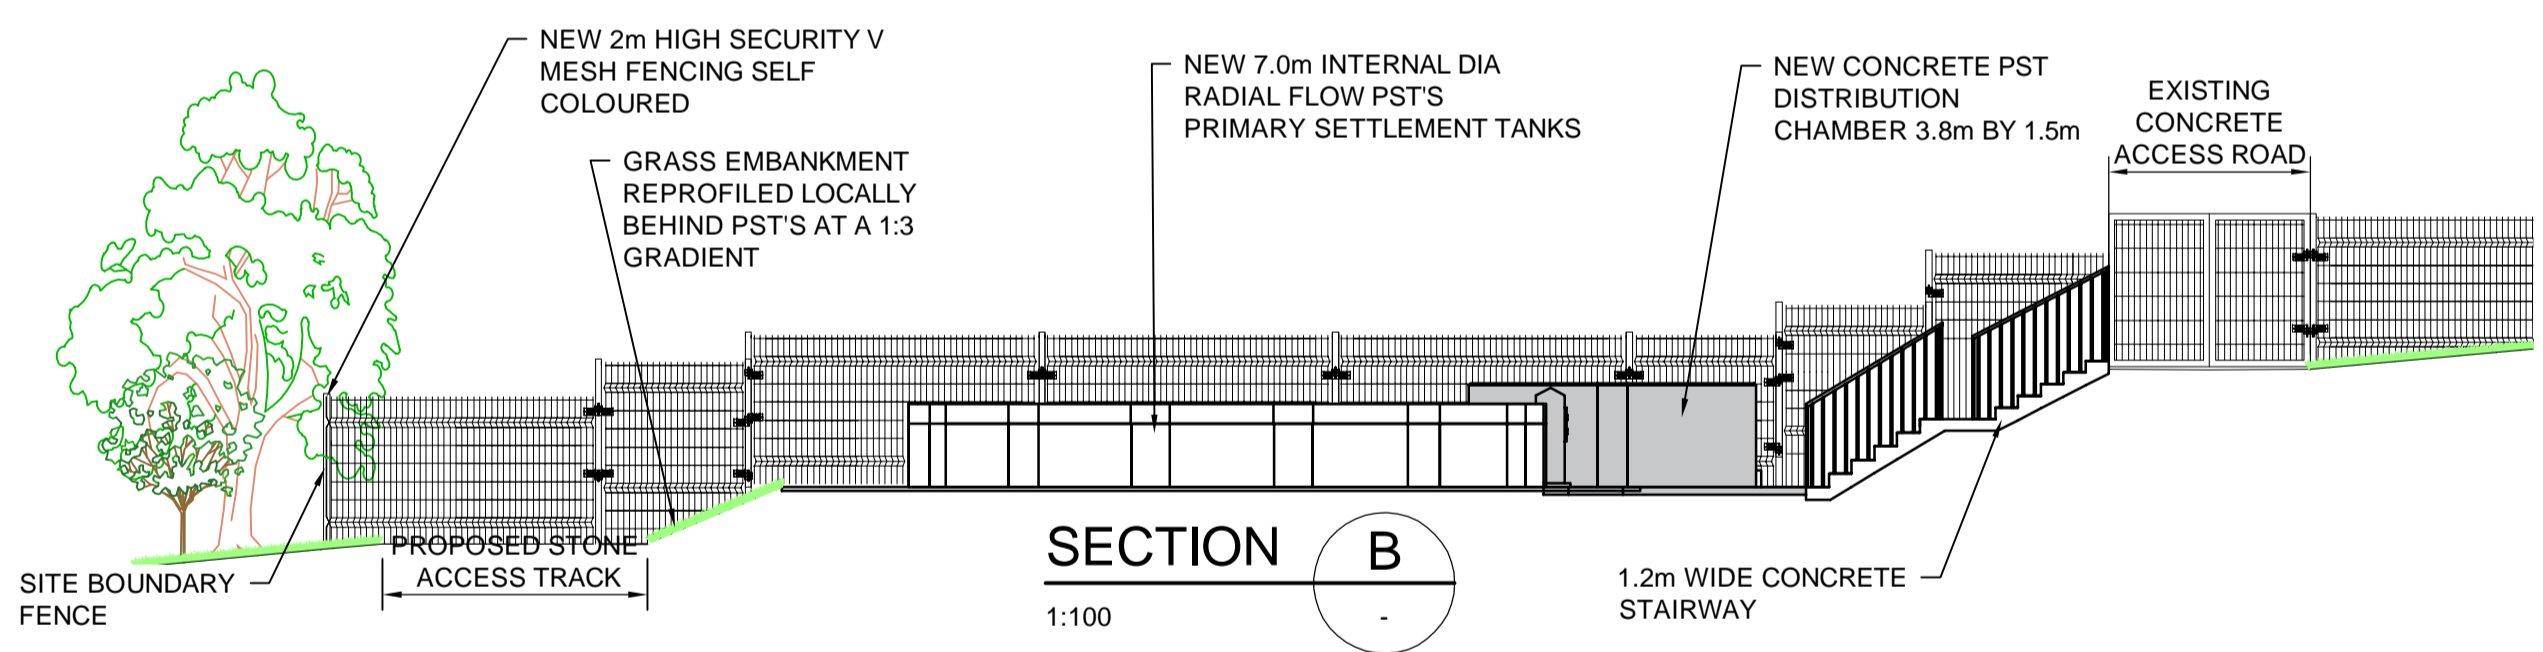

Rev	Date	Drawn	Description	Ch'k'd	App'd
P01	20/01/21	NN	First Issue		KM
P02	29/01/21	NN	Updated with planning consultant comments		KM
P03.1	19/11/21	TH	Updated for planning NMA (HSAF/MCC Building Locations Swapped)	HB	TP

**MMB**  
MOTT MACDONALD BENTLEY

Mott MacDonald Bentley  
Spectrum 5, Spectrum Business Park  
Seaham, SR7 7TT  
United Kingdom

E info@mm-b.co.uk  
W www.mm-b.co.uk

Client

**NORTHUMBRIAN WATER** *living water*

Status Stamp

**NOT FOR CONSTRUCTION**

Title

**Rothbury STW I&D  
New PST Elevations  
Planning Application**

Sheet 1 of 1

DRL No:

Designed	R Nixon	RN	Eng check	H Biasi	HB
Drawn	T Haider	TH	Coordination		---
Dwg check	---	---	Approved	T Pitchforth	TP

Scale at A1: 1:100

Suitability Code: S2

Rev: P03.1

Security: STD

Suitable for Information

Drawing Number: ET38-MMB-00-XX-DR-T-00110