
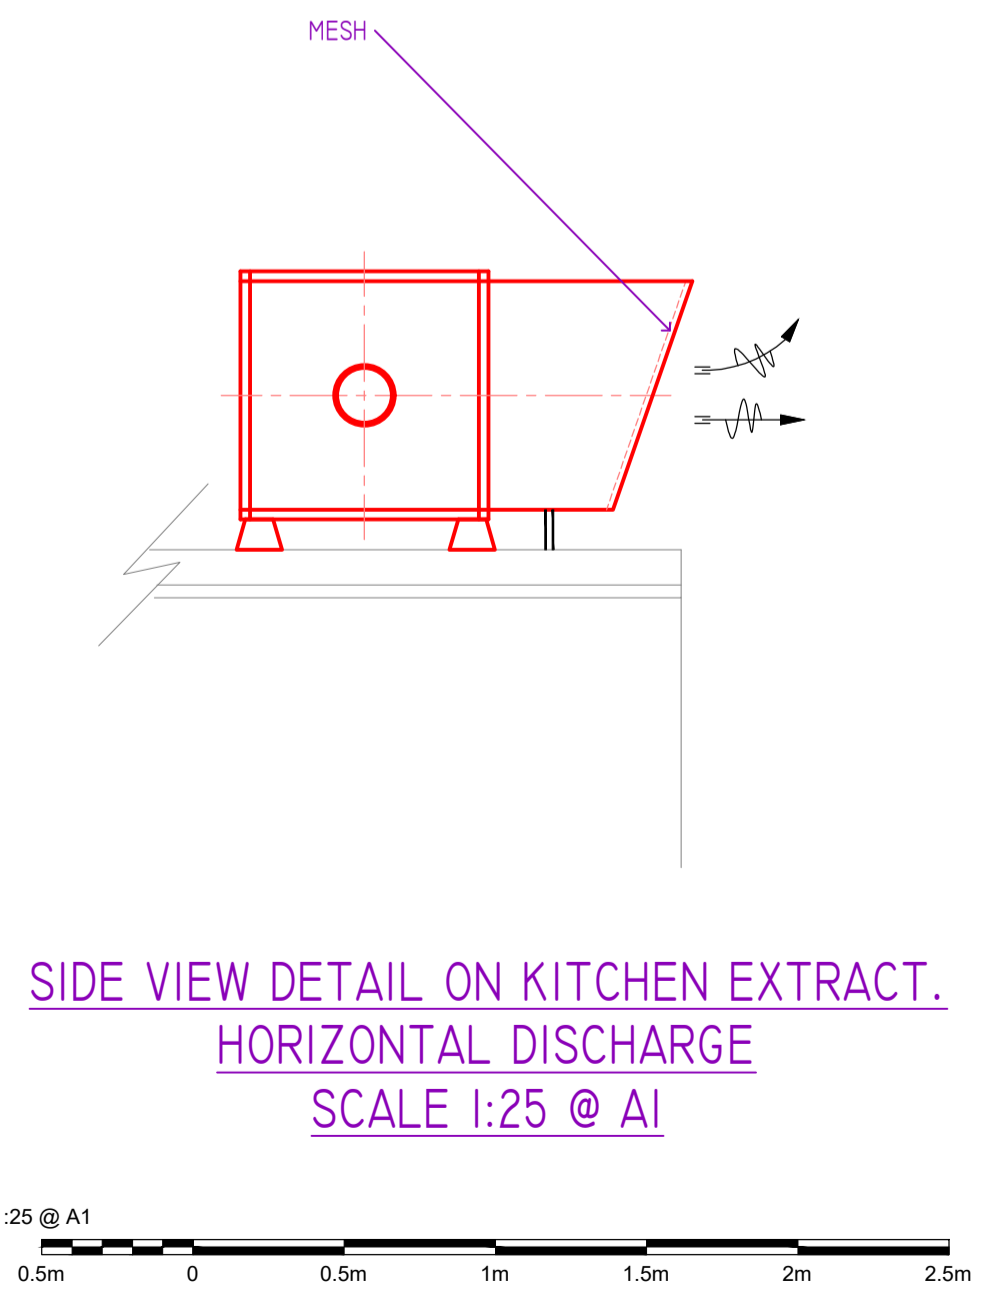
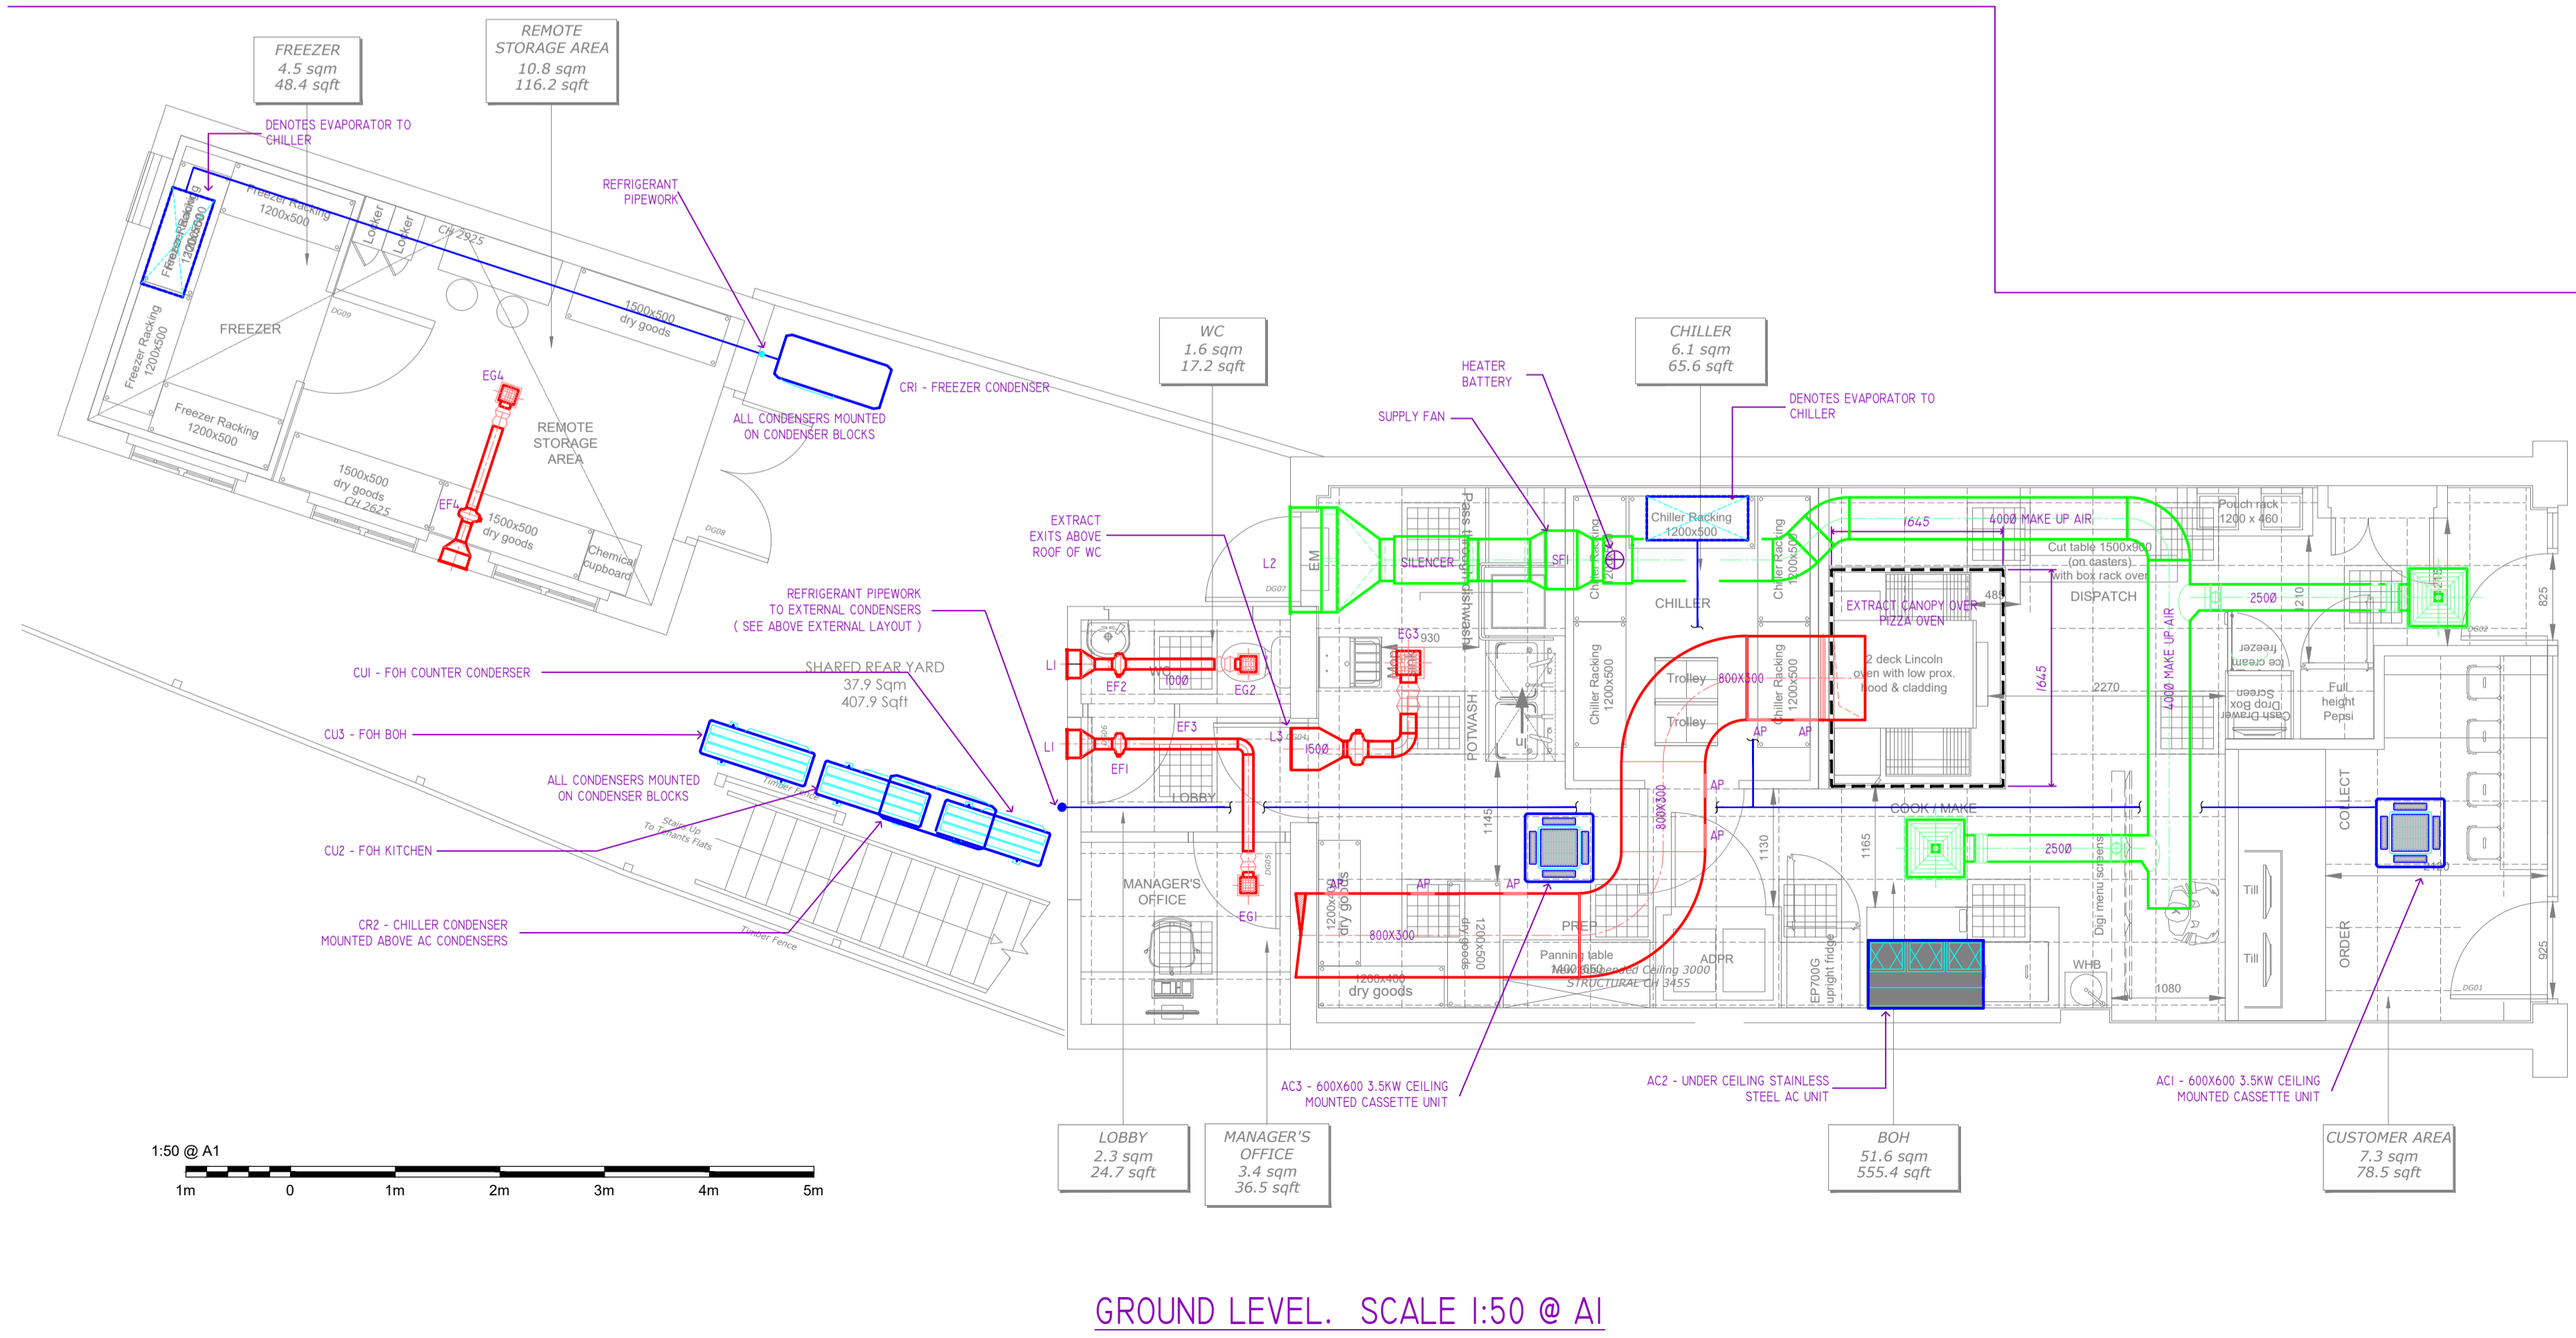
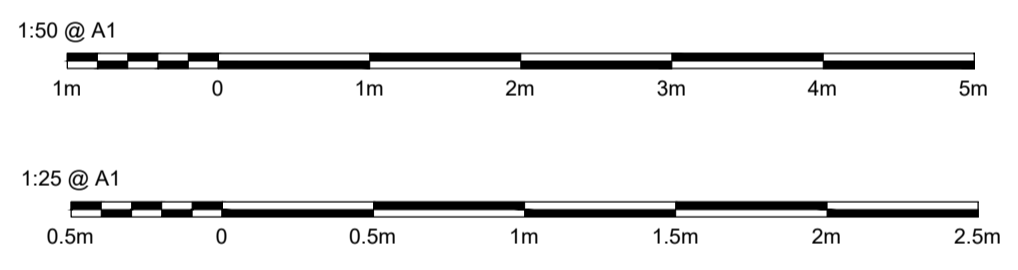
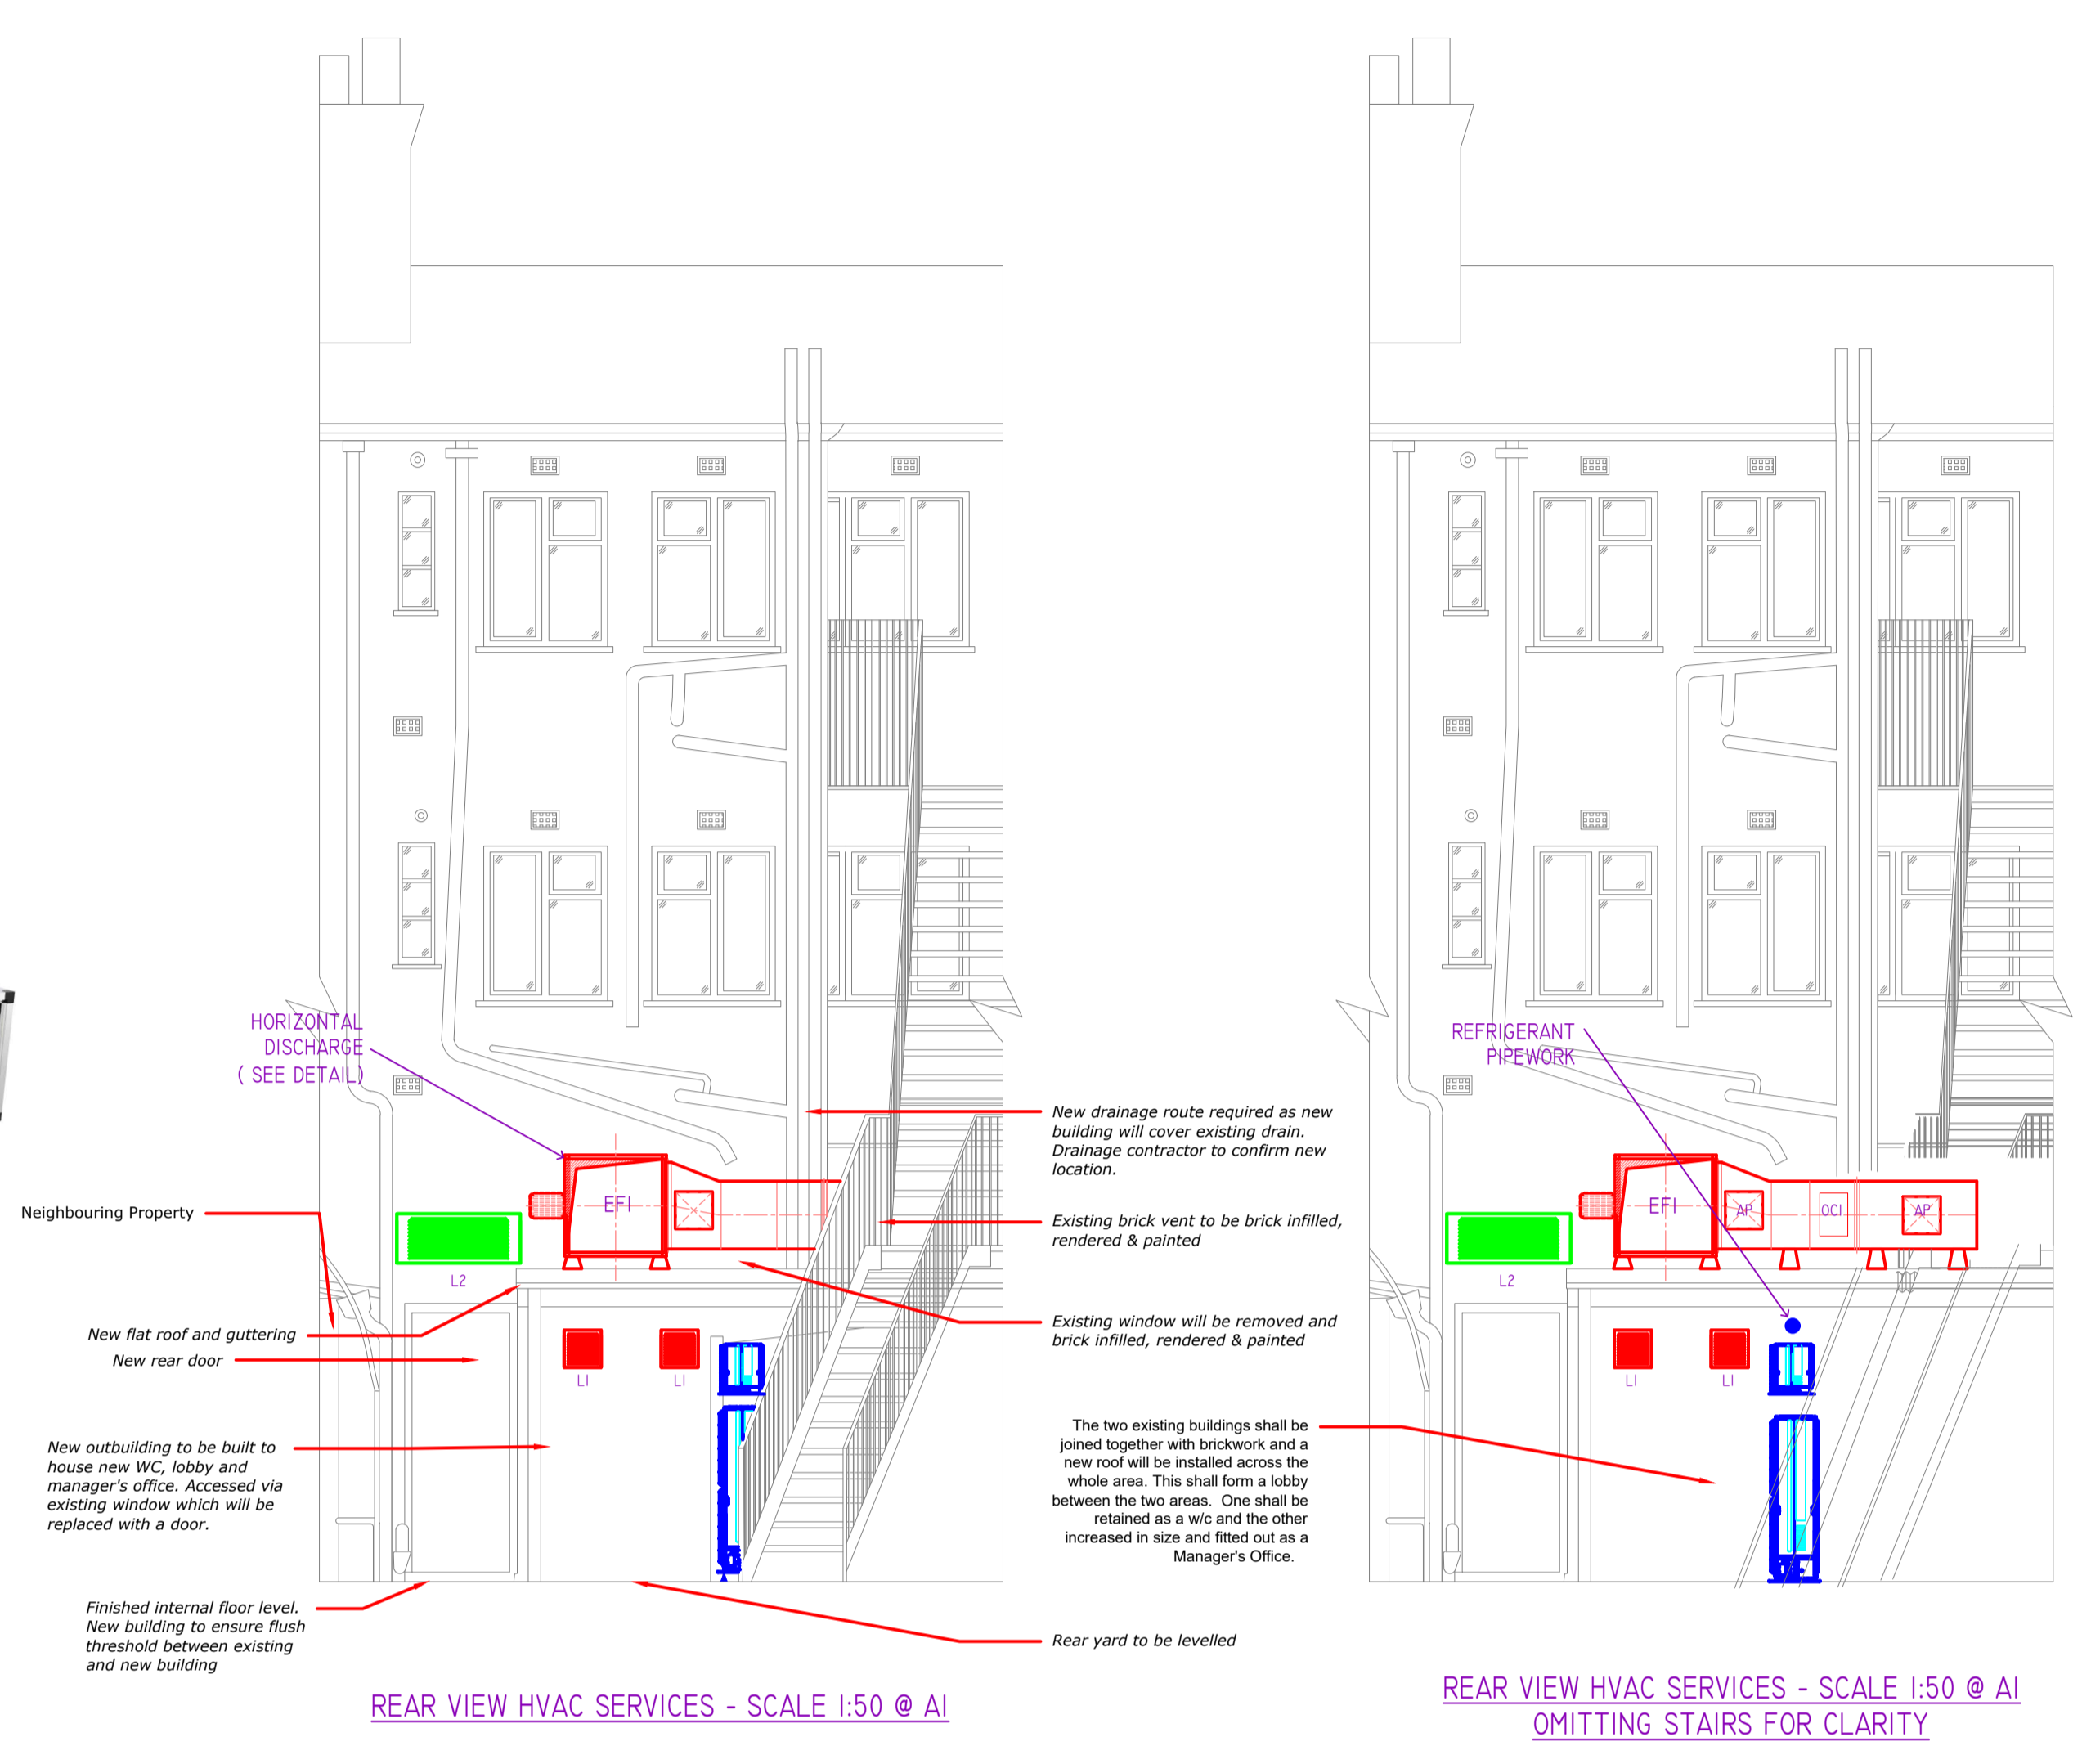


EQUIPMENT DETAILS

- FRONT OF HOUSE**
CUI - 800X285X714H
4.1KG
49DBA
- KITCHEN AC**
CU2 - 1136X360X943H
6.7KG
51DBA
- STAFF AC**
CU5 - 800X285X550H
35KG
48DBA
- FREEZER**
CRI - 800X500X500H
70KG
61DBA
- CHILLER**
CR2 - 800X400X400H
4.8KG
61DBA
- EFI - KITCHEN EXTRACT**
690X690X690
15KG
46DBA
- ODOUR CONTROL**
ESPI
1662X620X35H
120KG
OCI
300X300X150D
20KG
- LOUVER SCHEDULE**
L1 - 300X300
L2 - 1000X400
L3 - 400X400

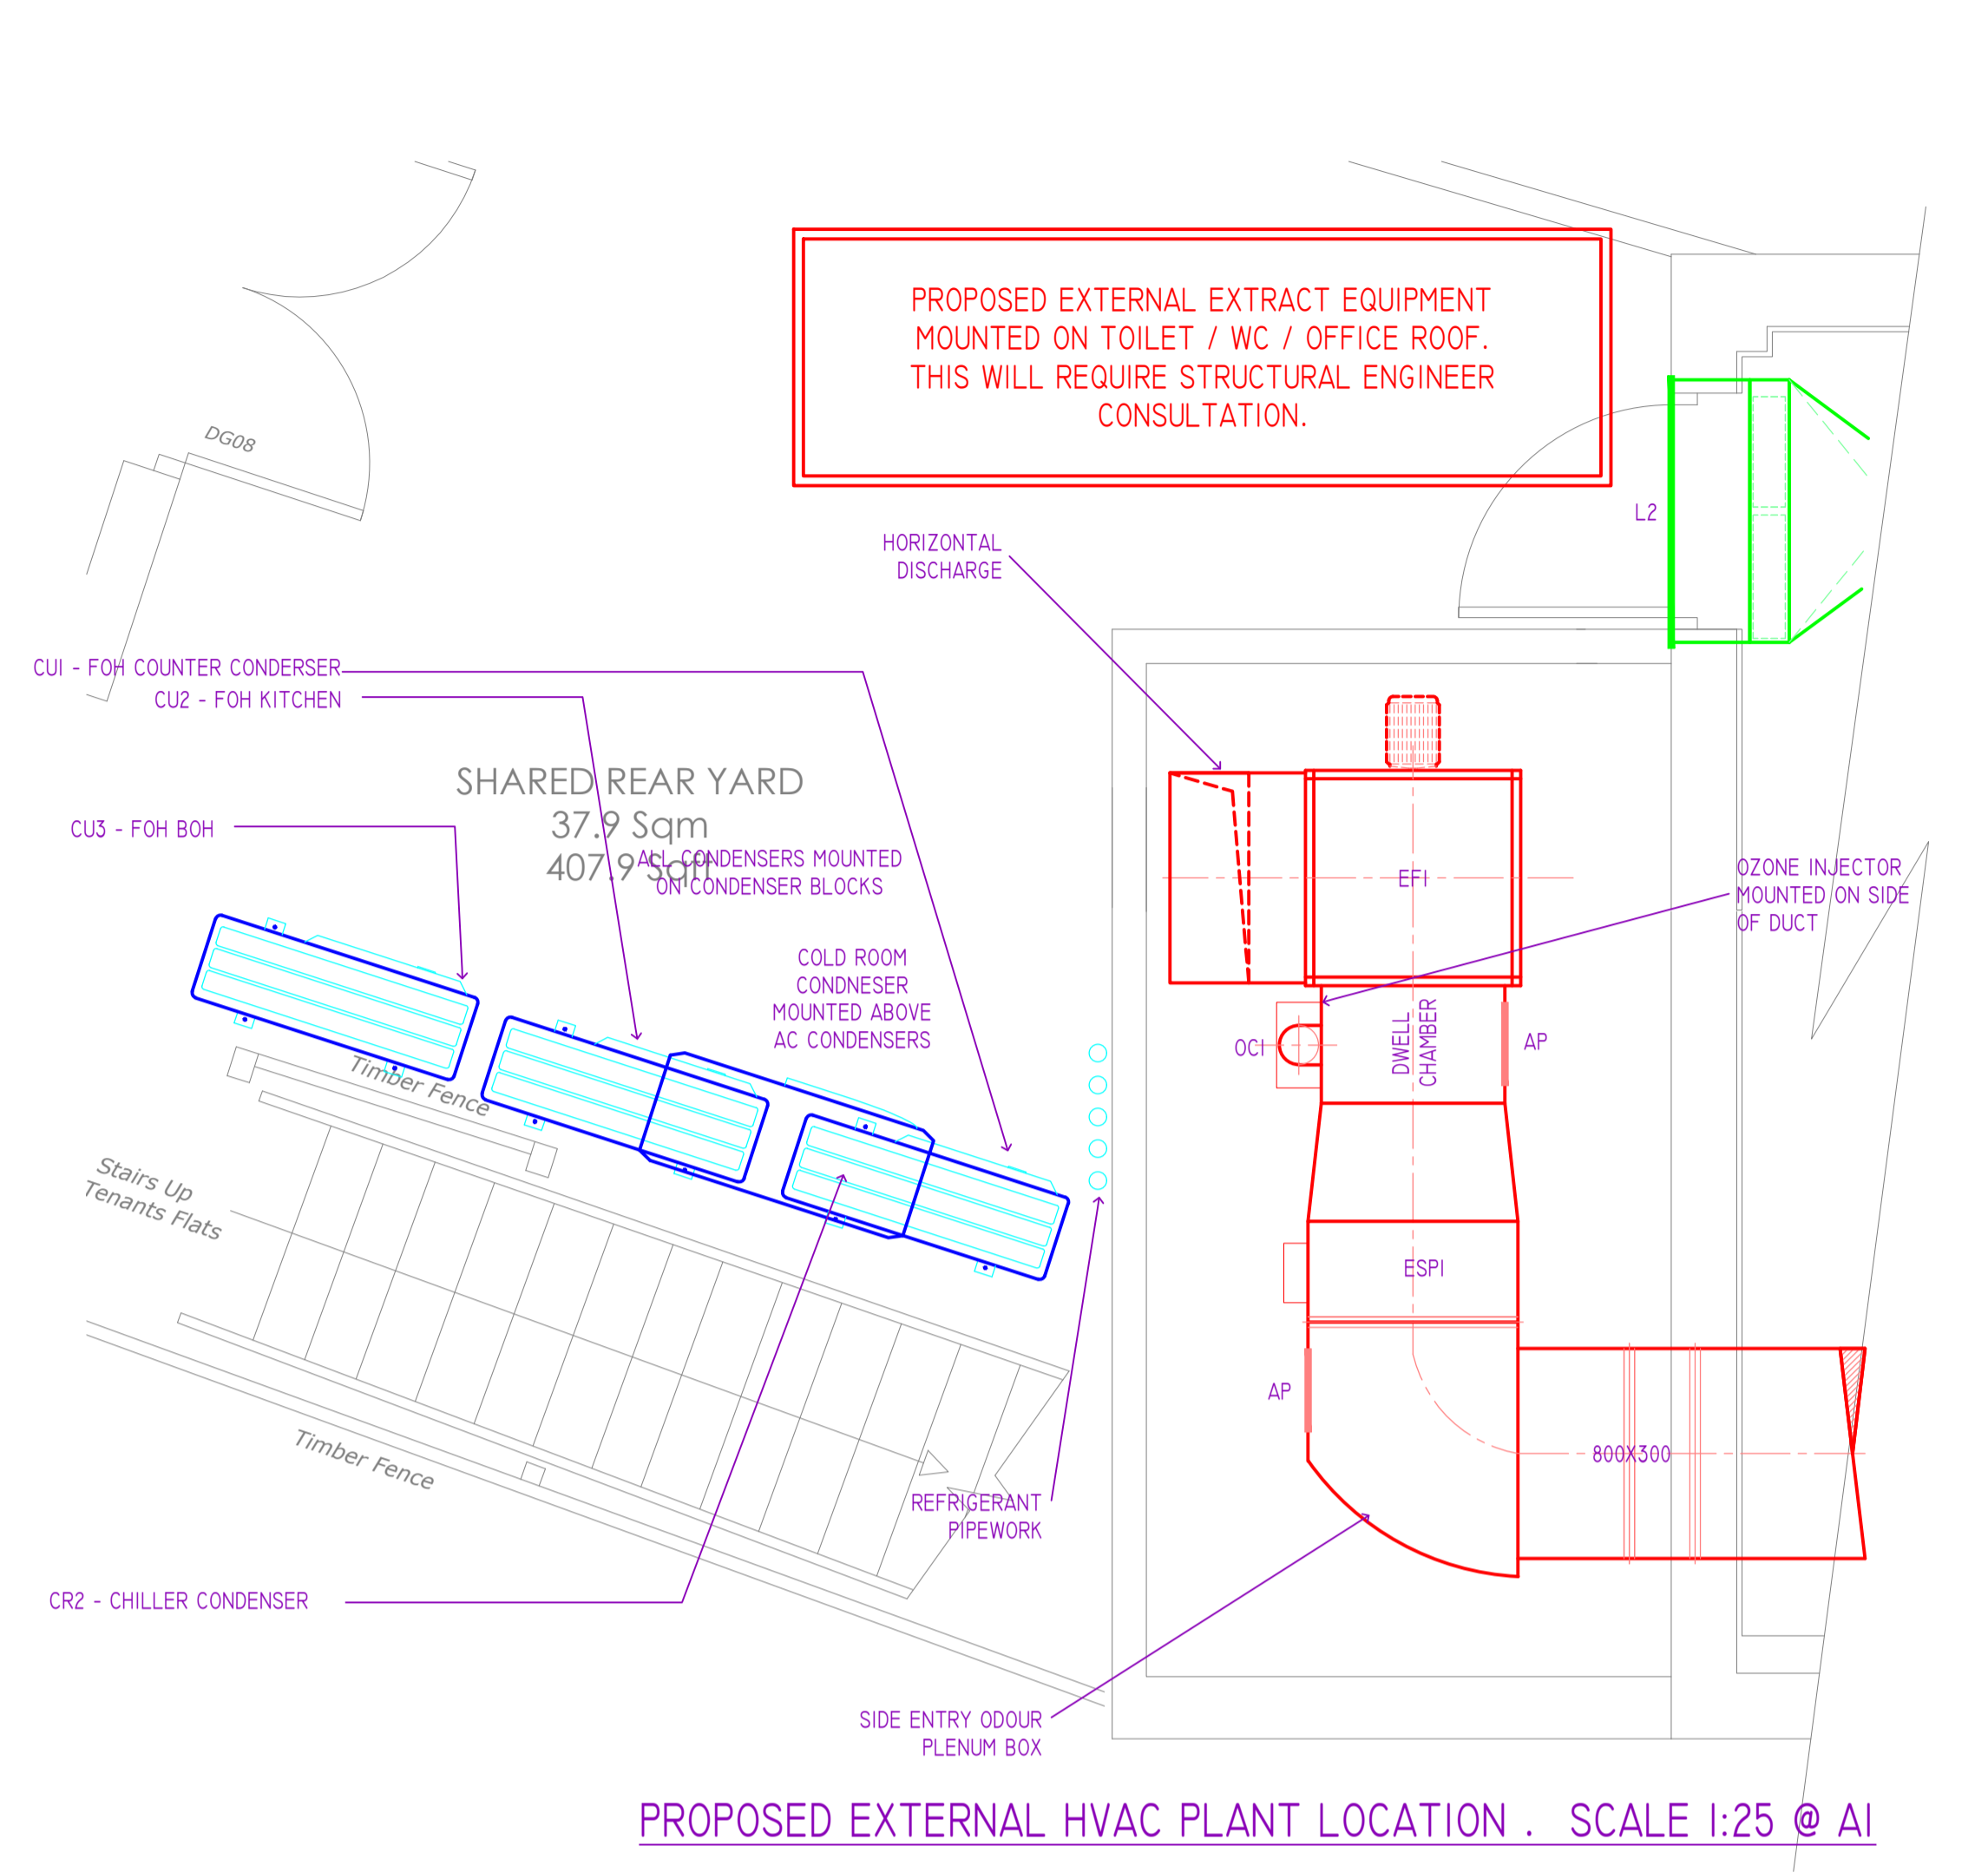

REV - D

FOR THIS DRAWING WE CLAIM LEGAL PROTECTION REGARDING COPYRIGHTS, COMMERCIAL CONFIDENTIALITY AND INTELLECTUAL GUARANTEE. THIS DRAWING IS ONLY TO BE USED FOR THE PURPOSE FOR WHICH IT IS SUPPLIED AND WITHOUT OUR CONSENT IT MUST NOT BE REPRODUCED, COPIED OR MADE ACCESSIBLE TO ANY THIRD PARTY.

REVISIONS	
REV A	15.07.21 CHANGES INCORPORATED IN THIS DRAWING AS FOLLOWS: NEW ARCHITECTS BACKGROUND & REAR ELEVATION. HVAC SERVICES MODIFIED TO SUIT THIS.
REV B	29.07.21 STAFF OUTDOOR CONDENSER OMITTED. KITCHEN EXTRACT NOTE MODIFIED.
REV C	26.10.21 NEW BACKGROUND INCORPORATED. REAR ELEVATION ADDED.
REV D	27.10.21 MODIFICATIONS MADE IN COLLABORATION WITH PLANNING DEPT RELATING TO CONDENSERS AS NOW INDICATED ON GROUND LEVEL VIEW.

DRAFT - FOR COMMENT

FOR PLANNING ONLY

Project Address:
PIZZA HUT, 131 Station Rd, Sidcup, Kent, DA15 7AA

Ashworth,
Unit 9, Lionwood Court,
Llantrisant, Neath, SA10 4EG
www.ashworthuk.com



PROJECT: Pizza Hut, 131 Station Rd, Sidcup, Kent
CLIENT: Pizza Hut

DRAWING: General Arrangement of HVAC Layout

FOR INFORMATION ONLY

SCALE: AS SHOWN @ A1
JOB No: 0000

DRAWING No: 0000/M/100 REV D