



1 PL_P_420_Quarry Haul Road Typical Lighting Plan
1 : 20

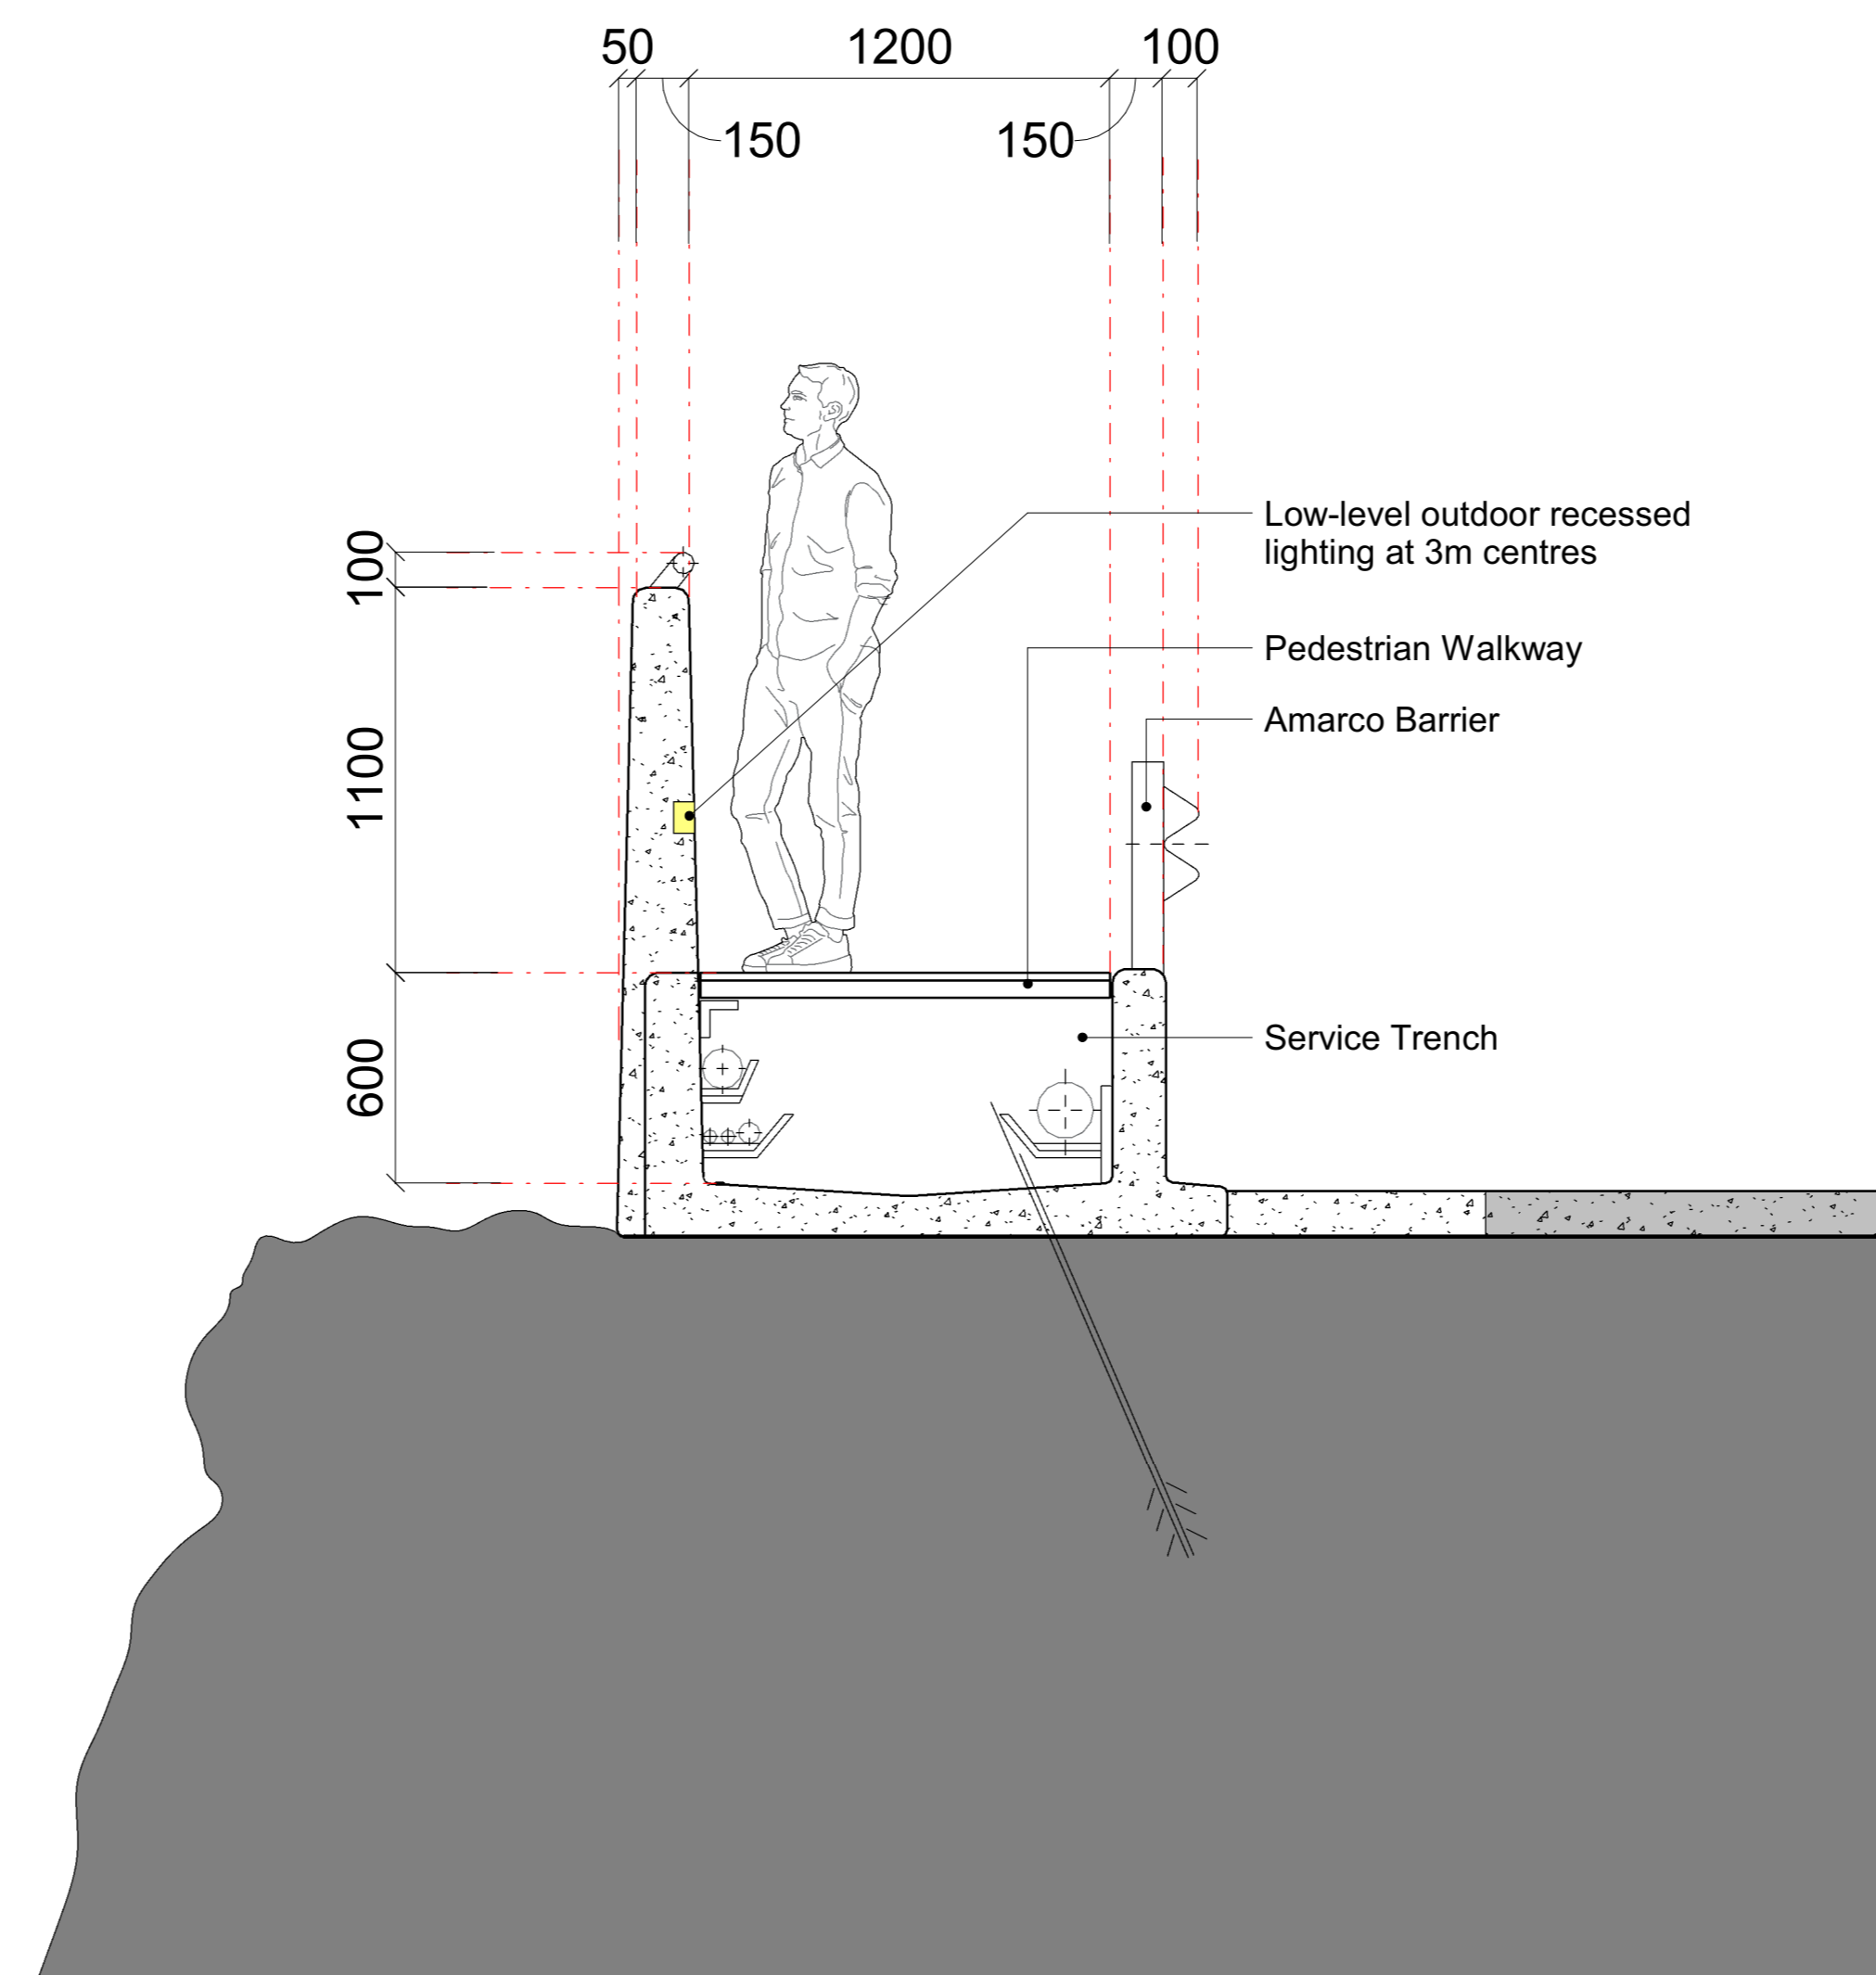

2 PL_Quarry Access Road_Detailed Section Lighting
1 : 20

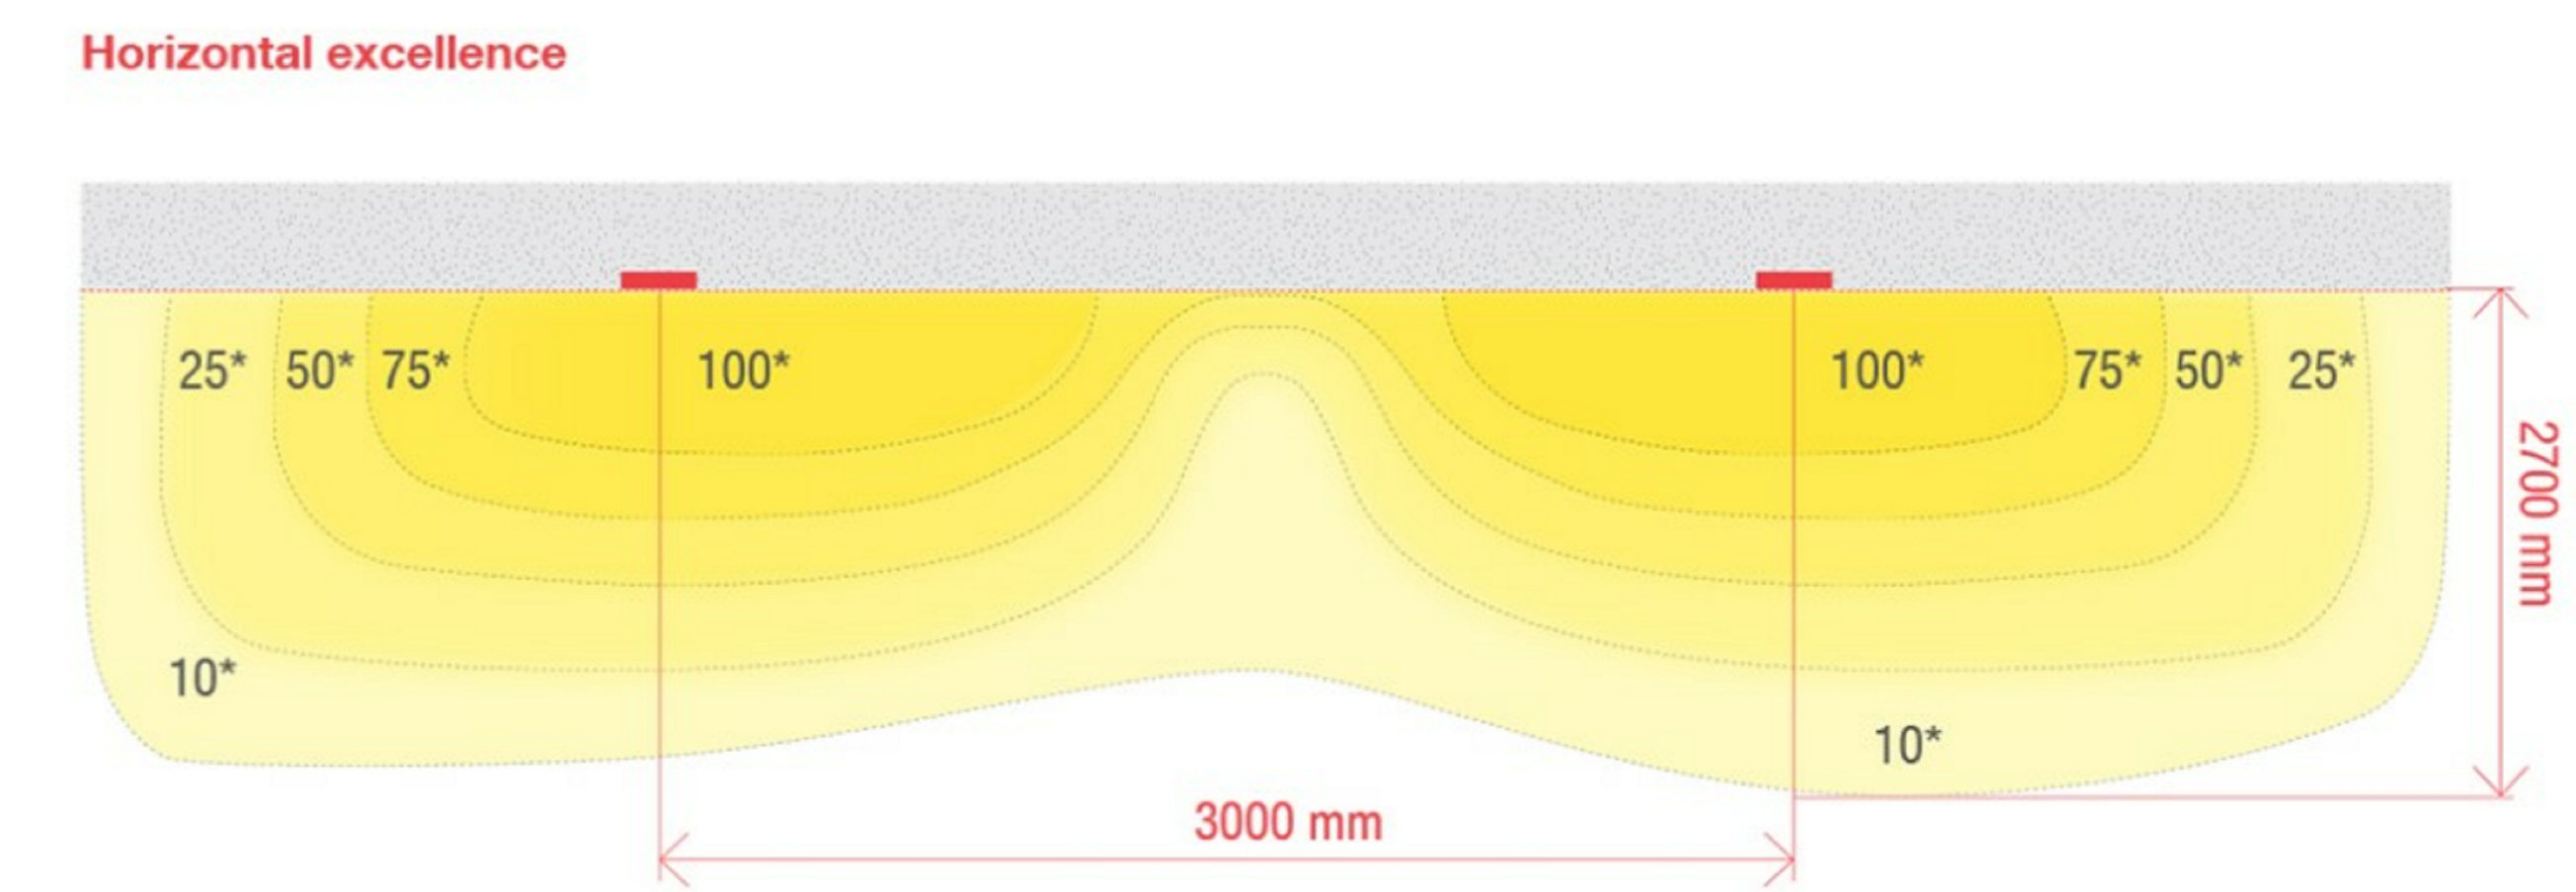


Notes

Disclaimer: Do not scale from this drawing. Check all dimensions on site before fabrication or setting out. This document is copyright and may not be reproduced without permission of the owner.

Consultants
Project Manager: Radcliffe
Planning Consultant: Soille
Quantity Surveyors: G&T
Structural Engineers: AKTII

Rev	Issued for Planning	Reason for Issue	Date	Drawn	Checked
00	Issued for Planning		14.04.2022	Apt	

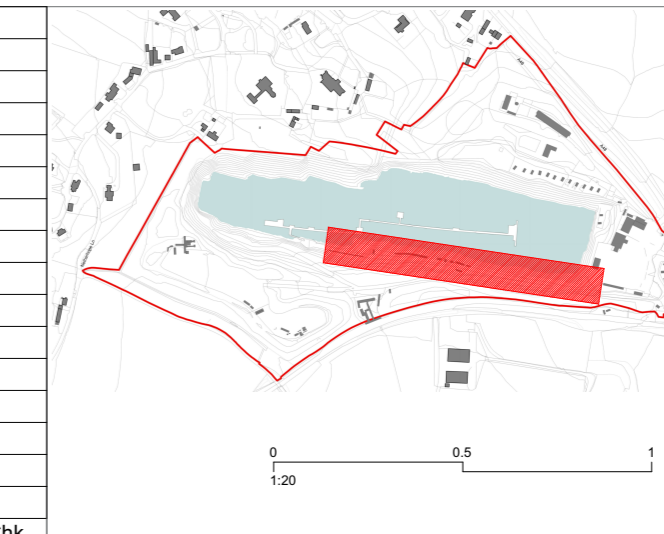

Apt

235 St John Street London EC1V 4NG www.aptlondon

Client: Dayhouse Holdings Ltd
Project: Dayhouse Quarry
Drawing Title: Quarry Haul Road - Lighting Plan

Scale: 1 : 20 @ A0

Project No: 21018 Drawing No: PL_P_420 Revision: 00