
 


Existing Block Plan
Scale 1:500

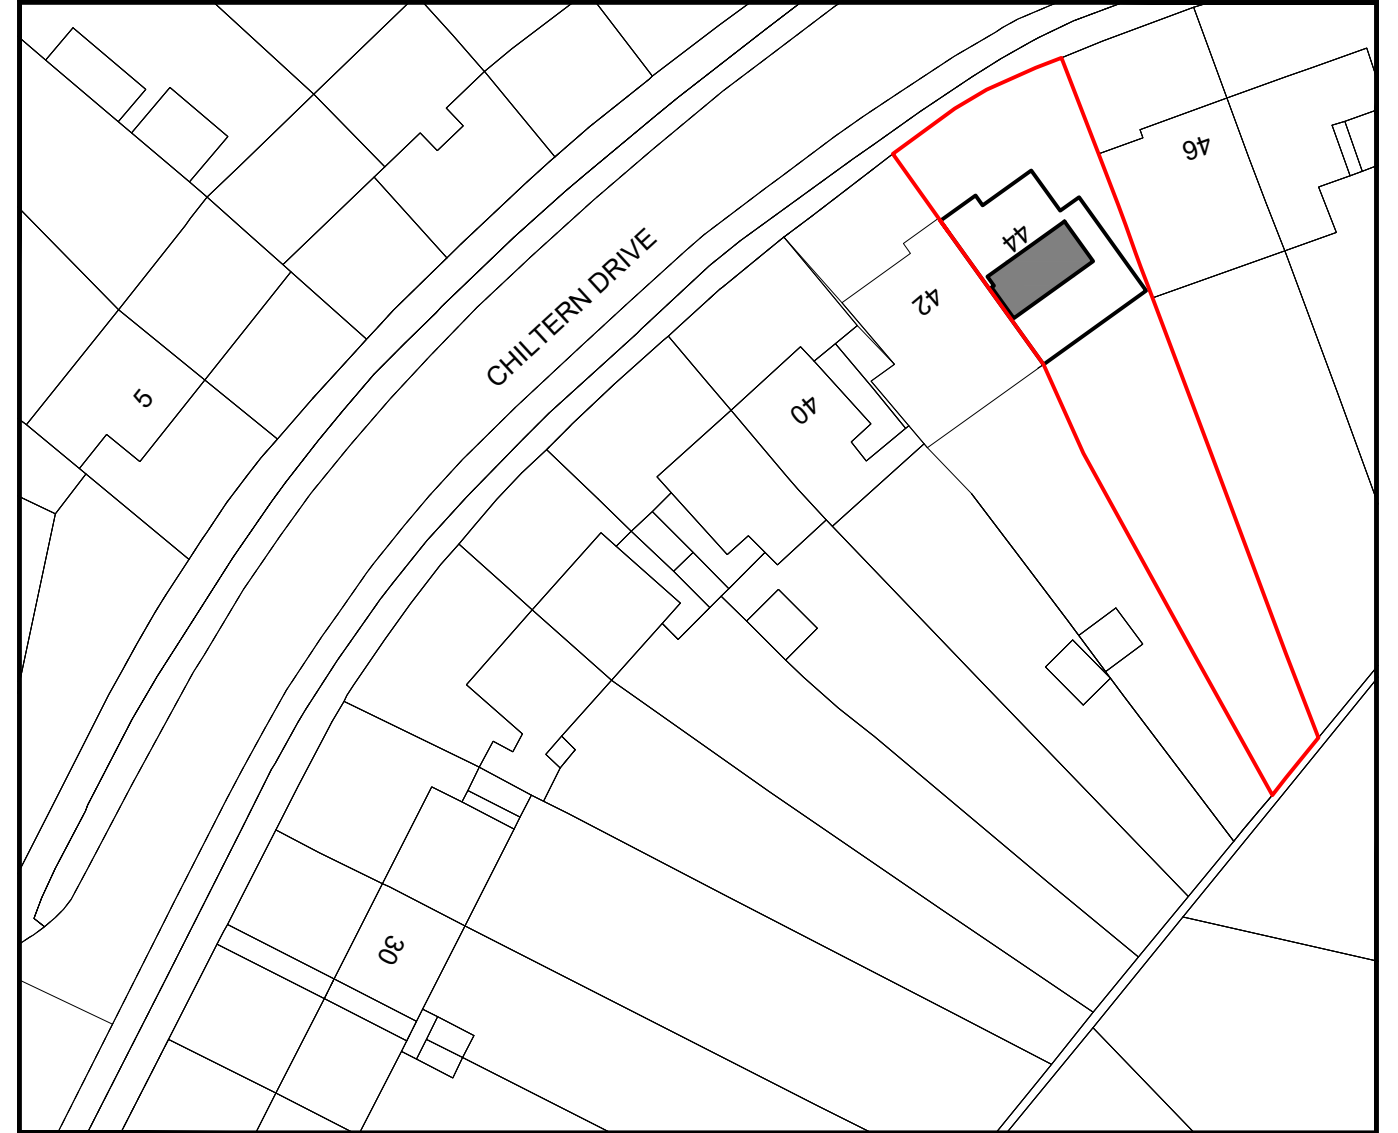

Proposed Block Plan
Scale 1:500



| Revision notes: | | |
|-----------------|-------|--|
| Rev: | Date: | Notes: |
| 001 | | <p>The Contractor must carry out His/Her own measured survey prior to works commencing on site to verify site dimensions and to report any discrepancies to the Designer. Contractor to refer to Building Control Notes. Contractor is responsible for final on site design using on site dimensions.</p> <p>Contractor responsible for on site drainage layout/runs - to be agreed by Building Control prior to Construction starting on site. All Details to be approved by Building Control prior to construction starting on site.</p> |

Drawn by:
FD

Project:
44 Chiltern Drive, Rickmansworth, WD3 8JY

Date:
03.03.2022

No.:
21-1975

Client:

Drawing Title:
EXISTING BLOCK PLAN
PROPOSED BLOCK PLAN

Scale @ A3:
1:500

Rev:
B

Issue:
PLANNING DRAWINGS

Page:
D02



www.planituk.co.uk