




Proposed Front Elevation

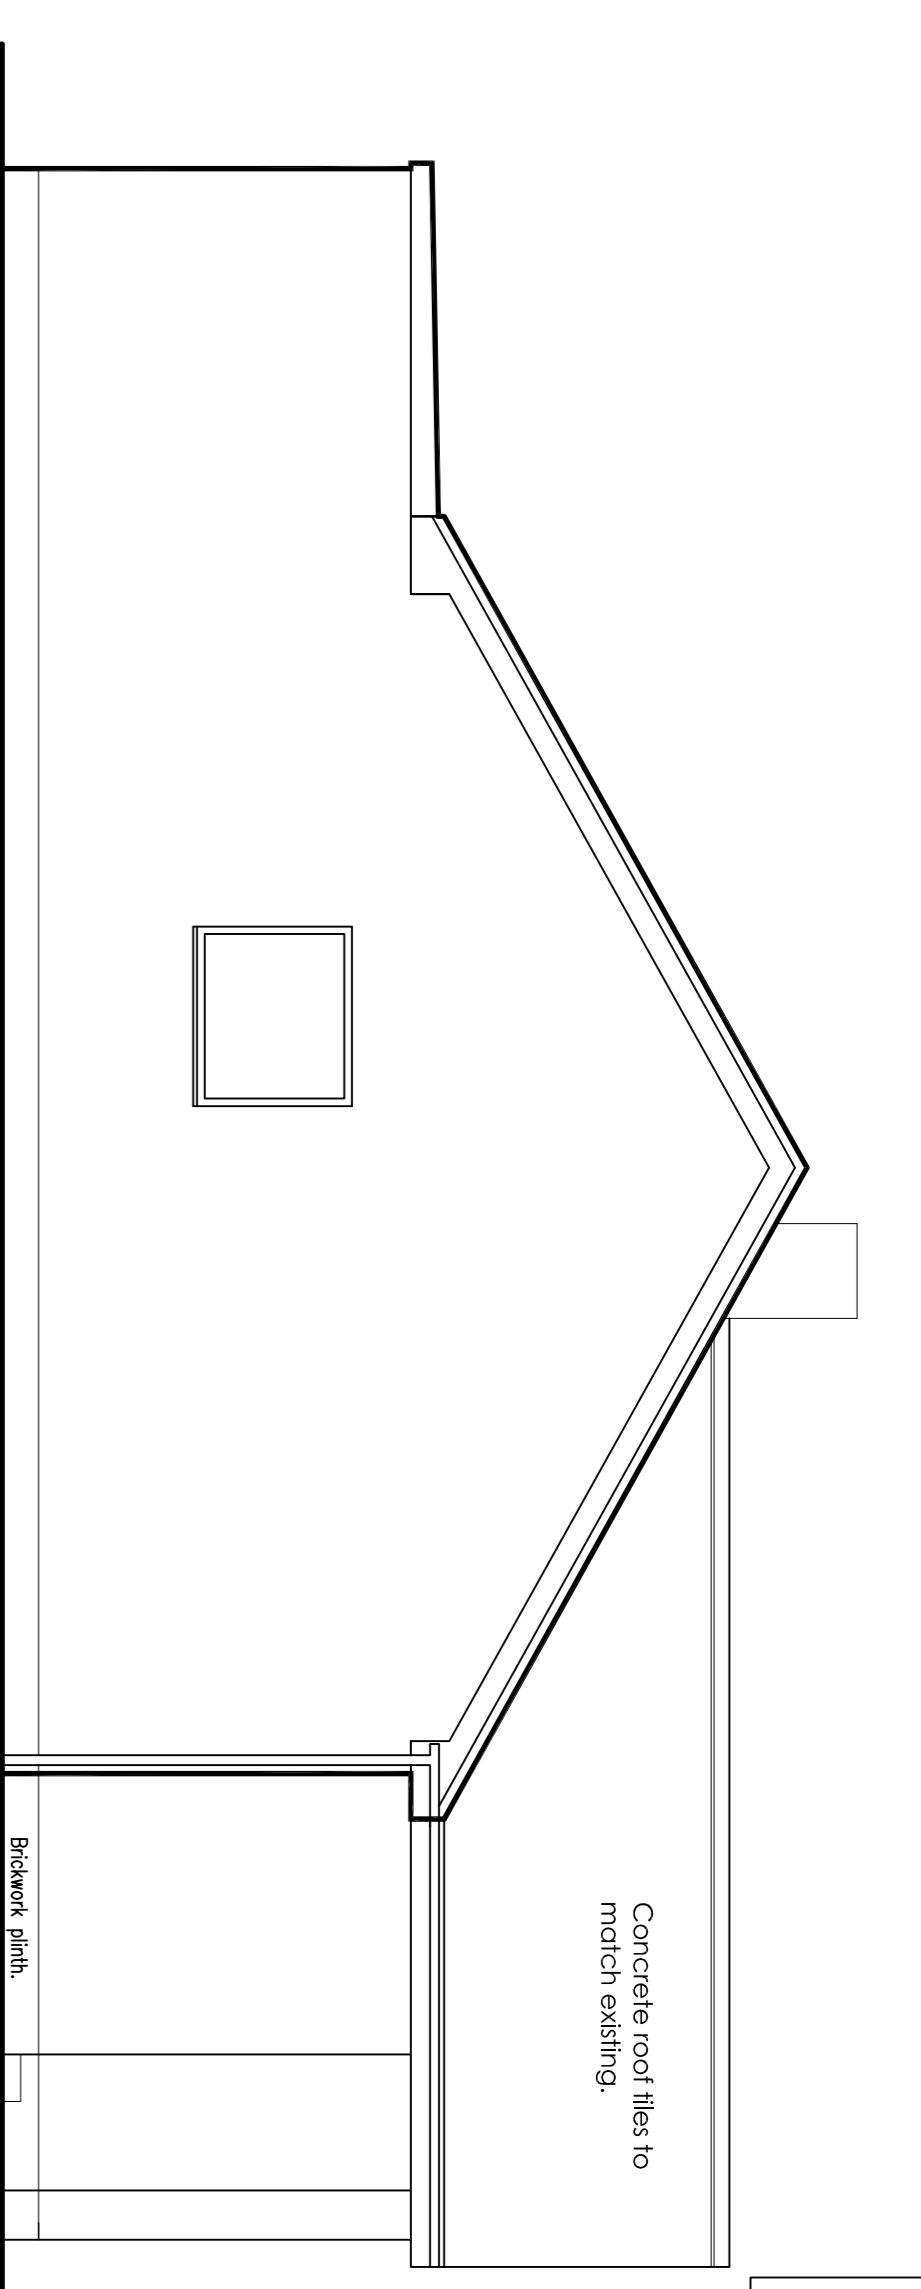


Proposed Side Elevation

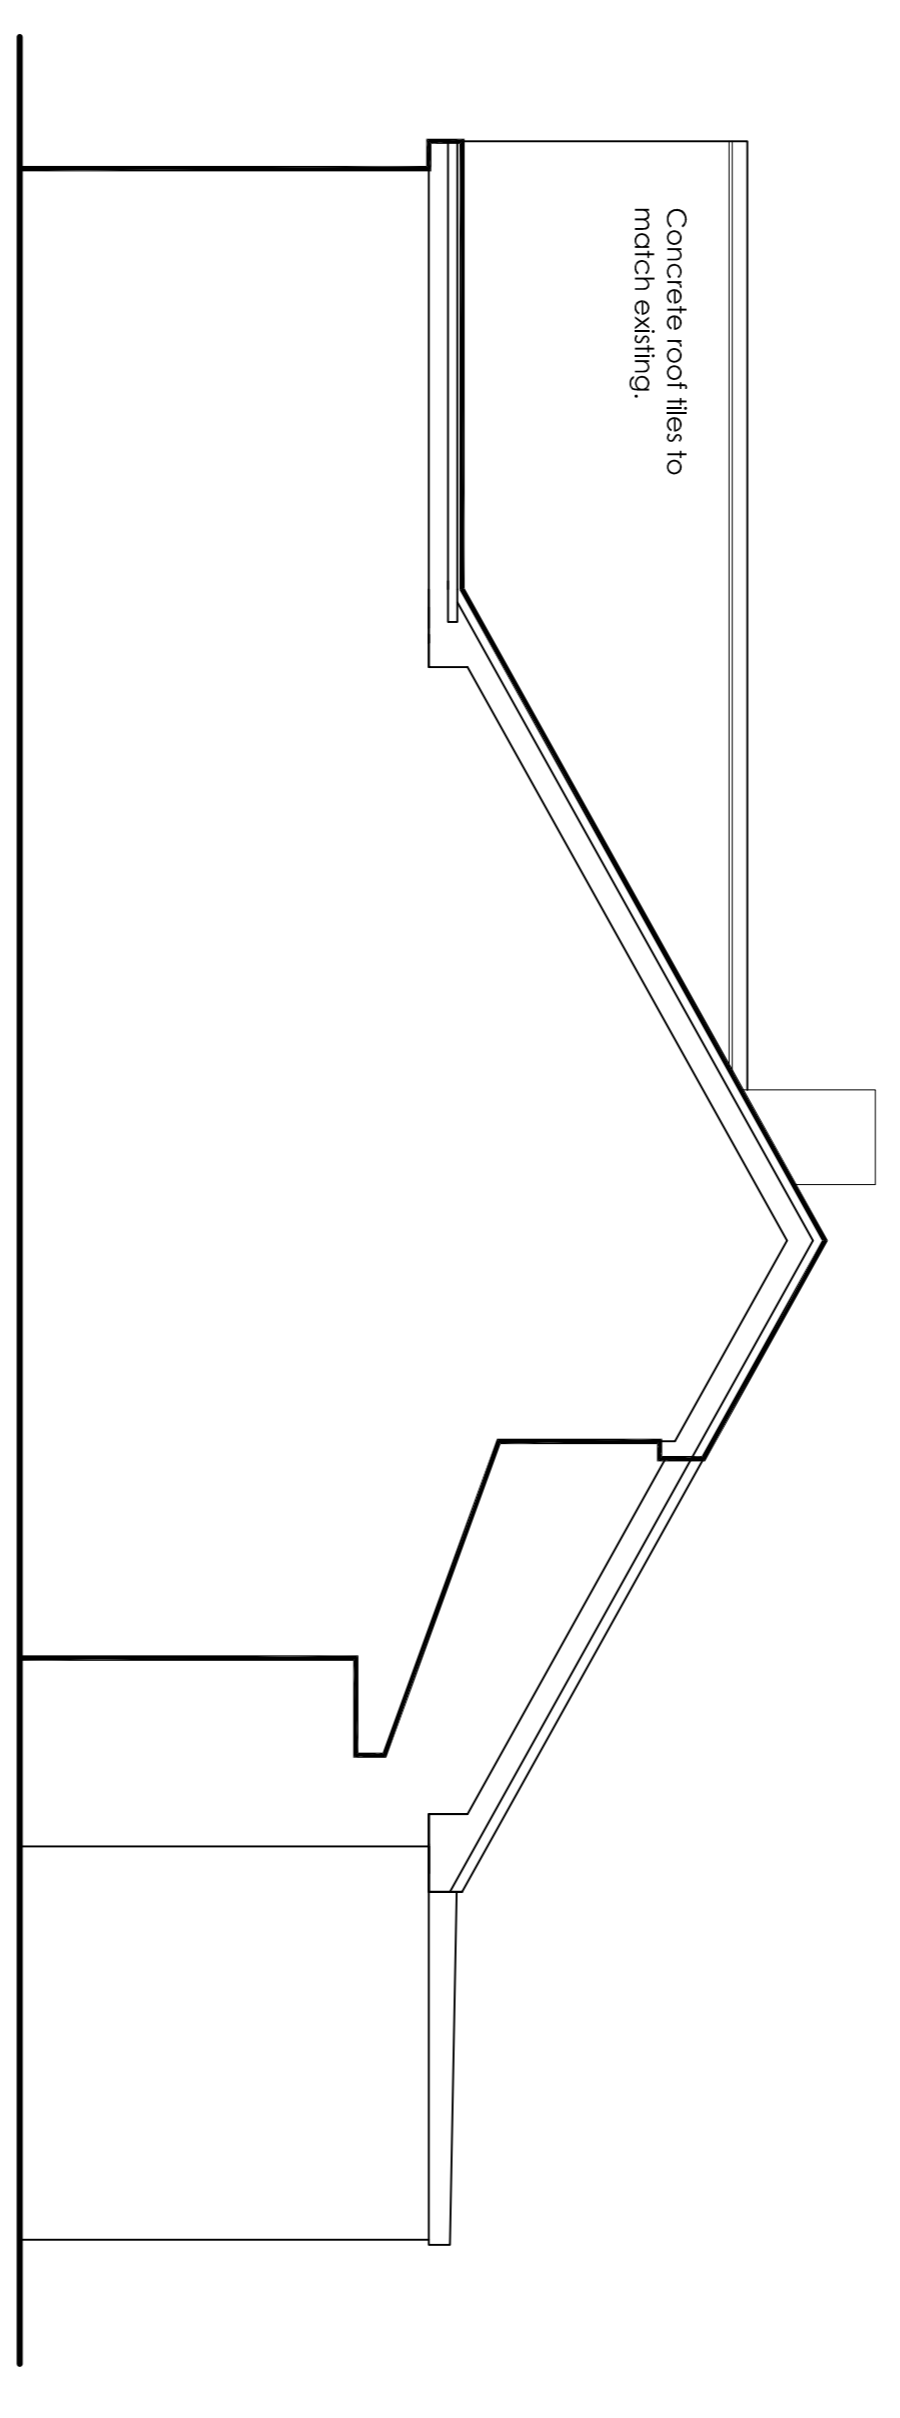

Proposed Side Elevation

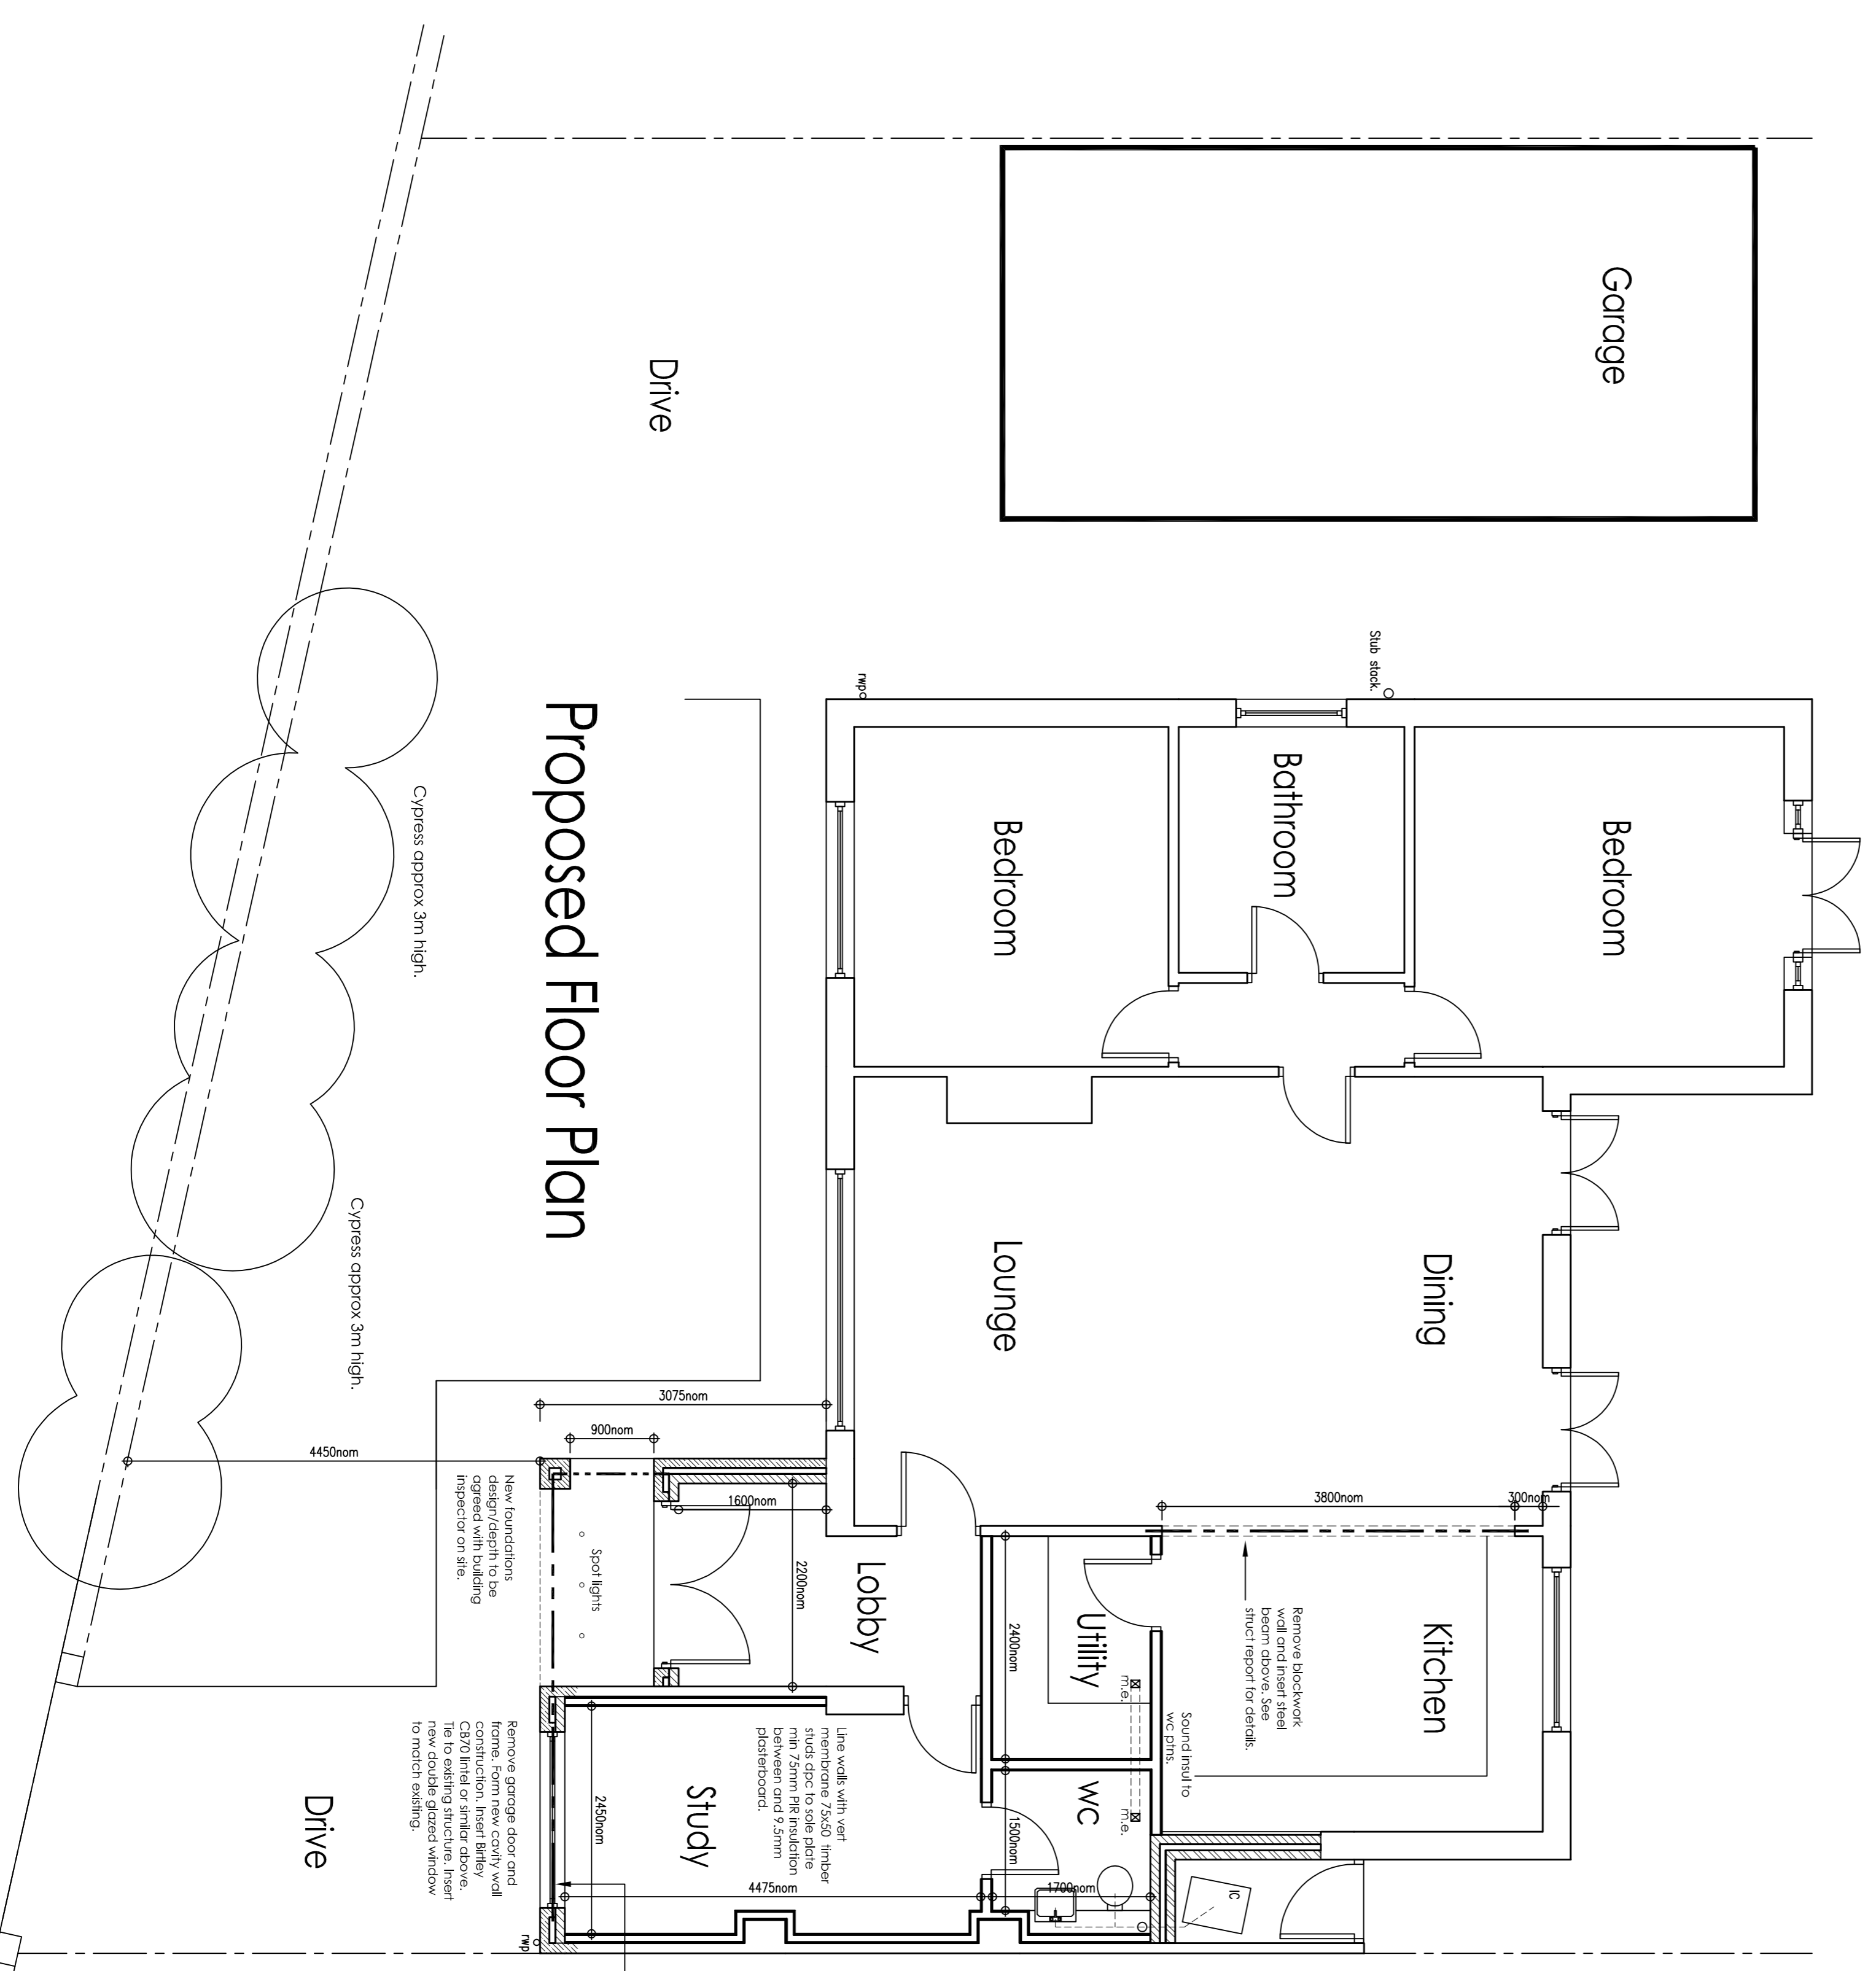

Proposed Floor Plan

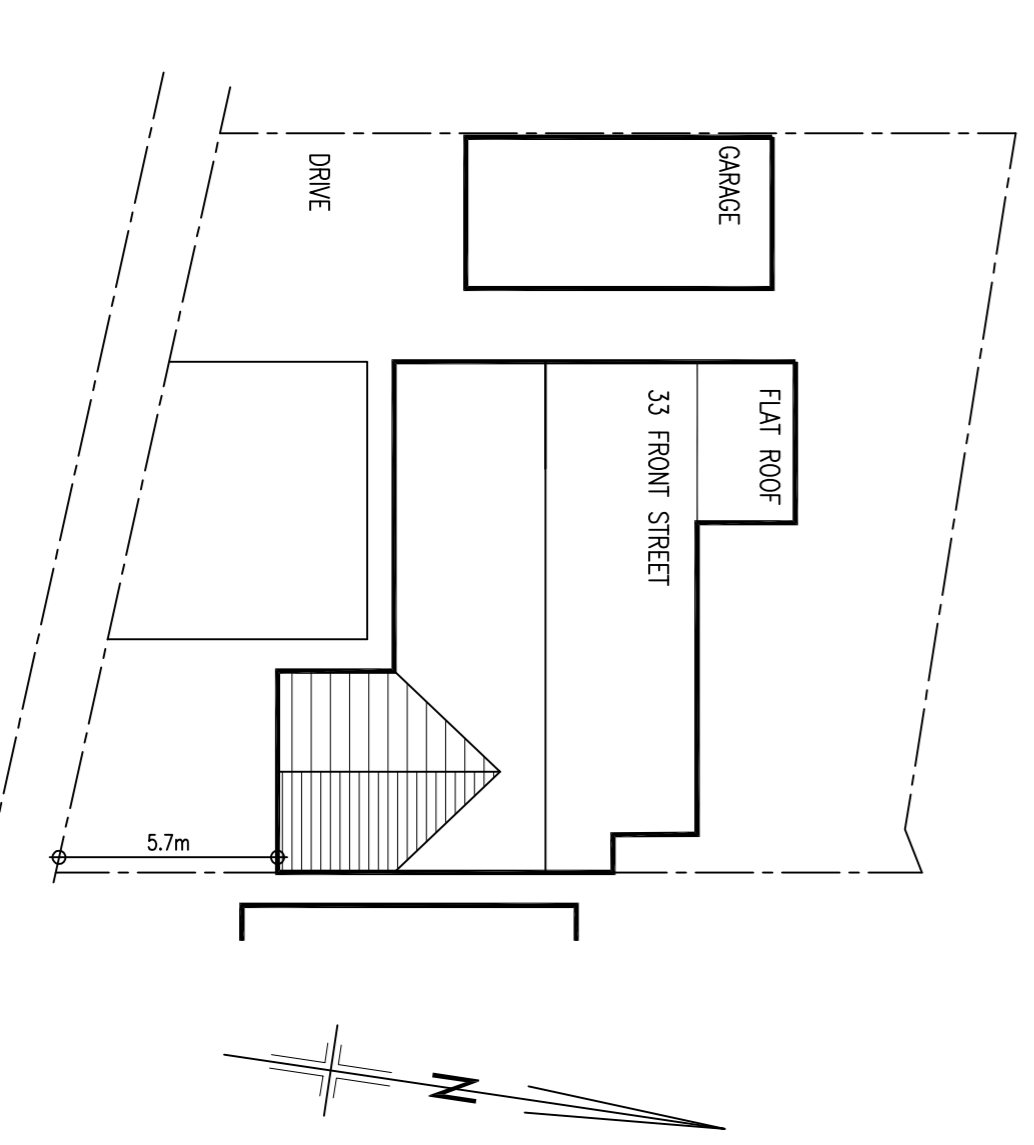

Proposed Site/Roof Plan

DO NOT SCALE FROM THIS DRAWING
 THE ELECTRICAL LAYOUT IS FOR INDICATION PURPOSES ONLY.
 INSPECT SITE, TREES ETC./WORKS BEFORE COMMENCEMENT. REPORT ANY DISCREPANCIES IMMEDIATELY.
 ALL SITE DIMENSIONS SHALL BE VERIFIED BY THE CONTRACTOR ON SITE PRIOR TO COMMENCING WORKS
 ALL DRAINAGE RUNS SHOWN ARE ASSUMED. THE CONTRACTOR IS TO CHECK LAYOUT PRIOR TO BUILD.

NMS
 Building Design
 Proposed Alterations
 33 Front Street
 Preston Grange
 NE29 9LF
 Mob: 07534 416 370

DATE	SCALE	DWG NO.
APRIL 2022	(A1)1:50; 1:200	22-632-02

This drawing must not, without permission of the designer, be published, copied, reproduced, manufactured or exploited in any other unauthorised way.