






EXISTING FRONT ELEVATION  
(scale 1:100)

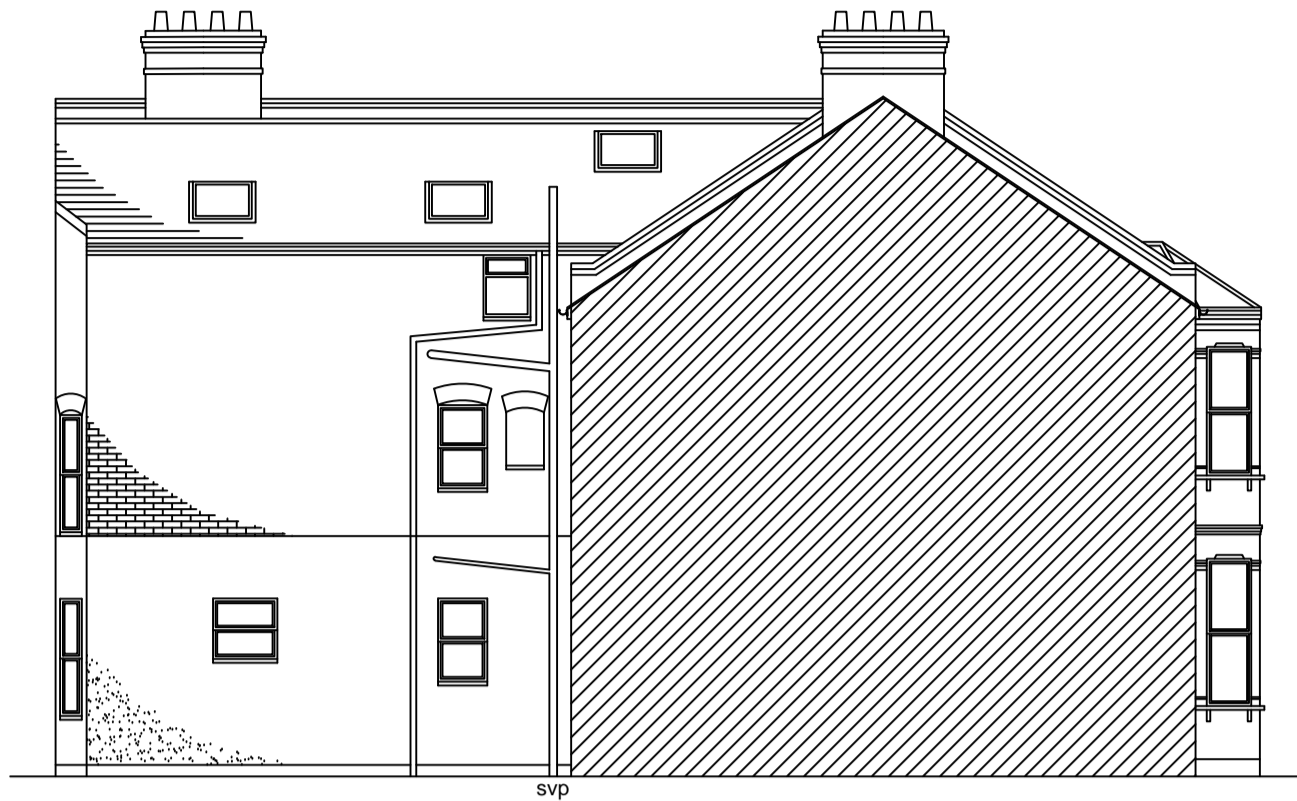


EXISTING SIDE ELEVATION  
(scale 1:100)

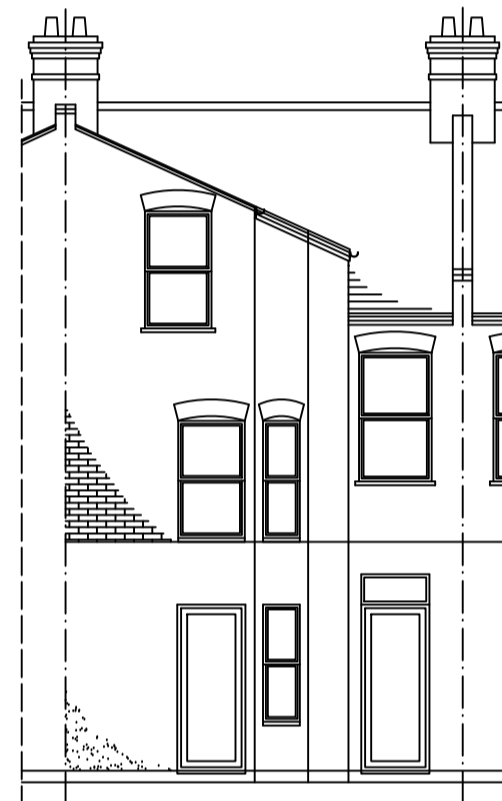


EXISTING REAR ELEVATION  
(scale 1:100)

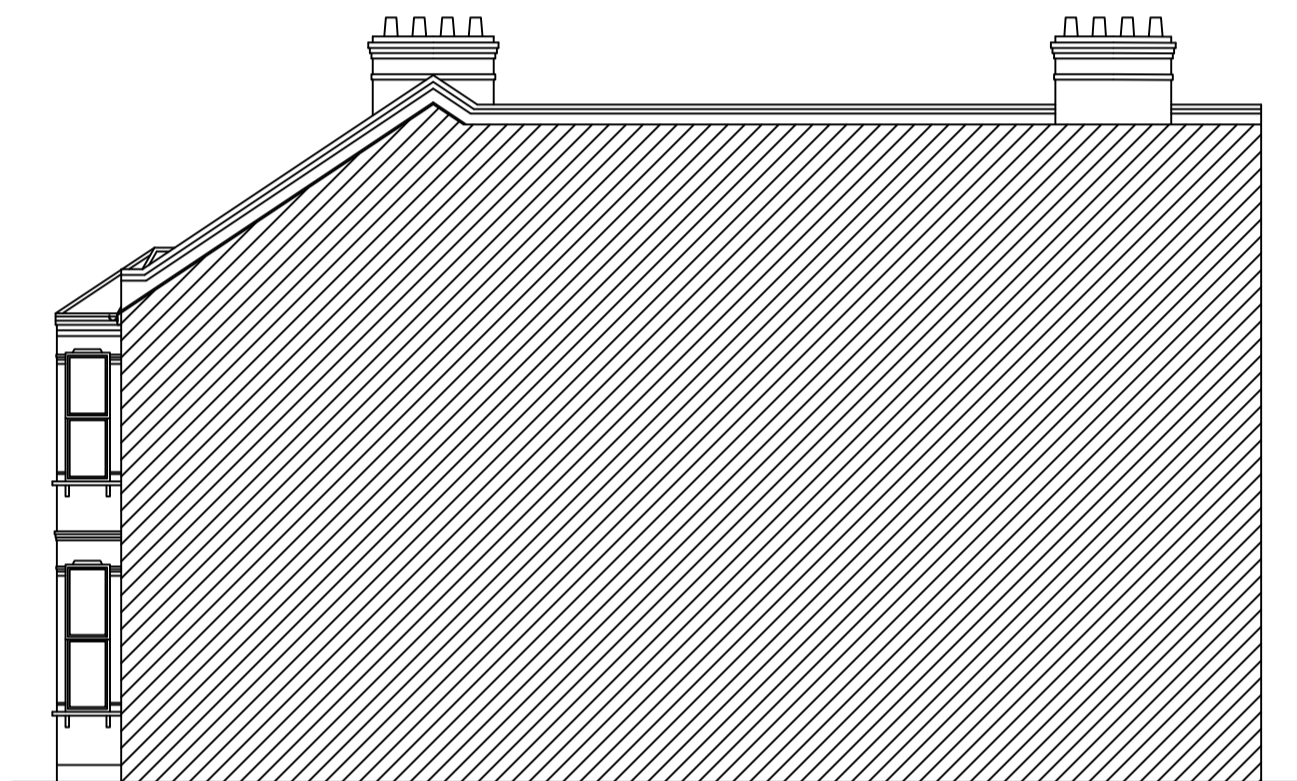


EXISTING ADJ. SIDE ELEVATION  
(scale 1:100)

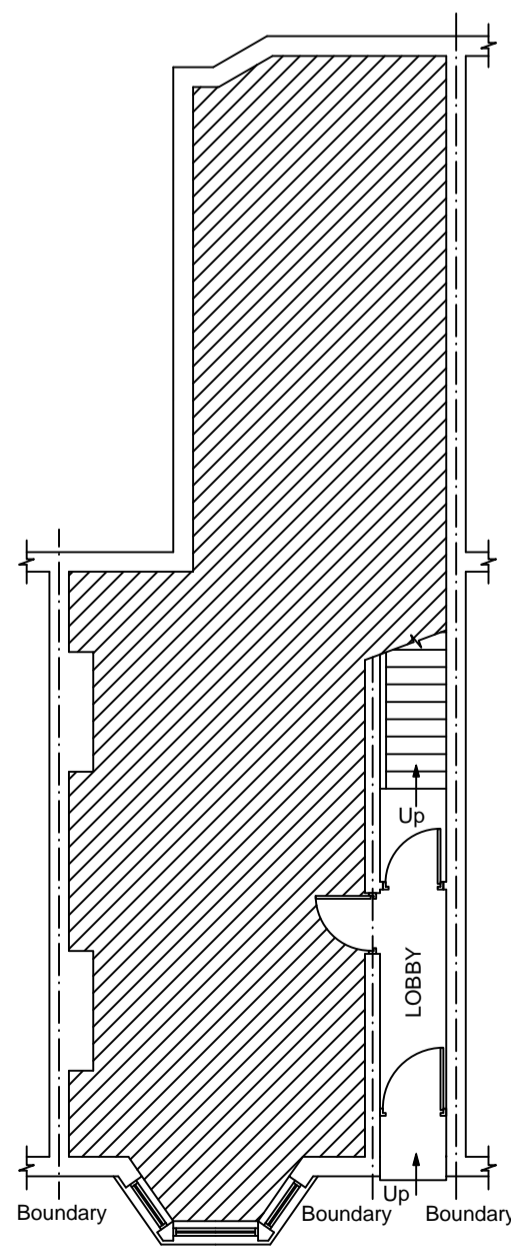


EXISTING GROUND FLOOR PLAN  
(scale 1:100)

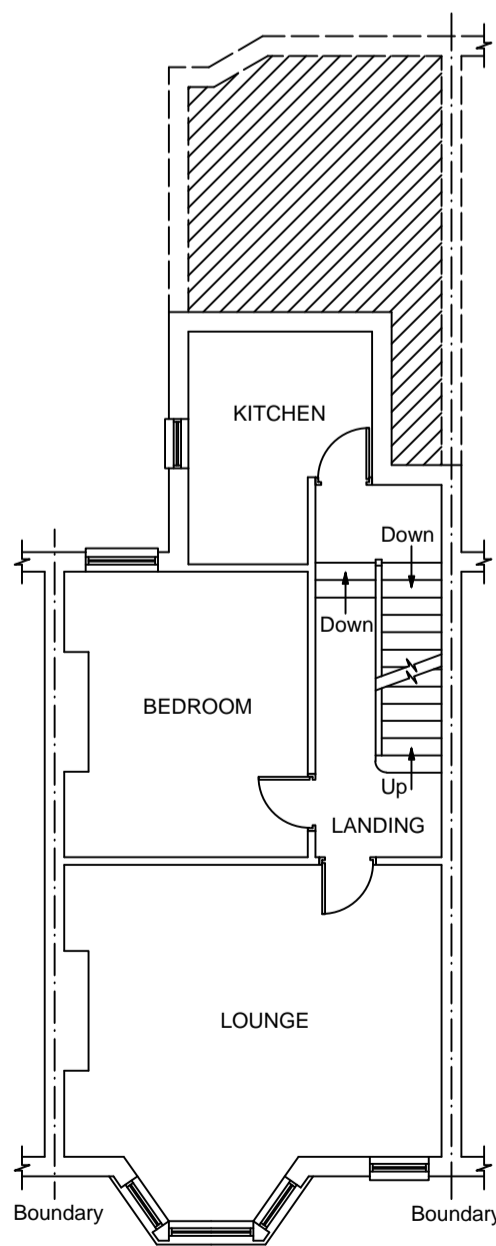


EXISTING FIRST FLOOR PLAN  
(scale 1:100)

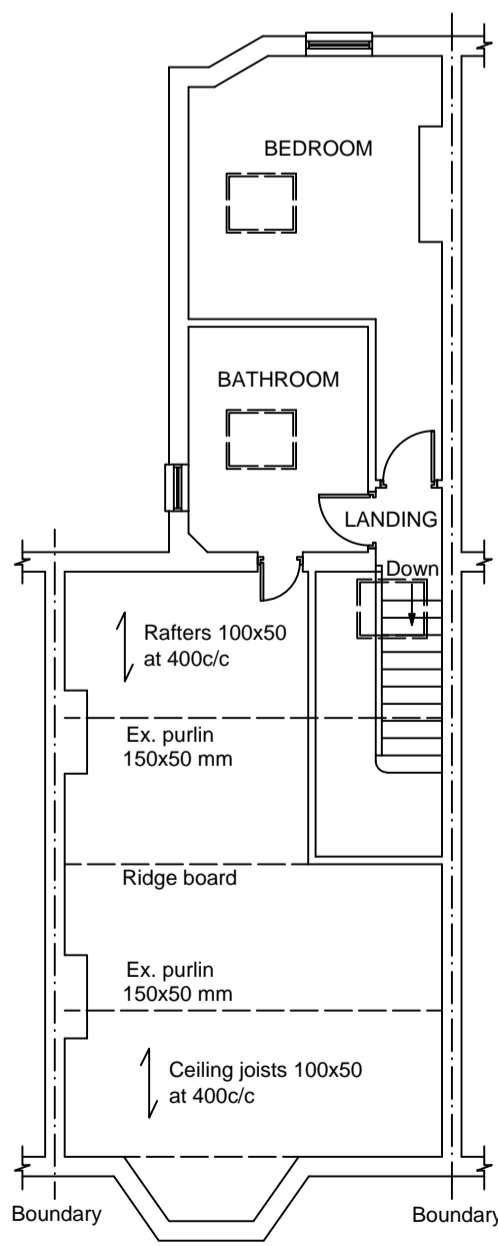

EXISTING SECOND / ATTIC FLOOR PLAN  
(scale 1:100)

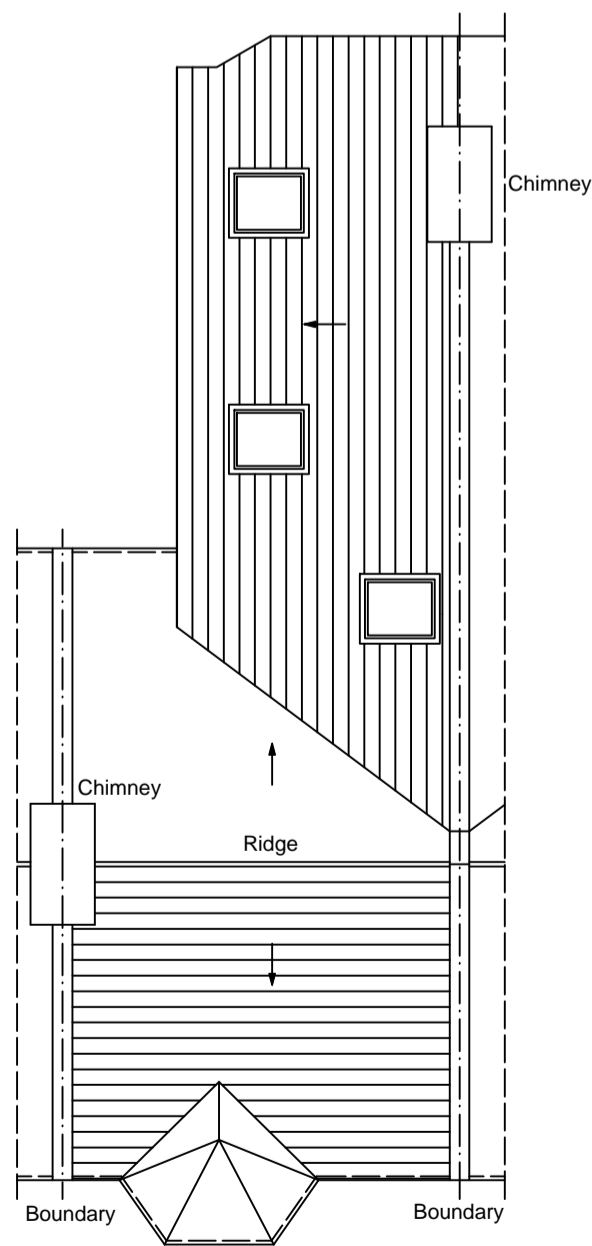


EXISTING ROOF PLAN  
(scale 1:100)

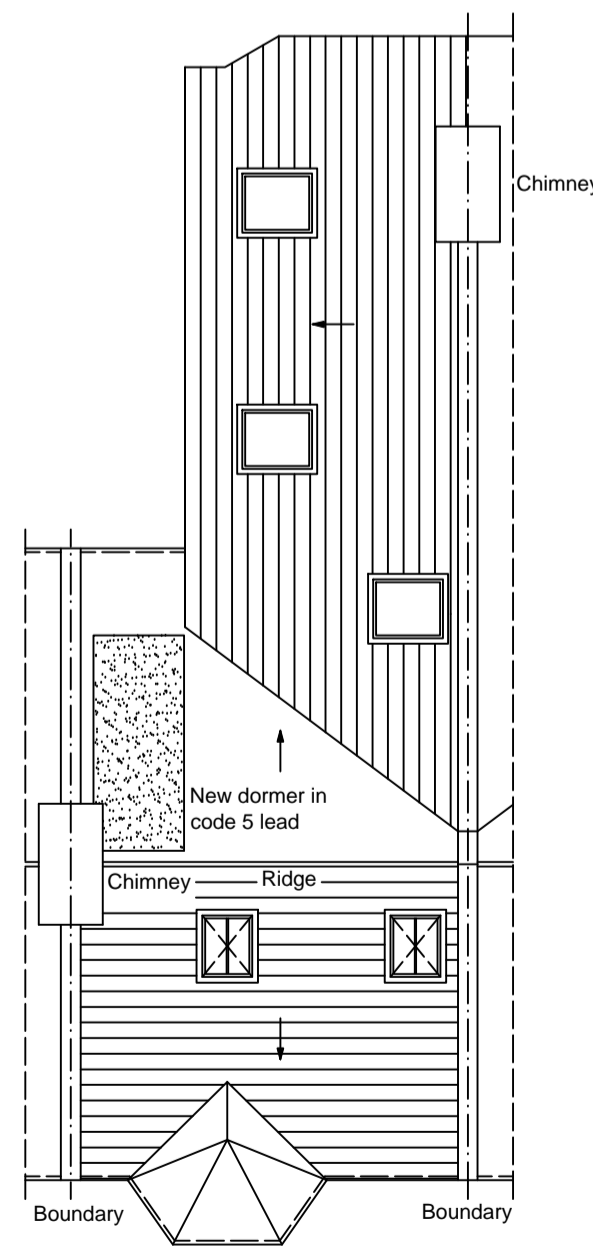

PROPOSED ROOF PLAN  
(scale 1:100)

THIS DRAWING IS © SOUTH LONDON LOFTS.  
DO NOT SCALE FROM THIS DRAWING. ANY  
ERROR TO BE REPORTED BEFORE WORKS ARE  
CARRIED OUT. THESE DRAWINGS ARE NOT FOR  
CONSTRUCTION USE AND ALL DIMENSIONS ARE  
TO BE VERIFIED UNLESS STATED.

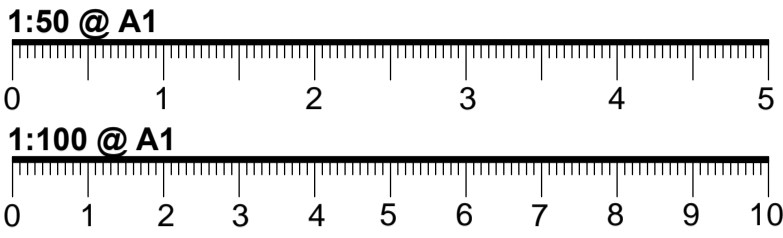

- NOTES:
- THESE DRAWINGS ARE FOR BUILDING ILLUSTRATION PURPOSES ONLY
  - (REFER TO BUILDING SPEC FOR FURTHER INFORMATION)
  - DIMENSIONS ARE TO BE CHECKED ON SITE PRIOR TO ANY CONSTRUCTION
  - REFER TO STRUCTURAL ENGINEER REPORT FOR STEEL WORKS, THESE DRAWINGS ARE FOR ILLUSTRATION PURPOSES ONLY
  - ELECTRICAL LAYOUT TO BE CONFIRMED BY CLIENT ON SITE WITH BUILDER
  - PLUMBING TO CONNECT TO EXISTING

- KEY:
- SITE BOUNDARY
  - - - DEMOLITION
  - DRAINAGE
  - LIGHT LAYOUT TBC

- KEY:
- DS MAINS CONNECTED SMOKE DETECTOR
  - HD MAINS CONNECTED HEAT DETECTOR
  - ◇ (REFER TO BUILDING SPEC NOTES)
  - FFL+XXX FINISHED FLOOR LEVEL
  - FE/RL FIRE ESCAPE ROPE LOCATION
  - FR/ER FIRE ESCAPE ROUTE WINDOW
  - FD-30 FIRE RATED DOOR UP TO 30min
  - FS-30 FIRE RATED STUD WALL UP TO 30min
  - FR-30 FIRE RATED GLASS UP TO 30min



REVISION DATE/DRAWN



PROJECT 13 Holmewood Road

London

DRAWING TITLE PLANNING

EXISTING PLANS  
& ELEVATIONS

DATE JAN 22 SCALE @ A1

DRAWN MC CHECK SS

STATUS

JOB NUMBER

DRAWING NUMBER DR-A-01 REV E