




TYPICAL SECTION
(scale 1:50)

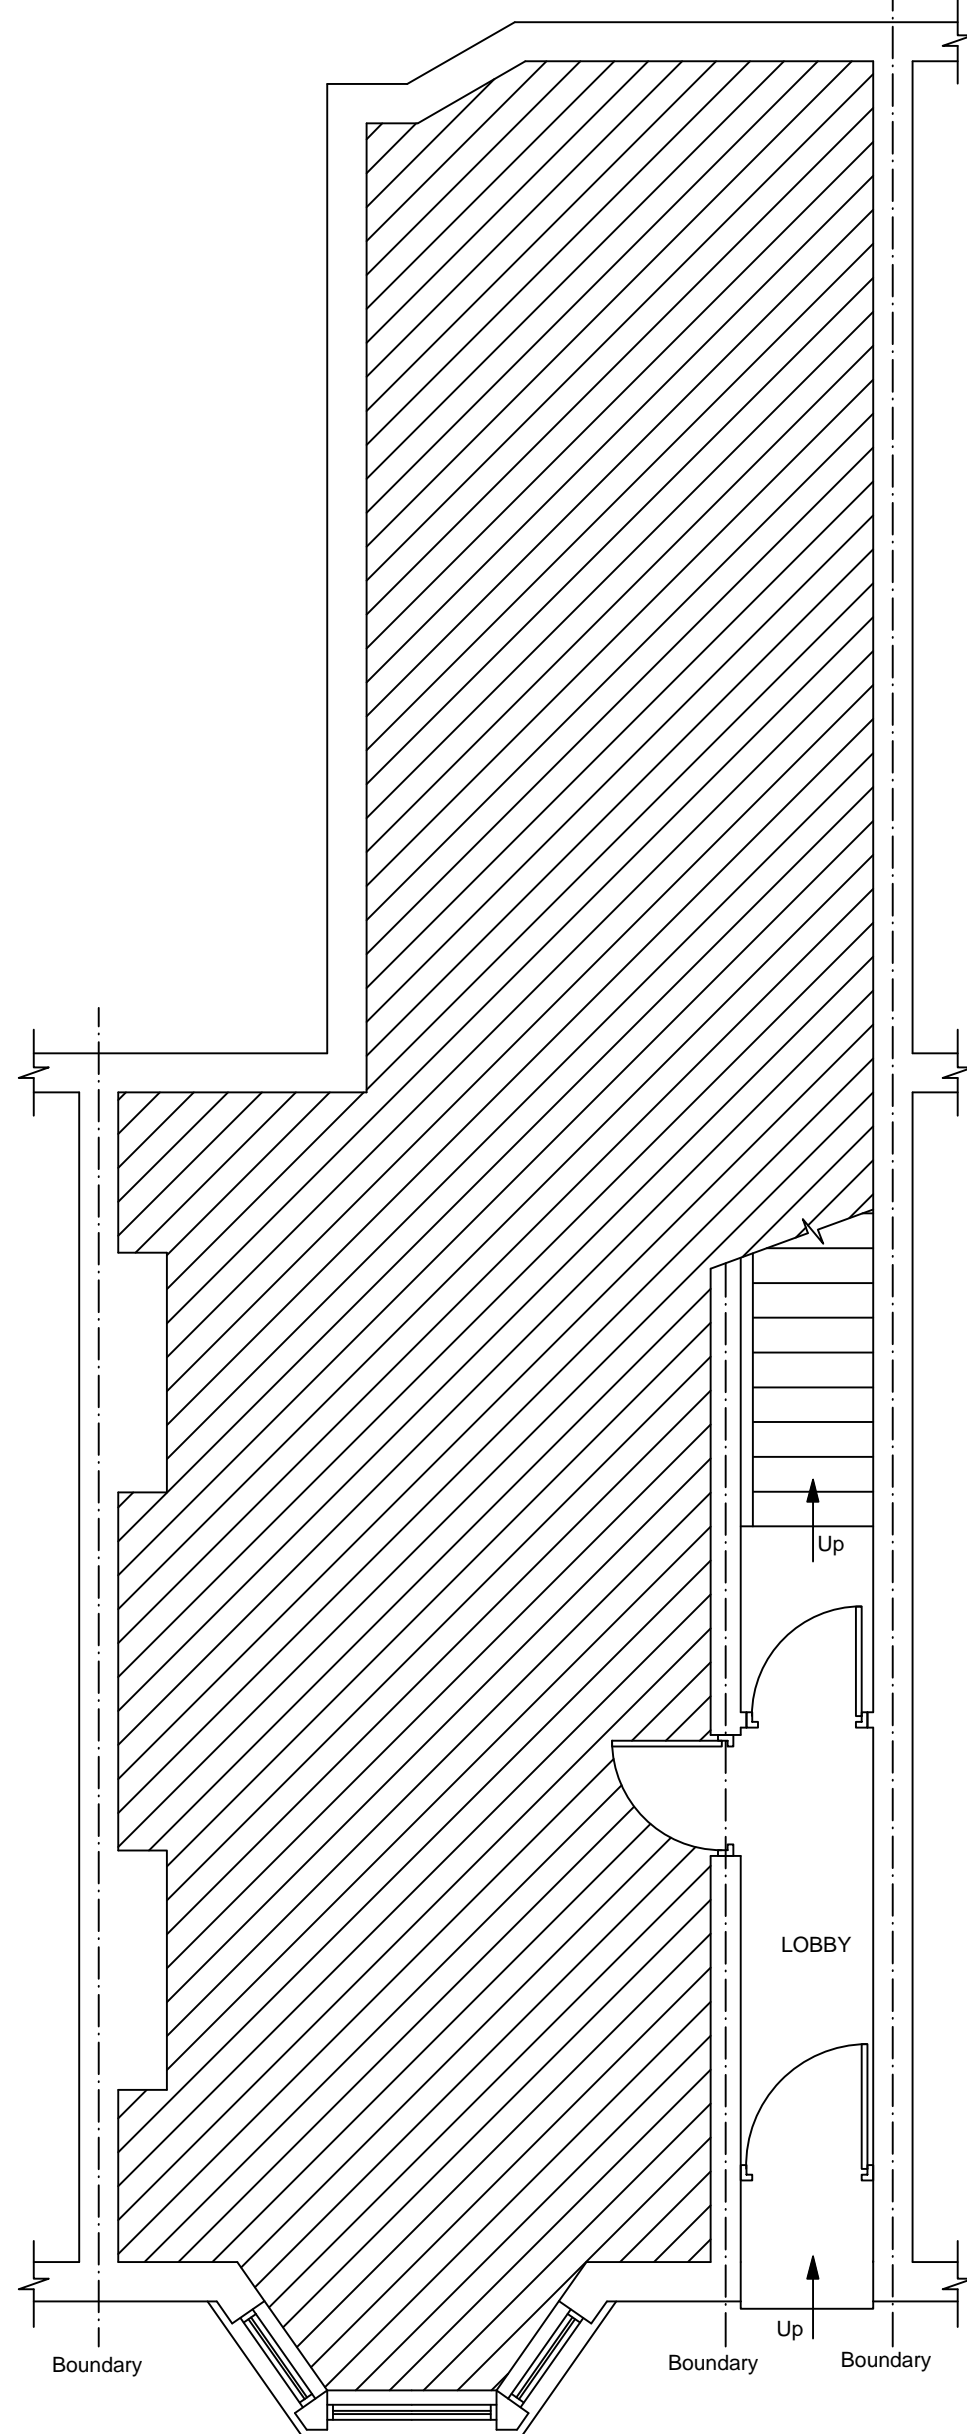

PROPOSED GROUND FLOOR PLAN
(scale 1:50)

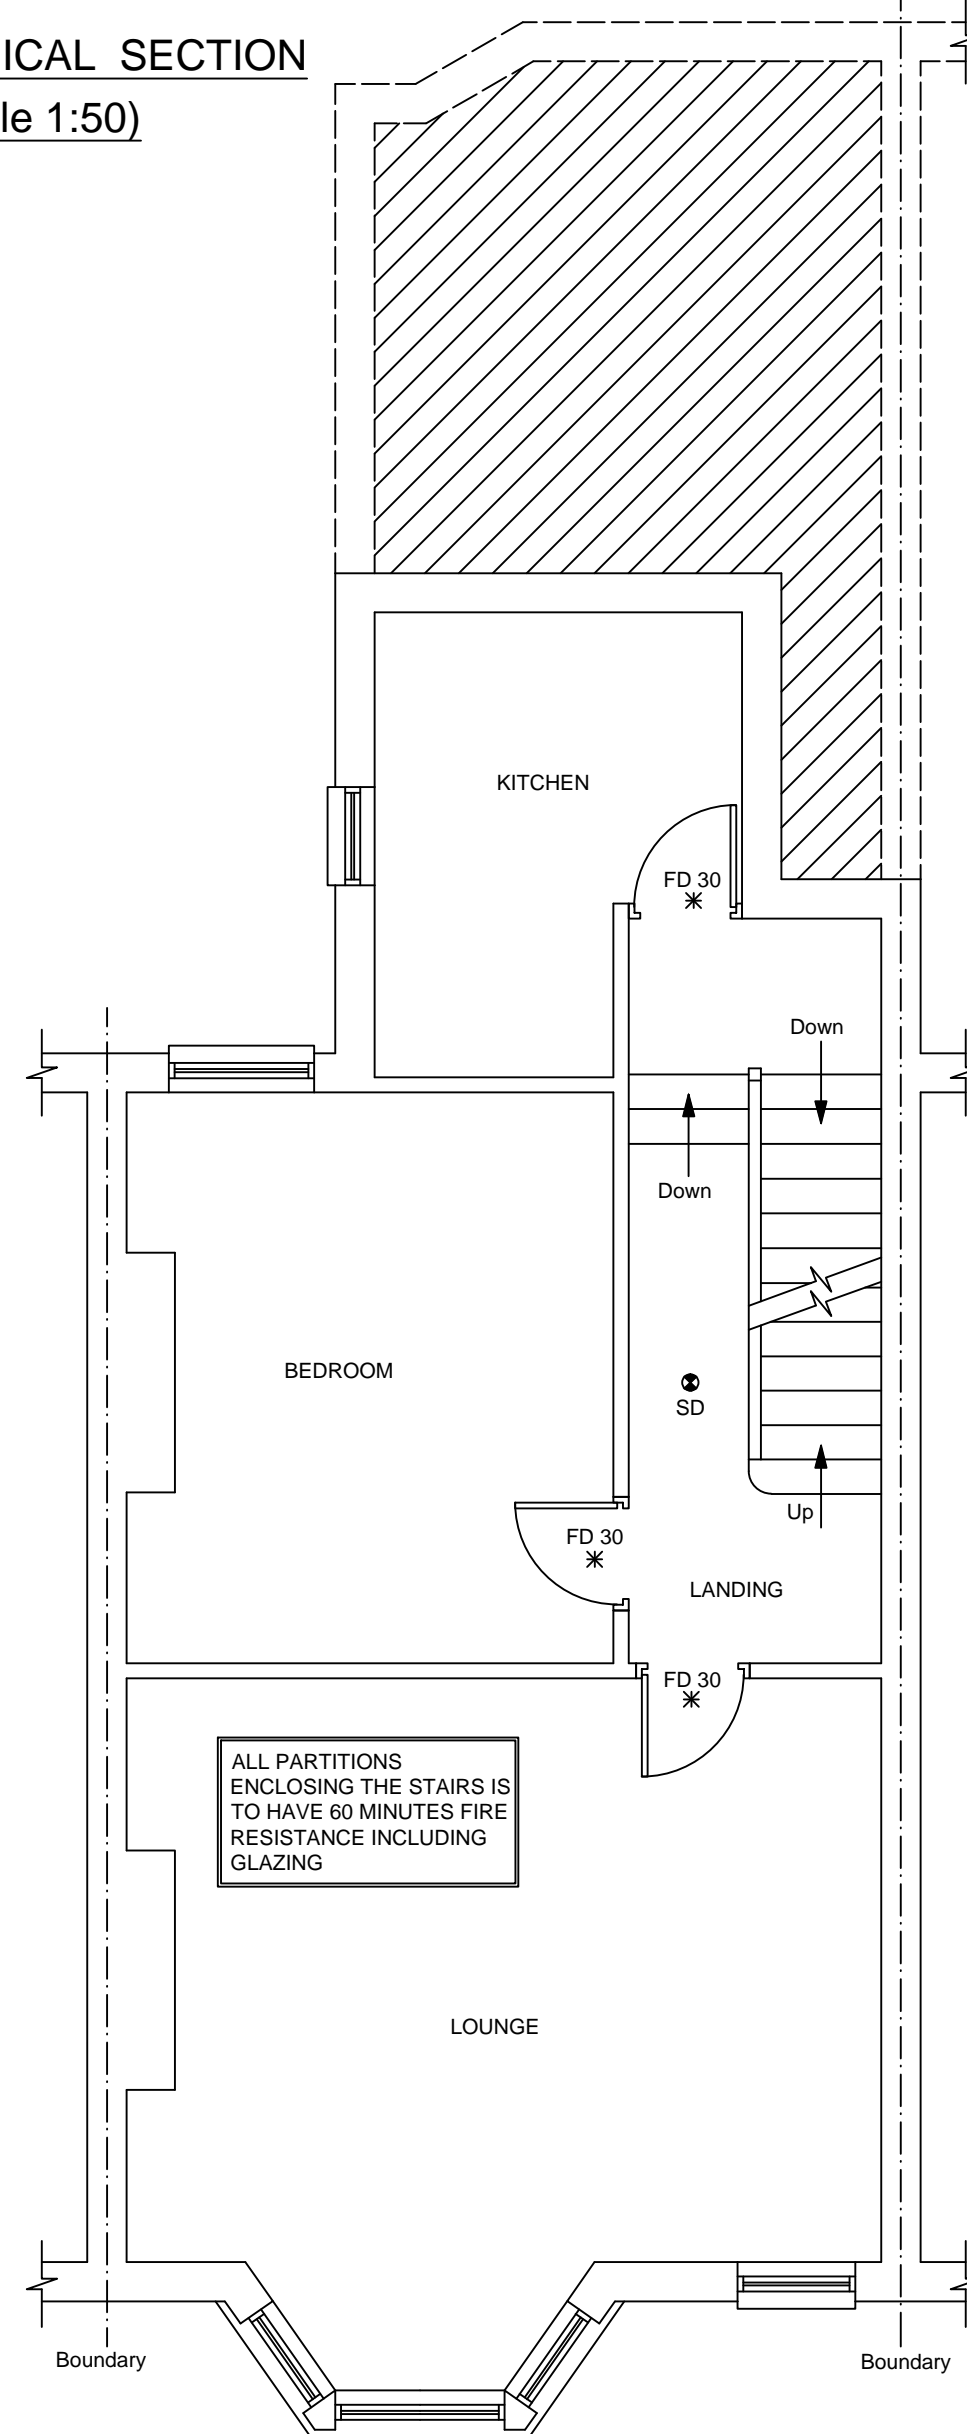


PROPOSED FIRST FLOOR PLAN
(scale 1:50)

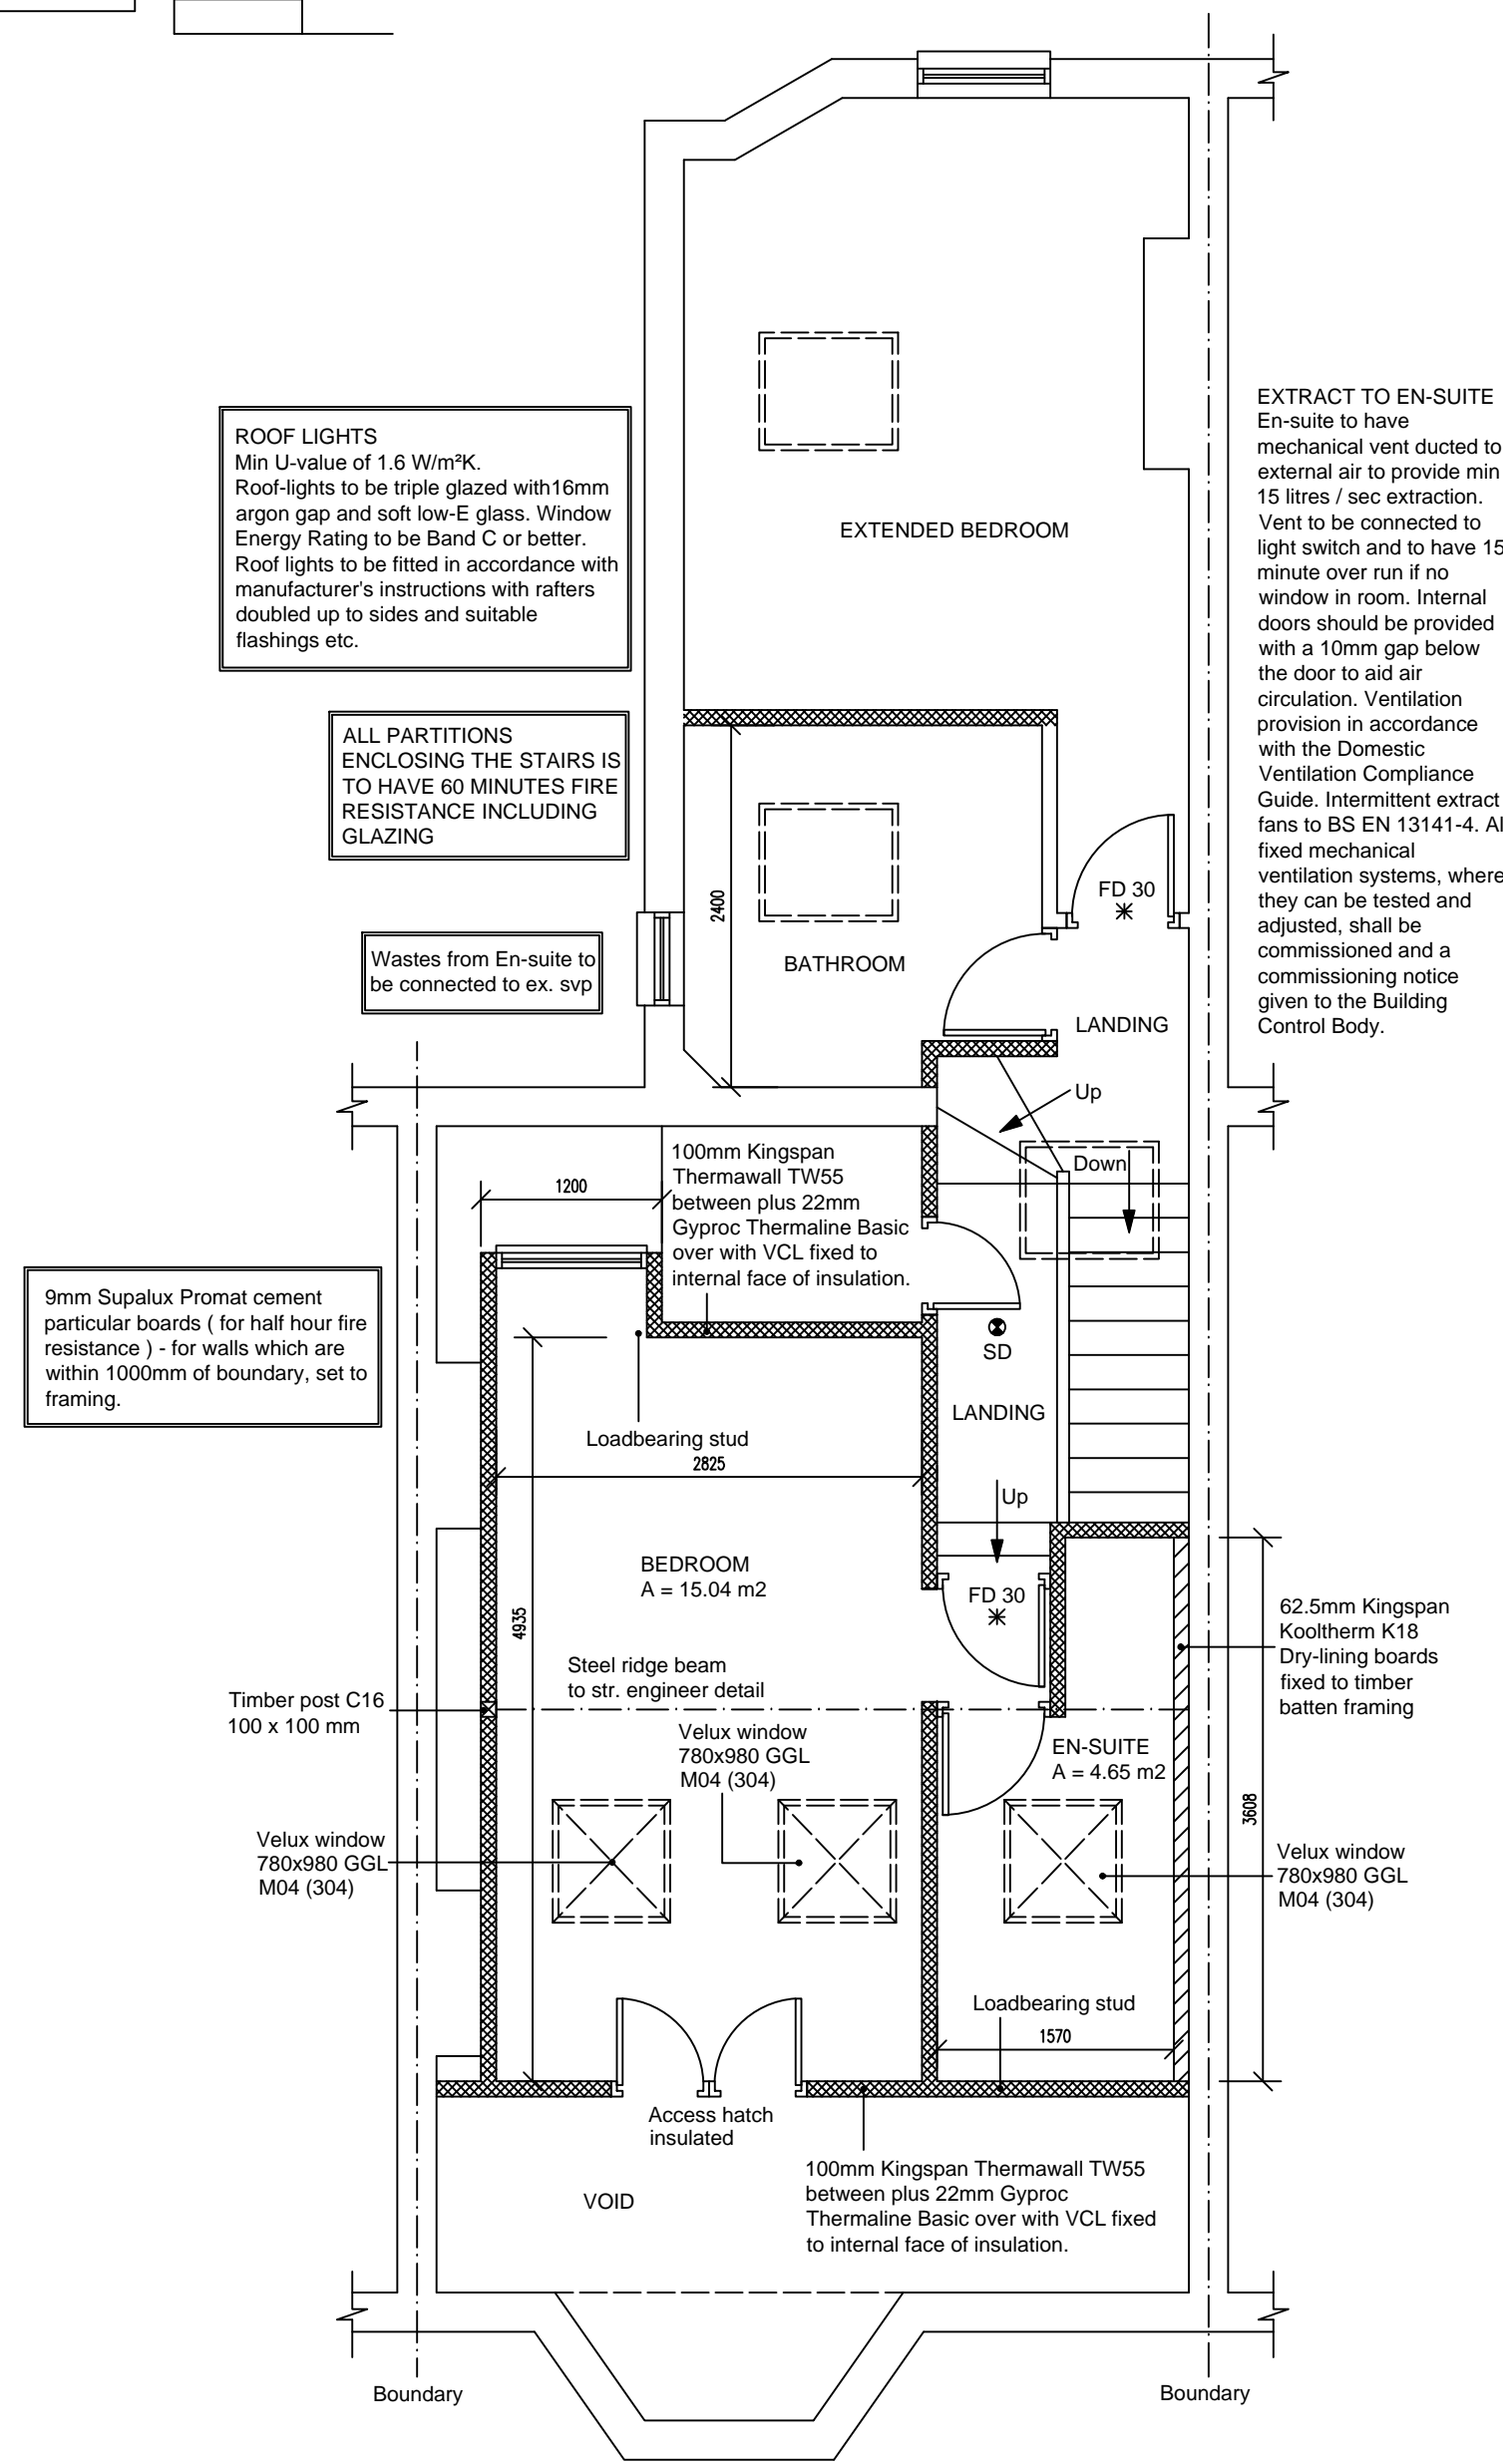

PROPOSED SECOND / ATTIC FLOOR PLAN
(scale 1:50)

THIS DRAWING IS © SOUTH LONDON LOFTS. DO NOT SCALE FROM THIS DRAWING. ANY ERROR TO BE REPORTED BEFORE WORKS ARE CARRIED OUT. THESE DRAWINGS ARE NOT FOR CONSTRUCTION USE AND ALL DIMENSIONS ARE TO BE VERIFIED UNLESS STATED.

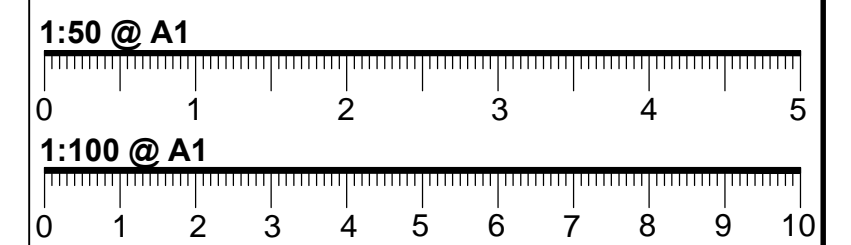

NOTES:


- THESE DRAWINGS ARE FOR BUILDING ILLUSTRATION PURPOSES ONLY
- (REFER TO BUILDING SPEC FOR FURTHER INFORMATION)
- DIMENSIONS ARE TO BE CHECKED ON SITE PRIOR TO ANY CONSTRUCTION
- REFER TO STRUCTURAL ENGINEER REPORT FOR STEEL WORKS, THESE DRAWINGS ARE FOR ILLUSTRATION PURPOSES ONLY
- ELECTRICAL LAYOUT TO BE CONFIRMED BY CLIENT ON SITE WITH BUILDER
- PLUMBING TO CONNECT TO EXISTING

KEY:

- SITE BOUNDARY
- - - DEMOLITION
- DRAINAGE
- LIGHT LAYOUT TBC

KEY:

 - DS MAINS CONNECTED SMOKE DETECTOR
- HD MAINS CONNECTED HEAT DETECTOR
- (REFER TO BUILDING SPEC NOTES)
- FFL+XXX FINISHED FLOOR LEVEL
- FE/RL FIRE ESCAPE ROPE LOCATION
- FR/ER FIRE ESCAPE ROUTE WINDOW
- FD-30 FIRE RATED DOOR UP TO 30min
- FS-30 FIRE RATED STUD WALL UP TO 30min
- FR-30 FIRE RATED GLASS UP TO 30min



REVISION

DATE/DRAWN



PROJECT 13 Holmewood Road

London

DRAWING TITLE PLANNING

PROPOSED PLANS

& SECTION

DATE JAN 22 SCALE @ A1

DRAWN MC CHECK SS

STATUS

JOB NUMBER

DRAWING NUMBER DR-A-03 REV B