




TYPICAL SECTION
(scale 1:50)

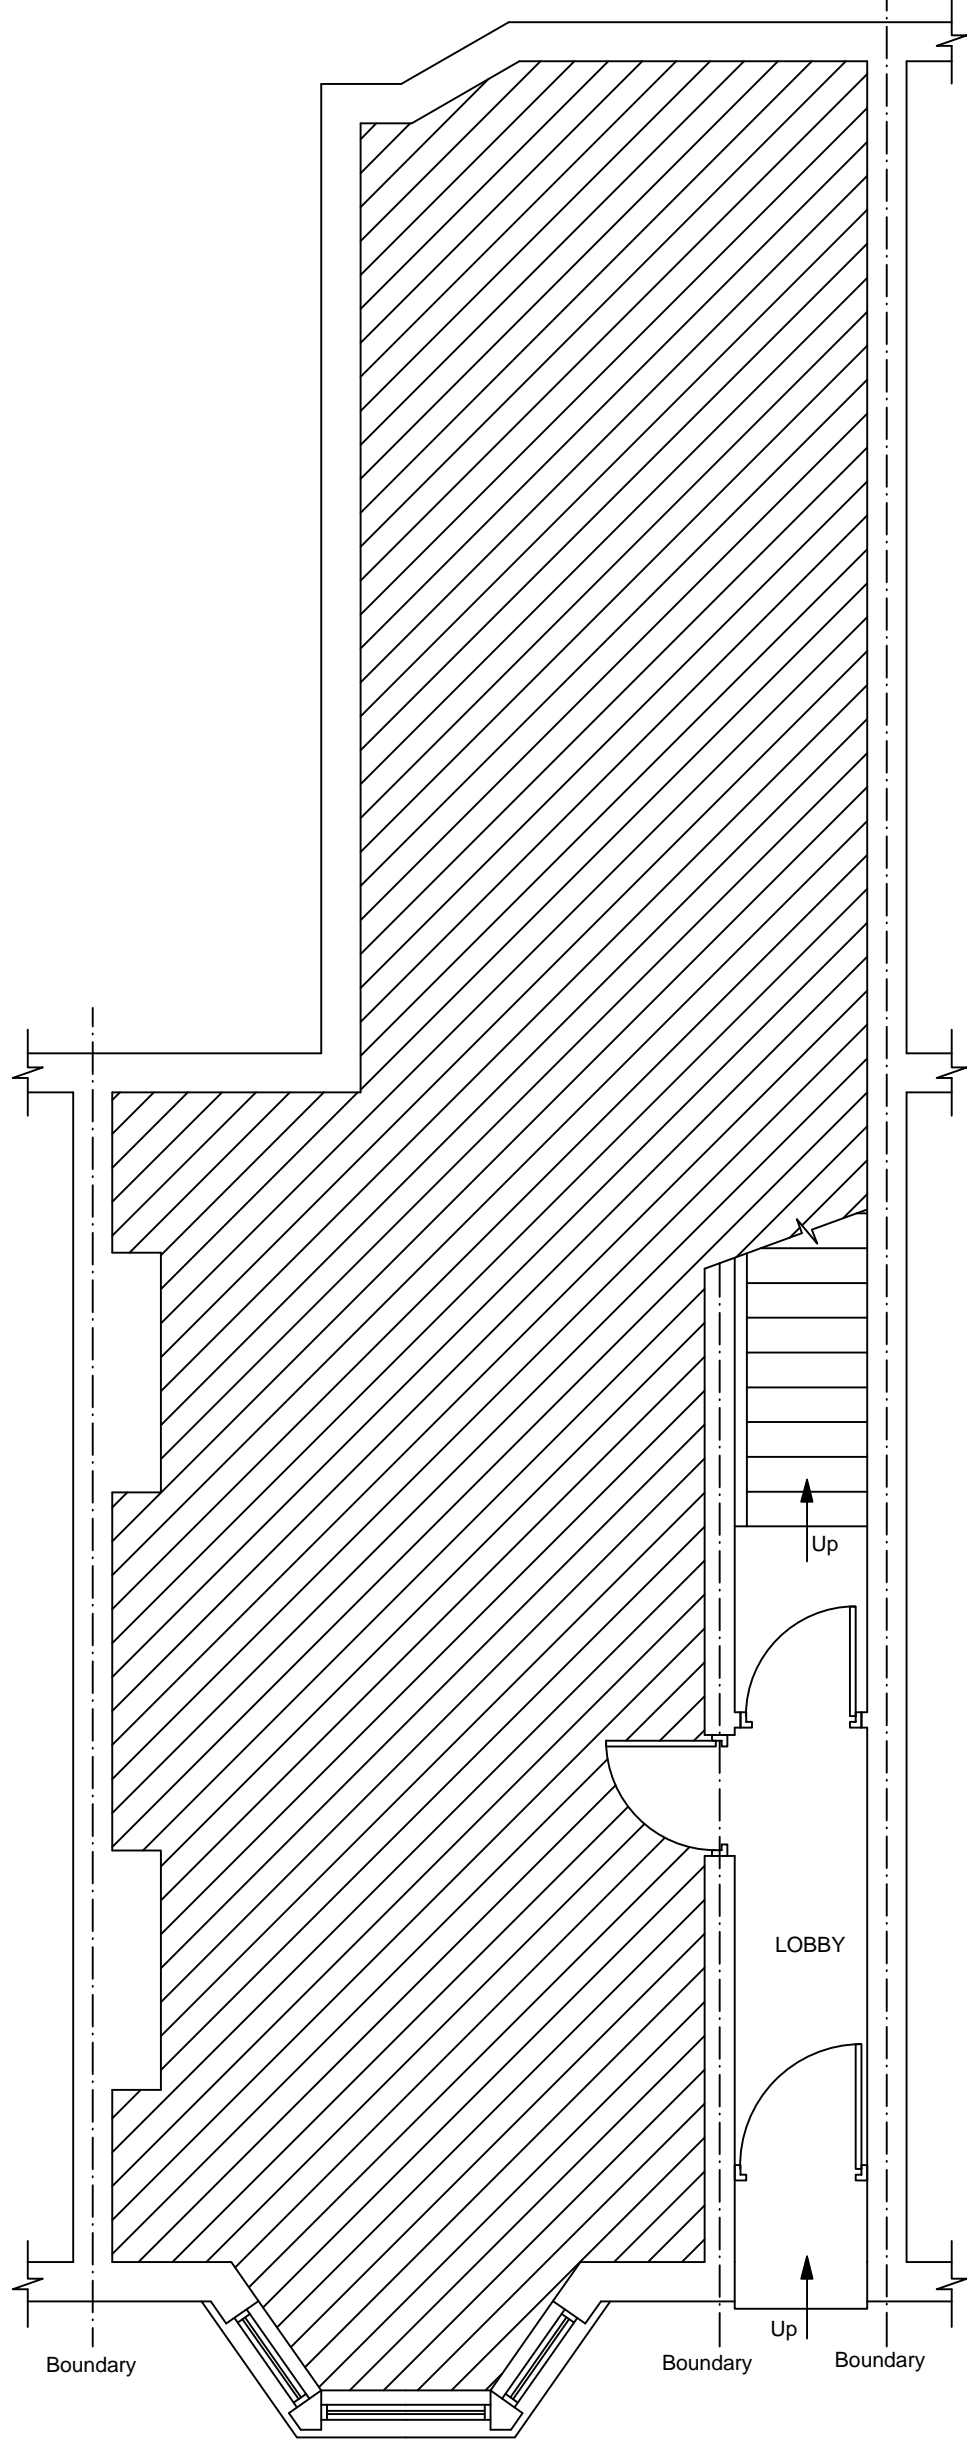

PROPOSED GROUND FLOOR PLAN
(scale 1:50)

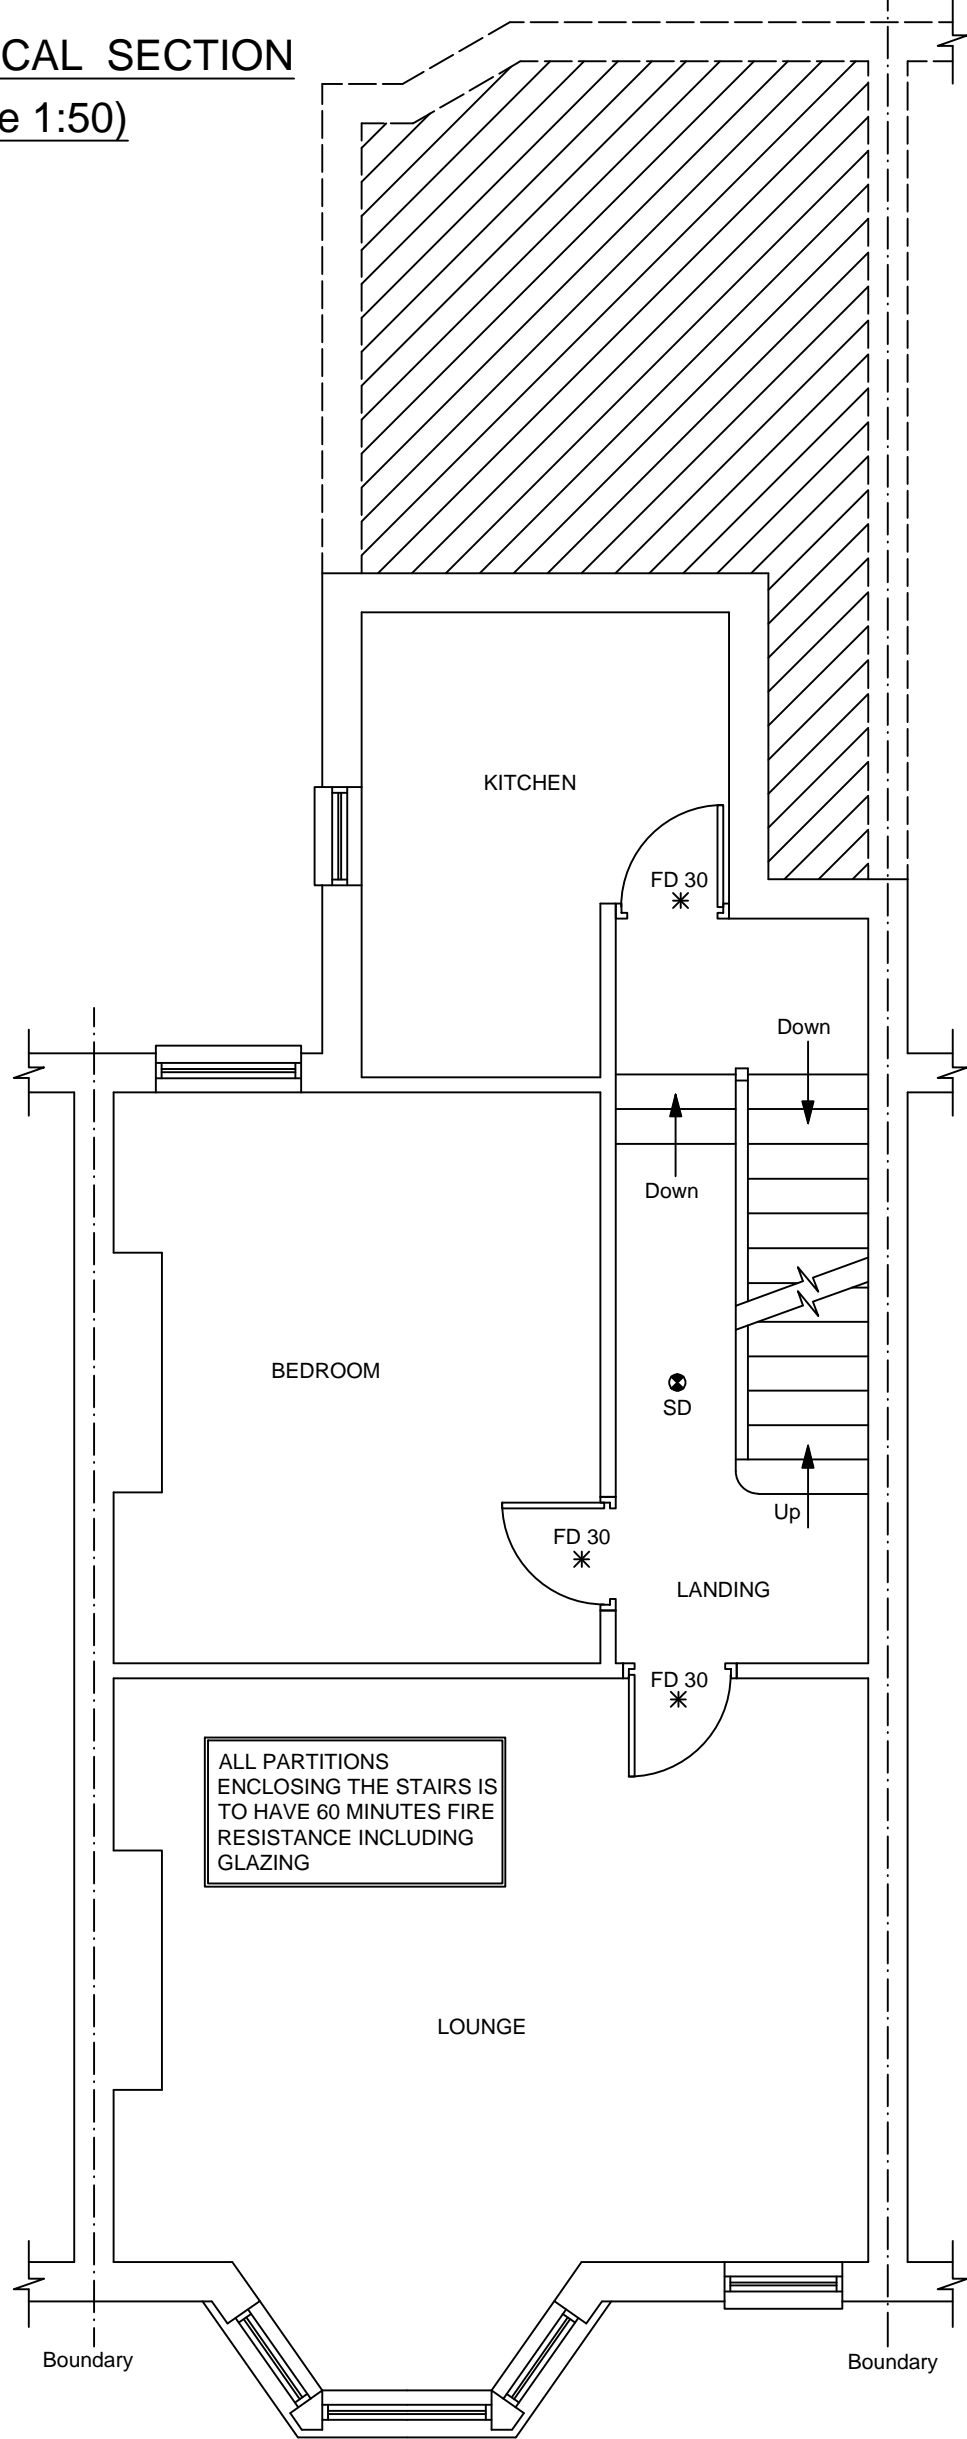


PROPOSED FIRST FLOOR PLAN
(scale 1:50)

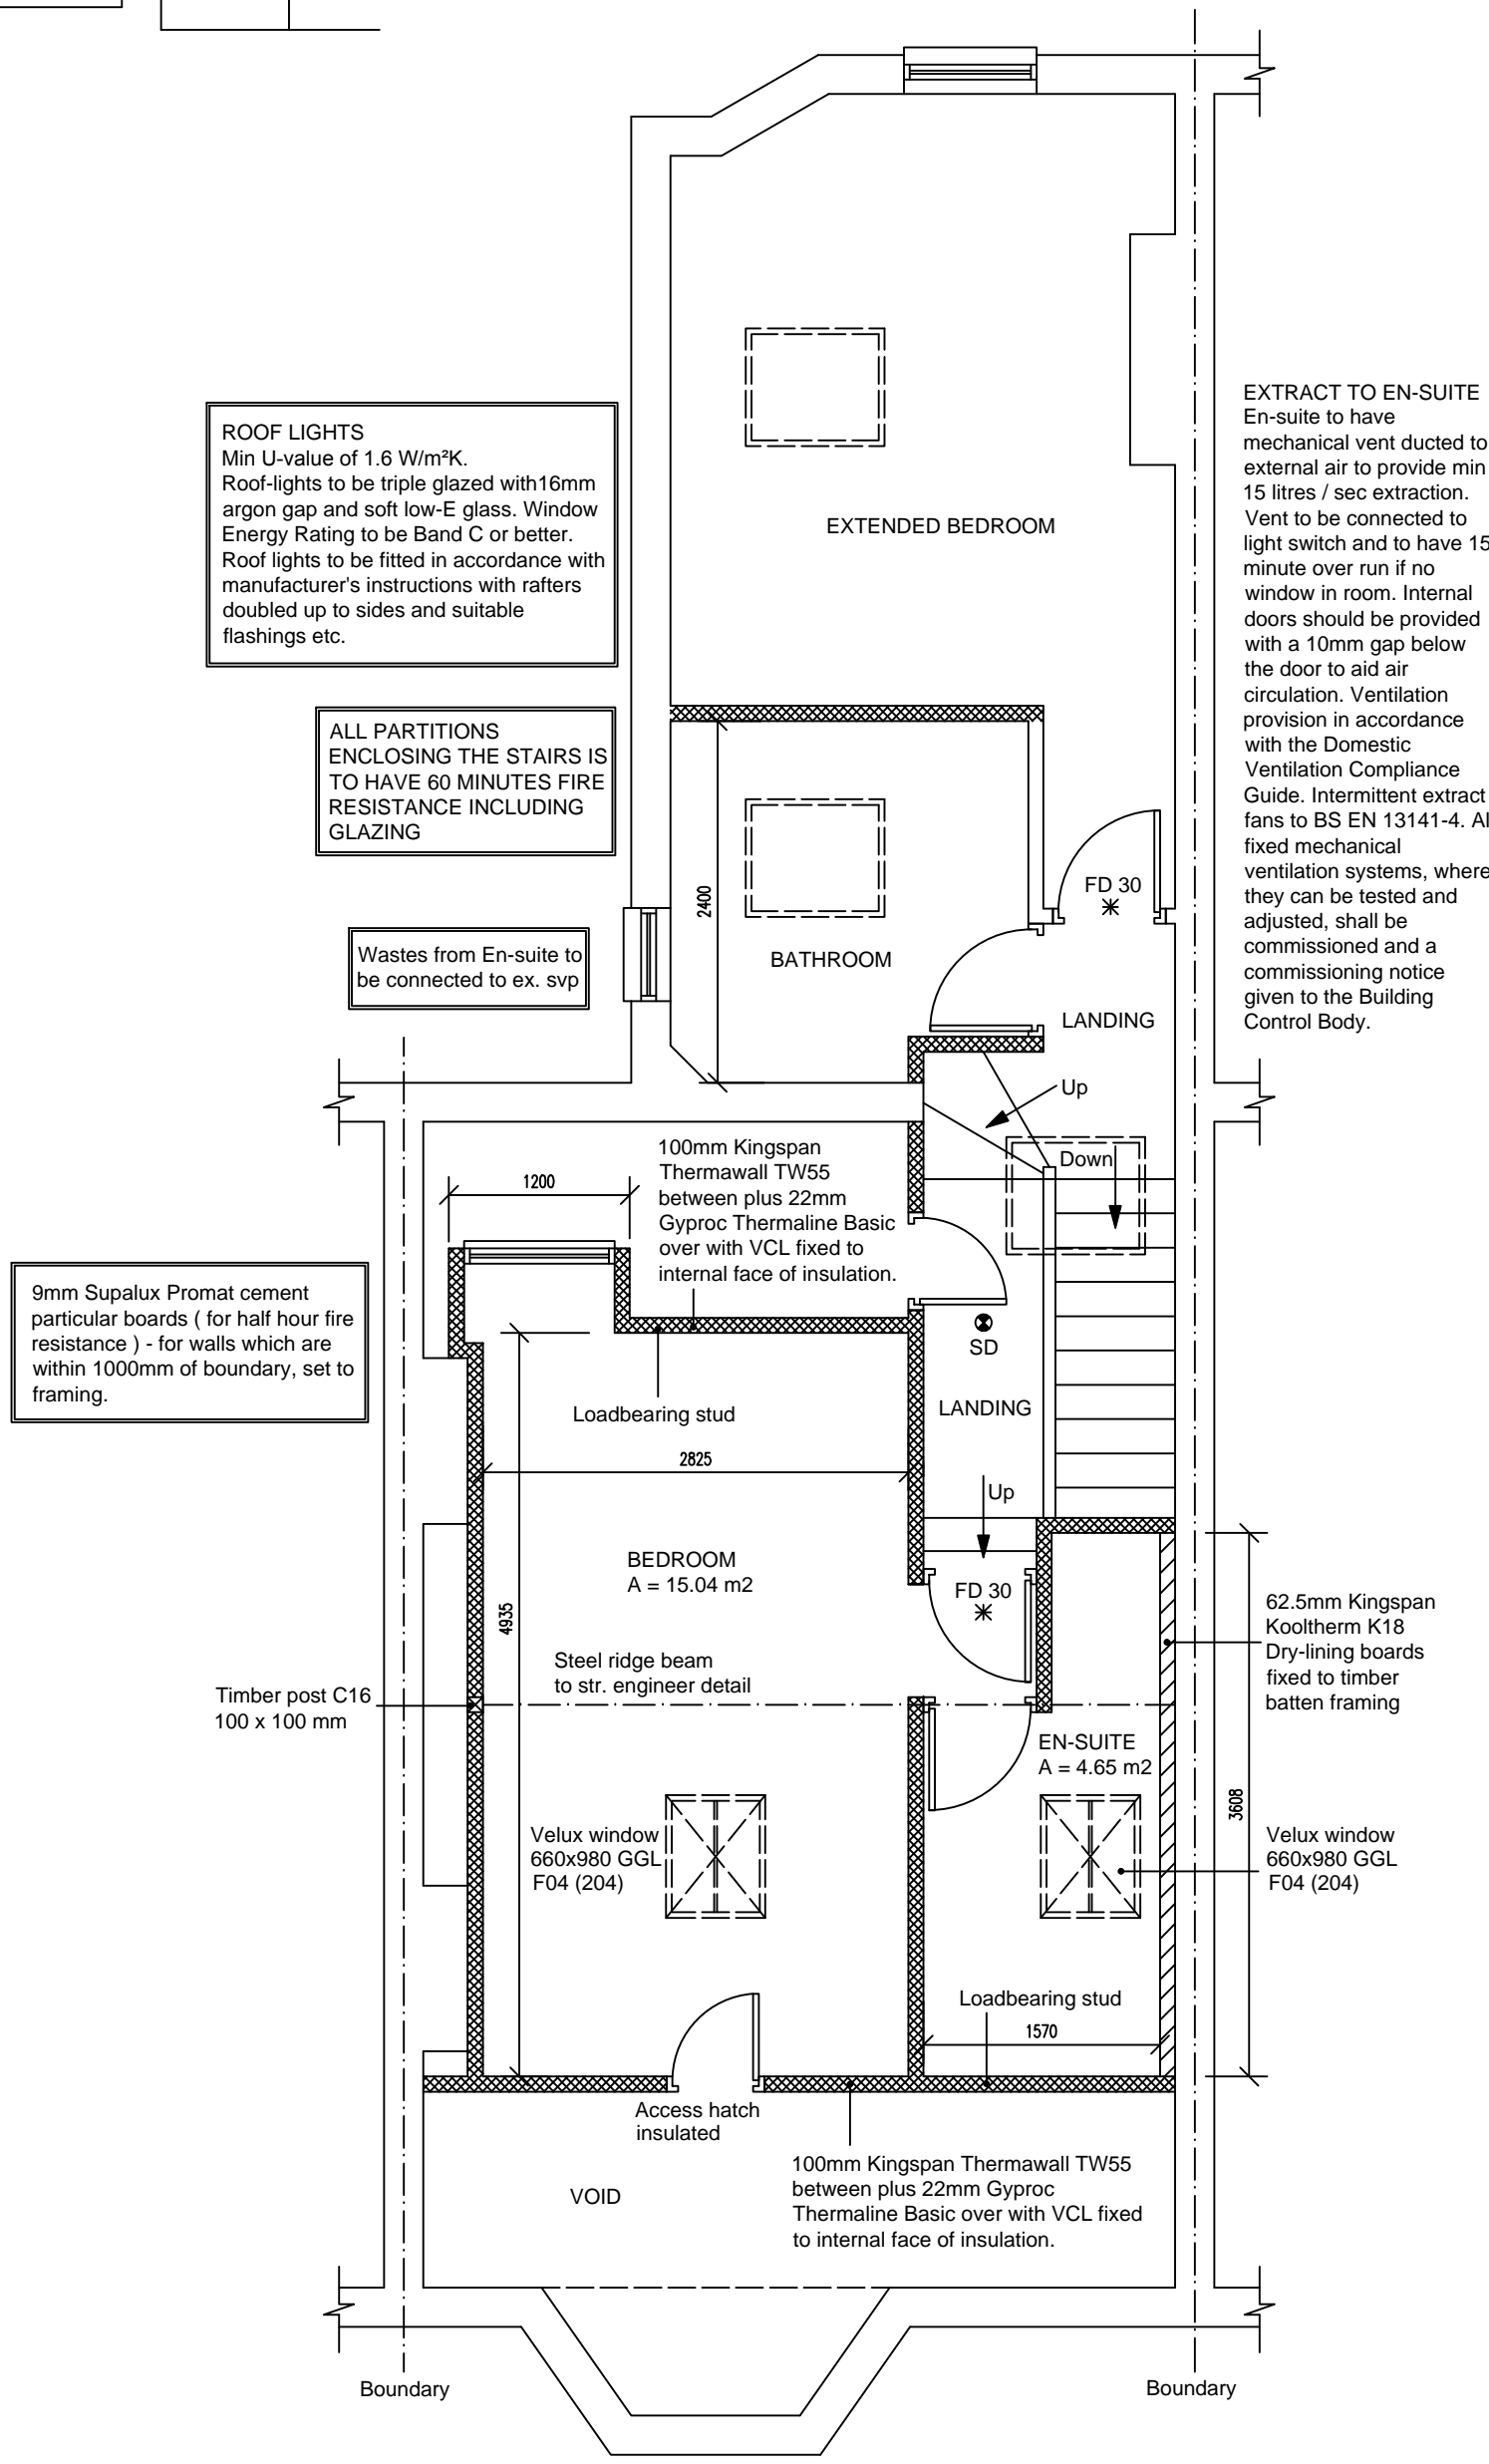

PROPOSED SECOND / ATTIC FLOOR PLAN
(scale 1:50)

THIS DRAWING IS © SOUTH LONDON LOFTS. DO NOT SCALE FROM THIS DRAWING. ANY ERROR TO BE REPORTED BEFORE WORKS ARE CARRIED OUT. THESE DRAWINGS ARE NOT FOR CONSTRUCTION USE AND ALL DIMENSIONS ARE TO BE VERIFIED UNLESS STATED.

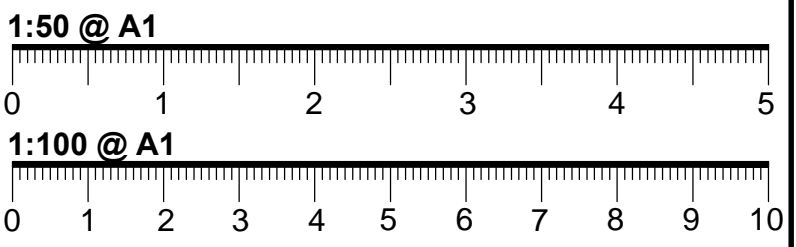

- NOTES:**
- THESE DRAWINGS ARE FOR BUILDING ILLUSTRATION PURPOSES ONLY
 - (REFER TO BUILDING SPEC FOR FURTHER INFORMATION)
 - DIMENSIONS ARE TO BE CHECKED ON SITE PRIOR TO ANY CONSTRUCTION
 - REFER TO STRUCTURAL ENGINEER REPORT FOR STEEL WORKS, THESE DRAWINGS ARE FOR ILLUSTRATION PURPOSES ONLY
 - ELECTRICAL LAYOUT TO BE CONFIRMED BY CLIENT ON SITE WITH BUILDER
 - PLUMBING TO CONNECT TO EXISTING

- KEY:**
- SITE BOUNDARY
 - - - DEMOLITION
 - DRAINAGE
 - LIGHT LAYOUT TBC

- KEY:**
- DS MAINS CONNECTED SMOKE DETECTOR
 - HD MAINS CONNECTED HEAT DETECTOR
 - XX-X (REFER TO BUILDING SPEC NOTES)
 - FFL+XXX FINISHED FLOOR LEVEL
 - FE/RL FIRE ESCAPE ROPE LOCATION
 - FR/ER FIRE ESCAPE ROUTE WINDOW
 - FD-30 FIRE RATED DOOR UP TO 30min
 - FS-30 FIRE RATED STUD WALL UP TO 30min
 - FR-30 FIRE RATED GLASS UP TO 30min



REVISION DATE/DRAWN



PROJECT	13 Holmewood Road		
	London		
DRAWING TITLE	PLANNING		
	PROPOSED PLANS		
	& SECTION		
DATE	JAN 22	SCALE	@ A1
DRAWN	MC	CHECK	SS
STATUS			
JOB NUMBER			
DRAWING NUMBER	DR-A-03	REV	E