
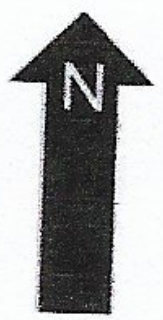
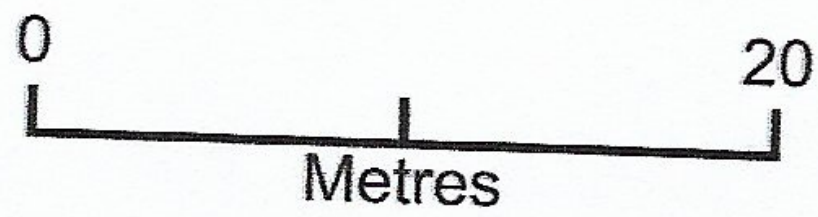


Proposed Site Plan (whole system)

inc points of discharge

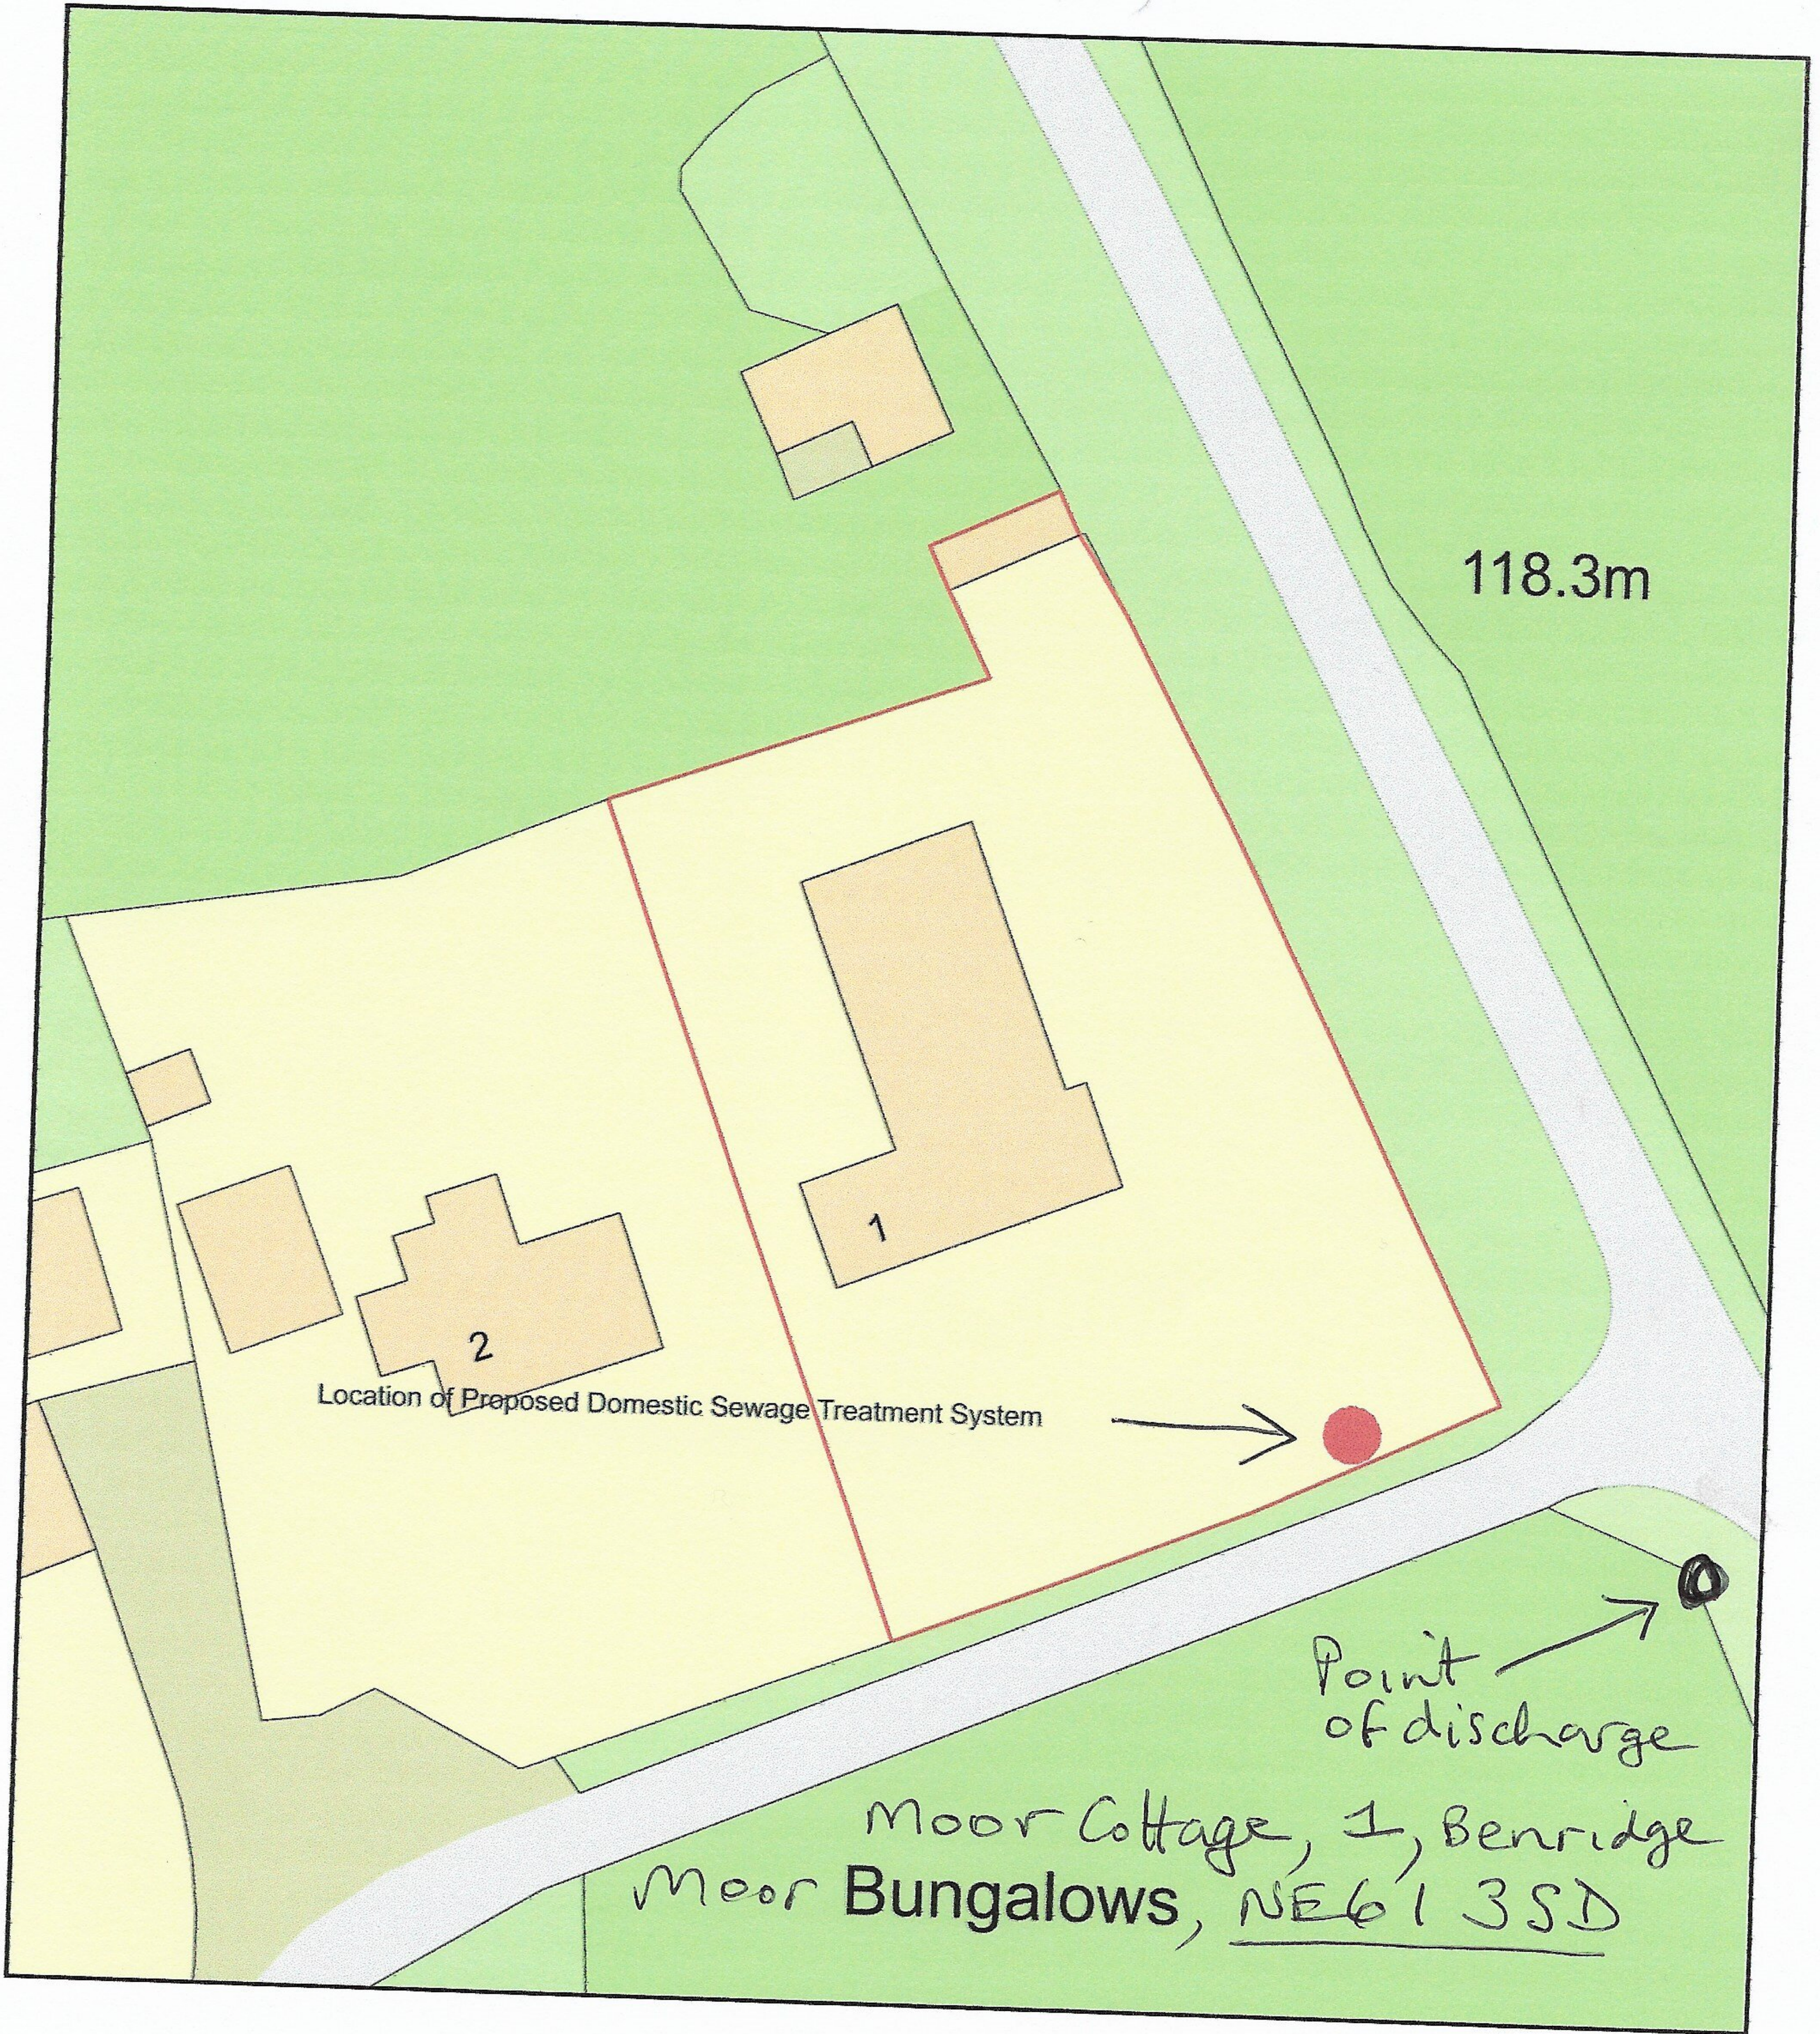

Plan Produced for: Mr Derek Milne
Date Produced: 09 May 2022
Plan Reference Number: TQRQM22129115213088
Scale: 1:500 @ A4