

- Notes :
- Dimensions are to be checked on site before
 - Remediation and construction
 - All measurements are to be immediately notified to the architects
 - Structural measurements are to be taken from the structural engineers drawings
 - Do not scale
 - Copyright reserved by LAB 4D

REVISION :

Description	Date
A -XXXXXX	01.01.21
B -XXXXXX	01.01.21
C -XXXXXX	01.01.21

SMOKE DETECTION
 L1 DETECTION AND ALARM SYSTEM IS RECOMMENDED THROUGHOUT THE BUILDING.
 IN ACCORDANCE WITH THE RECOMMENDATIONS OF BS 5839-1, THE FIRE ALARM SYSTEM TO BE INSTALLED SHOULD BE OF THE 'MEDIUM' RISK TO COMMENCEMENT OF THE INSTALLATION ON SITE.

Christopher Melvin
 ARCHITECTURE & DESIGN

Drawing Issue status
PLANNING


Client
BOBBY SINGH

Project
3 FALCONS HOTEL

100, Orchardson St,
 St Johns Wood,
 London,
 NW8 8NG

Drawing
ORCHARDSON ST EXISTING ELEVATION

Scale	Date	Drawn	Checked
1:100@A1 1:200@A3	19.09.21	CM	CM
Project 3F	Client BS	Drawing No 3F EL002 EXISTING REV -	

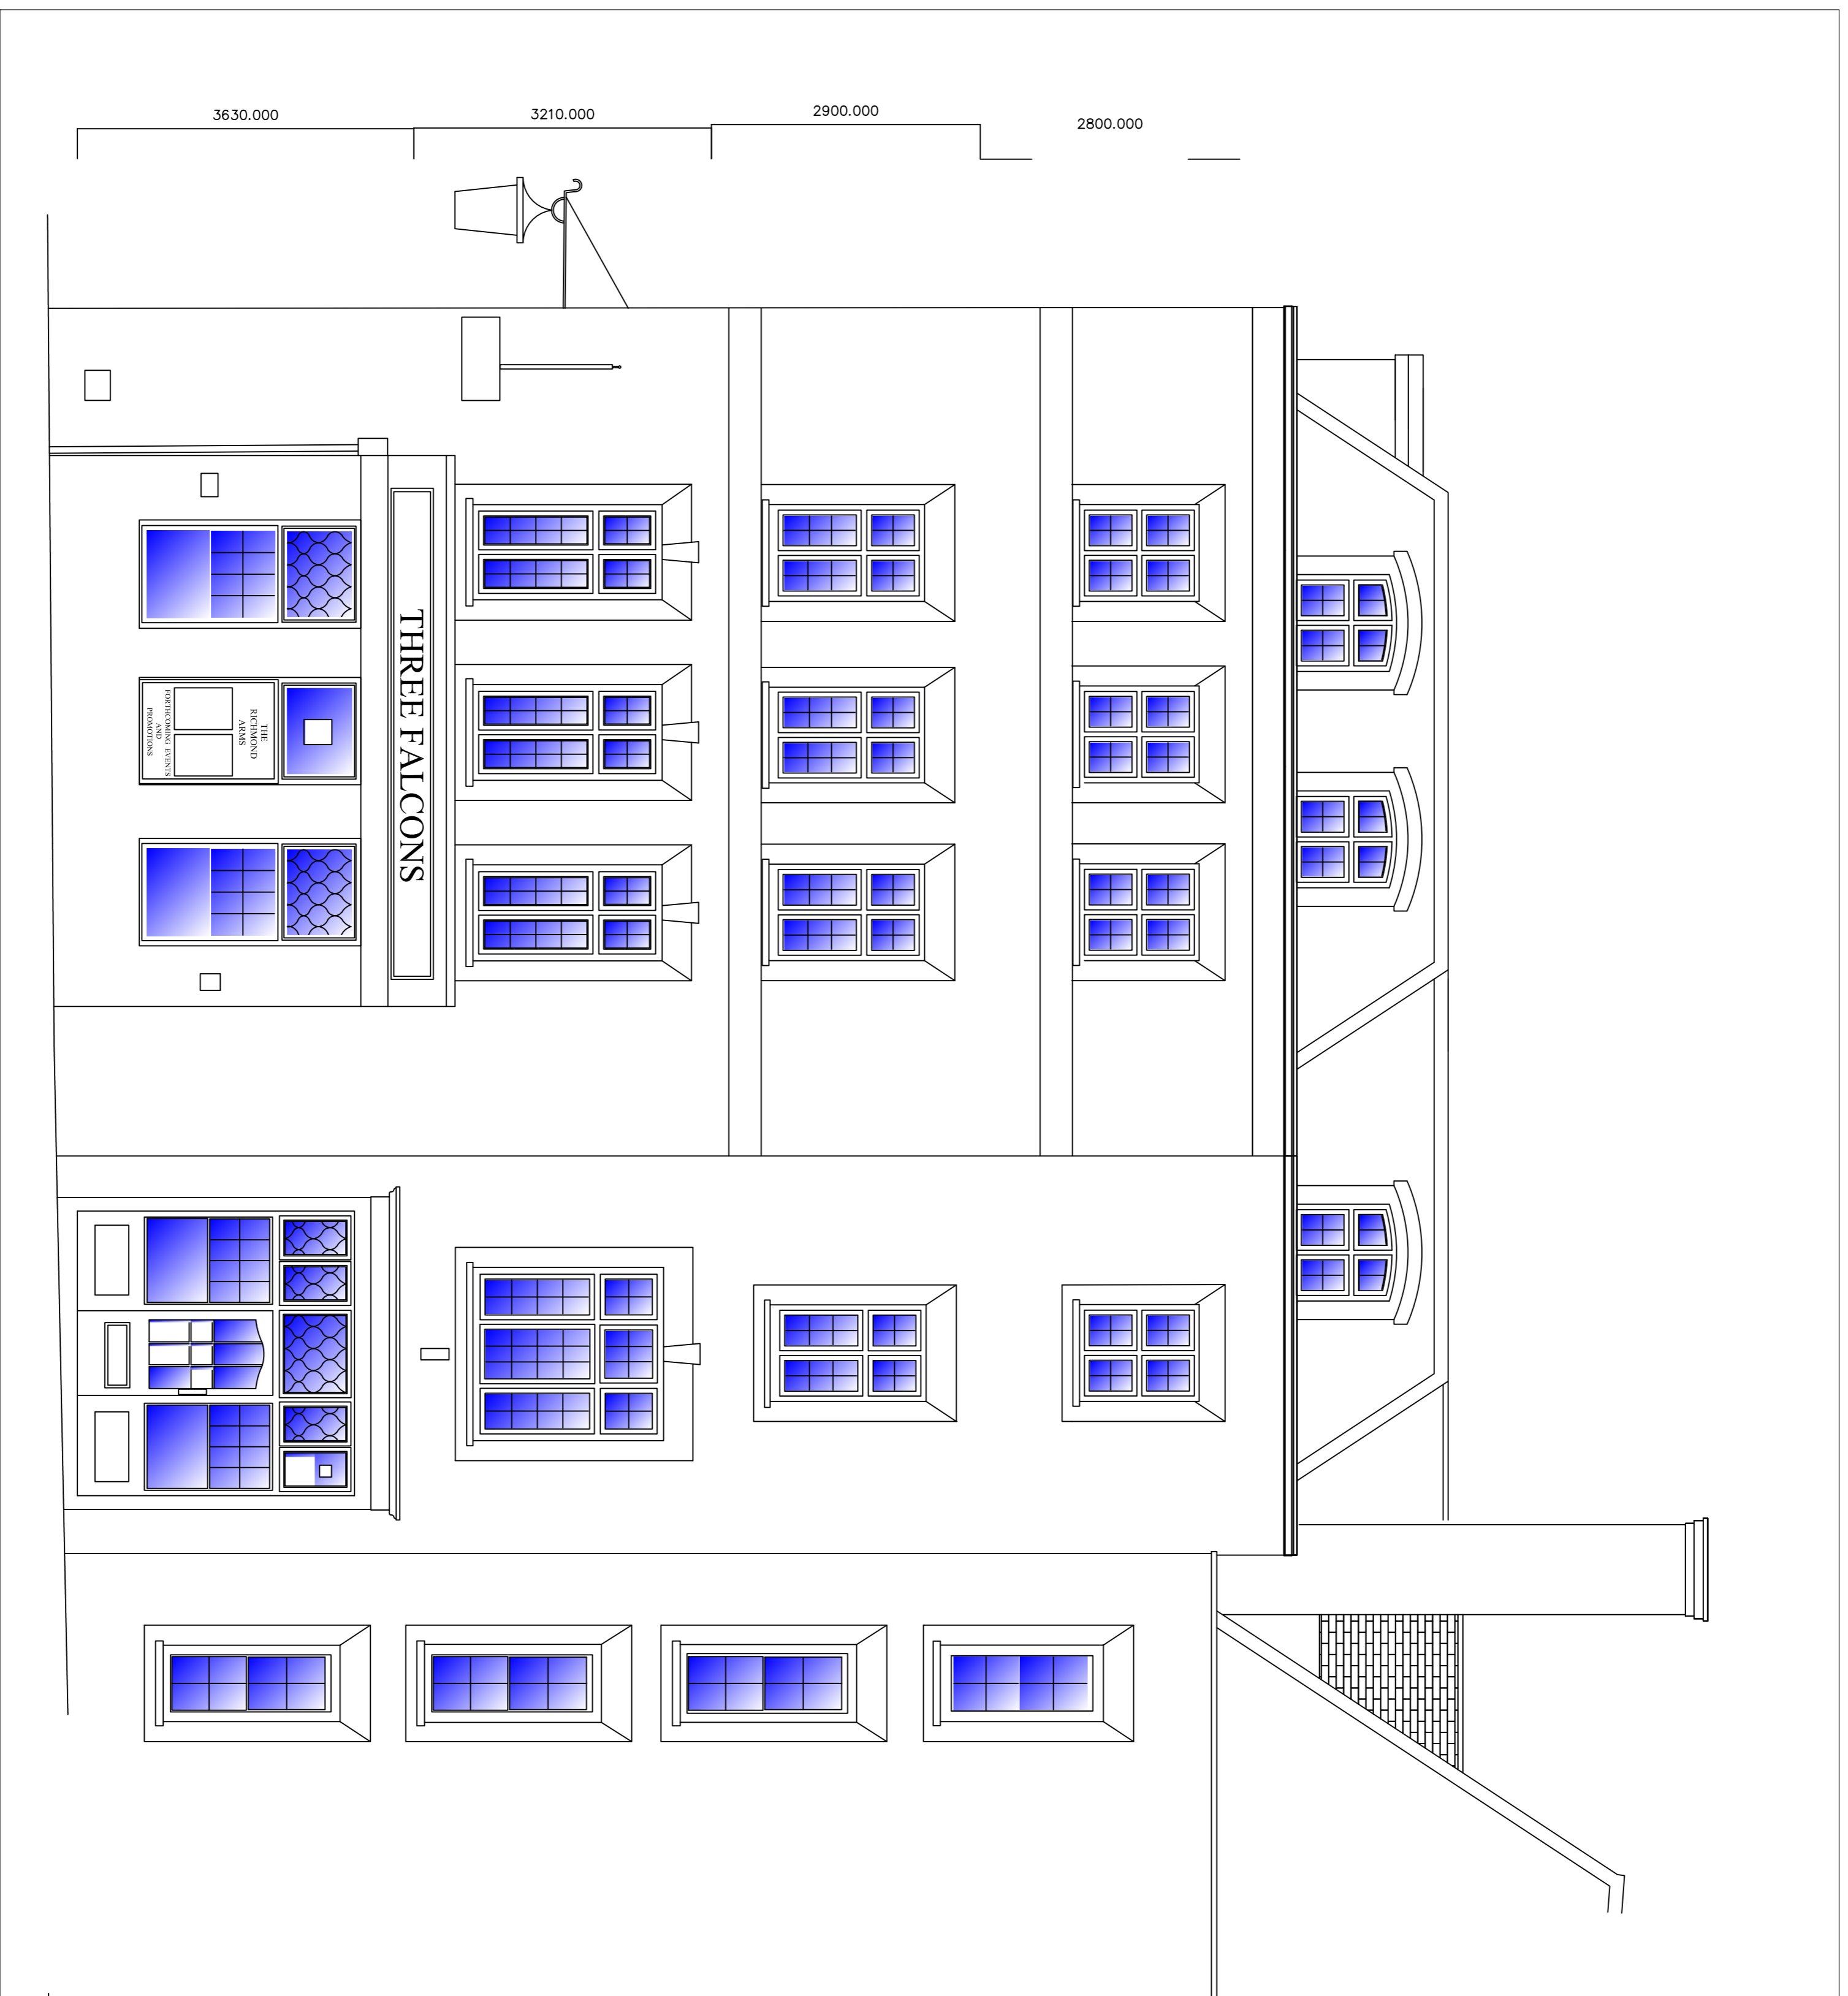

1 ORCHARDSON ST EXISTING ELEVATION
 SCALE 1:100@A1 1:200@A3