

- Notes :
- Dimensions are to be checked on site before
  - Remediation and construction
  - All measurements are to be immediately notified to the architects
  - Structural measurements are to be taken from the structural engineers drawings
  - Do not scale
  - Copyright reserved by LAB 4D

REVISION :

Description	Date
A -XXXXXX	01.01.21
B -XXXXXX	01.01.21
C -XXXXXX	01.01.21

**SMOKE DETECTION**  
 L1 DETECTION AND ALARM SYSTEM IS RECOMMENDED THROUGHOUT THE BUILDING.  
 IN ACCORDANCE WITH THE RECOMMENDATIONS OF BS 5839-1, THE FIRE ALARM SYSTEM SHALL BE INSTALLED IN ACCORDANCE WITH THE RECOMMENDATIONS OF THE INSTALLATION ON SITE.

Christopher Melvin  
 ARCHITECTURE & DESIGN

Drawing Issue status  
**PLANNING**


Client  
**BOBBY SINGH**

Project  
**3 FALCONS HOTEL**  
 100, Abchurch Lane,  
 St. John's Wood,  
 London,  
 NW8 8NG

Drawing  
**LYONS PLACE EXISTING ELEVATION**

Scale	Date	Drawn	Checked
1:100@A1 1:200@A3	19.09.21	CM	CM

Project	Client	Drawing No
3F	BS	3F EL001 EXISTING REV -

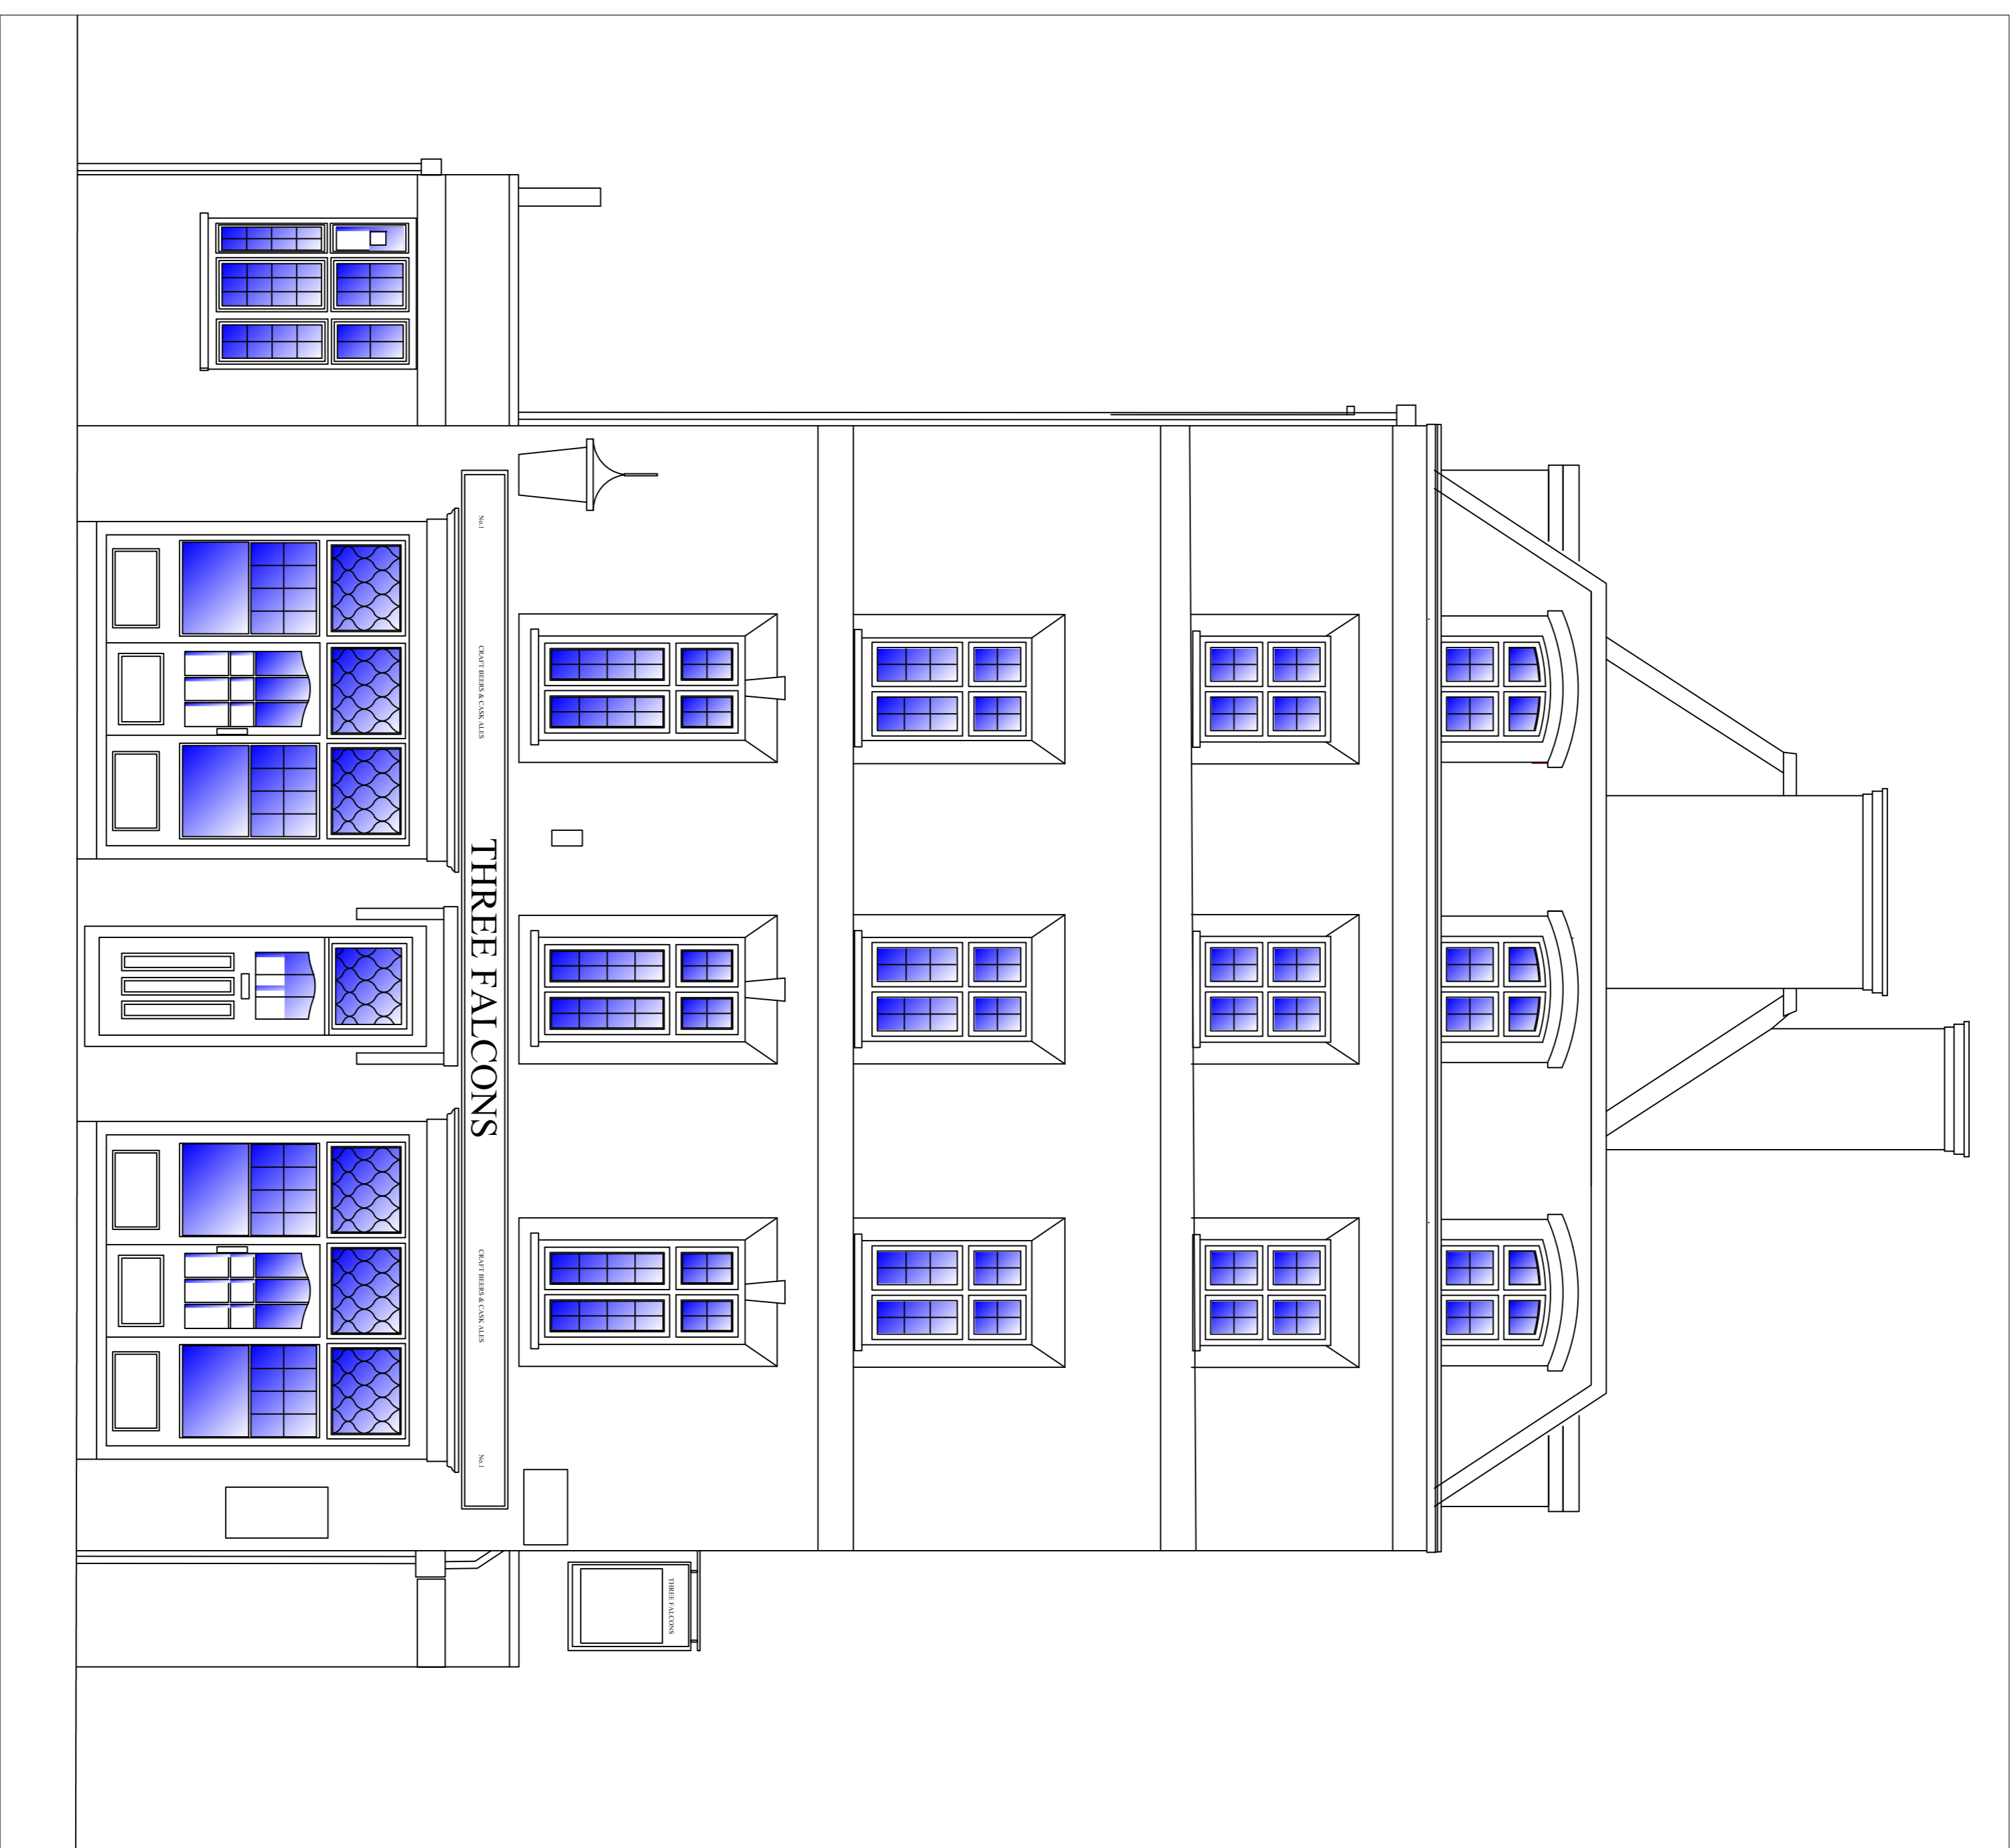

1 LYONS PLACE EXISTING ELEVATION  
 SCALE 1:100@A1 1:200@A3