

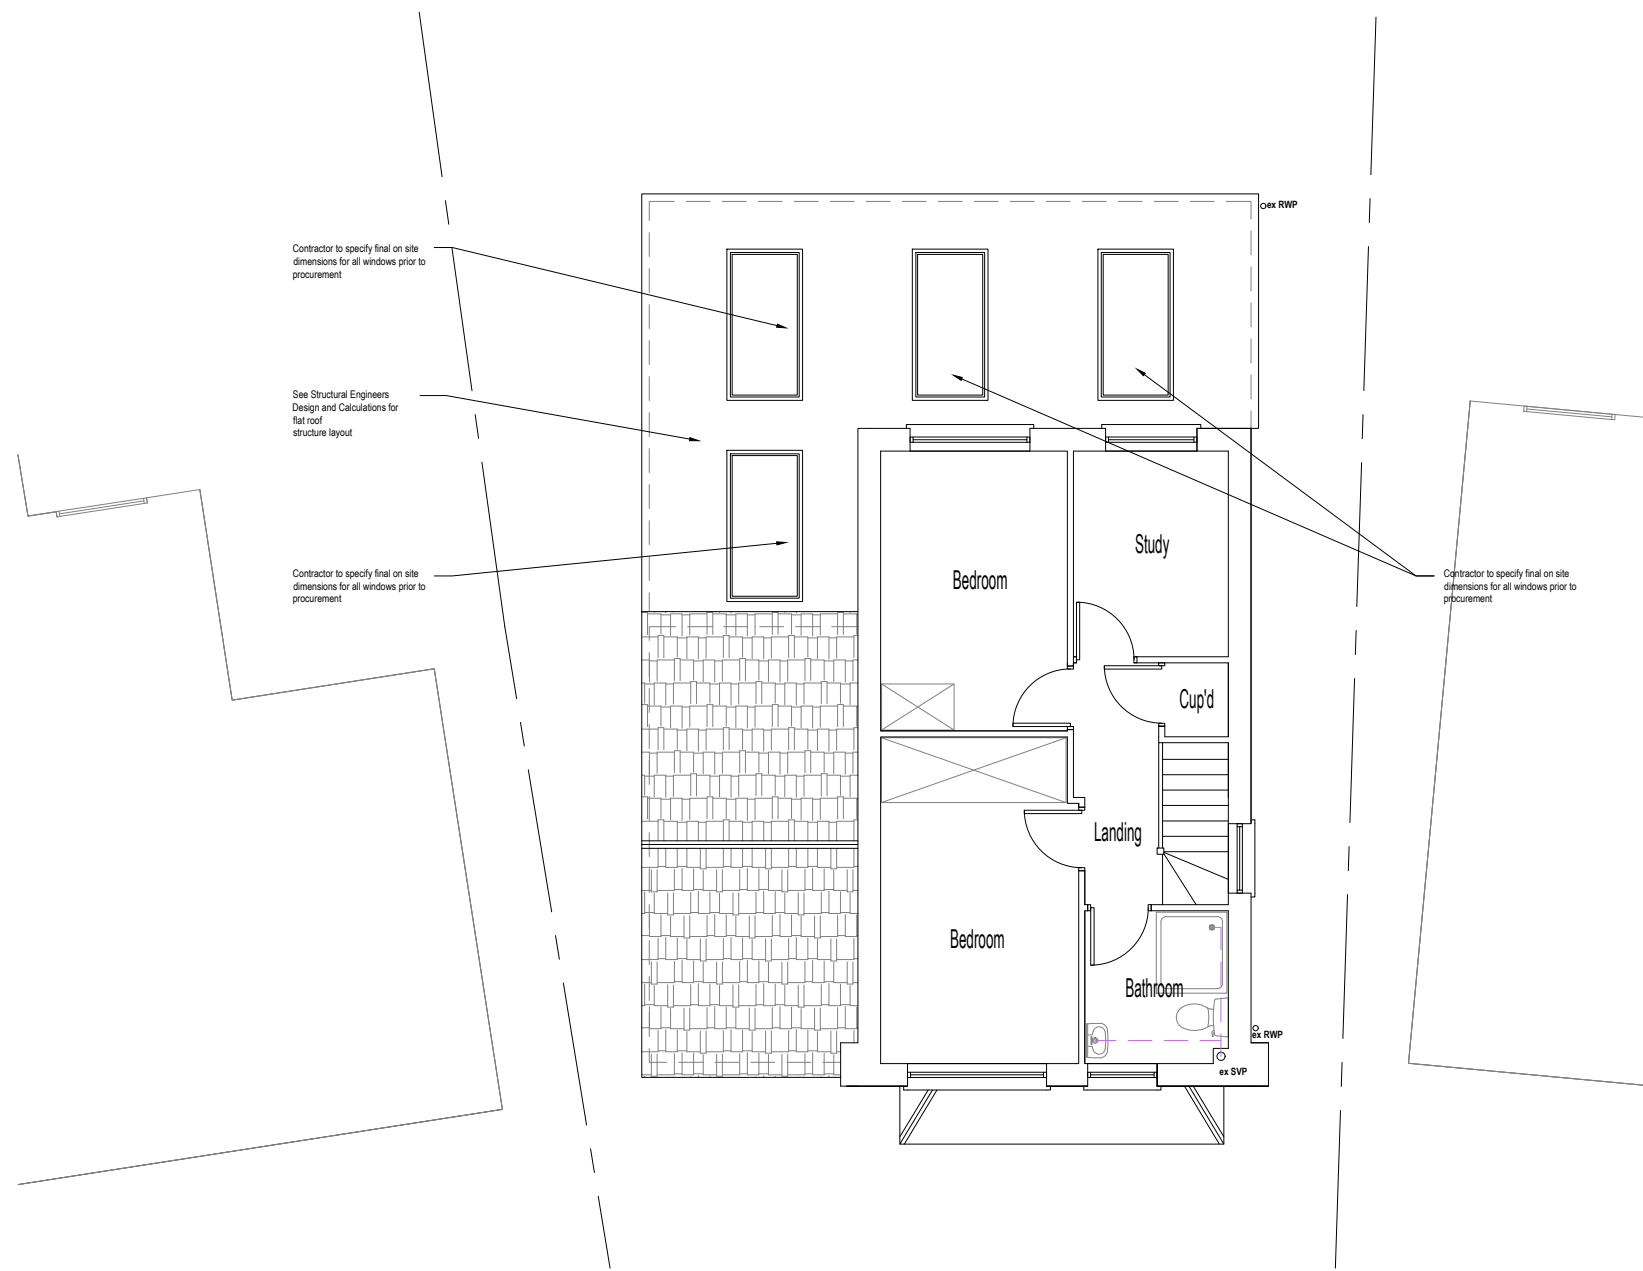


PROPOSED

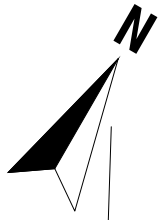

First Floor Plan
Area ca. 37.26 m²

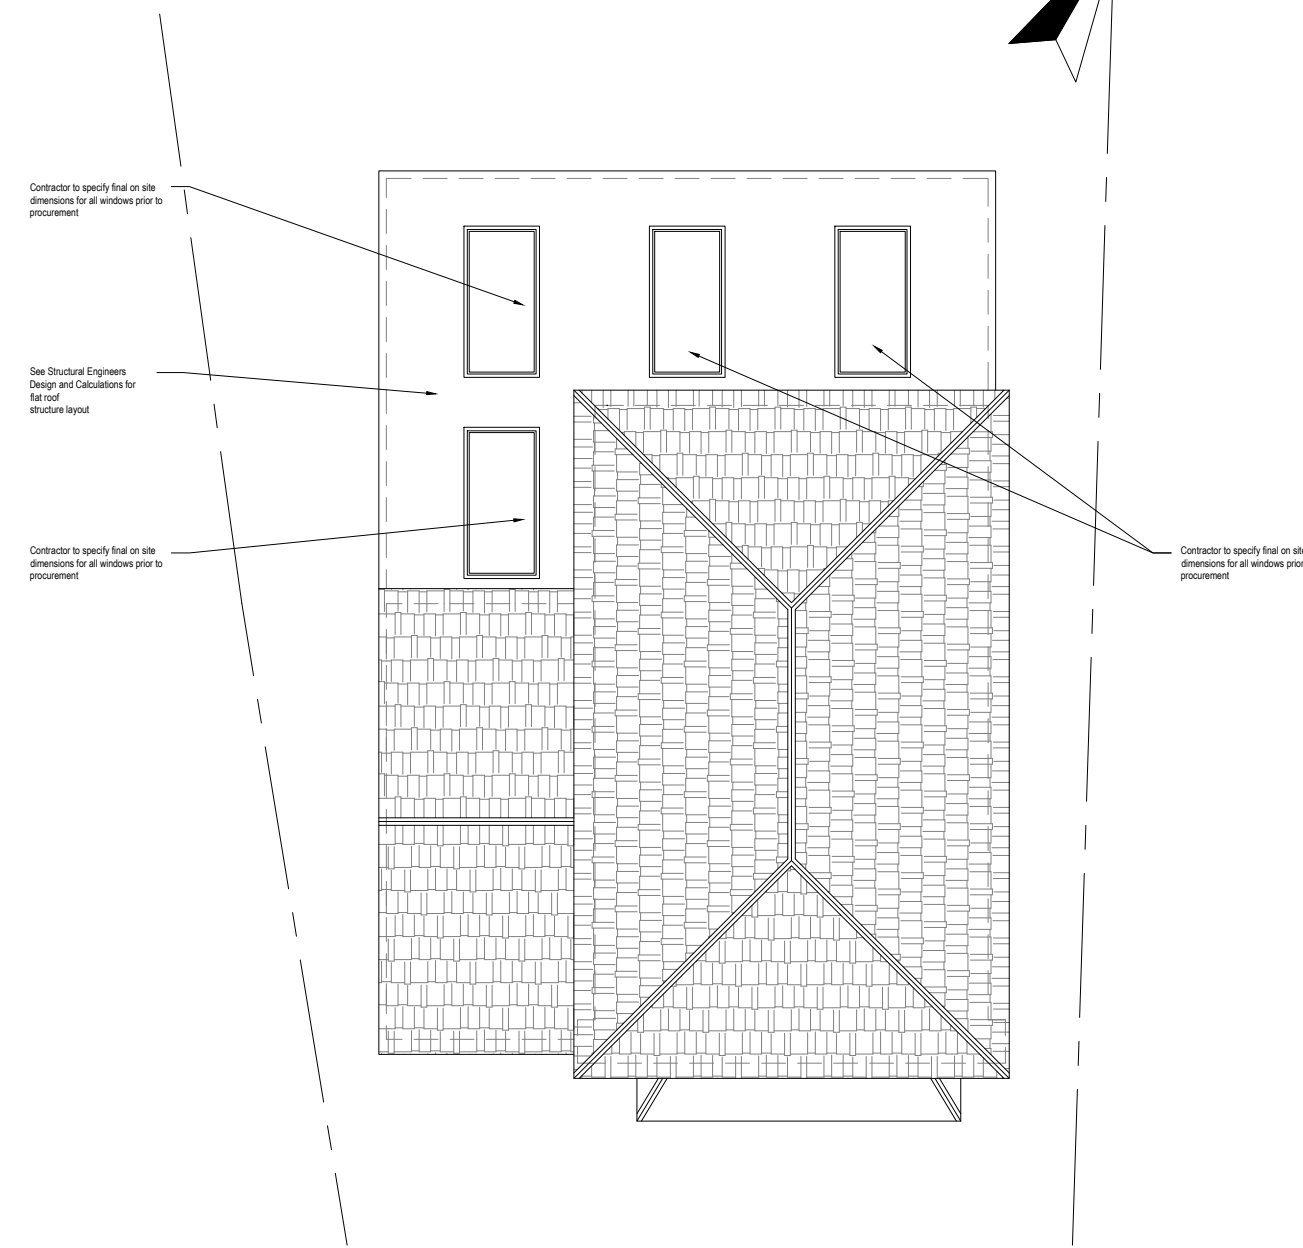

Roof Plan



Revision notes:		
Rev:	Date:	Notes:
001		The Contractor must carry out His/Her own measured survey prior to works commencing on site to verify site dimensions and to report any discrepancies to the Designer. Contractor to refer to Building Control Notes. Contractor is responsible for final on site design using on site dimensions. Contractor responsible for on site drainage layout/runs - to be agreed by Building Control prior to Construction starting on site. All Details to be approved by Building Control prior to construction starting on site.

Drawn by: FD	Client:
------------------------	----------------

Project: 59 Page Close Bean, Dartford DA2 8BX	Drawing Title: PROPOSED PLANS
---	---

Date: 02.04.2022	No.: 22-0747
Scale @A3: 1:100	Rev: 0
Issue: BUILDING REGULATIONS	Page: D07

Plan It
Architectural Services
www.planituk.co.uk