


**Existing Block Plan**  
Scale 1:500

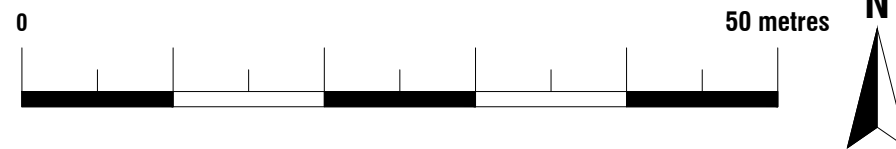

**Proposed Block Plan**  
Scale 1:500



Revision notes:		
Rev:	Date:	Notes:
001		The Contractor must carry out His/Her own measured survey prior to works commencing on site to verify site dimensions and to report any discrepancies to the Designer. Contractor to refer to Building Control Notes. Contractor is responsible for final on site design using on site dimensions.  Contractor responsible for on site drainage layout/runs - to be agreed by Building Control prior to Construction starting on site. All Details to be approved by Building Control prior to construction starting on site.

<b>Drawn by:</b> FD	<b>Client:</b>
------------------------	----------------

<b>Project:</b> 59 Page Close Bean, Dartford DA2 8BX	<b>Drawing Title:</b> EXISTING BLOCK PLAN PROPOSED BLOCK PLAN
---	---

<b>Date:</b> 02.04.2022	<b>No.:</b> 22-0747
<b>Scale @A3:</b> 1:500	<b>Rev:</b> 0
<b>Issue:</b> BUILDING REGULATIONS	<b>Page:</b> 002

**Plan It**  
Architectural Services  
www.planituk.co.uk