


Location Plan

Scale 1:1250

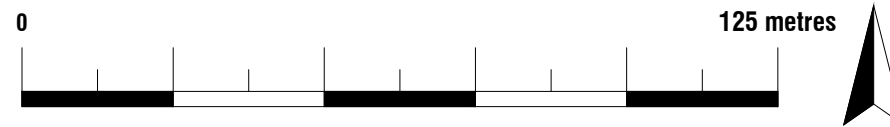

Revision notes:		
Rev:	Date:	Notes:
001		The Contractor must carry out His/Her own measured survey prior to works commencing on site to verify site dimensions and to report any discrepancies to the Designer. Contractor to refer to Building Control Notes. Contractor is responsible for final on site design using on site dimensions. Contractor responsible for on site drainage layout/runs - to be agreed by Building Control prior to Construction starting on site.All Details to be approved by Building Control prior to construction starting on site.

Drawn by: FD	Client:
------------------------	----------------

Project: 59 Page Close Bean, Dartford DA2 8BX	Drawing Title: LOCATION PLAN
---	--

Date: 02.04.2022	Scale @A3: 1:1250
Issue: BUILDING REGULATIONS	

No.: 22-0747	Rev: 0
Page: D01	

Plan It
Architectural Services
www.planituk.co.uk