 


SITE LOCATION




Reproduced by permission of Ordnance Survey on behalf of the Controller of Her Majesty's Stationary Office  
All rights reserved. © Crown Copyright licence no. 100022432

SITE AREA PLAN




SITE PHOTOGRAPH

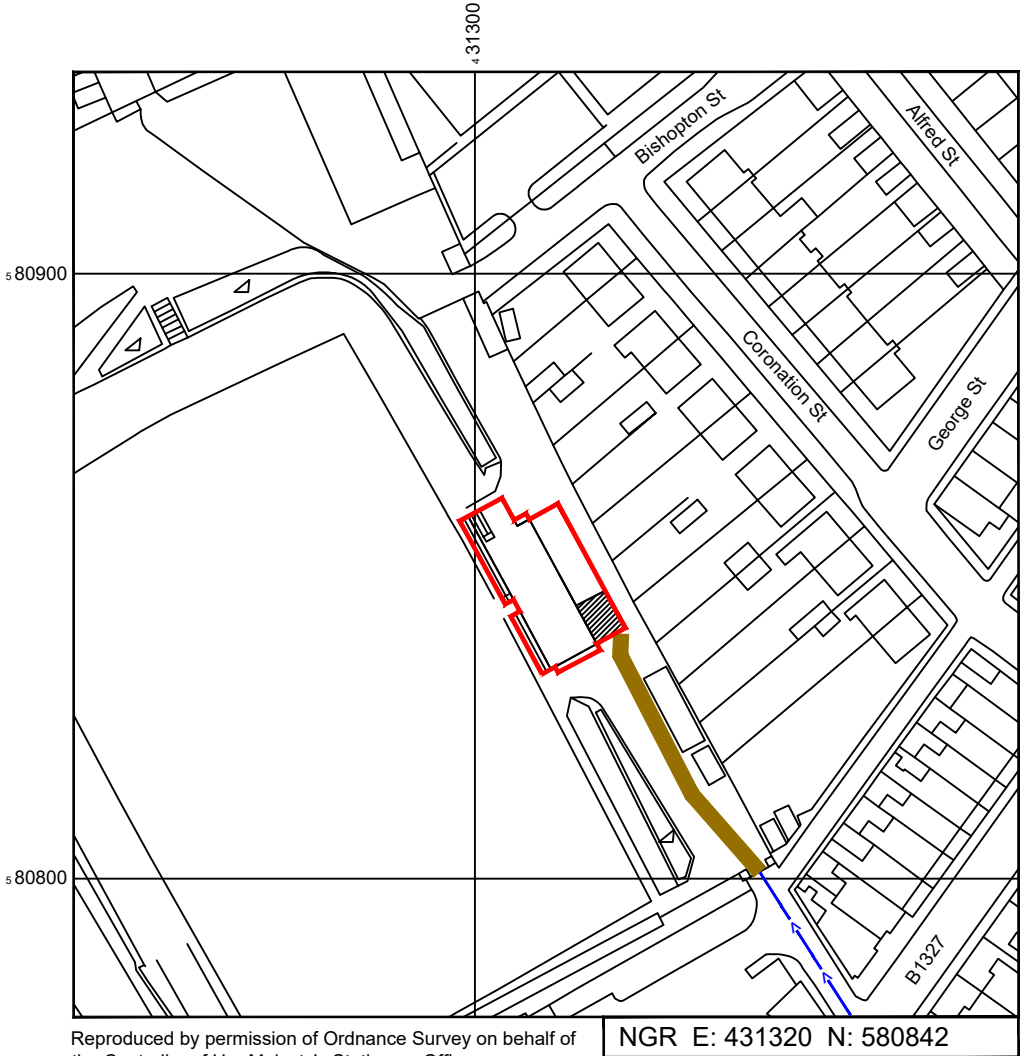

Reproduced by permission of Ordnance Survey on behalf of  
the Controller of Her Majesty's Stationary Office  
All rights reserved. © Crown Copyright licence no. 100022432

 SITE LOCATION PLAN



GOOGLE MAPS QR CODE

GOOGLE MAPS - <https://goo.gl/maps/pUiDTScWPzDaz8ww9>

GOOGLE STREET VIEW - <https://goo.gl/maps/tfgDpUSCwhD9esJs8>

NOTES:

1. ALL DIMENSIONS IN MM UNLESS OTHERWISE NOTED.

DIRECTIONS TO SITE:

Head north on A1(M). Keep right at the fork to continue on A194(M), follow signs for Tyne Tunnel/South Shields. At White Mare Pool Interchange, take the 2nd exit onto Leam Ln/A194. At the roundabout, take the 2nd exit and stay on Leam Ln/A194. At the roundabout, take the 2nd exit onto the A19 slip road to Tyne Tunnel/Morpeth. Merge onto A19. Keep left to stay on A19. At the roundabout, take the 5th exit onto A189. Take the exit towards Seaton/A192/Delaval/Cramlington. Continue onto A1061. At the roundabout, take the 3rd exit and stay on A1061. At the roundabout, take the 2nd exit onto Laverock Hall Rd/A1061. At the roundabout, take the 2nd exit onto A1061. At the roundabout, take the 1st exit onto S Newsham Rd/B1523. At the roundabout, continue straight onto Plessey Rd/B1327. Turn left. Destination will be on the left

Site Location:



Access Route To Site:



Access Route:



Master:	MBNL / EE / H3G:	Project:	Purpose of Issue:	Issue:
M001	EE	Airscale	General Arrangement	A
Date:	18/06/2022	Revision / Upgrade Description:		
Drawn:	RMITHA	First Issue		
Checked:	MP			
Approved:	MP			



Hatfield Business Park  
Hatfield  
Hertfordshire  
AL10 9BW

Tel: 01707 315000  
Fax: 01707 319001

Design Consultant & Principal Contractor:




WALDON TELECOM  
PHOENIX HOUSE  
PYRFORD ROAD  
WEST BYFLEET  
SURREY  
KT14 6RA

TEL : 01932 411011  
FAX : 01932 411012

Site Name:	BLYTH SPARTANS AFC 212654		
Site ID:	1104677		
Address:	BLYTH SPARTANS AFC CROFT PARK BLYTH NORTHUMBERLAND NE24 3JE		
Title:	002 SITE LOCATION PLAN		
Project:	AIRSCALE		
Purpose of Issue:	GENERAL ARRANGEMENT		
EE Cell ID:	MBNL Cell ID:	3UK Cell ID:	
24620	BLV015	NE0137	
Master Drawing No:			Issue:
1104677_BLV015_24620_NE0137_M001			A



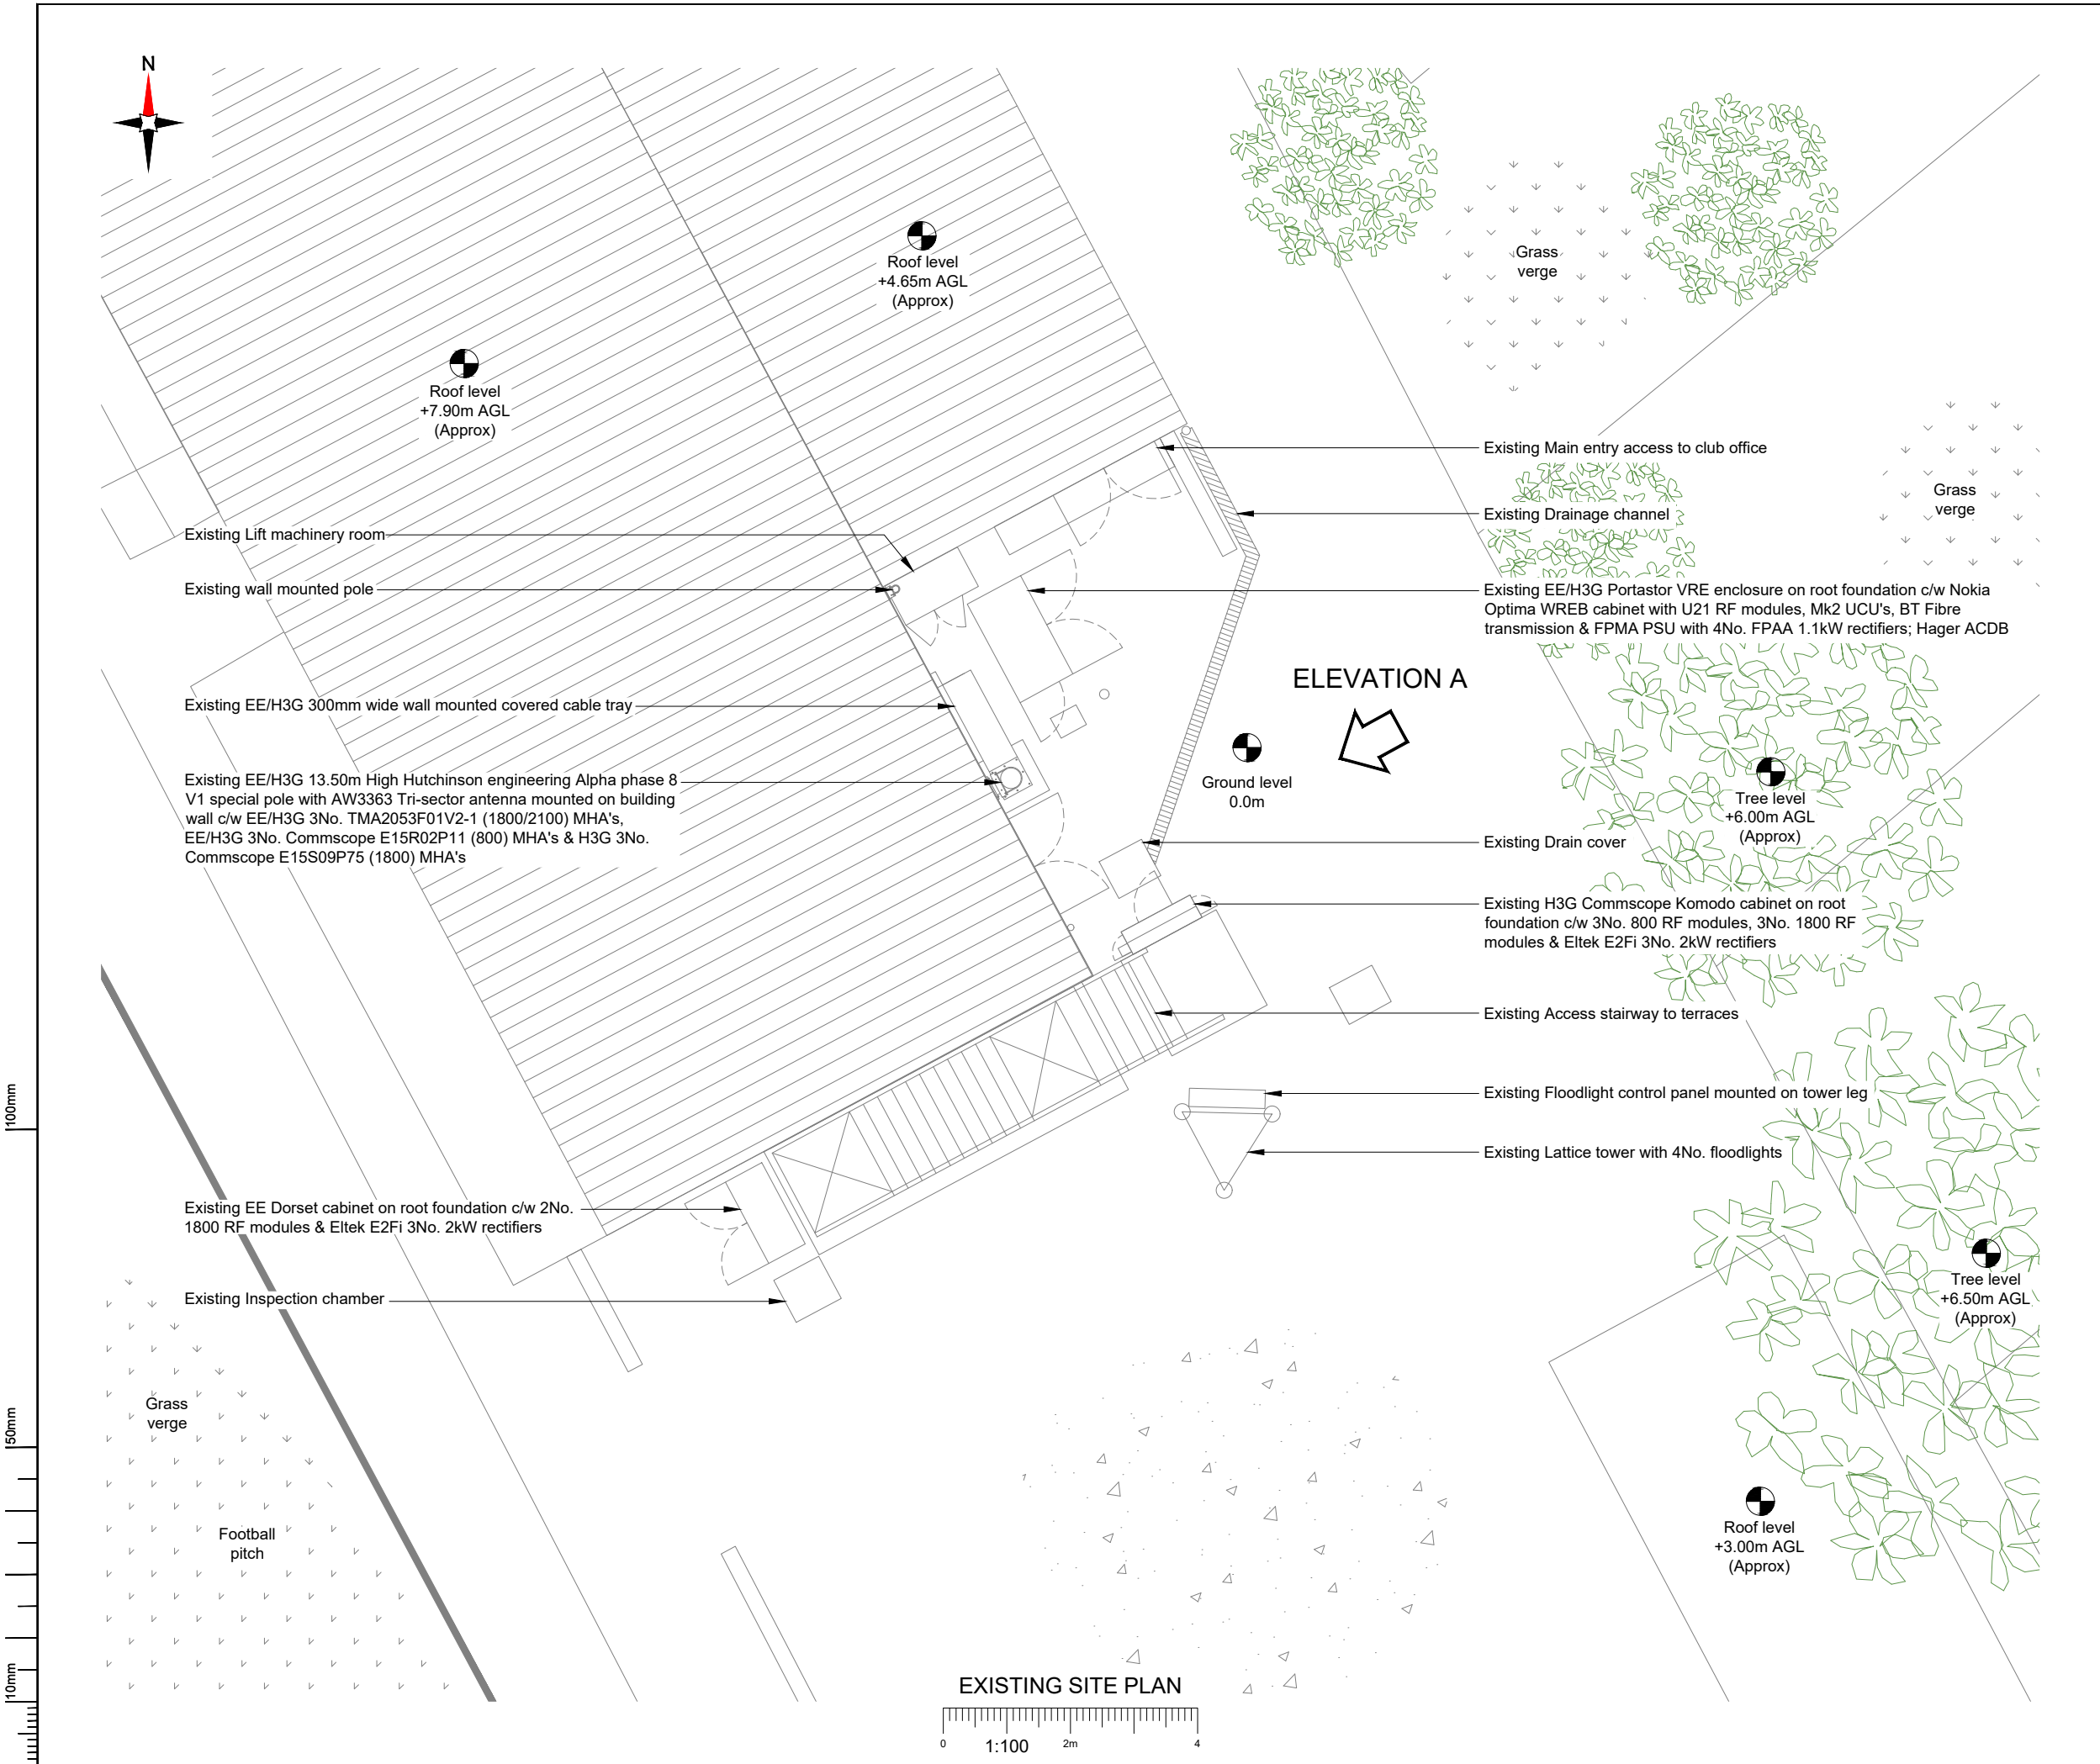

- NOTES:
- ALL DIMENSIONS IN MM UNLESS OTHERWISE NOTED.

Master:	MBNL / EE / H3G:	Project:	Purpose of Issue:	Issue:
M001	EE	Airscale	General Arrangement	A
Date:	18/06/2022	Revision / Upgrade Description:		
Drawn:	RMITHA	First Issue		
Checked:	MP			
Approved:	MP			



Hatfield Business Park  
Hatfield  
Hertfordshire  
AL10 9BW

Tel: 01707 315000  
Fax: 01707 319001

Design Consultant & Principal Contractor:



A part of **MG**roupServices

WALDON TELECOM  
PHOENIX HOUSE  
PYRFORD ROAD  
WEST BYFLEET  
SURREY  
KT14 6RA

TEL : 01932 411011  
FAX : 01932 411012

Site Name:  
**BLYTH SPARTANS AFC 212654**

Site ID:  
**1104677**

Address:  
**BLYTH SPARTANS AFC  
CROFT PARK  
BLYTH  
NORTHUMBERLAND  
NE24 3JE**


Title:  
**100 EXISTING SITE PLAN**

Project:  
**AIRSCALE**

Purpose of Issue:  
**GENERAL ARRANGEMENT**

EE Cell ID:	MBNL Cell ID:	3UK Cell ID:
<b>24620</b>	<b>BLV015</b>	<b>NE0137</b>

Master Drawing No:	Issue:
<b>1104677_BLV015_24620_NE0137_M001</b>	<b>A</b>

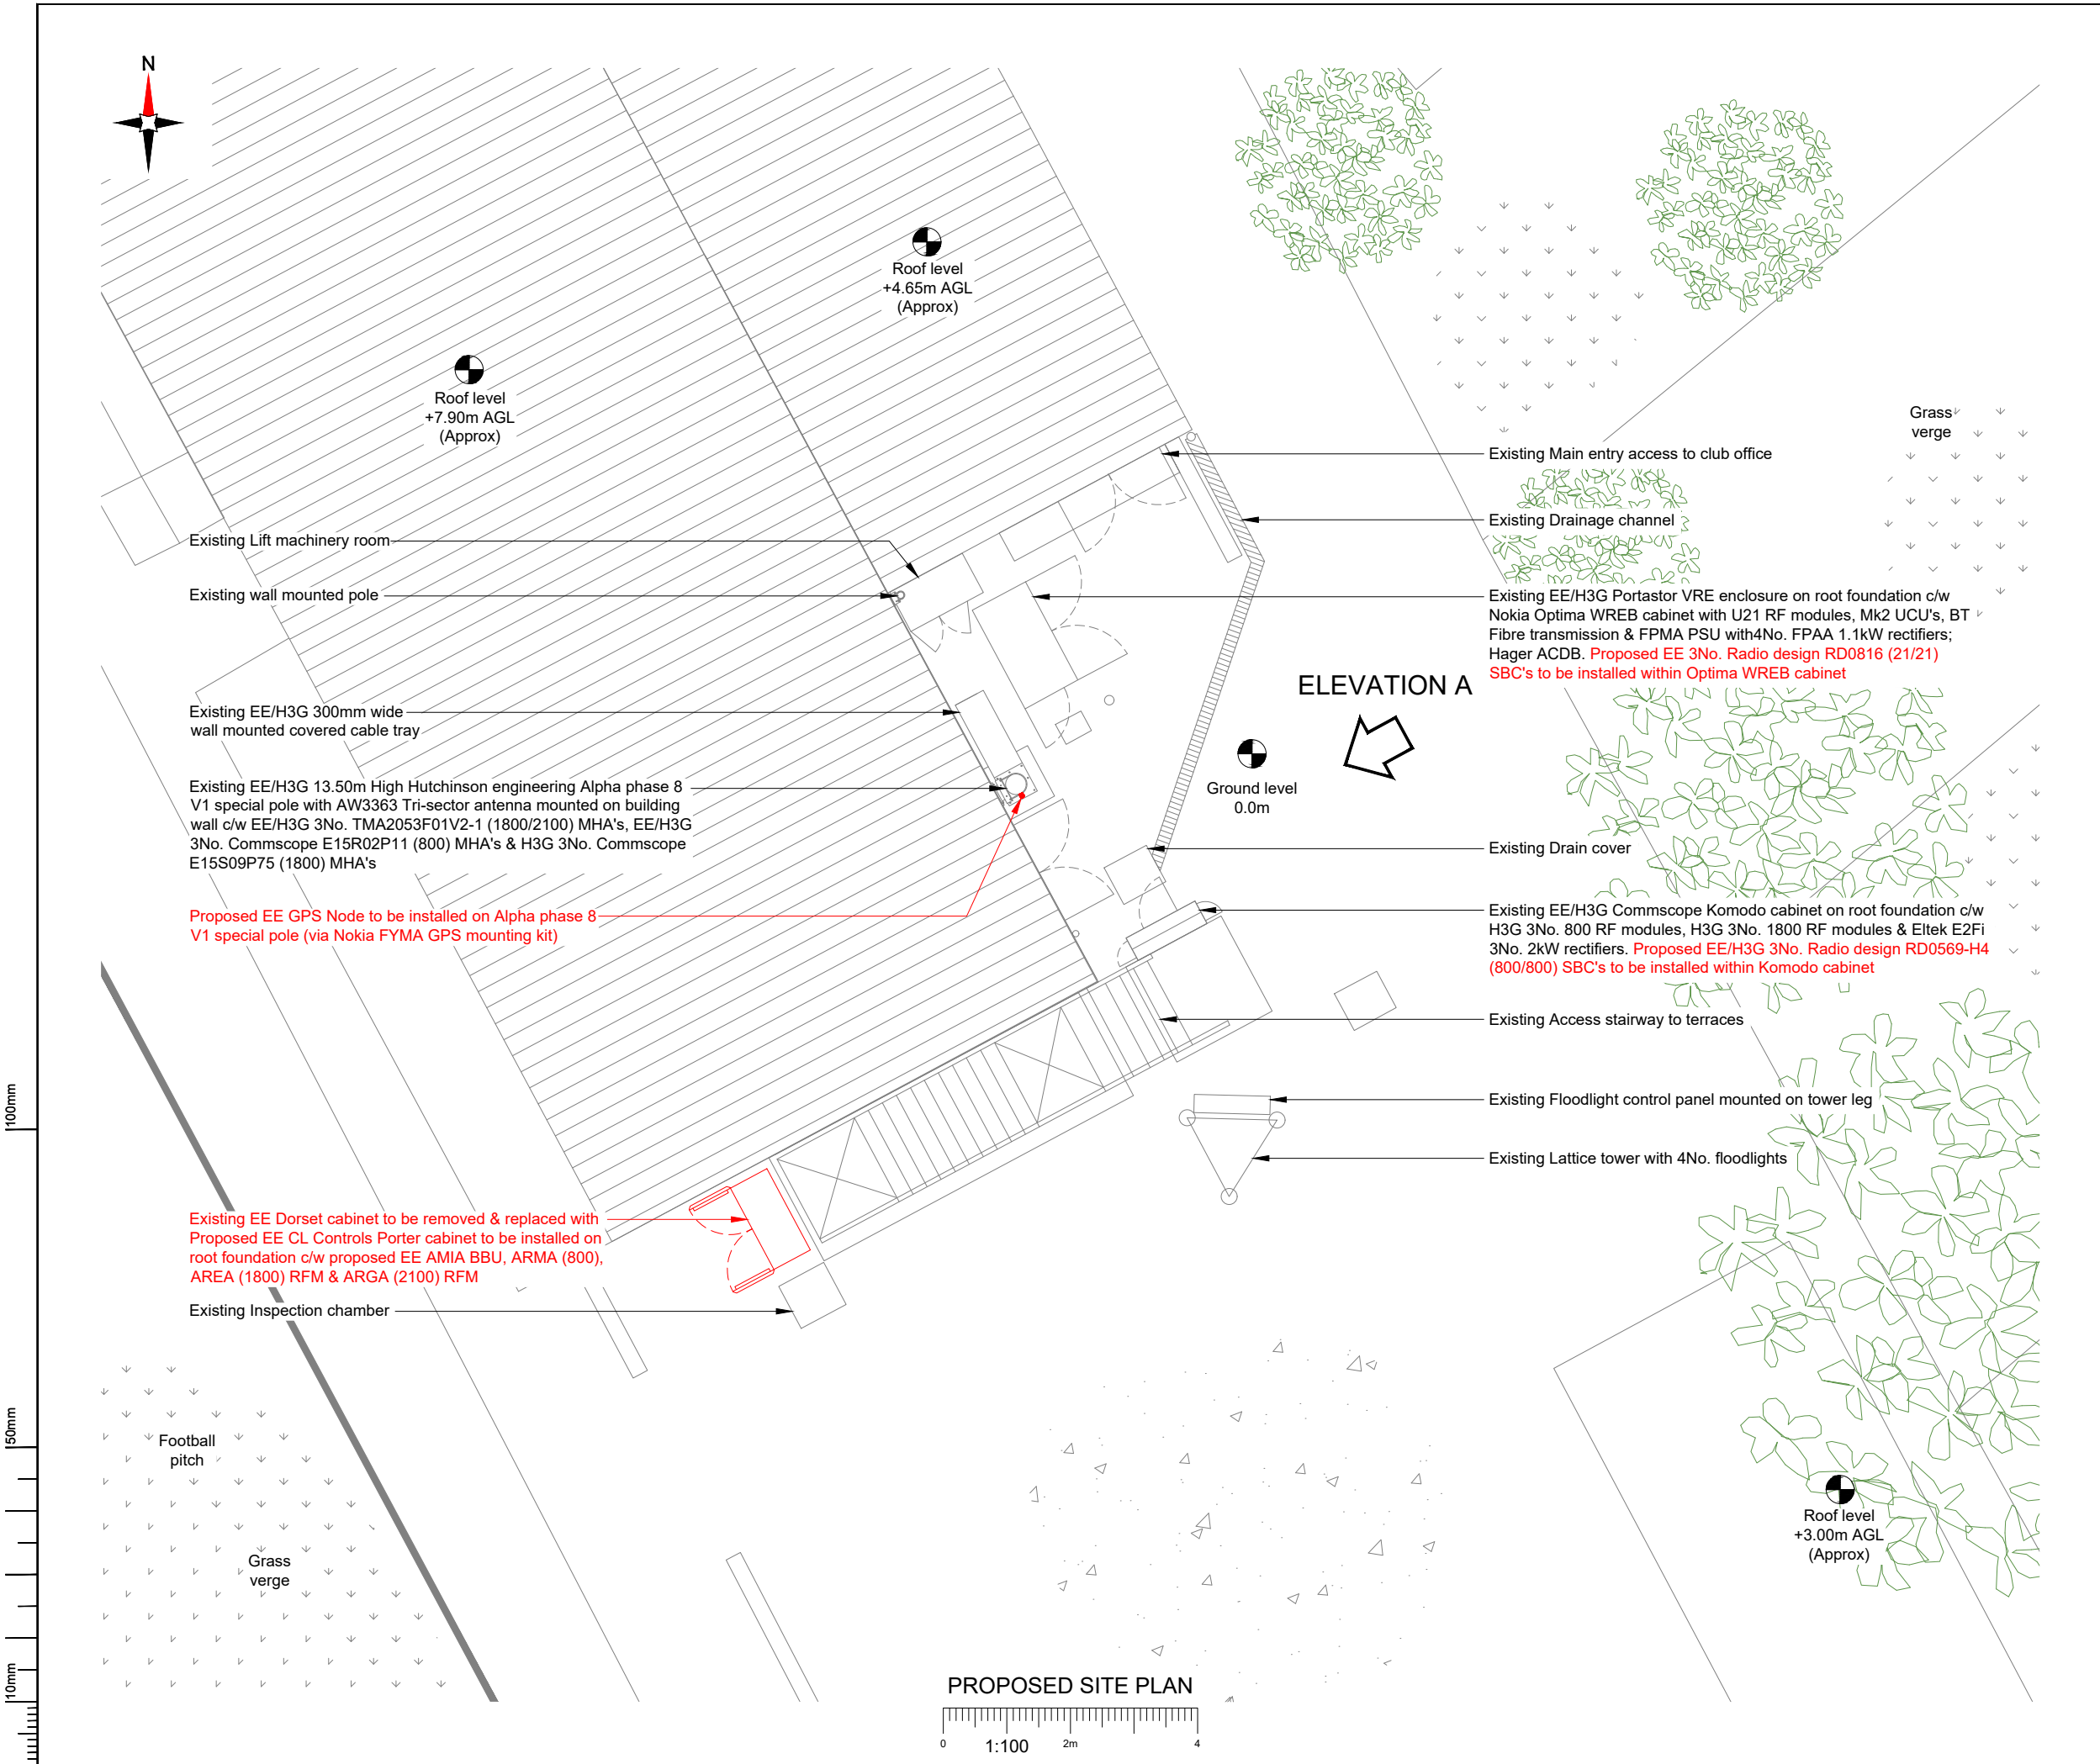

NOTES:

1. ALL DIMENSIONS IN MM UNLESS OTHERWISE NOTED.

Master:	MBNL / EE / H3G:	Project:	Purpose of Issue:	Issue:
M001	EE	Airscale	General Arrangement	A
Date:	18/06/2022	Revision / Upgrade Description:		
Drawn:	RMITHA	First Issue		
Checked:	MP			
Approved:	MP			



Hatfield Business Park  
Hatfield  
Hertfordshire  
AL10 9BW

Tel: 01707 315000  
Fax: 01707 319001

Design Consultant & Principal Contractor:

**waldon**  A part of **MG** Group Services

WALDON TELECOM  
PHOENIX HOUSE  
PYRFORD ROAD  
WEST BYFLEET  
SURREY  
KT14 6RA

TEL : 01932 411011  
FAX : 01932 411012

Site Name:  
BLYTH SPARTANS AFC 212654

Site ID:  
1104677

Address:  
BLYTH SPARTANS AFC  
CROFT PARK  
BLYTH  
NORTHUMBERLAND  
NE24 3JE

Title:  
150 PROPOSED SITE PLAN

Project:  
AIRSCALE

Purpose of Issue:  
GENERAL ARRANGEMENT


EE Cell ID: 24620	MBNL Cell ID: BLV015	3UK Cell ID: NE0137
----------------------	-------------------------	------------------------

Master Drawing No: 1104677_BLV015_24620_NE0137_M001	Issue: A
--	-------------

100mm

50mm

10mm

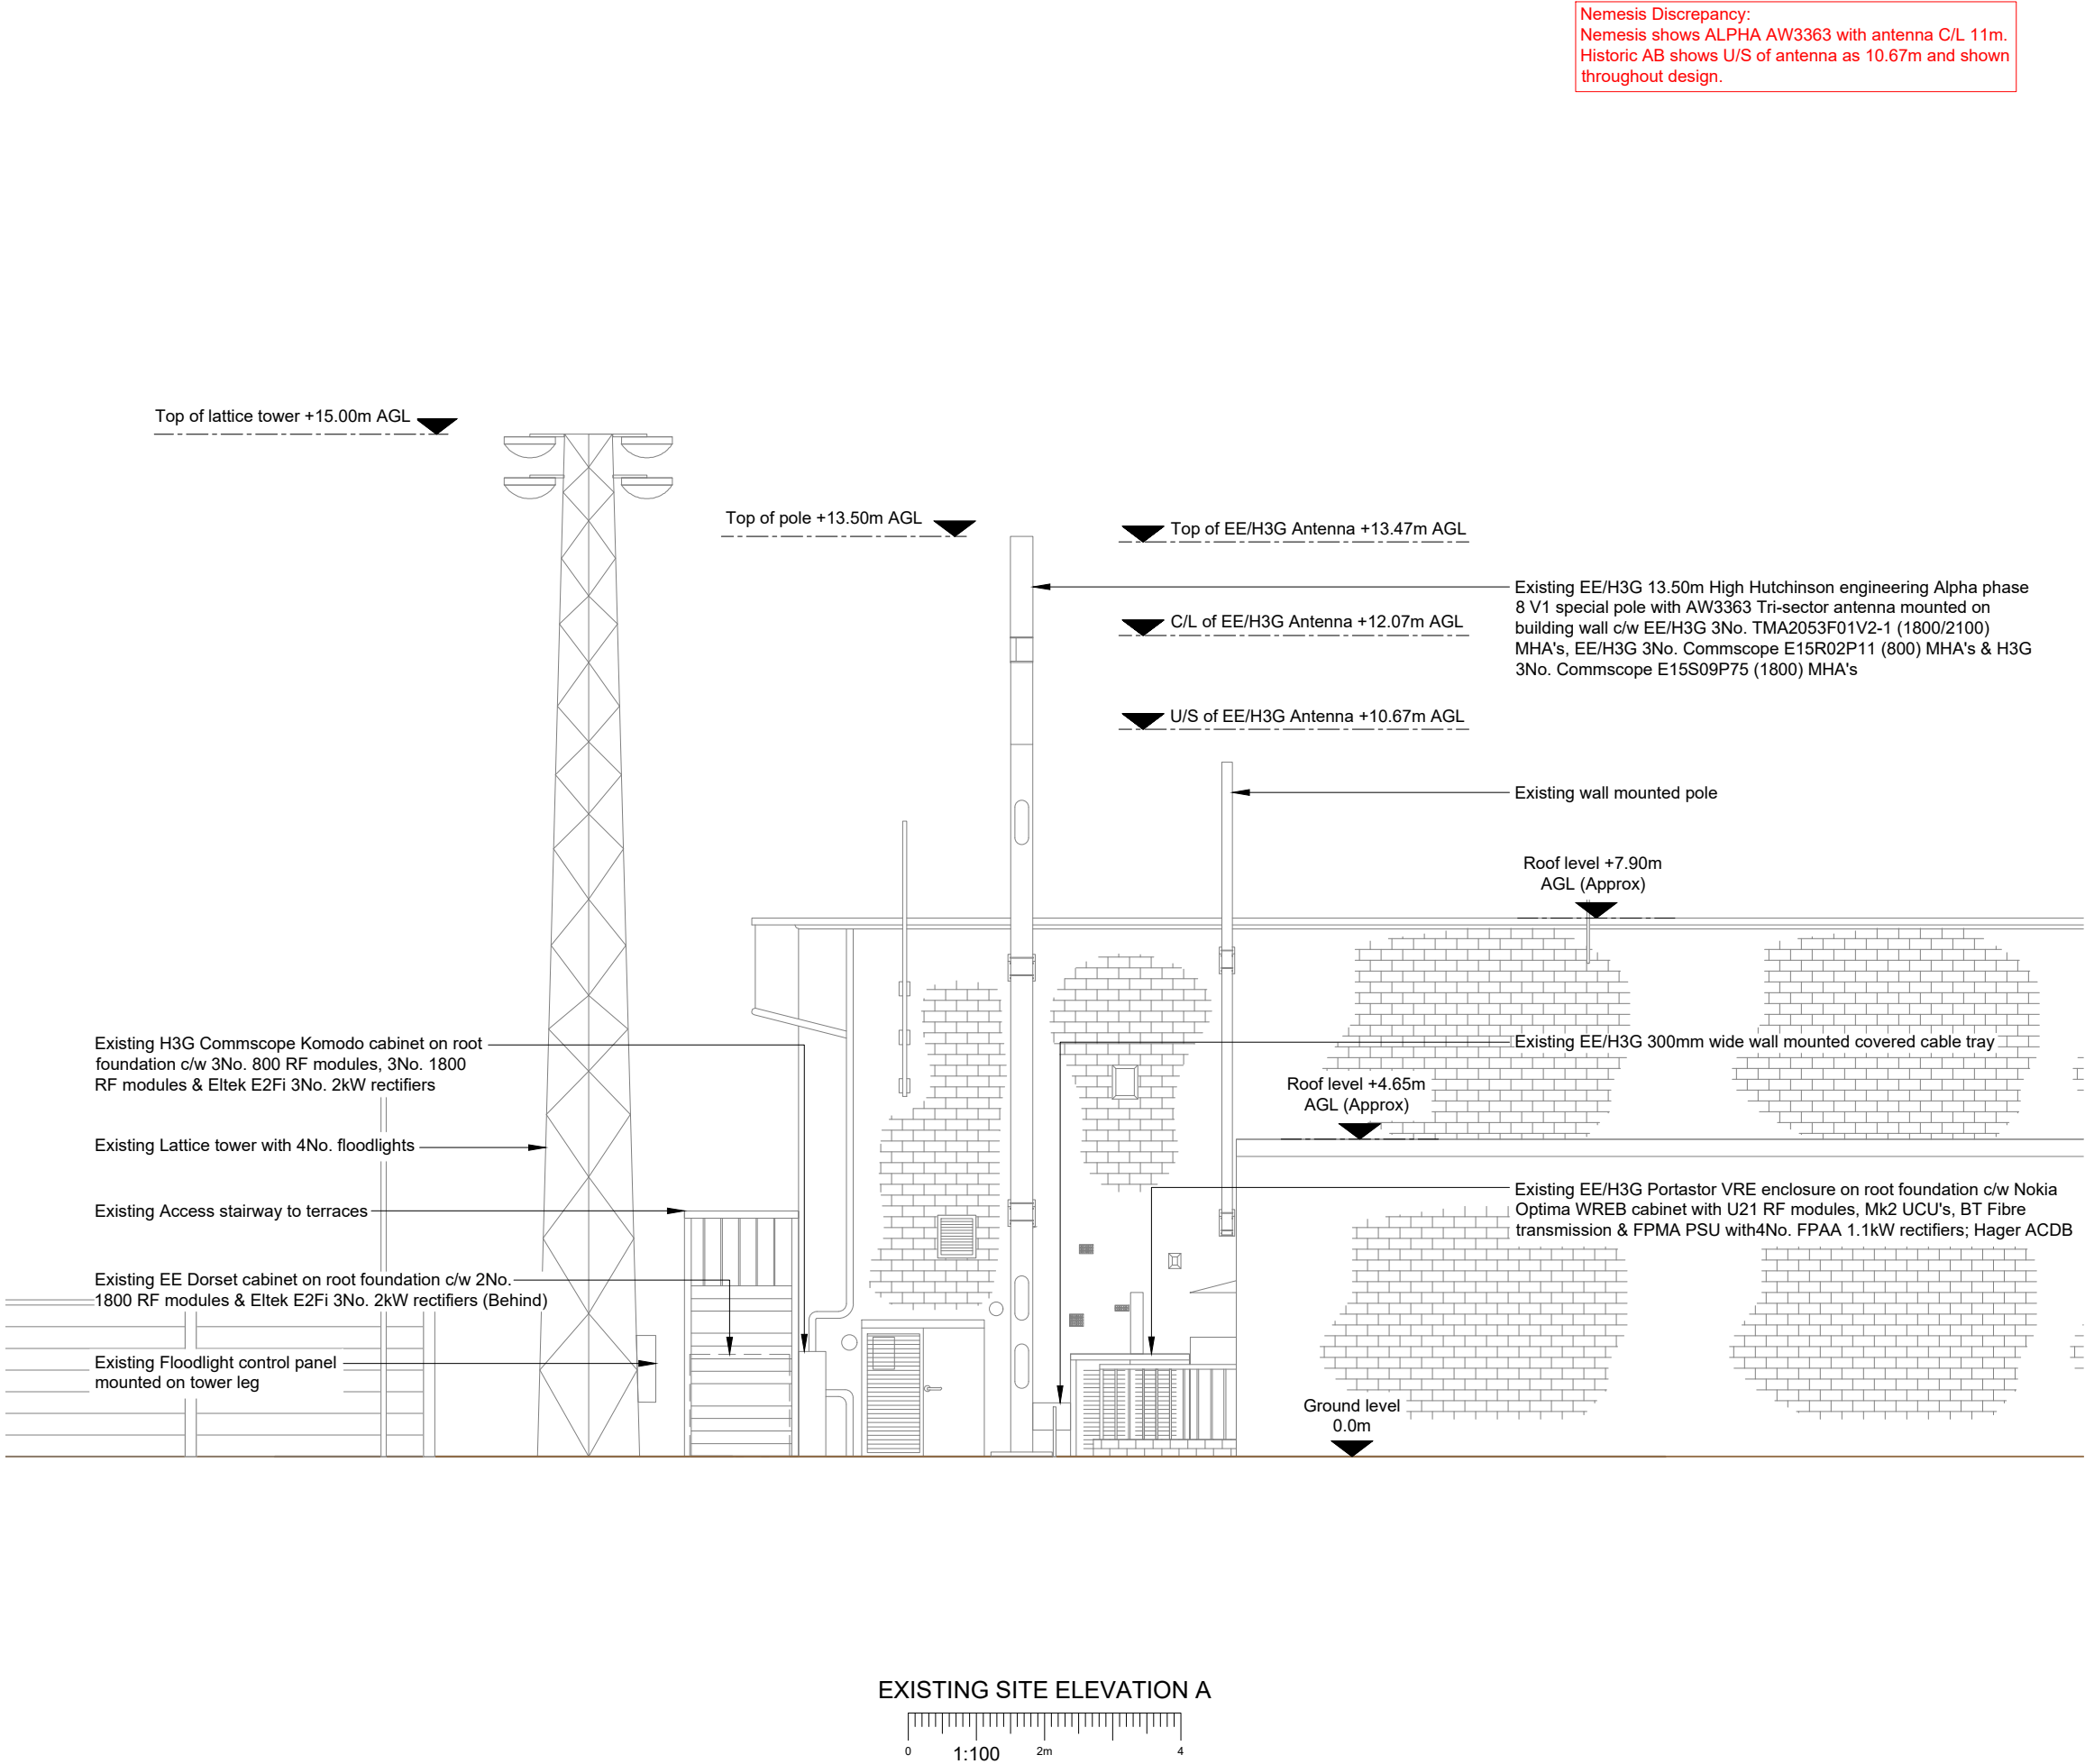

- NOTES:
1. ALL DIMENSIONS IN MM UNLESS OTHERWISE NOTED.

Master:	MBNL / EE / H3G:	Project:	Purpose of Issue:	Issue:
M001	EE	Airscale	General Arrangement	A
Date:	18/06/2022	Revision / Upgrade Description:		
Drawn:	RMITHA	First Issue		
Checked:	MP			
Approved:	MP			



Hatfield Business Park  
Hatfield  
Hertfordshire  
AL10 9BW

Tel: 01707 315000  
Fax: 01707 319001

Design Consultant & Principal Contractor:



A part of **MG**roupServices

WALDON TELECOM  
PHOENIX HOUSE  
PYRFORD ROAD  
WEST BYFLEET  
SURREY  
KT14 6RA


TEL : 01932 411011  
FAX : 01932 411012

Site Name:	BLYTH SPARTANS AFC 212654		
Site ID:	1104677		
Address:	BLYTH SPARTANS AFC CROFT PARK BLYTH NORTHUMBERLAND NE24 3JE		
Title:	200 EXISTING SITE ELEVATION A		
Project:	AIRSCALE		
Purpose of Issue:	GENERAL ARRANGEMENT		
EE Cell ID:	MBNL Cell ID:	3UK Cell ID:	
24620	BLV015	NE0137	
Master Drawing No:		Issue:	
1104677_BLV015_24620_NE0137_M001		A	

100mm

50mm

10mm

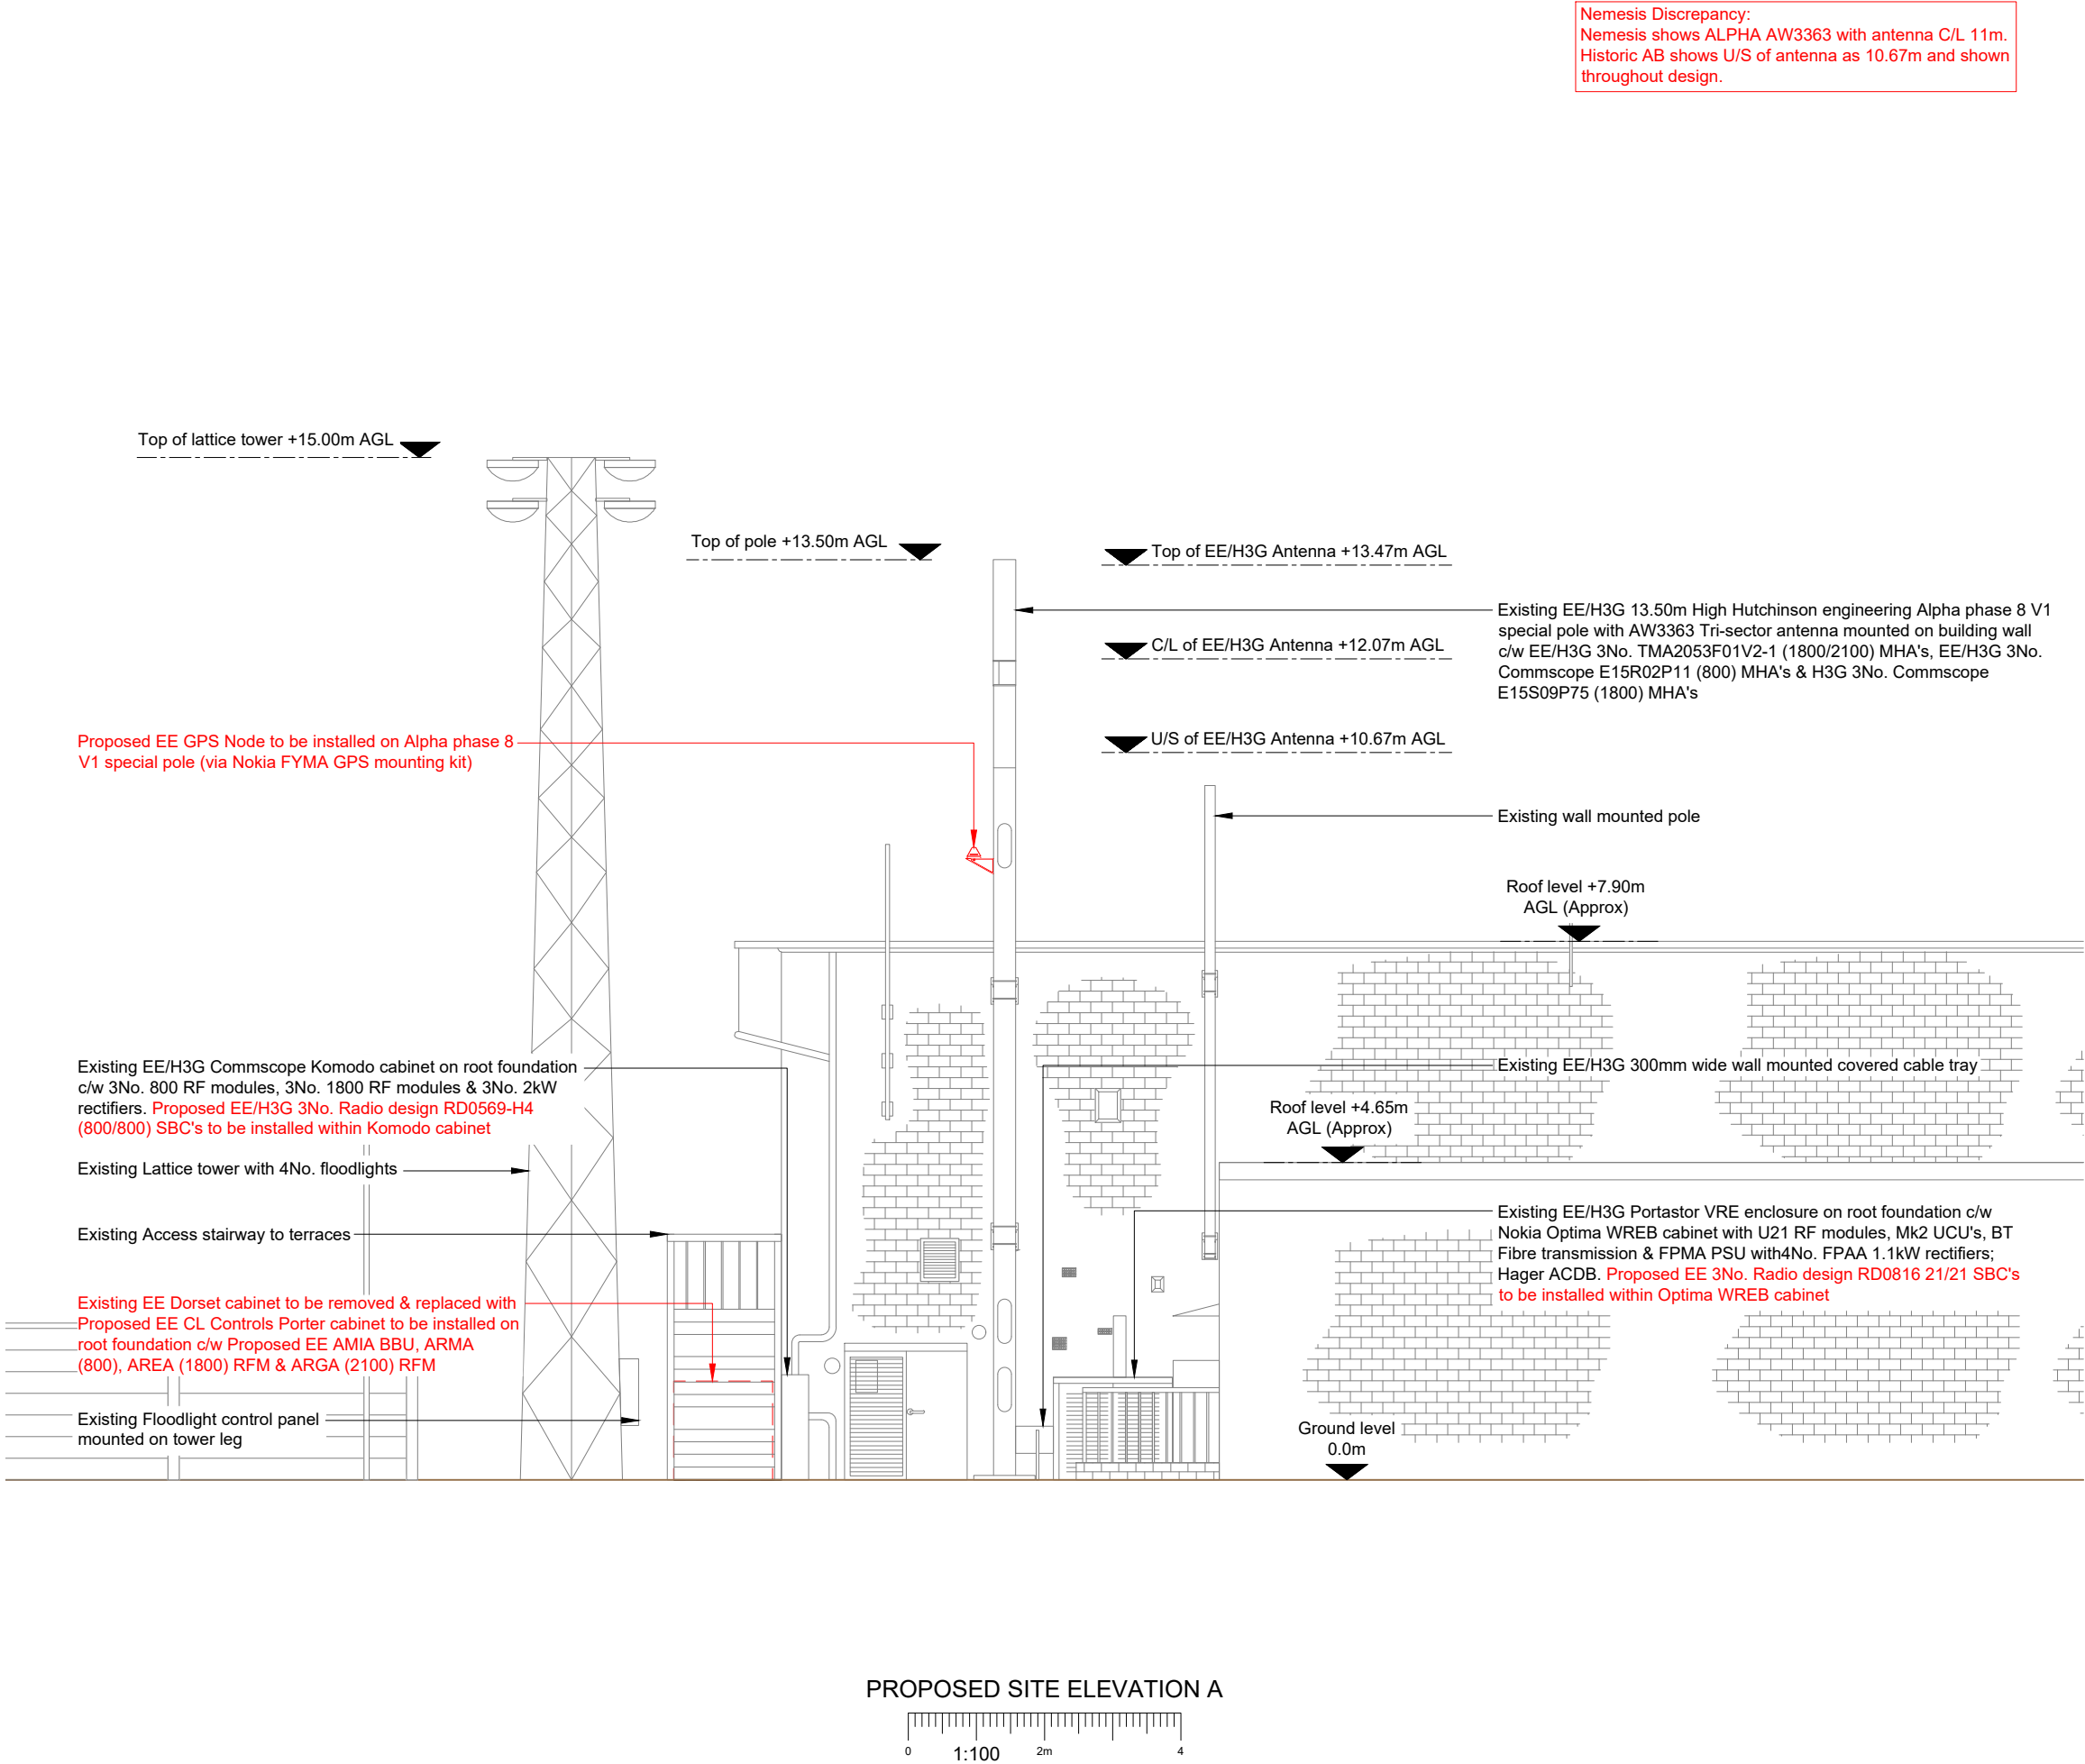

- NOTES:
- ALL DIMENSIONS IN MM UNLESS OTHERWISE NOTED.

Master:	MBNL / EE / H3G:	Project:	Purpose of Issue:	Issue:
M001	EE	Airscale	General Arrangement	A
Date:	18/06/2022	Revision / Upgrade Description:		
Drawn:	RMITHA	First Issue		
Checked:	MP			
Approved:	MP			



Hatfield Business Park  
Hatfield  
Hertfordshire  
AL10 9BW

Tel: 01707 315000  
Fax: 01707 319001

Design Consultant & Principal Contractor:



A part of **MG**roupServices

WALDON TELECOM  
PHOENIX HOUSE  
PYRFORD ROAD  
WEST BYFLEET  
SURREY  
KT14 6RA

TEL : 01932 411011  
FAX : 01932 411012

Site Name:  
BLYTH SPARTANS AFC 212654

Site ID:  
1104677

Address:  
BLYTH SPARTANS AFC  
CROFT PARK  
BLYTH  
NORTHUMBERLAND  
NE24 3JE

Title:  
250 PROPOSED SITE ELEVATION A

Project:  
AIRSCALE

Purpose of Issue:  
GENERAL ARRANGEMENT

EE Cell ID:	MBNL Cell ID:	3UK Cell ID:
24620	BLV015	NE0137

Master Drawing No:	Issue:
1104677_BLV015_24620_NE0137_M001	A