
 


3 LOCATION PLAN  
1:1  
11/20

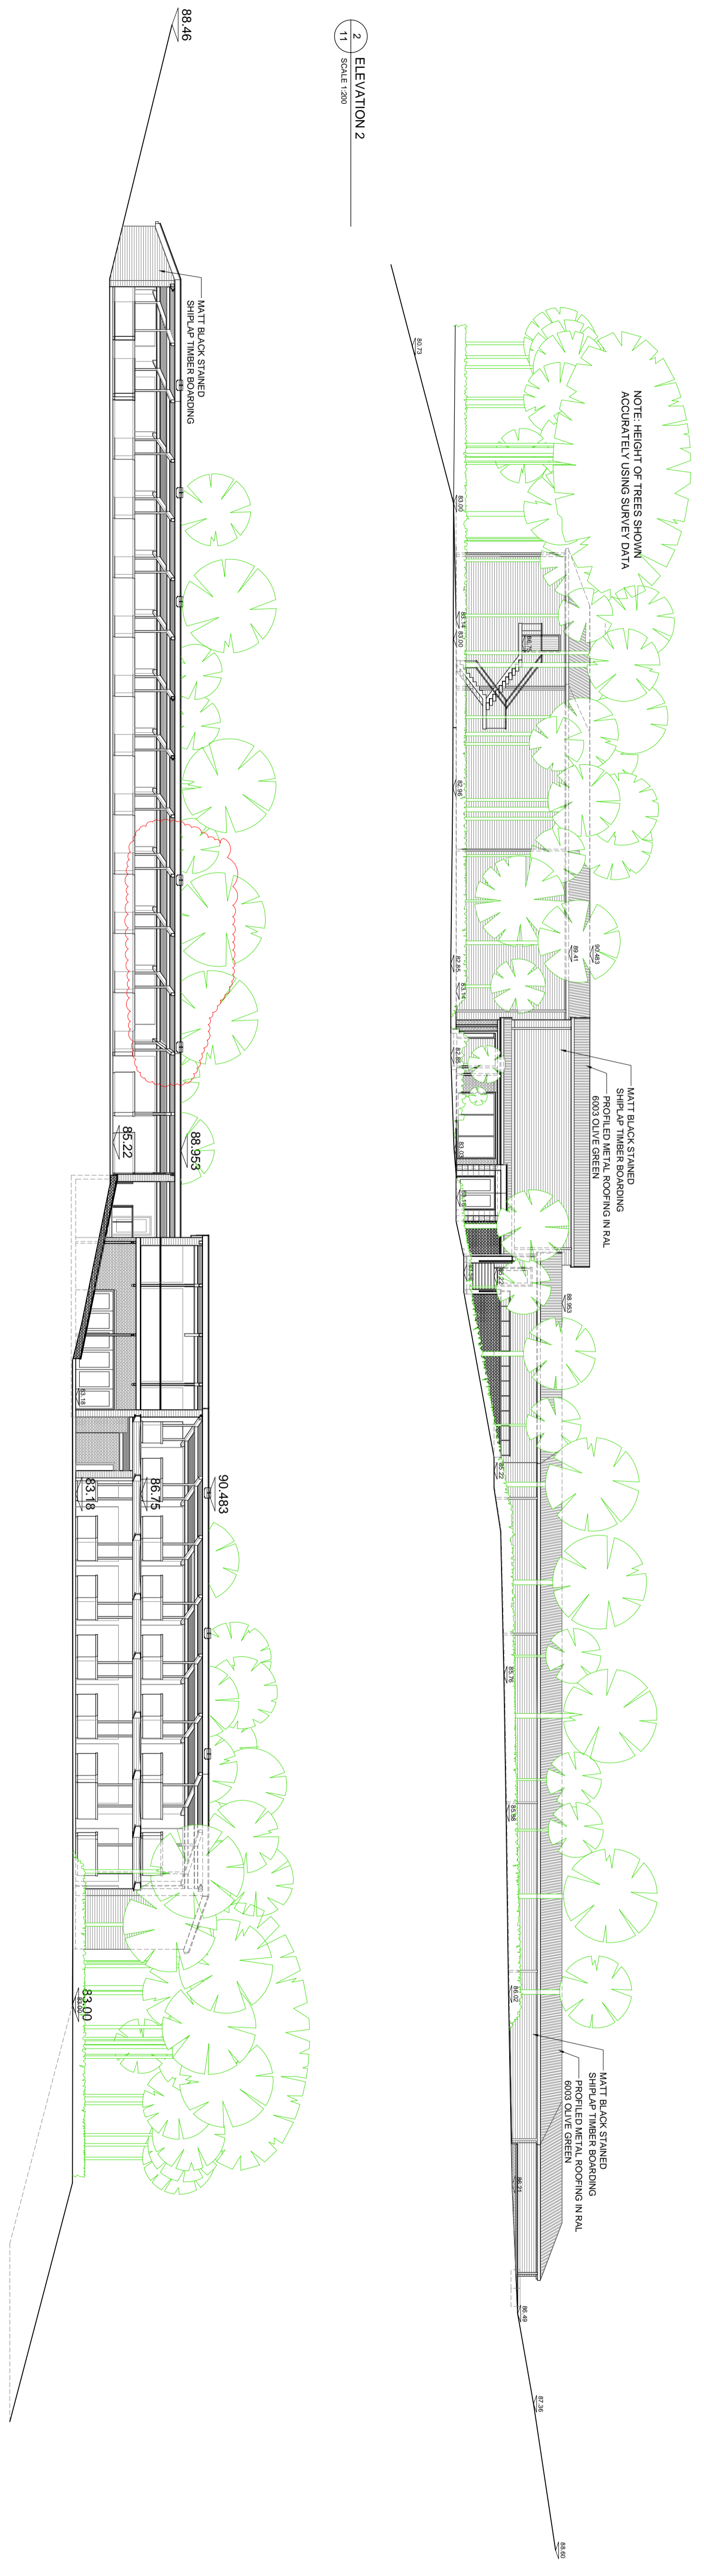

2 ELEVATION 2  
1:1  
SCALE 1:200

1 ELEVATION 1  
1:1  
SCALE 1:200



**COPYRIGHT:** © THIS DRAWING IS THE PROPERTY OF SPARCSTUDIO LTD AND MAY NOT BE REPRODUCED WITHOUT WRITTEN CONSENT.  
**DIMENSIONS:** FIGURED DIMENSIONS ONLY TO BE TAKEN, NO DIMENSIONS TO BE SCALED FROM THIS DRAWING. ALL DIMENSIONS TO BE CHECKED ON SITE.  
**NOTES:** THIS DRAWING IS PROVIDED ON THE UNDERSTANDING THAT THE CONTRACTOR/SUB CONTRACTOR WILL PRODUCE 'AS SHOWN' DRAWINGS IN A TIMELY MANNER, PRIOR TO MANUFACTURE AND FOR APPROVAL, WHICH ARE BASED ON SITE DIMENSIONS FOR CONSTRUCTION PURPOSES.  
**CONTRACTORS RESPONSIBILITIES:** IT IS THE CONTRACTOR & SUB CONTRACTOR'S RESPONSIBILITY TO CHECK THE ACCURACY AND BUILDABILITY OF ALL DIMENSIONS AND SPECIFICATIONS IDENTIFIED ON THIS DRAWING IN A TIMELY MANNER, IN ORDER TO MANAGE RISKS AND ASSISTANCE CAN BE REASONABLY GIVEN PRIOR TO CONSTRUCTION.  
 SPARCSTUDIO LTD ACCEPTS NO RESPONSIBILITY FOR ANY DELAYS TO PROGRAMME, ADDITIONAL COSTS ETC WHICH MAY BE INCURRED AS A RESULT OF UNTIMELY RESPONSES.

**ASSOCIATED INFORMATION:** THIS DRAWING IS TO BE READ IN CONJUNCTION WITH ALL RELEVANT AND ASSOCIATED DRAWINGS AND SPECIFICATIONS PRODUCED BY SPARCSTUDIO AND THE PROJECT CONSULTANT DESIGN TEAM.  
**T** REFERENCES INDICATE TRESHOLD CONDITIONS - REFER TO TRESHOLD DRAWING FOR DETAILS.  
**SW** REFERENCES INDICATE SANITARYWARE ITEMS - REFER TO RELEVANT SANITARYWARE SCHEDULE FOR DETAILS.  
**FR** REFERENCES INDICATE FIXTURE & FITTINGS - REFER TO RELEVANT FIXTURE & FITTINGS SCHEDULE FOR DETAILS.  
 ALL LOCATIONS OF ACCESS MATCHES/PANELS IN FRONT OF HOUSE AREAS TO BE SET-OUT & COORDINATED WITH REFLECTED CEILING & LIGHTING PLANS AND APPROVED PRIOR TO INSTALLATION.

REV	B	DISCREPANCY FOR DATE OF REVISION REFER TO ISSUE SHEET
		REV B FLOODLIGHTS AMENDED IN ACCORDANCE WITH EXED PROPOSALS
		REV A TREE LINE AMENDED TO REFLECT TREE SURVEY. DRAWING RENAMED 1 OF 3

**SPARCSTUDIO**  
DESIGN CONSULTANTS

CLIENT NAME: CLUB COMPANY  
 PROJECT NAME: WARWICKSHIRE STRIKE SHACK DRIVING RANGE  
 DRAWING TITLE: PROPOSED ELEVATIONS (1 OF 3)  
 PROJECT NO: 3090  
 DRAWING NO: 11  
 SCALES: 1:200 @ A1

20 WATER LAKE  
 80 CHAMOND LONDON, TW9 1TT  
 TELEPHONE: +44(0)203 637 5997  
 EMAIL: studio@sparcstudio.co.uk

DATE DEC: 15.07.2022  
 DRAWN BY: TH  
 CHECKED BY: ...

STATUS: PLANNING