
 


3 LOCATION PLAN
1:1
11/18

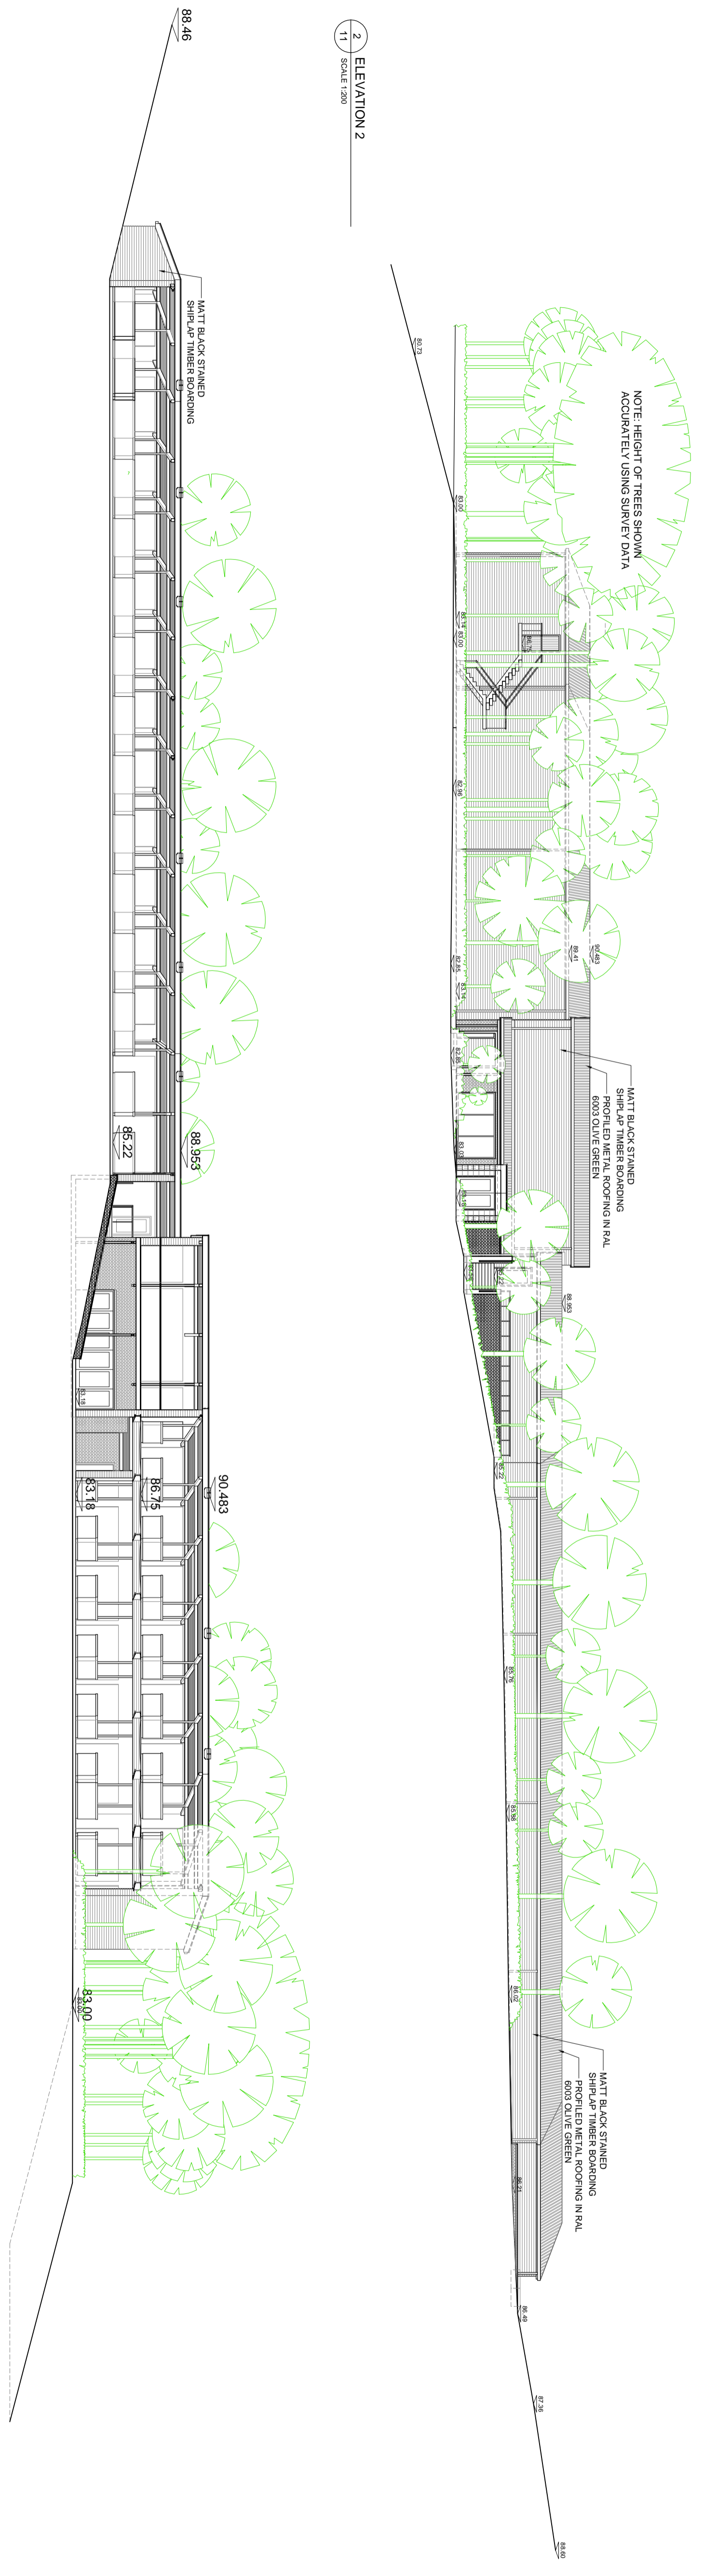

2 ELEVATION 2
1:1
11/18

1 ELEVATION 1
1:1
11/18



COPYRIGHT: © THIS DRAWING IS THE PROPERTY OF SPARCSTUDIO LTD AND MAY NOT BE REPRODUCED WITHOUT WRITTEN CONSENT.
DIMENSIONS: FIGURED DIMENSIONS ONLY TO BE TAKEN, NO DIMENSIONS TO BE SCALED FROM THIS DRAWING. ALL DIMENSIONS TO BE CHECKED ON THE DRAWING.
NOTES: THIS DRAWING IS PROVIDED ON THE UNDERSTANDING THAT THE CONTRACTOR/SUB CONTRACTOR WILL PRODUCE 'AS SHOWN' DRAWINGS IN A TIMELY MANNER, PRIOR TO MANUFACTURE AND FOR APPROVAL, WHICH ARE BASED ON SITE DIMENSIONS FOR CONSTRUCTION PURPOSES.
CONTRACTORS RESPONSIBILITIES: IT IS THE CONTRACTOR & SUB CONTRACTOR'S RESPONSIBILITY TO CHECK THE ACCURACY AND BUILDABILITY OF ALL DIMENSIONS AND SPECIFICATIONS IDENTIFIED ON THIS DRAWING IN A TIMELY MANNER, IN ORDER TO MANAGE RISKS AND ASSISTANCE CAN BE REASONABLY GIVEN PRIOR TO CONSTRUCTION.
 SPARCSTUDIO LTD ACCEPTS NO RESPONSIBILITY FOR ANY DELAYS TO PROGRAMME, ADDITIONAL COSTS ETC WHICH MAY BE INCURRED AS A RESULT OF UNTIMELY RESPONSES.

ASSOCIATED INFORMATION: THIS DRAWING IS TO BE READ IN CONJUNCTION WITH ALL RELEVANT AND ASSOCIATED DRAWINGS AND SPECIFICATIONS PRODUCED BY SPARCSTUDIO AND THE PROJECT CONSULTANT DESIGN TEAM.
TR REFERENCES INDICATE THRESHOLD CONDITIONS - REFER TO THRESHOLD DRAWING FOR DETAILS.
FW REFERENCES INDICATE FIXTURE & FITTINGS - REFER TO RELEVANT SANITARYWARE SCHEDULE FOR DETAILS.
FR REFERENCES INDICATE FIXTURE & FITTINGS - REFER TO RELEVANT SANITARYWARE SCHEDULE FOR DETAILS.
 ALL LOCATIONS OF ACCESS MATCHES/PANELS IN FRONT OF HOUSE AREAS TO BE SET-OUT & COORDINATED WITH REFLECTED CEILING & LIGHTING PLANS AND APPROVED PRIOR TO INSTALLATION.

DESCRIPTION: FOR DATE OF REVISION REFER TO ISSUE SHEET	REV	A
REV A THE LINE AMENDED TO REFLECT TREE SURVEY. DRAWING REMOVED 1 OF 3		
SPARCSTUDIO DESIGN CONSULTANTS	20 WATER LAKE ROCHAMOND LONDON, TW9 1JJ TELEPHONE: +44(0)203 637 5997 EMAIL: studio@sparcstudio.co.uk	
CLIENT NAME: CLUB COMPANY	PROJECT NAME: WARWICKSHIRE STRIKE SHACK DRIVING RANGE	
DRAWING TITLE: PROPOSED ELEVATIONS (1 OF 3)	PROJECT NO: 3090	DRAWING NO: 11
SCALES: 1:200 @ A1	STATUS: PLANNING	DATE/DESC: 16.12.21
	DRAWN BY: TH	CHECKED BY: ...