




1 ELEVATION 1
03 SCALE 1:100
Datum: 80.00m

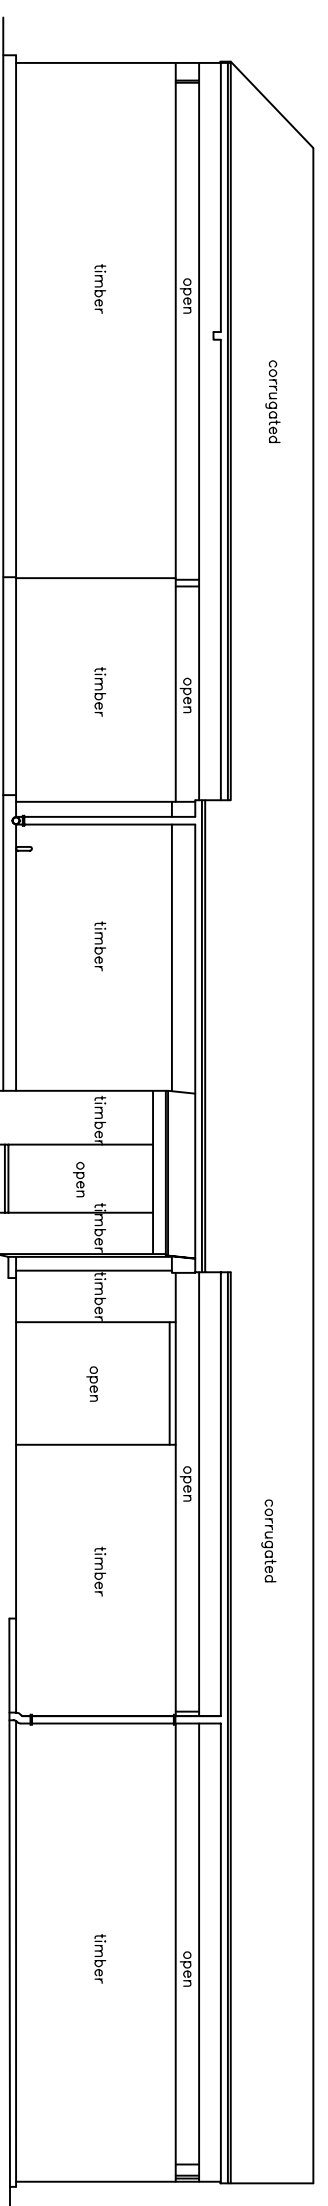


2 ELEVATION 2
03 SCALE 1:100
Datum: 80.00m

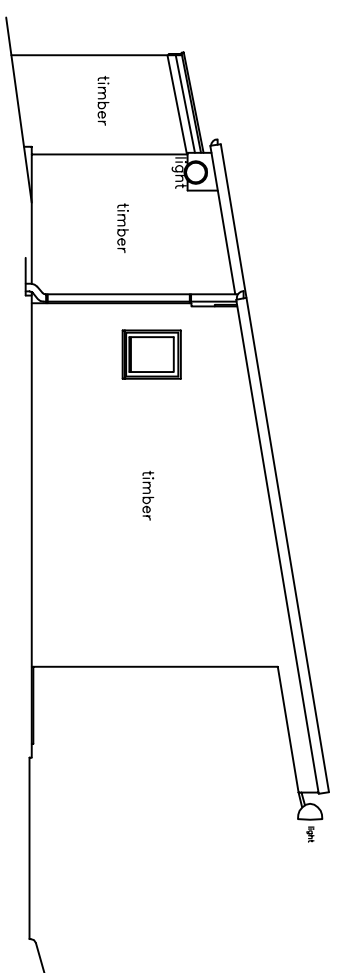


3 ELEVATION 3
03 SCALE 1:100
Datum: 80.00m

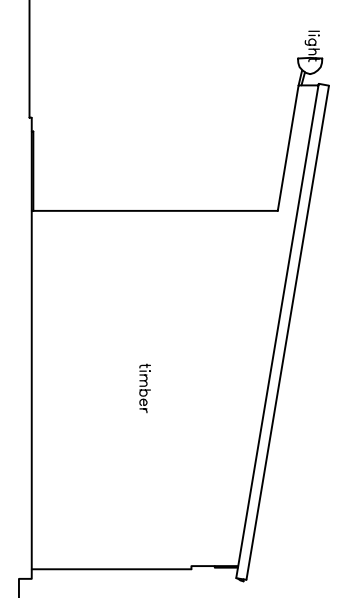

4 ELEVATION 4
03 SCALE 1:100
Datum: 80.00m

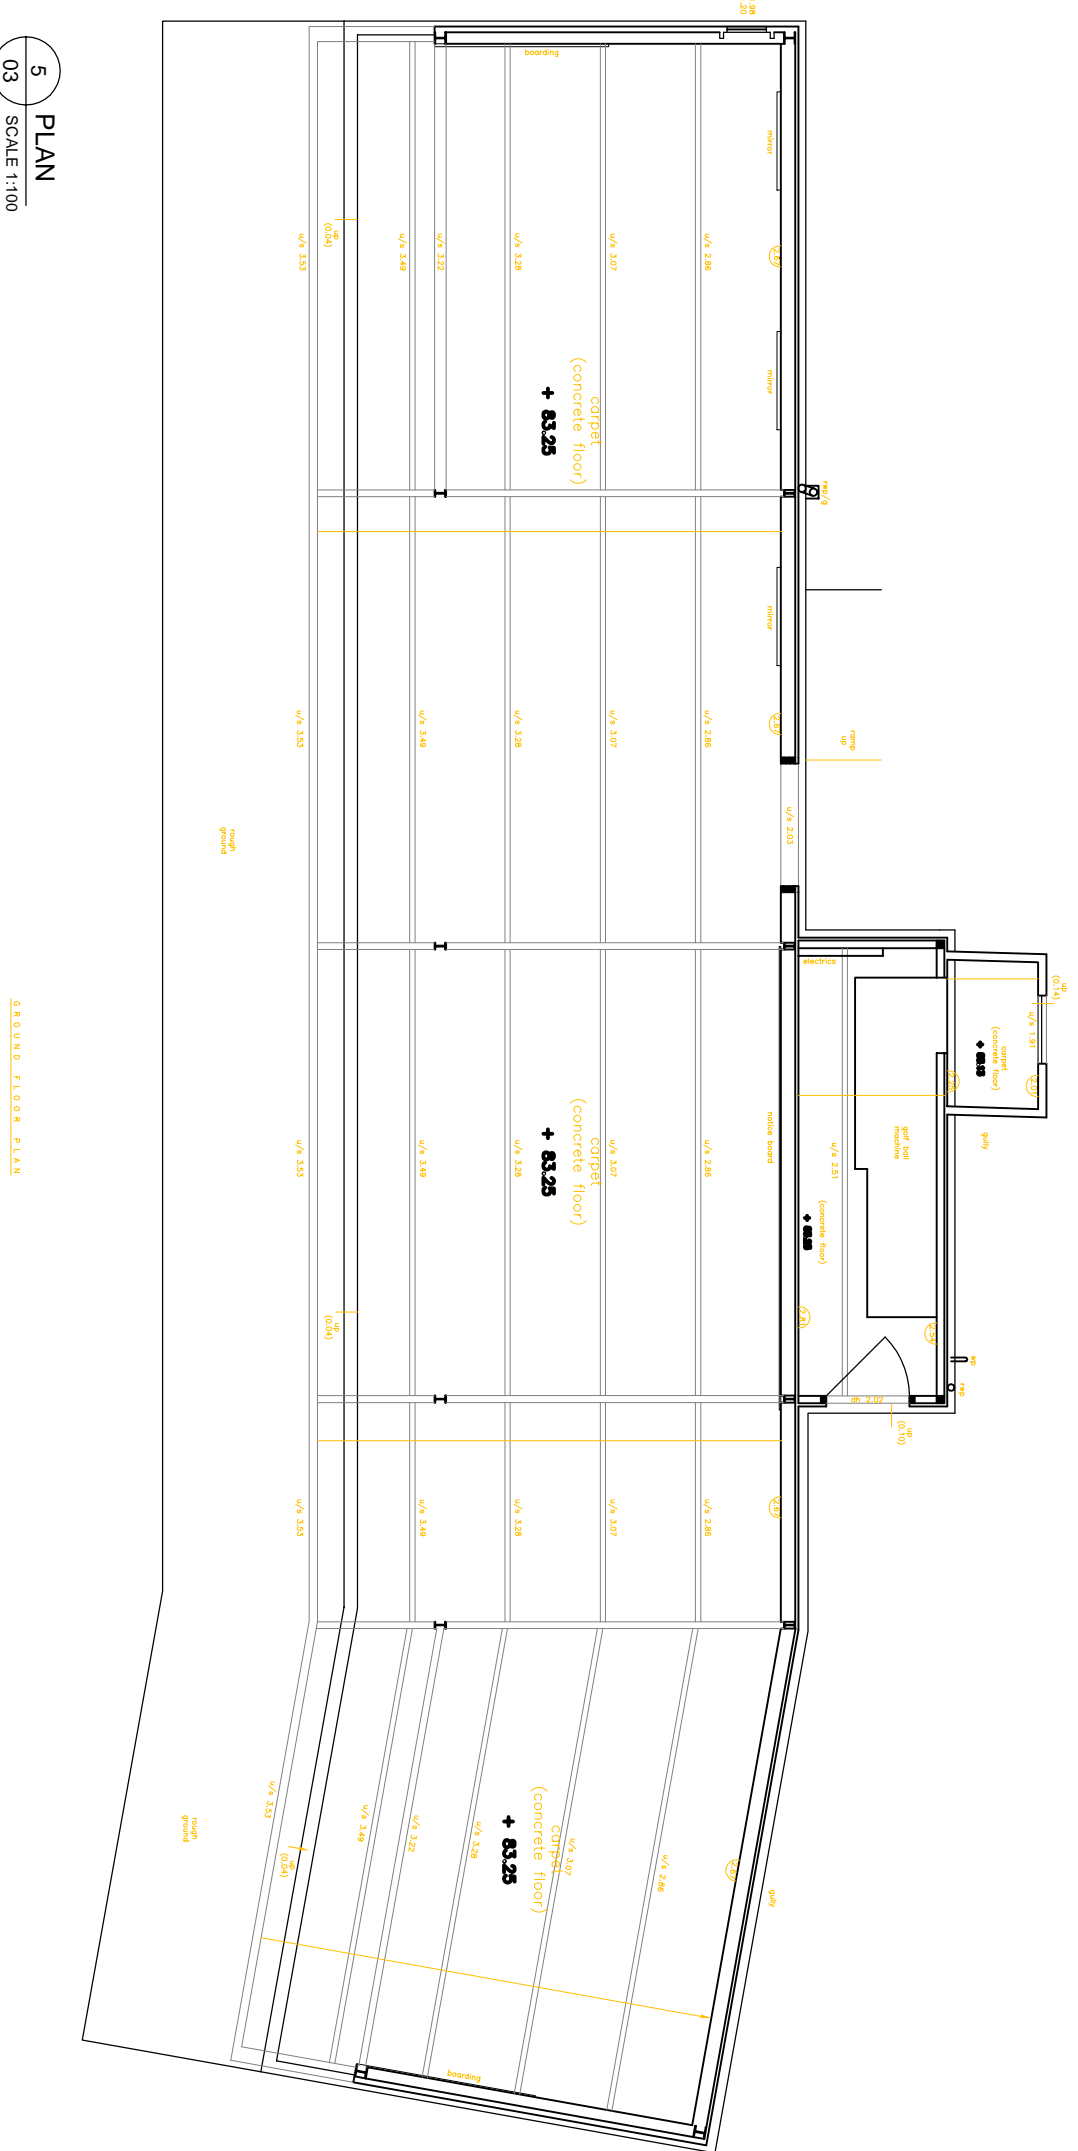

5 PLAN
03 SCALE 1:100

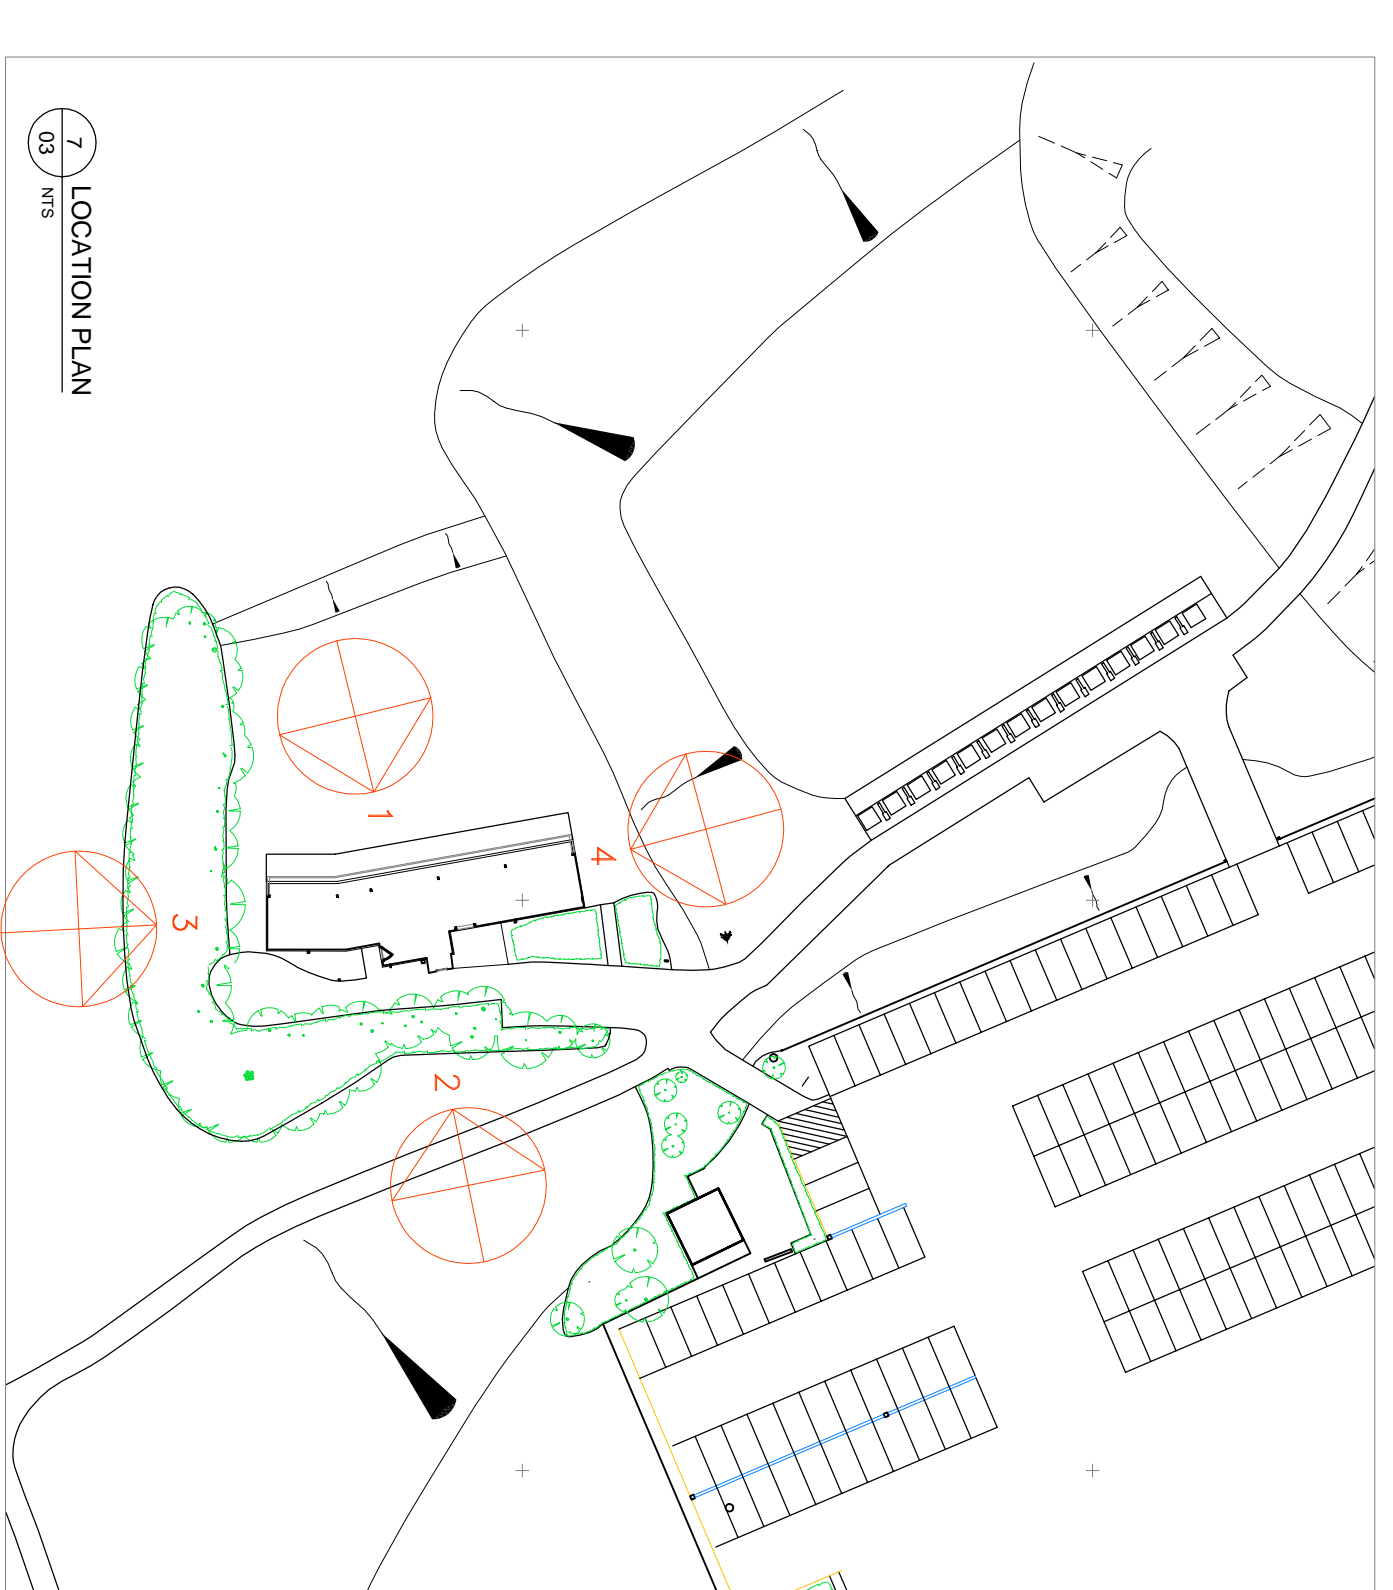

7 LOCATION PLAN
03 NTS

COPYRIGHT ©: THIS DRAWING IS THE PROPERTY OF SPARCSTUDIO LTD AND MAY NOT BE REPRODUCED WITHOUT WRITTEN CONSENT.
DIMENSIONS: FIGURED DIMENSIONS ONLY TO BE TAKEN, NO DIMENSIONS TO BE SCALED FROM THIS DRAWING. ALL DIMENSIONS TO BE CHECKED ON THE DRAWING.
RODS: THIS DRAWING IS PROVIDED ON THE UNDERSTANDING THAT THE CONTRACTOR/SUB CONTRACTOR WILL PRODUCE 'ROD-SHOP DRAWINGS' IN A TIMELY MANNER, PRIOR TO MANUFACTURE AND FOR APPROVAL, WHICH ARE BASED ON SITE DIMENSIONS FOR CONSTRUCTION PURPOSES.
CONTRACTORS RESPONSIBILITIES: IT IS THE CONTRACTOR & SUB CONTRACTOR'S RESPONSIBILITY TO CHECK THE ACCURACY AND BUILDABILITY OF ALL DIMENSIONS AND DIMENSIONS IDENTIFIED ON THIS DRAWING IN A TIMELY MANNER, IN ORDER THAN RESPONSES AND ASSISTANCE CAN BE REASONABLY GIVEN PRIOR TO CONSTRUCTION.
 SPARCSTUDIO LTD ACCEPTS NO RESPONSIBILITY FOR ANY DELAYS TO PROGRAMME, ADDITIONAL COSTS ETC WHICH MAY BE INCURRED AS A RESULT OF UNTIMELY RESPONSES.

ASSOCIATED INFORMATION: THIS DRAWING IS TO BE READ IN CONJUNCTION WITH ALL RELEVANT AND ASSOCIATED DRAWINGS AND SPECIFICATIONS PRODUCED BY SPARCSTUDIO AND THE PROJECT CONSULTANT DESIGN TEAM.
TR REFERENCES INDICATE TRESHOLD CONDITIONS - REFER TO TRESHOLD DRAWING FOR DETAILS.
SM REFERENCES INDICATE SANITARYWARE ITEMS - REFER TO RELEVANT SANITARYWARE SCHEDULE FOR DETAILS.
FR REFERENCES INDICATE FIXTURE & FITTINGS - REFER TO RELEVANT FIXTURE & FITTINGS SCHEDULE FOR DETAILS.
 ALL LOCATIONS OF ACCESS MATCHES/PANELS IN FRONT OF HOUSE AREAS TO BE SET-OUT & COORDINATED WITH REFLECTED CEILING & LIGHTING PLANS AND APPROVED PRIOR TO INSTALLATION.

REV	DESCRIPTION	FOR DATE OF REVISION REFER TO ISSUE SHEET

SPARCSTUDIO	20 WATER LAKE
DESIGN CONSULTANTS	ROCHAMOND LONDON TW9 1TT
CLIENT NAME	CLUBB COMPANY
PROJECT NAME	WARWICKSHIRE STRIKE SHACK DRIVING RANGE
DRAWING TITLE	EXISTING DRIVING RANGE ELEVATIONS AND PLAN
PROJECT NO.	3090
DRAWING NO.	03
SCALES	1:100 @ A1
STATUS	PLANNING
DATE/DESC	17/12/21
DRAWN BY	TH
CHECKED BY	...