
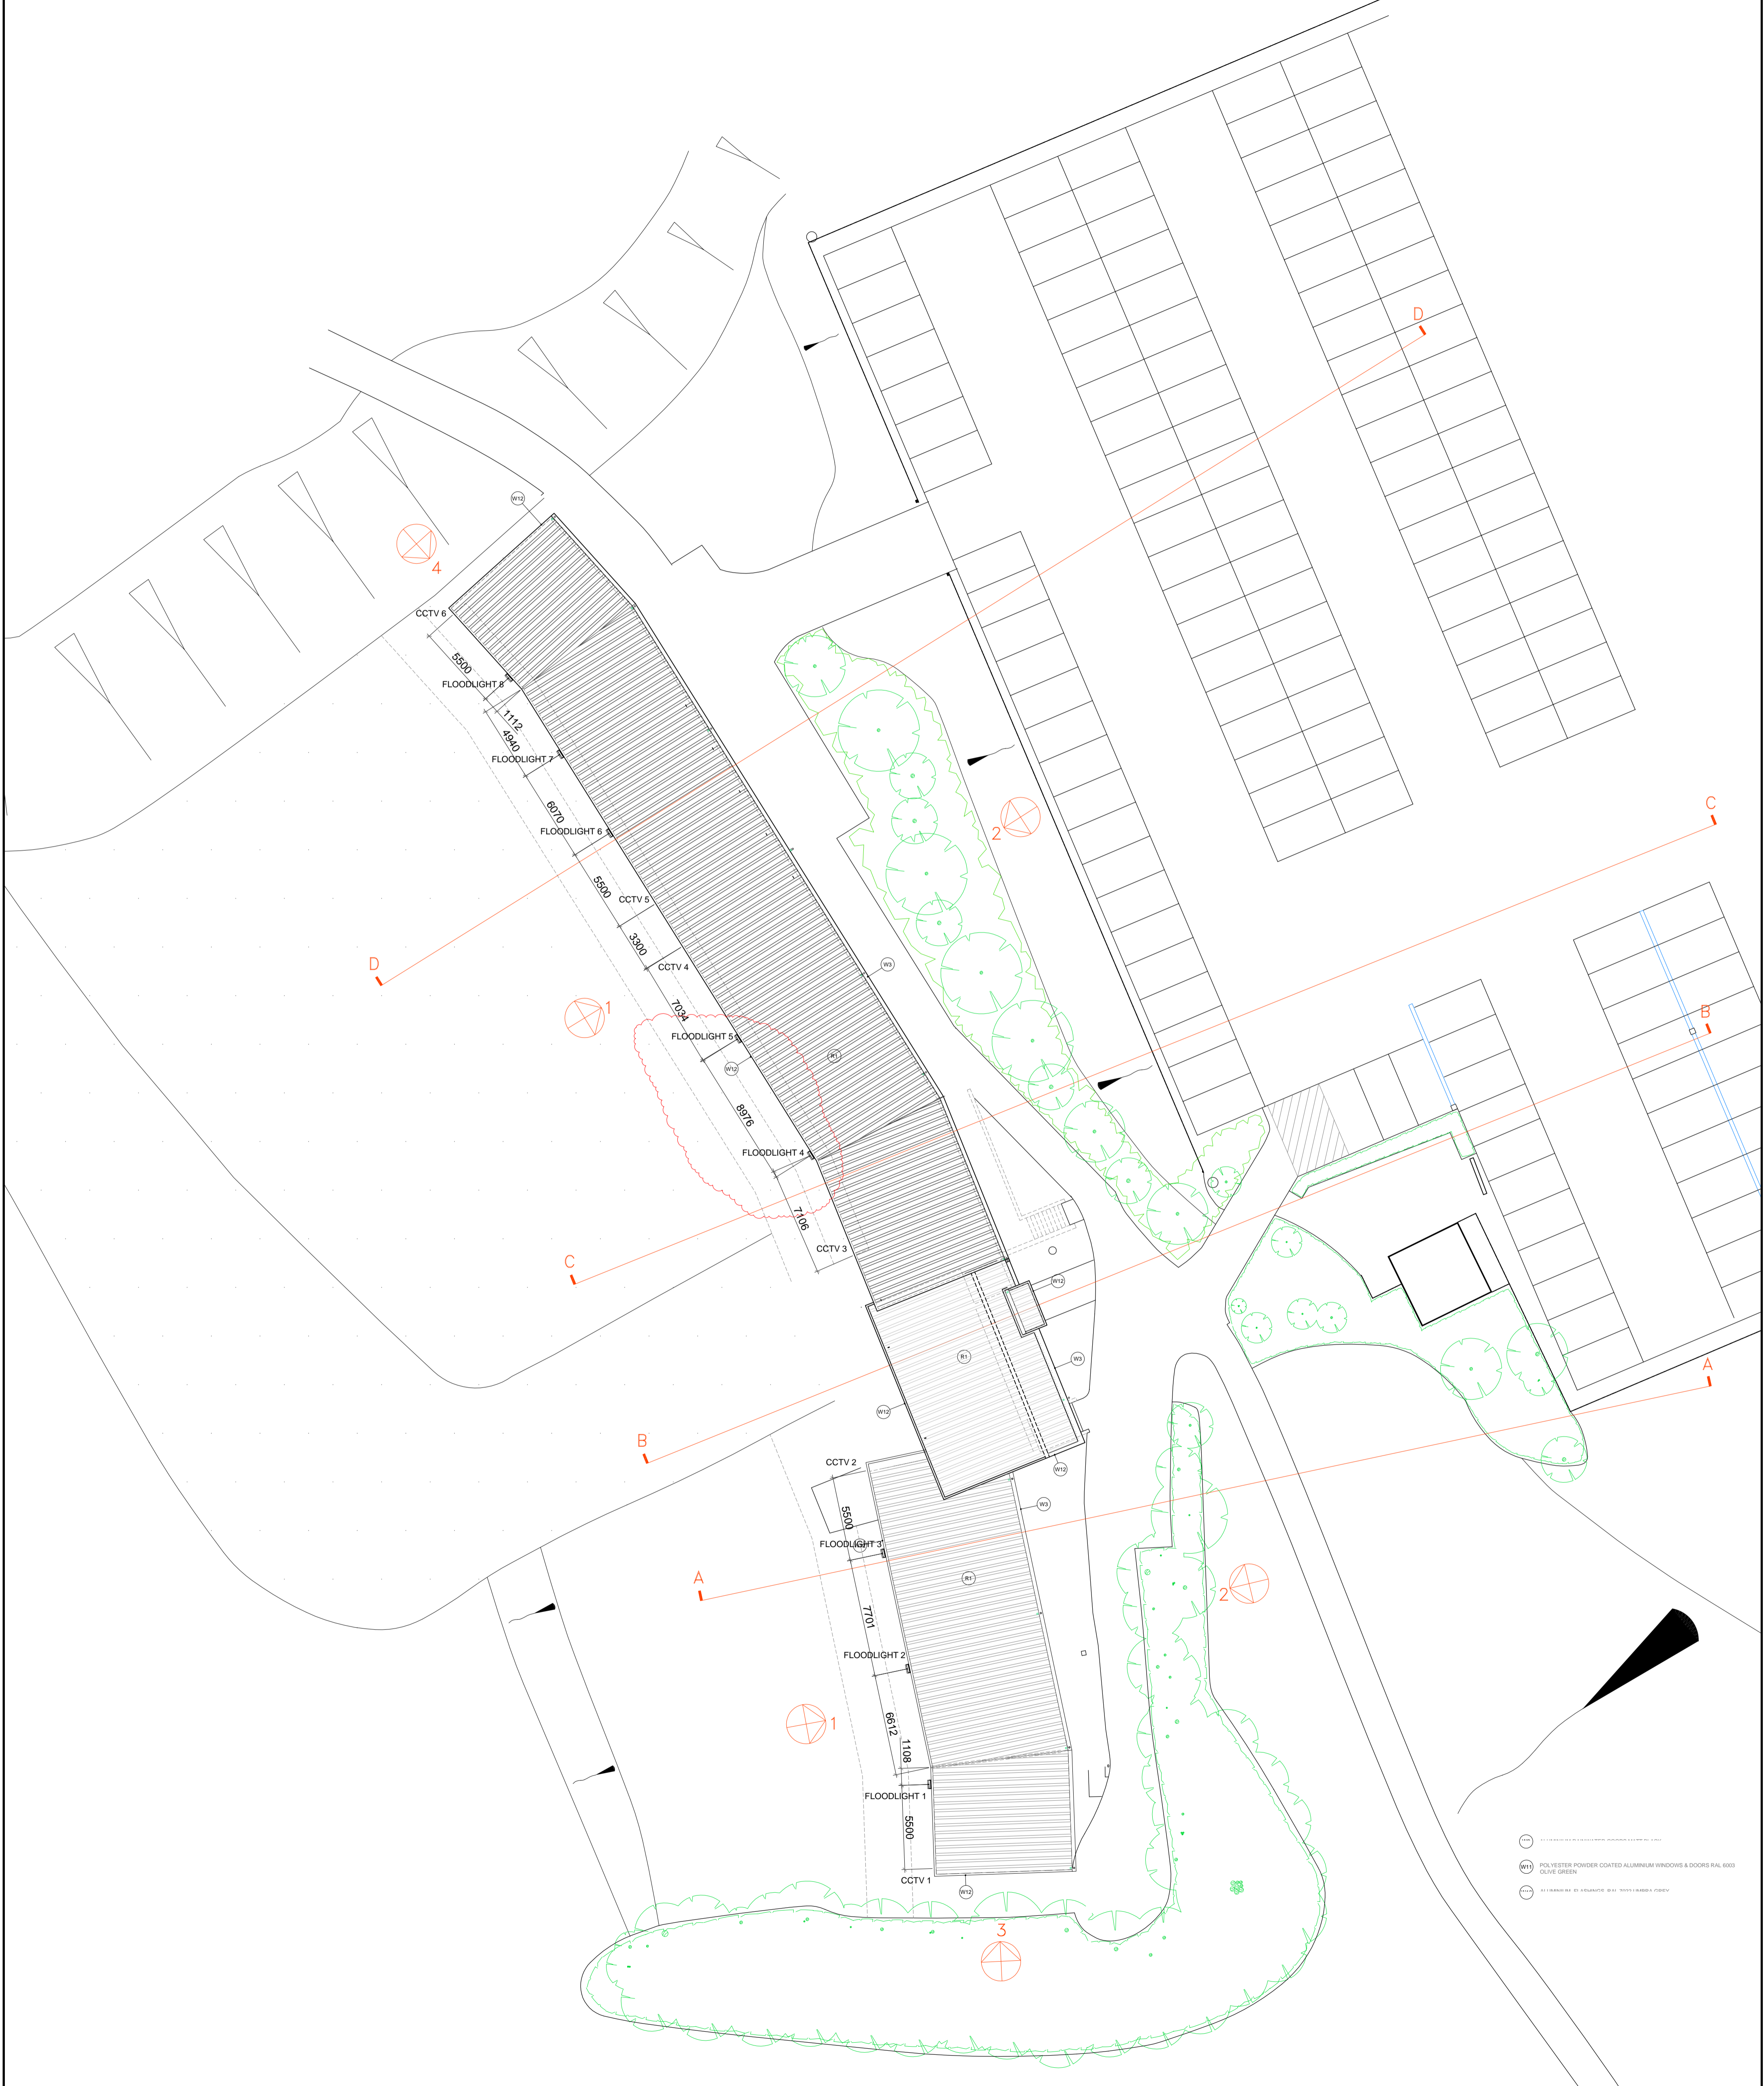


0 5M 10M 15M 20M 30M 40M 50M

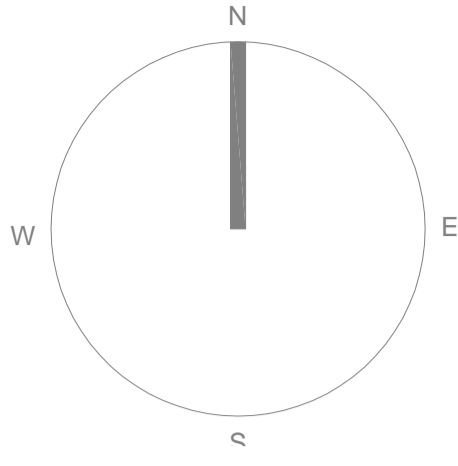

(---) POLYESTER POWDER COATED ALUMINIUM WINDOWS & DOORS RAL 6003 OLIVE GREEN
 (---) ALUMINIUM FINISHES
 (---)

COPYRIGHT: THIS DRAWING IS THE PROPERTY OF SPARCSTUDIO LTD AND MAY NOT BE REPRODUCED WITHOUT WRITTEN CONSENT.
DIMENSIONS: FIGURED DIMENSIONS ONLY TO BE TAKEN. NO DIMENSIONS TO BE SCALED FROM THIS DRAWING - ALL DIMENSIONS TO BE CHECKED ON SITE PRIOR TO CONSTRUCTION - SPARCSTUDIO TO BE INFORMED IMMEDIATELY OF ANY DISCREPANCIES PRIOR TO WORK PROCEEDING.
NOTE: THIS DRAWING IS PROVIDED ON THE UNDERSTANDING THAT THE CONTRACTOR/SUB CONTRACTOR WILL PRODUCE 'ROD/SKIP DRAWINGS' IN A TIMELY MANNER, PRIOR TO MANUFACTURE AND FOR APPROVAL, WHICH ARE BASED ON SITE DIMENSIONS FOR CONSTRUCTION PURPOSES.
CONTRACTOR'S RESPONSIBILITIES: IT IS THE CONTRACTOR & SUB CONTRACTORS RESPONSIBILITY TO CHECK THE ACCURACY AND BUILDABILITY OF THE DESIGN AND THE SUITABILITY AND AVAILABILITY OF ALL MATERIALS IDENTIFIED ON THIS DRAWING IN A TIMELY MANNER, IN ORDER THAT RESPONSES AND ASSISTANCE CAN BE REASONABLY GIVEN PRIOR TO CONSTRUCTION.
 SPARCSTUDIO TO ACCEPT NO RESPONSIBILITY FOR ANY DELAYS TO PROGRAMME, ADDITIONAL COSTS ETC WHICH MAY BE INCURRED AS A RESULT OF UNTIMELY RESPONSES.

ASSOCIATED INFORMATION: THIS DRAWING IS TO BE READ IN CONJUNCTION WITH ALL RELEVANT AND ASSOCIATED DRAWINGS AND SPECIFICATIONS PRODUCED BY SPARCSTUDIO AND THE PROJECT CONSULTANT DESIGN TEAM.
CODES: 'F' / 'SK' / 'W' / 'C' / 'P' INDICATE FINISHES CODES - REFER TO RELEVANT FINISHES SCHEDULES FOR DETAILS.
'T' REFERENCES INDICATE THRESHOLD CONDITIONS - REFER TO THRESHOLD DRAWING FOR DETAILS.
'SW' REFERENCES INDICATE SANITARYWARE ITEMS - REFER TO RELEVANT SANITARYWARE SCHEDULE FOR DETAILS.
'FP' REFERENCES INDICATE 'FITTINGS & FITTINGS' - REFER TO RELEVANT 'FITTINGS & FITTINGS' SCHEDULE.
SERVICES ACCESS: ACCESS TO SERVICES LOCATED IN CEILING VOIDS TO BE OF LIMITED WHEREVER POSSIBLE TO CORRIDORS/CIRCULATION ROUTES AND BACK OF HOUSE AREAS.
 ALL LOCATIONS OF ACCESS HATCHES/PANELS IN FRONT OF HOUSE AREAS TO BE SET OUT & COORDINATED WITH REFLECTED CEILING & LIGHTING PLANS AND APPROVED PRIOR TO INSTALLATION.

DESCRIPTION: FOR DATE OF REVISION REFER TO ISSUE SHEET
 REV A FLOOD LIGHTS AMENDED IN ACCORDANCE WITH EXLED PROPOSALS.

SPARCSTUDIO DESIGN CONSULTANTS		20 WATER LANE RICHMOND LONDON TW9 1TJ TELEPHONE: +44(0)203 637 5997 EMAIL: studio@sparcstudio.co.uk	
CLIENT NAME CLUB COMPANY	PROJECT NAME WARWICKSHIRE STRIKE SHACK DRIVING RANGE		
DRAWING TITLE PROPOSED ROOFPLAN			
PROJECT NO. 3090	DRAWING NO. 09	SCALE(S) 1:200 @ A1	STATUS PLANNING
DATE ORG. 15.07.2022		DRAWN BY TH	CHECKED BY ...