


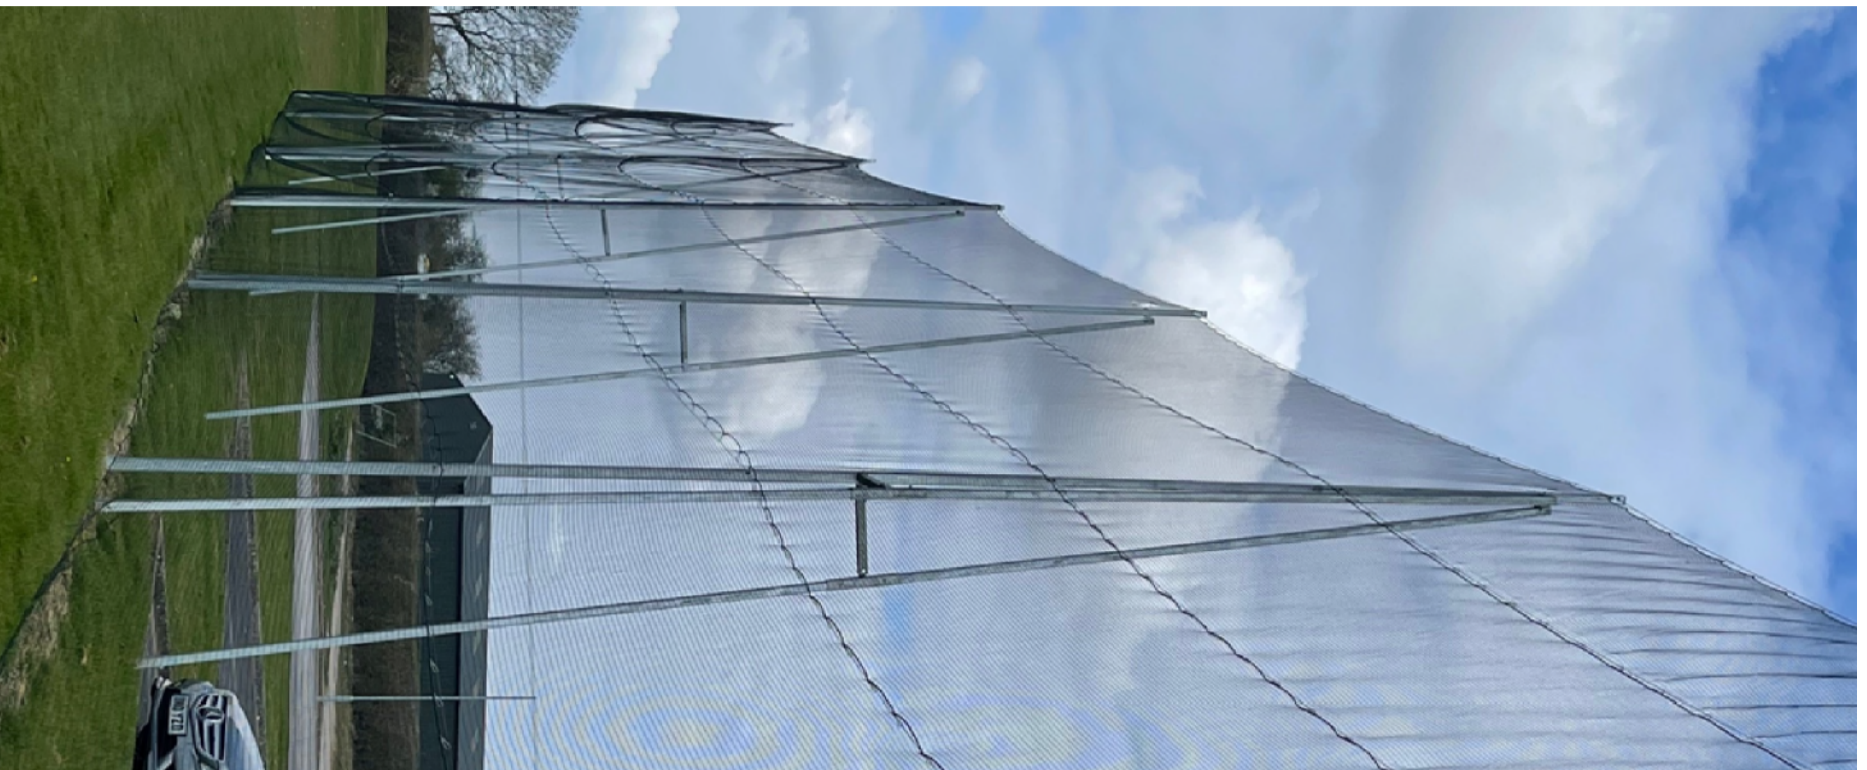


3 INDICATIVE IMAGE
SCALE 1:500



4 INDICATIVE IMAGE
SCALE 1:500



1 LOCATION PLAN
SCALE 1:500

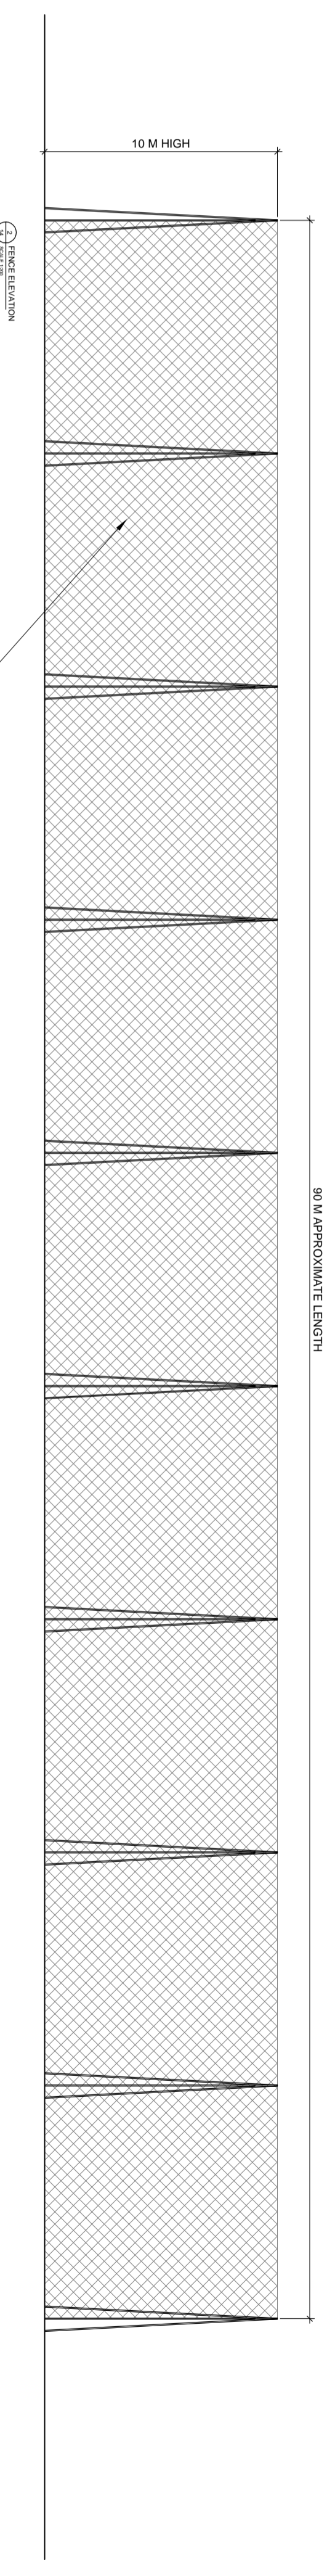

PROPOSED FENCING

STEELWORK GALVANIZED LATTICEWORK TOWER, TO BE BOLTED TO
STEEL TUBES FORMED IN THE CONCRETE BASE. COMPLETE WITH ALL
NEELED REINFORCEMENT. DATA CONSTRUCTION NOTIFIED WITH MESH
SIZE OF 20MM, NUMBER CORNER
SUPPORT TOWERS PER STRETCH/DIVESTER
GATE HEADS OF 20MM

COPYRIGHT: © THIS DRAWING IS THE PROPERTY OF SPARCSTUDIO LTD AND MAY NOT BE REPRODUCED WITHOUT WRITTEN CONSENT.
DIMENSIONS: FIGURED DIMENSIONS ONLY TO BE TAKEN, NO DIMENSIONS TO BE SCALED FROM THIS DRAWING. ALL DIMENSIONS TO BE CHECKED ON
RODS: THIS DRAWING IS PROVIDED ON THE UNDERSTANDING THAT THE CONTRACTOR/SUB CONTRACTOR WILL PRODUCE ROD/SHP DRAWINGS IN A
THEIR MANNER, PRIOR TO MANUFACTURE AND FOR APPROVAL, WHICH ARE BASED ON SITE DIMENSIONS FOR CONSTRUCTION PURPOSES.
CONTRACTORS RESPONSIBILITIES: IT IS THE CONTRACTOR & SUB CONTRACTOR'S RESPONSIBILITY TO CHECK THE ACCURACY AND BUILDABILITY OF
AND ASSISTANCE CAN BE REASONABLY GIVEN PRIOR TO CONSTRUCTION.
SPARCSTUDIO LTD ACCEPTS NO RESPONSIBILITY FOR ANY DELAYS TO PROGRAMME, ADDITIONAL COSTS ETC WHICH MAY BE INCURRED AS A RESULT OF
UNTIMELY RESPONSES.

ASSOCIATED INFORMATION: THIS DRAWING IS TO BE READ IN CONJUNCTION WITH ALL RELEVANT AND ASSOCIATED
DRAWINGS AND SPECIFICATIONS PRODUCED BY SPARCSTUDIO AND THE PROJECT CONSULTANT DESIGN TEAM.
REFERENCES INDICATE THRESHOLD CONDITIONS - REFER TO THRESHOLD DRAWING FOR DETAILS.
REFERENCES INDICATE FIXTURE & FITTINGS - REFER TO RELEVANT SANITARYWARE SCHEDULE FOR DETAILS.
REFERENCES INDICATE FIXTURE & FITTINGS - REFER TO RELEVANT SANITARYWARE SCHEDULE FOR DETAILS.
CORRIDORS/CIRCULATION ROUTES AND BACK OF HOUSE AREAS. VOIDS TO BE LIMITED WHEREVER POSSIBLE TO
ALL LOCATIONS OF ACCESS MATCHES/PANELS IN FRONT OF HOUSE AREAS TO BE SET-OUT & COORDINATED WITH REFLECTED
CEILING & LIGHTING PLANS AND APPROVED PRIOR TO INSTALLATION.

DESCRIPTION: FOR DATE OF REVISION REFER TO ISSUE SHEET

SPARCSTUDIO DESIGN CONSULTANTS		20 WATER LAKE ROCHAMOND LONDON, TW9 1TT TELEPHONE: +44(0)203 637 5997 EMAIL: studio@sparcstudio.co.uk	
CLIENT NAME	CLUB COMPANY	PROJECT NAME	WARWICKSHIRE STRIKE SHACK DRIVING RANGE
DRAWING TITLE	PROPOSED DRIVING RANGE NETTING	DRAWING NO.	14
PROJECT NO.	3090	SCALE(S)	1:500/200 @ A1
STATUS	PLANNING	DATE/DESC	17.05.22
DRAWN BY	TH	CHECKED BY	...