




Existing Rear Elevation

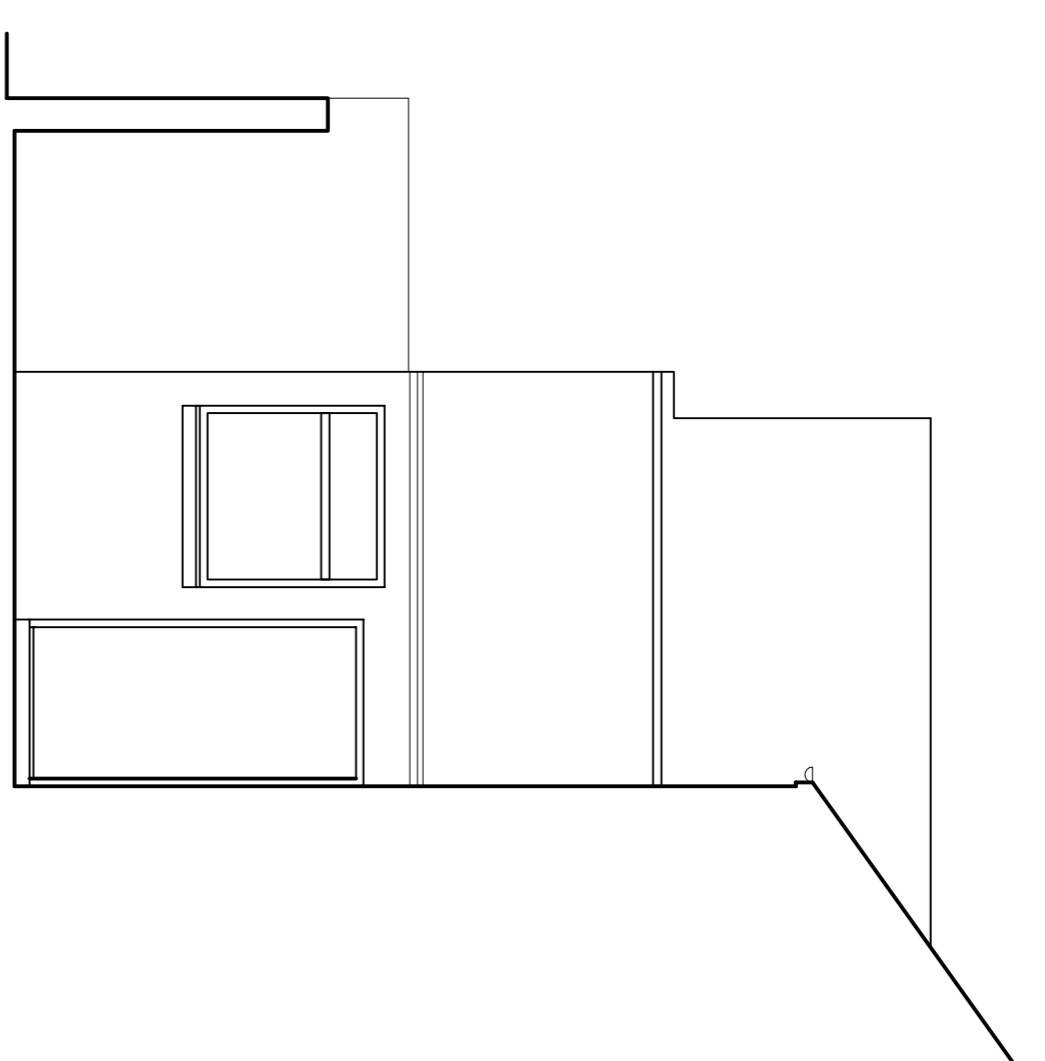


Existing Side Elevation

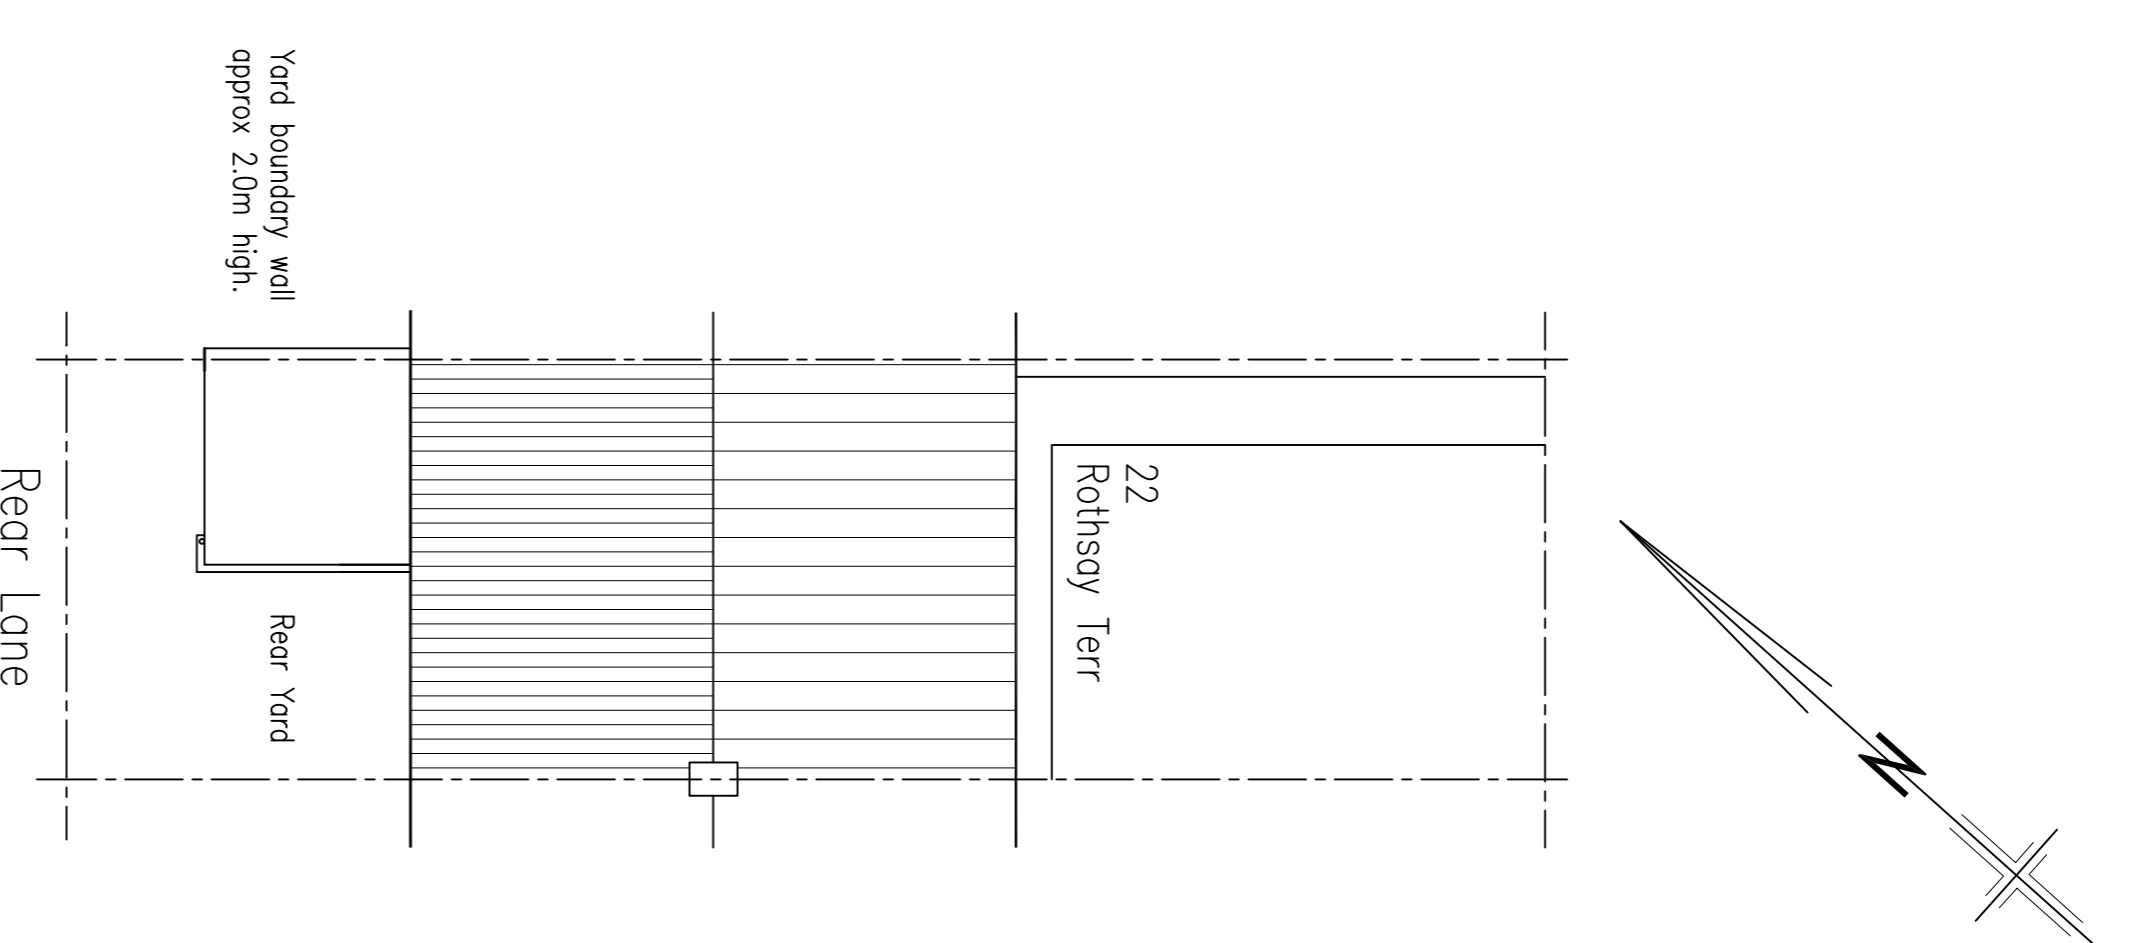

Existing Site/roof Plan.

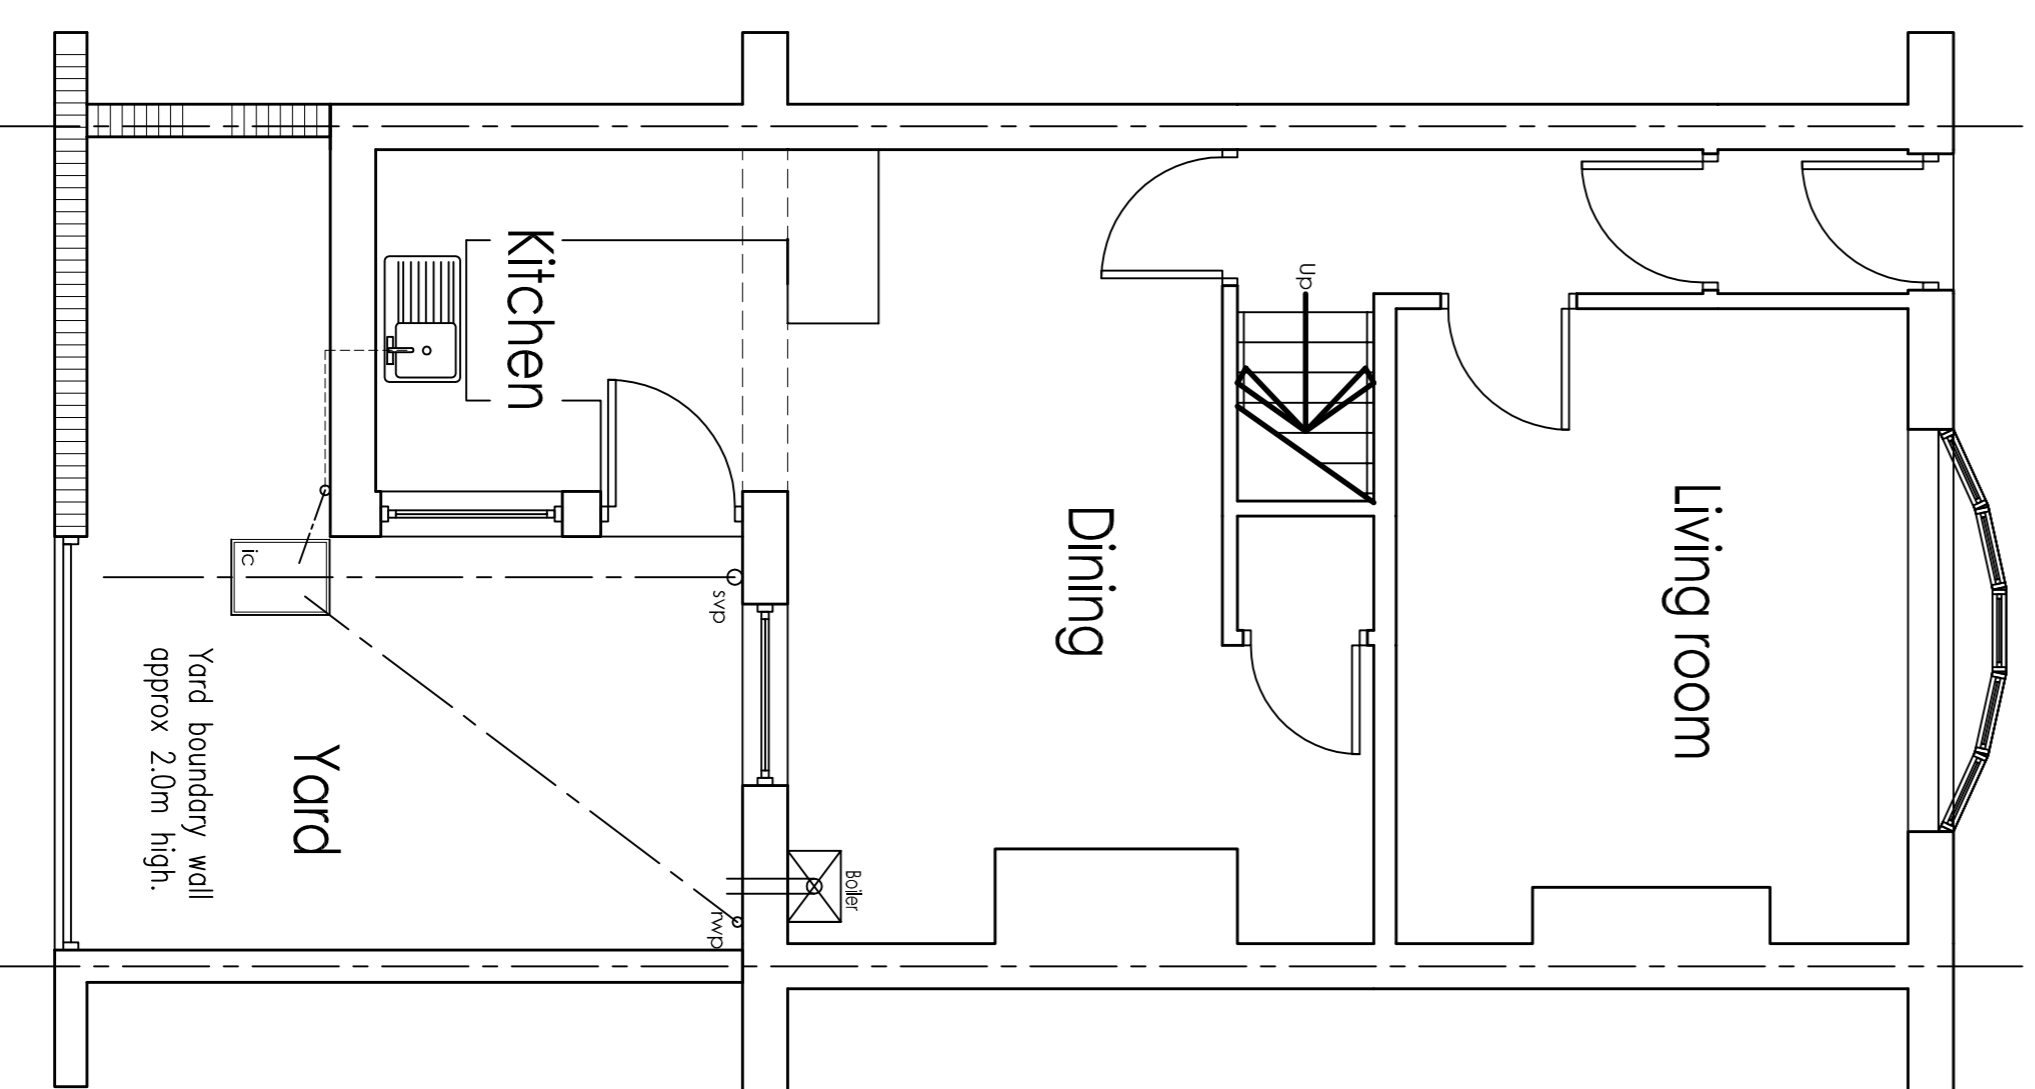

Existing Ground Floor

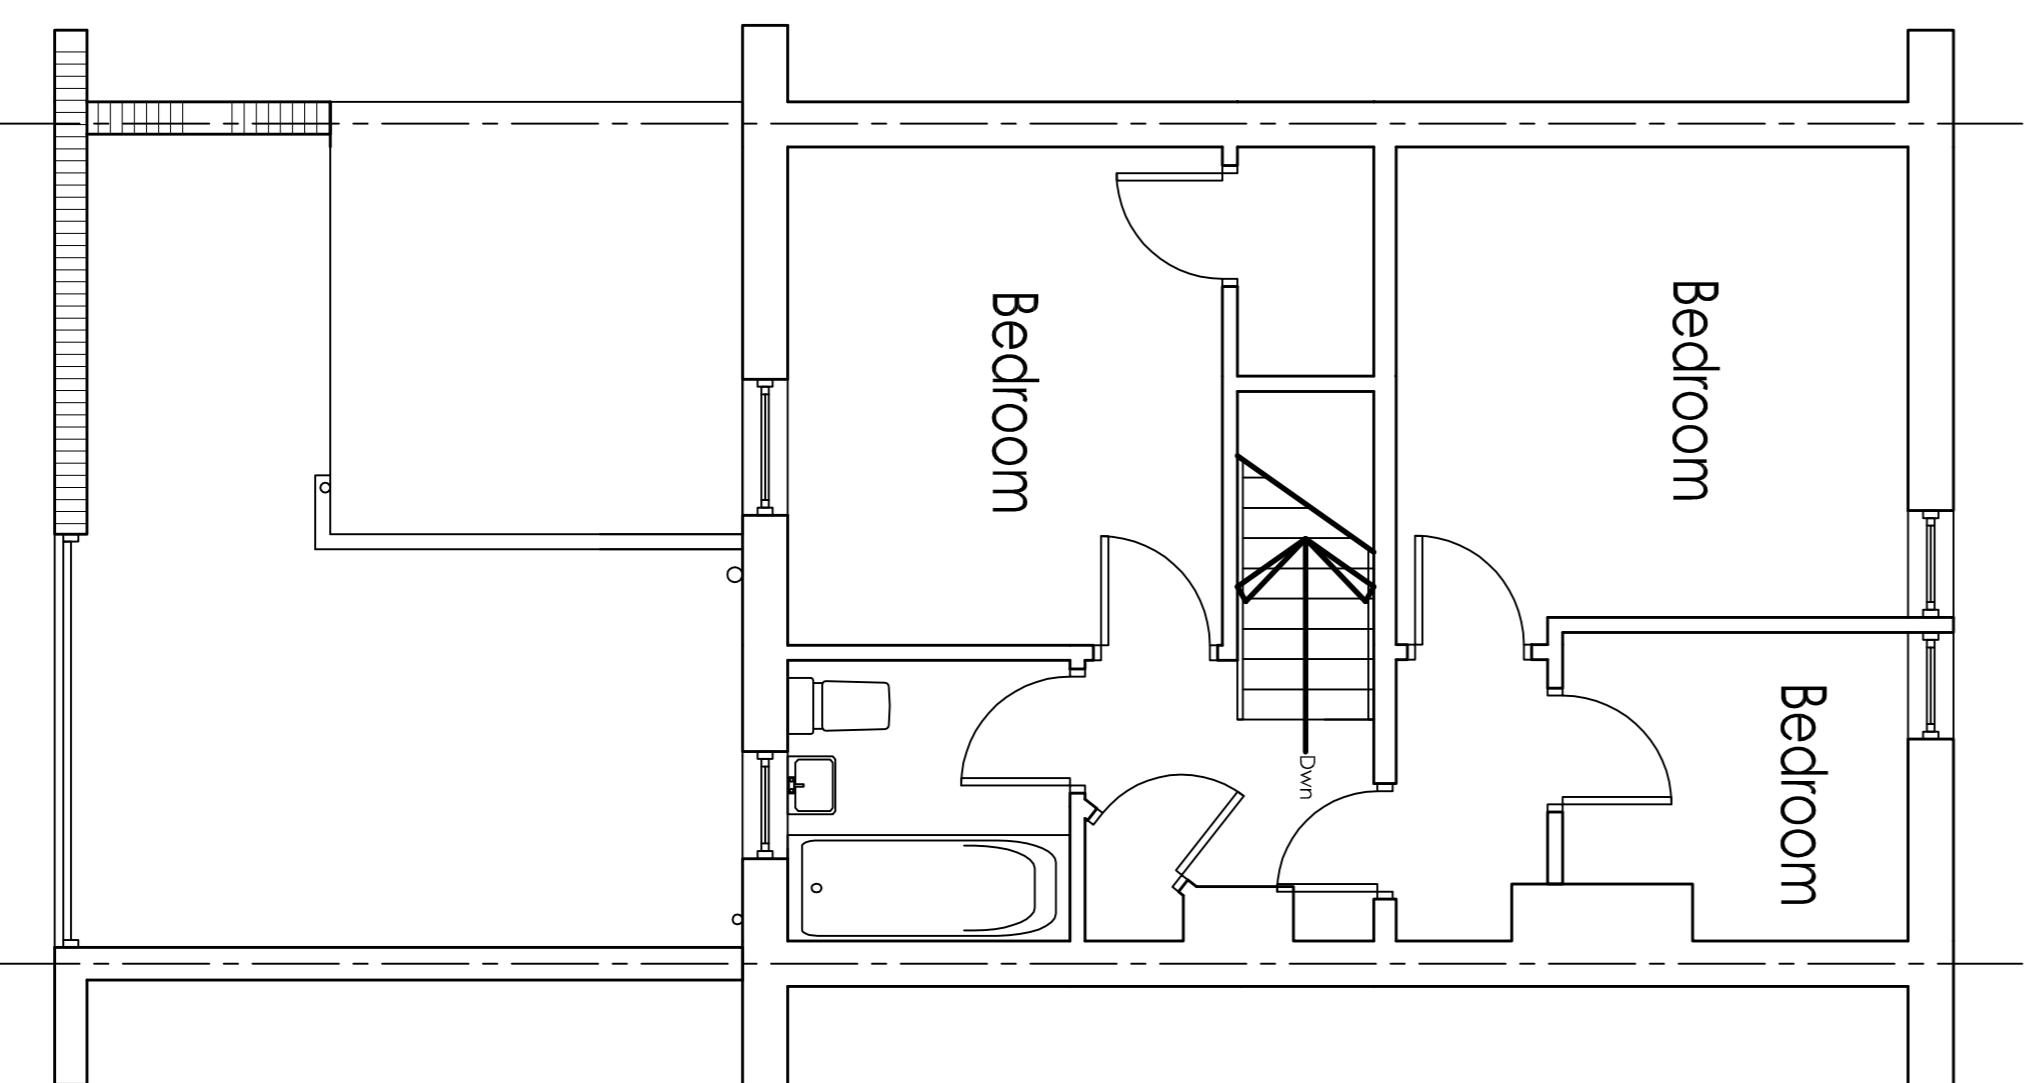

Existing First Floor

DO NOT SCALE FROM THIS DRAWING.
 FOUNDATION DEPTH AND DESIGN ARE ASSUMED AND DEPENDANT UPON SOIL CONDITIONS AND NEARBY VEGETATION. ALL TO BE APPROVED BY BUILDING CONTROL PRIOR TO INSTALLATION.
 THE ELECTRICAL LAYOUT IS FOR INDICATION PURPOSES ONLY.
 INSPECT SITE, TESTS ETC./WORKS BEFORE COMMENCEMENT. REPORT ANY DISCREPANCIES IMMEDIATELY.
 ALL SITE DIMENSIONS SHALL BE VERIFIED BY THE CONTRACTOR ON SITE PRIOR TO COMMENCING WORKS
 ALL DRAINAGE RUNS SHOWN ARE ASSUMED. THE CONTRACTOR IS TO CHECK LAYOUT PRIOR TO BUILD.

NMS (0191) 488 1928
 Building Design Mob. 07534 416 370

Proposed Rear Extension
 22 Rothsay Terrace
 Newbiggin
 NE64 6XW

DATE	SCALE	DWG NO.
JULY 2022	1:50; 1:100	22-751-01

This drawing must not, without permission of the designer, be published, copied, reproduced, manufactured or exploited in any other unauthorized way.