

KEY TO SYMBOLS




Low Level Path Lighting

Lanea Path Lighting Bollard with PIR sensor.



Benefits :

- LED mains wired.
- Low level height, only 40cm high.
- LED bulbs installed into this pillar lamp are in such a manner that they shine downwards onto cascading reflectors, keeping all light at low level.
- Integrated PIR sensor, keeping light levels low and only on when required.
- Range 2-8metres, set at 5m as shown.
- Lighting duration (5 seconds to 6 minutes) are configurable.
- Detects movement at an angle of 90 degrees .

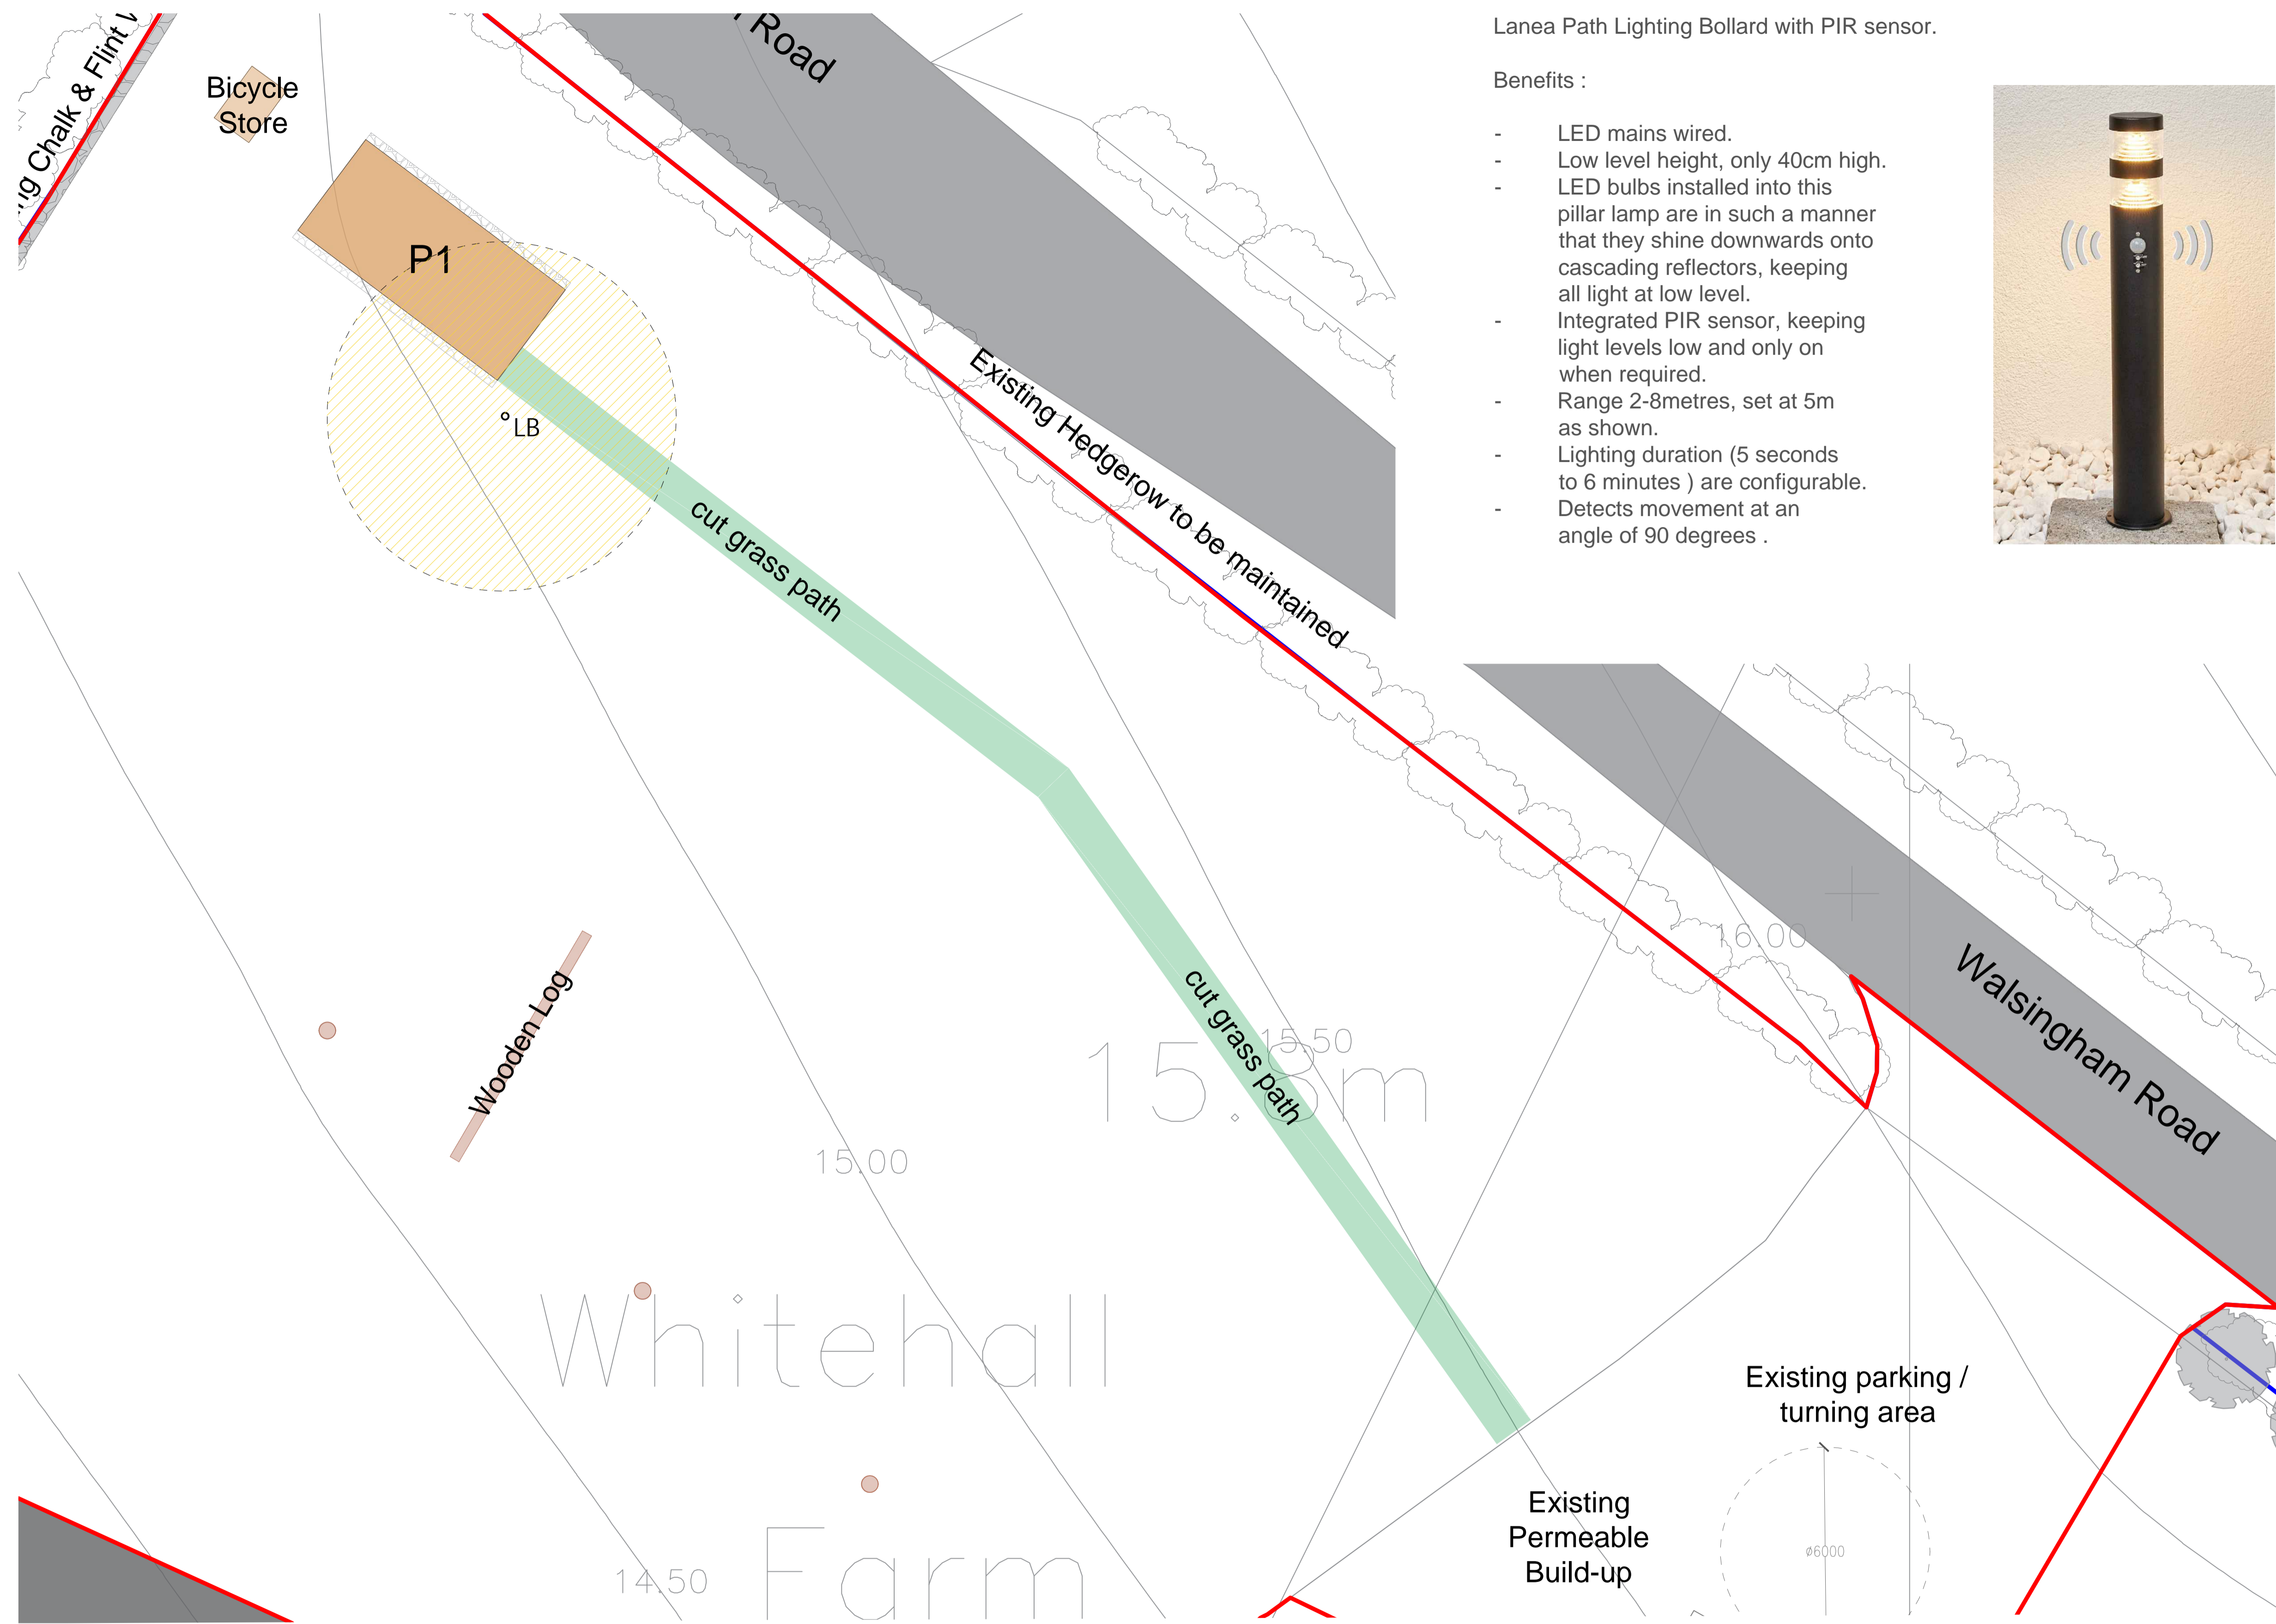


OWNERSHIP BOUNDARY
 AREA = 1,995,883 m²

SITE BOUNDARY
 SITE AREA = 2,388 m²

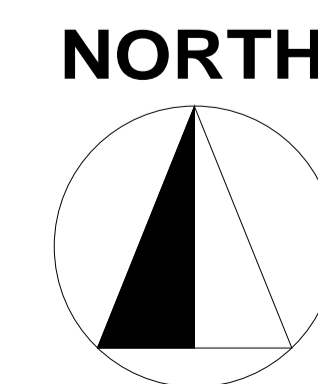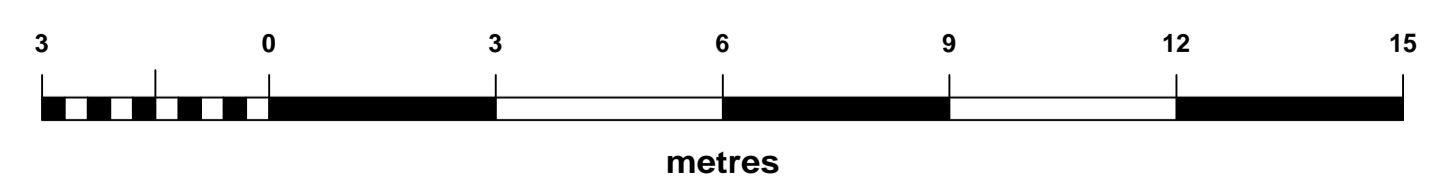

Date	Description	Rev	By

Revision Description

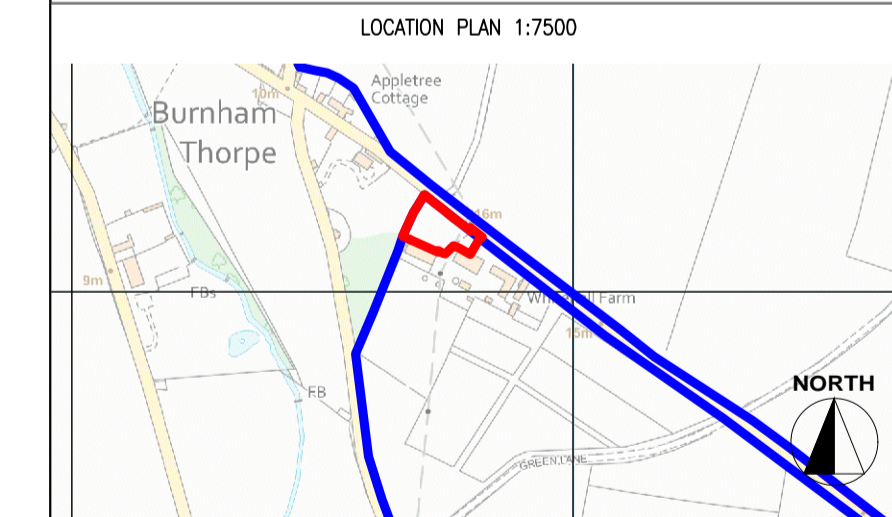

Project:
 Proposed Glamping Site - For Valerie Southerland
 Whitehall Farm, Burnham Thorpe, Kings Lynn, Norfolk
 PE31 8HN

Drawing Title:
 LIGHTING PLAN

Drawing Number:
 220427-01-08

Revision:

Date: 08/09/22
 Scale: 1:100 @ A1
 Drawn By: LI
 CAD Dwg File: -
 Checked By: EC

Issue Status:
 Full Planning Application