



GROUND FLOOR

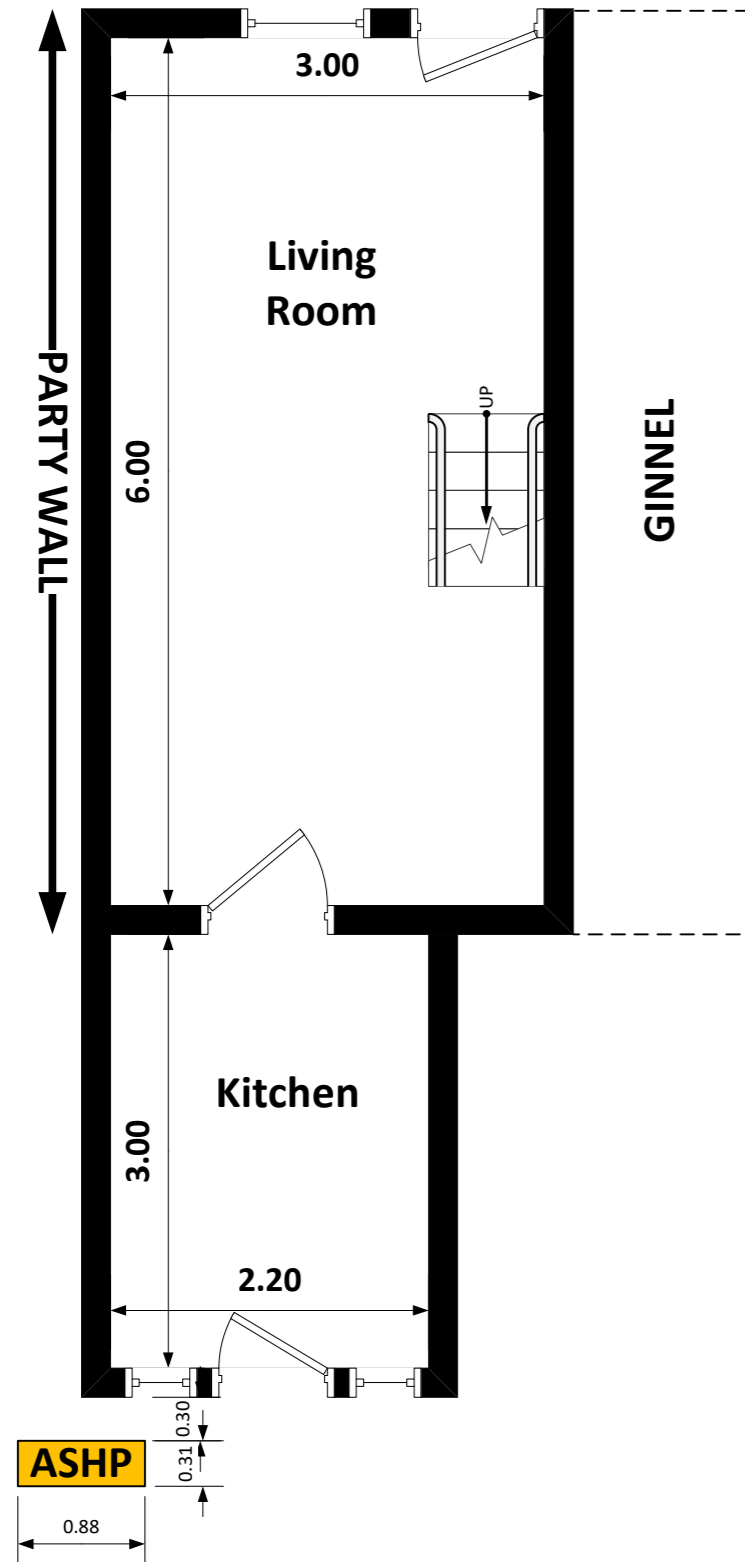

FIRST FLOOR

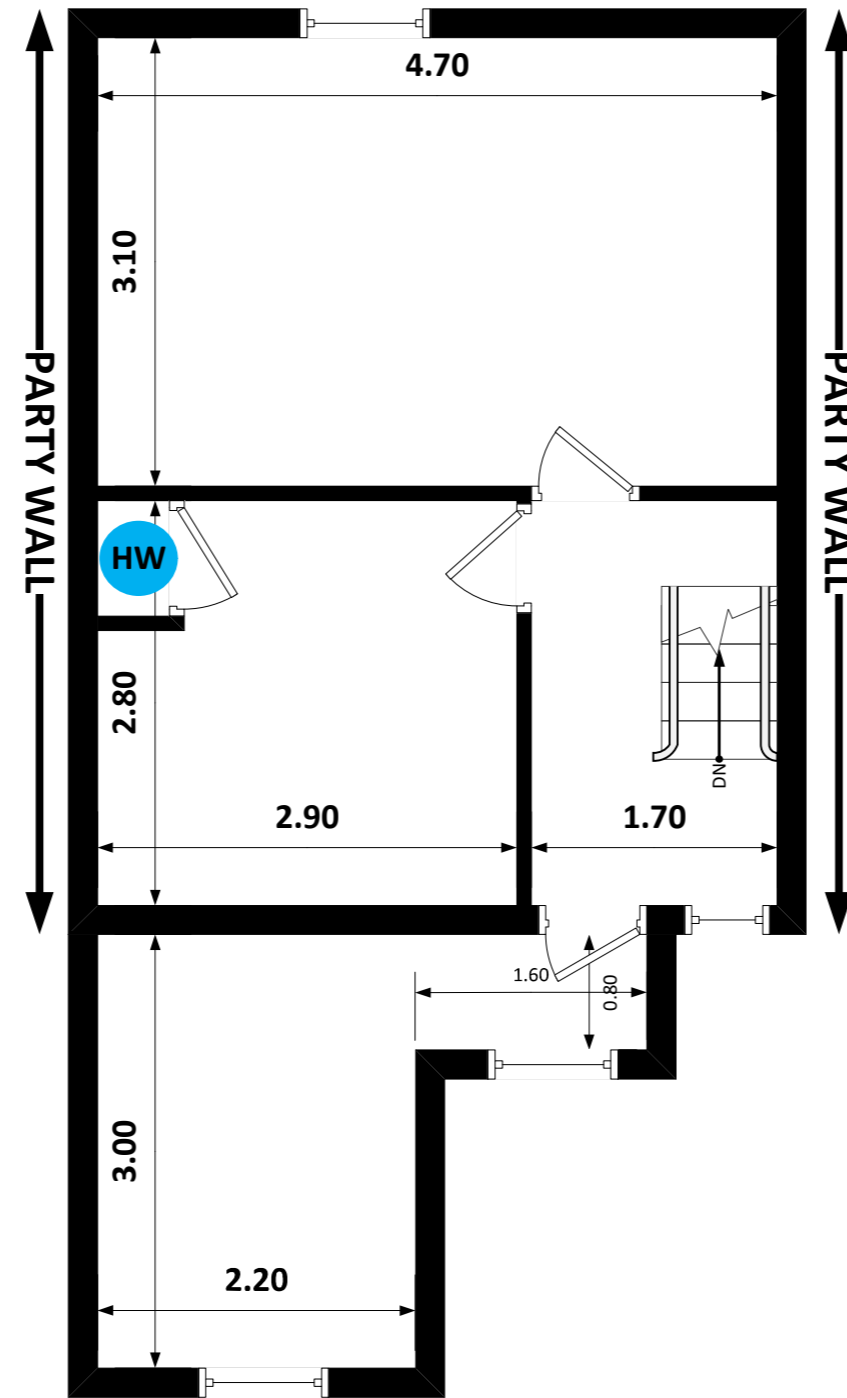

ASHP	Air Source Heat Pump
	Radiator (Sized as per Schedule)
HW	Hot Water Cylinder

	TITLE: AIR SOURCE HEAT PUMP FLOOR PLAN		
	DATE: 05/09/2022	DRAWN BY: ROY ROGERS	SCALE: 1: 50
	FILENAME: CAMBRIAN COTTAGE - ASHP - FLOOR PLAN.VSDX		