


BACK LANE

 
FOLLY BUNGALOW

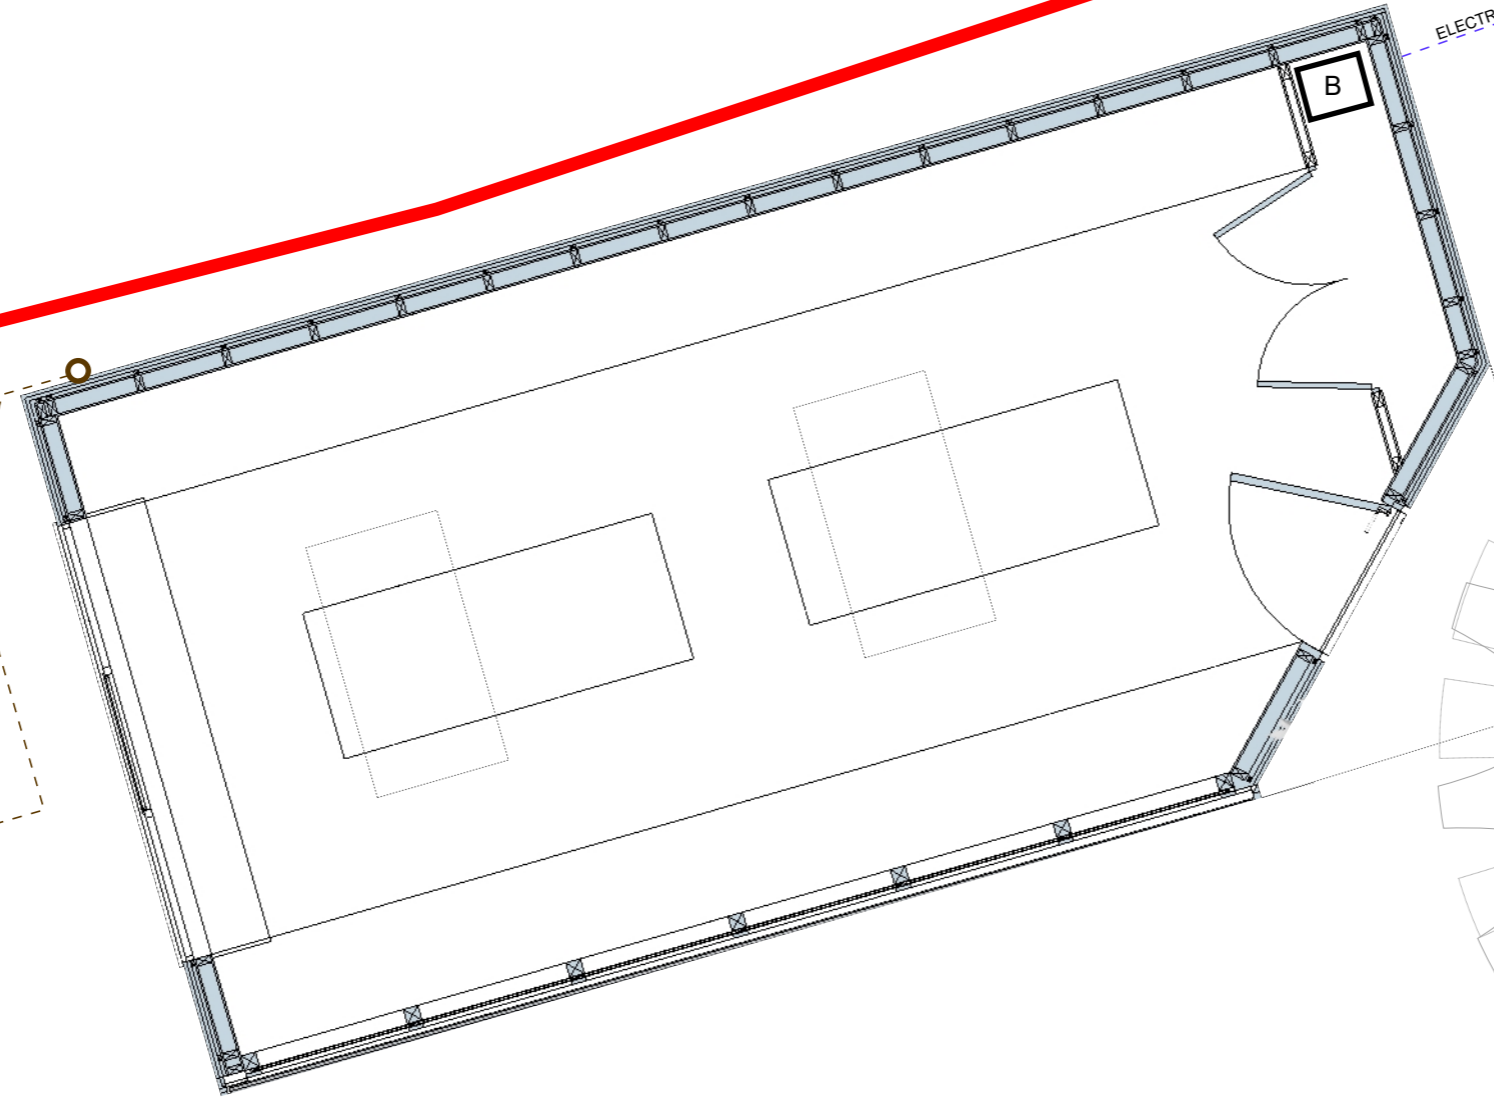

ELECTRIC SUPPLY - armoured cable

B

K
A



Client: Tony Thompson
Project: Folly Cottage
Chewton Mendip

Floor Plan: 115_03
Scale: 1:50
Date: 02/11/2022

A3

