

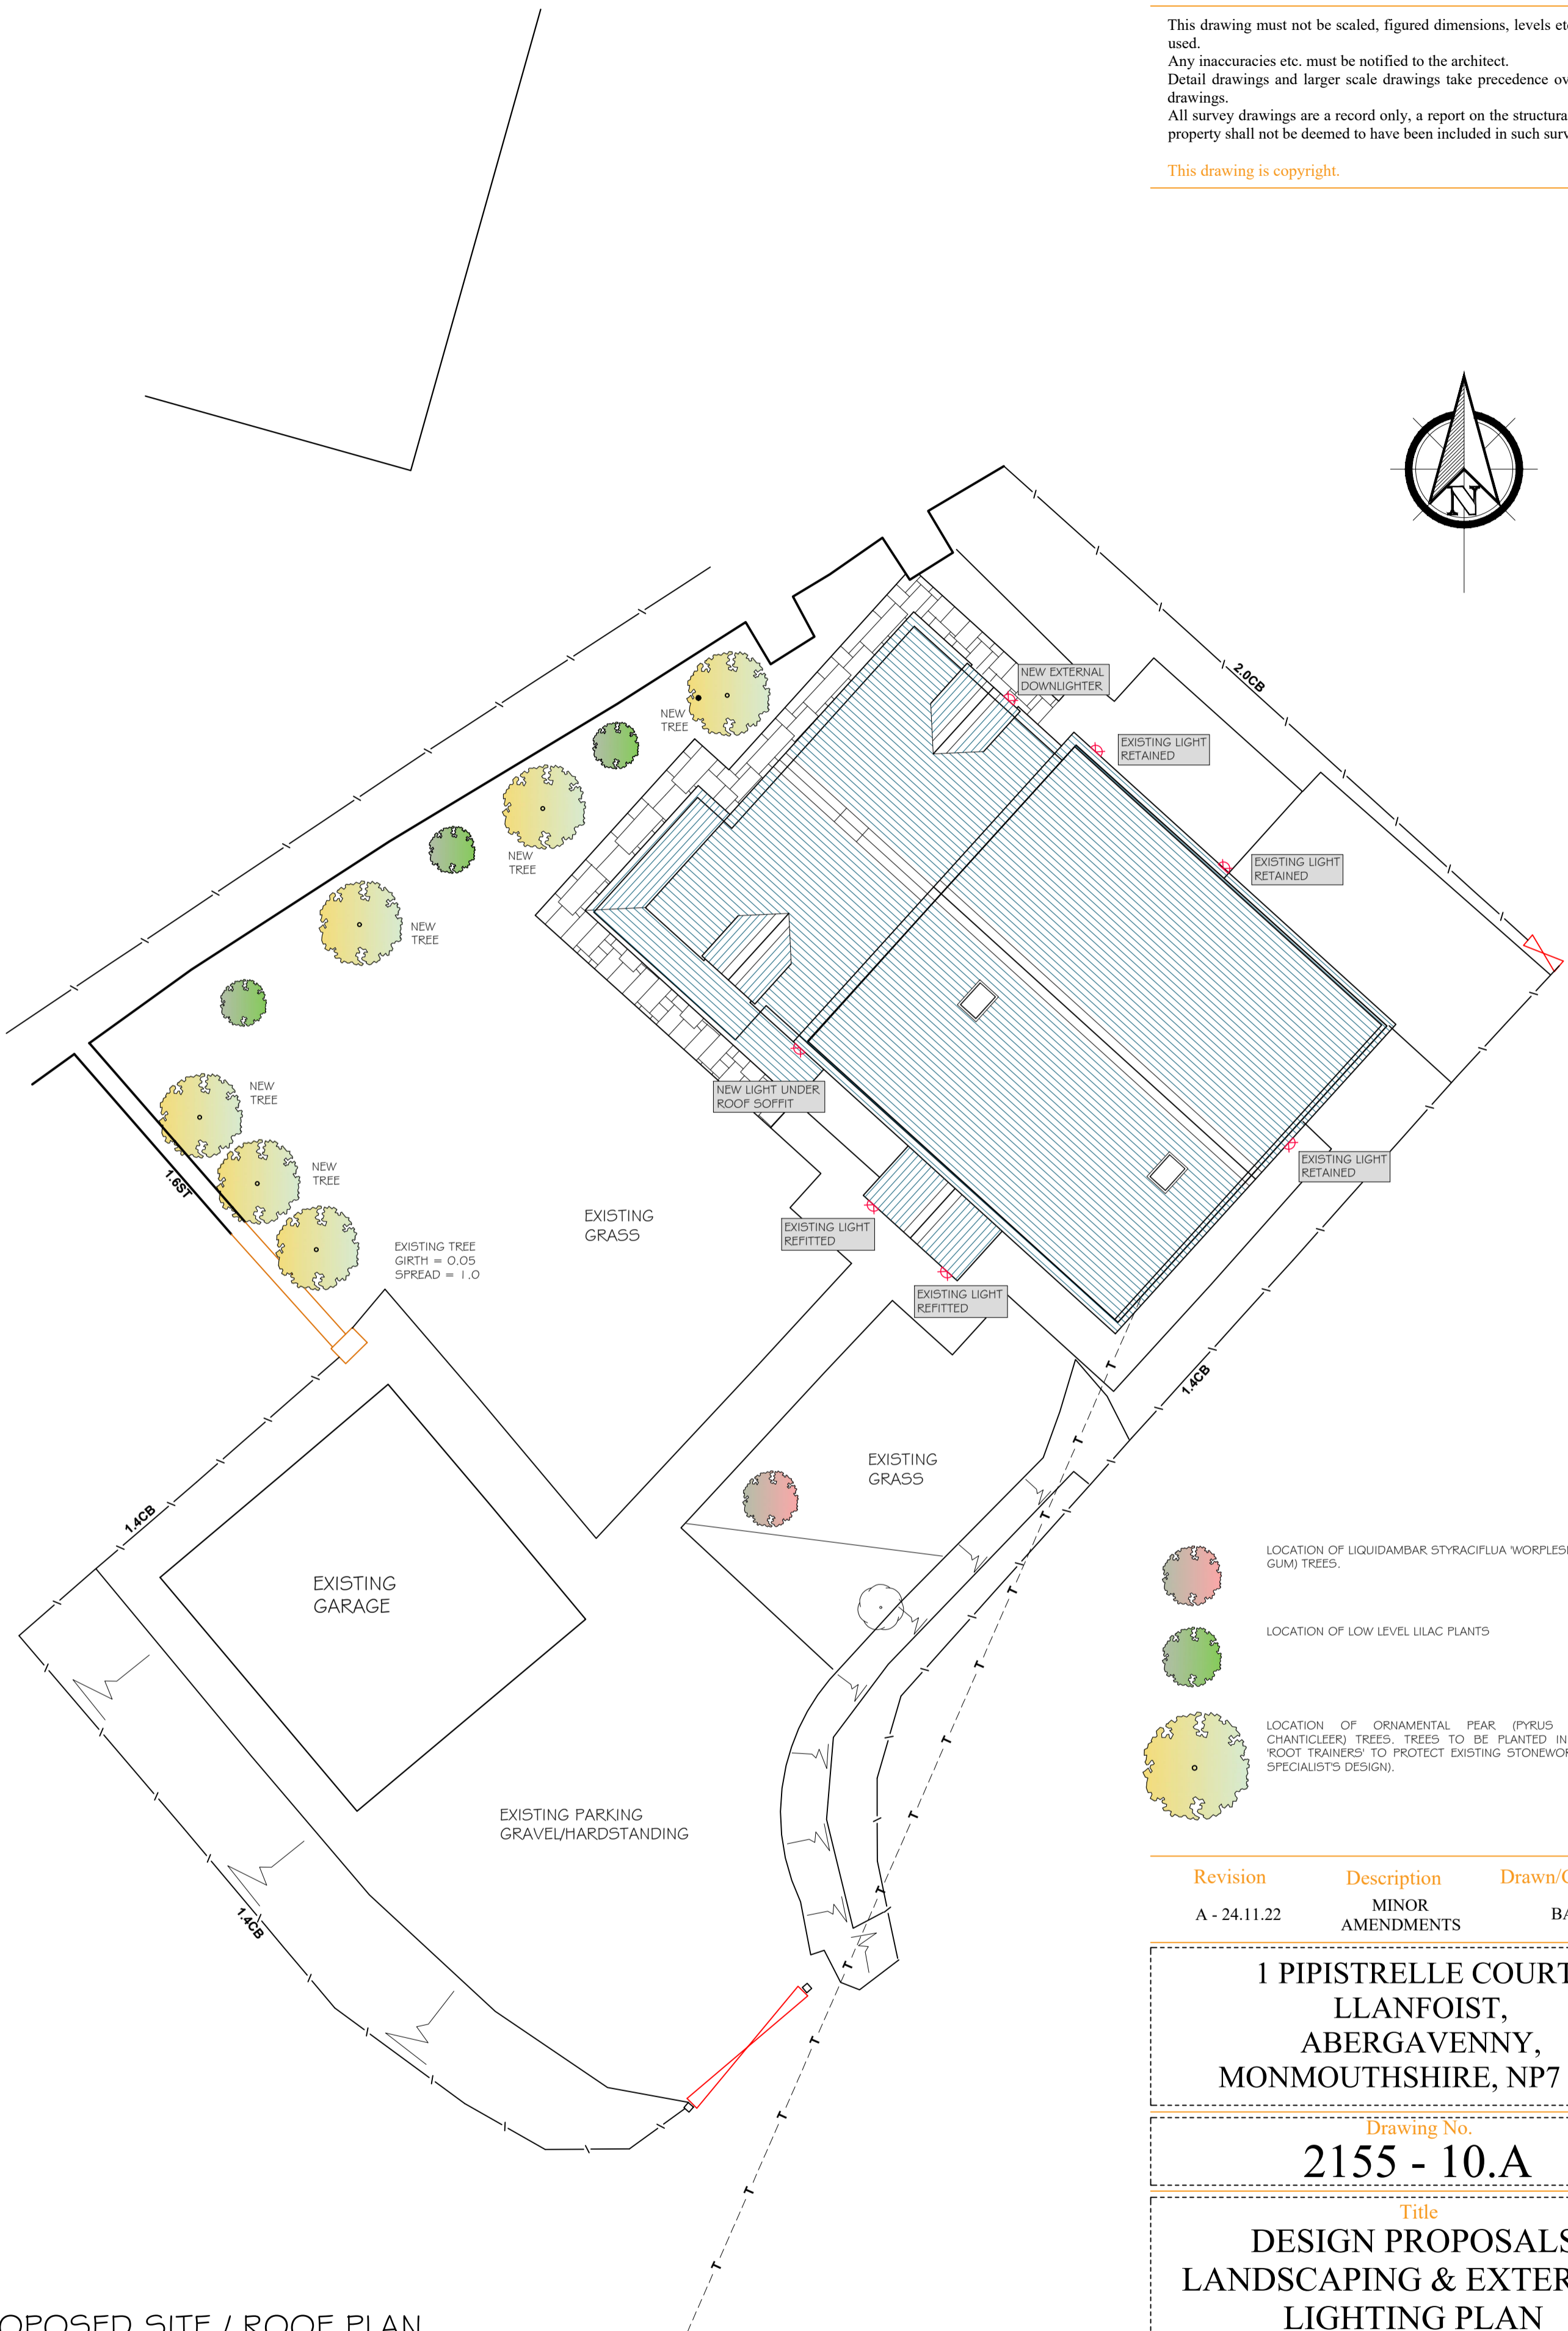


This drawing must not be scaled, figured dimensions, levels etc. only are to be used.  
 Any inaccuracies etc. must be notified to the architect.  
 Detail drawings and larger scale drawings take precedence over smaller scale drawings.  
 All survey drawings are a record only, a report on the structural integrity of the property shall not be deemed to have been included in such surveys.

This drawing is copyright.

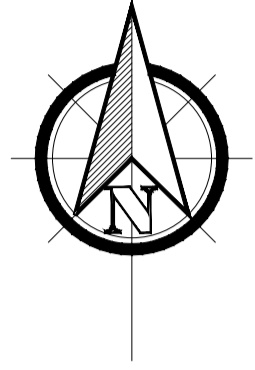

PROPOSED SITE / ROOF PLAN  
 SCALE 1:100

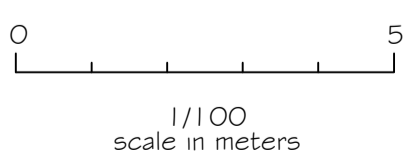

| Revision     | Description      | Drawn/Checked by |
|--------------|------------------|------------------|
| A - 24.11.22 | MINOR AMENDMENTS | BAB              |

1 PIPISTRELLE COURT,  
 LLANFOIST,  
 ABERGAVENNY,  
 MONMOUTHSHIRE, NP7 9NF

Drawing No.  
**2155 - 10.A**

Title  
**DESIGN PROPOSALS  
 LANDSCAPING & EXTERNAL  
 LIGHTING PLAN**

| Scale          | Date     | Drawn/Checked by |
|----------------|----------|------------------|
| As shown at A2 | NOV 2022 | JCL/ACC          |

**Morgan & Horowskyj Architects LLP**  
 The School Room, Castle Street, Abergavenny, Monmouthshire, NP7 5EE  
 Tel 01873 852465/855273 Email reception@morganhorowskyj.co.uk www.morganhorowskyj.co.uk