



'ERLA14DW1' REVERSIBLE AIR SOURCE HEAT PUMP FOR HEATING / COOLING BY DALKIN.
 INSTALLED WITH BIG FOOT FIX IT FOOT OR SIMILAR, TO REDUCE NOISE POLLUTION.


NEW EV CHARGING POINT

PROPOSED FRONT ELEVATION



'ERLA14DW1' REVERSIBLE AIR SOURCE HEAT PUMP FOR HEATING / COOLING BY DALKIN.
 INSTALLED WITH BIG FOOT FIX IT FOOT OR SIMILAR, TO REDUCE NOISE POLLUTION.

PROPOSED SIDE ELEVATION

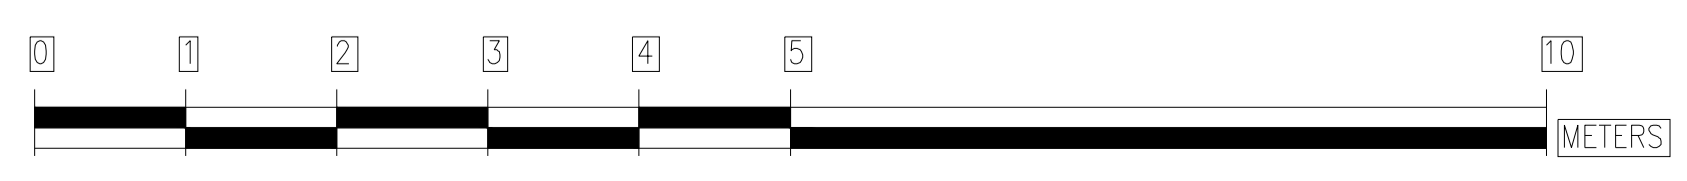

REV.	DATE	PURPOSE	DRAWN
E	09/02/23	ISSUED FOR PLANNING / LBC	TJ
D	09/09/22	RELOCATION OF WORKSHOP	TJ
C	11/04/22	ISSUED FOR LBC	TJ
B	16/03/22	ISSUED FOR LBC	TJ
A	23/12/21	ISSUE TO LOCAL AUTHORITY	VP

PROJECT THE LORDSHIP, COTTERED, BUNTINGFORD SG9 9QL
 TITLE PROPOSED ELEVATIONS

REVISION	DWG No.	SCALE
E	SKK4005/005	1:50@A1
DATE	DRAWN	CHECKED
DEC'21	TJ	APF

SKK DESIGN

INTERIOR, ARCHITECTURAL & RETAIL DESIGN

The Mill
 Stortford Road
 Hatfield Heath
 CM22 7DL

Tel: 01279 873010
 www.senkenken.com