


100 DIA uPVC DRAIN SURROUNDED WITH 150 OF PEA SHINGLE TO NEW SOAKAWAY 1.5m3 5000 FROM ALL BUILDINGS. WHERE DRAIN PIPE IS WITHIN 600 OF GROUND LEVEL, COVER WITH 100 THICK CONCRETE OR CONCRETE PAVING SLABS PROPRIETARY SOAKAWAY INSTALLED IN ACCORDANCE WITH MAHUFACTURERS INSTRUCTIONS FOLLOWING PERCOLATION TEST

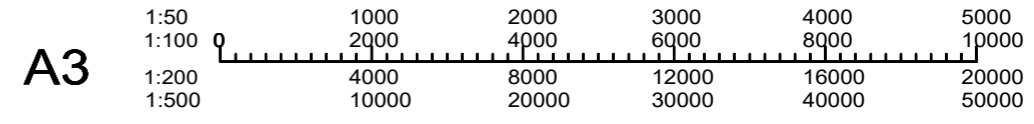

PROPOSED GROUND FLOOR PLAN

DRG NO. HP 5723 ISSUE A1
15/3/2023 SH 2

SCALE 1:50

P.S.DESIGNS
TEL 01784 450219 07956332516
peterslator@gmail.com

PROPOSED EXTENSION AT
10 FULLERTON CLOSE
FLEET
GU51 1BJ