
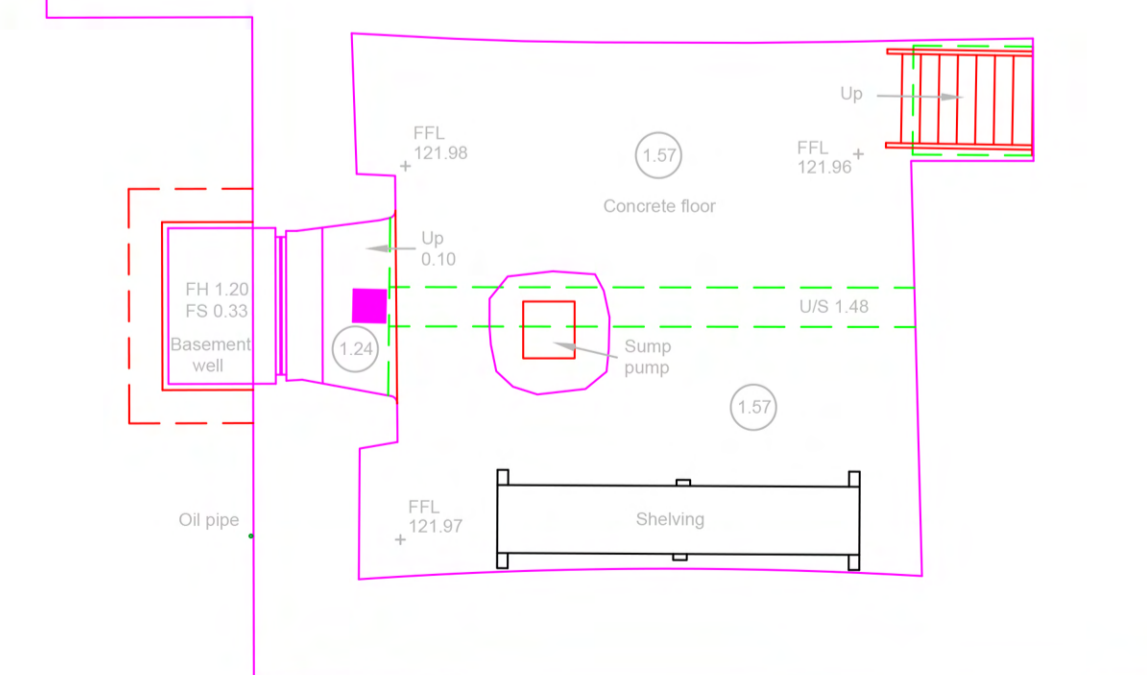


NOTES

ALL LEVELS ARE IN METRES RELATED TO OSG6836/10 DATUM USING LEICA GNSS RECEIVER

KEY - BUILDING


FFL	FINISHED FLOOR LEVEL	RWP	BREAK GLASS POINT
THL	THRESHOLD LEVEL	FHR	FIRE HOSE REEL
FH	FLOOR TO HEAD HEIGHT	FX	FIRE EXTINGUISHER
FS	FLOOR TO SILL HEIGHT	S	SMOKE
US	UNDERSIDE HEIGHT	SD	SMOKE DETECTOR
DH	DOOR HEIGHT	BS	BELLS
AH	ARCH HEAD HEIGHT	BS	BELLS
SP	SPRINKLING POINT HEIGHT	CS	COORNER SWITCH
RAD	RADIATOR	SS	SINGLE SOCKET
HTR	HEATER	DS	DOUBLE SOCKET
HWT	HOT WATER TANK	EL	EMERGENCY LIGHT
BLR	BLENDER	LF	LIGHT FITTING
WC	TOILET	LS	LIGHT SWITCH
WB	WASH BASIN	TR	TRUSCOCK POINT
SHR	SHOWER	TV	AERIAL POINT
BS	BINET	UP	DOWN PIPE
UR	URINAL	RWP	RAIN WATER PIPE
HD	HAND DRYER	WP	WASTE PIPE
WP	WATER FOUNTAIN	WP	WASTE PIPE
RF	ROOF LIGHT	AL	ALARM
SUS.C	SUSPENDED CEILING	AB	AIR BRICK
DB	DISTRIBUTION BOARD	W	WATER
FR	FIRE PLACE	WM	WATER METER
BDR	BLOCKED DOOR	AD	AIR BRICK
GMTR	GAS METER	BW	BLOCKED WINDOW
RM	ROOM HEIGHT	BR	BRICK
1.2	FLOORBOARD & DIRECTION	CT	CONCRETE
1.3		CC	CONCRETE
1.4		TOW	TOP OF WALL
1.5		V	VENT

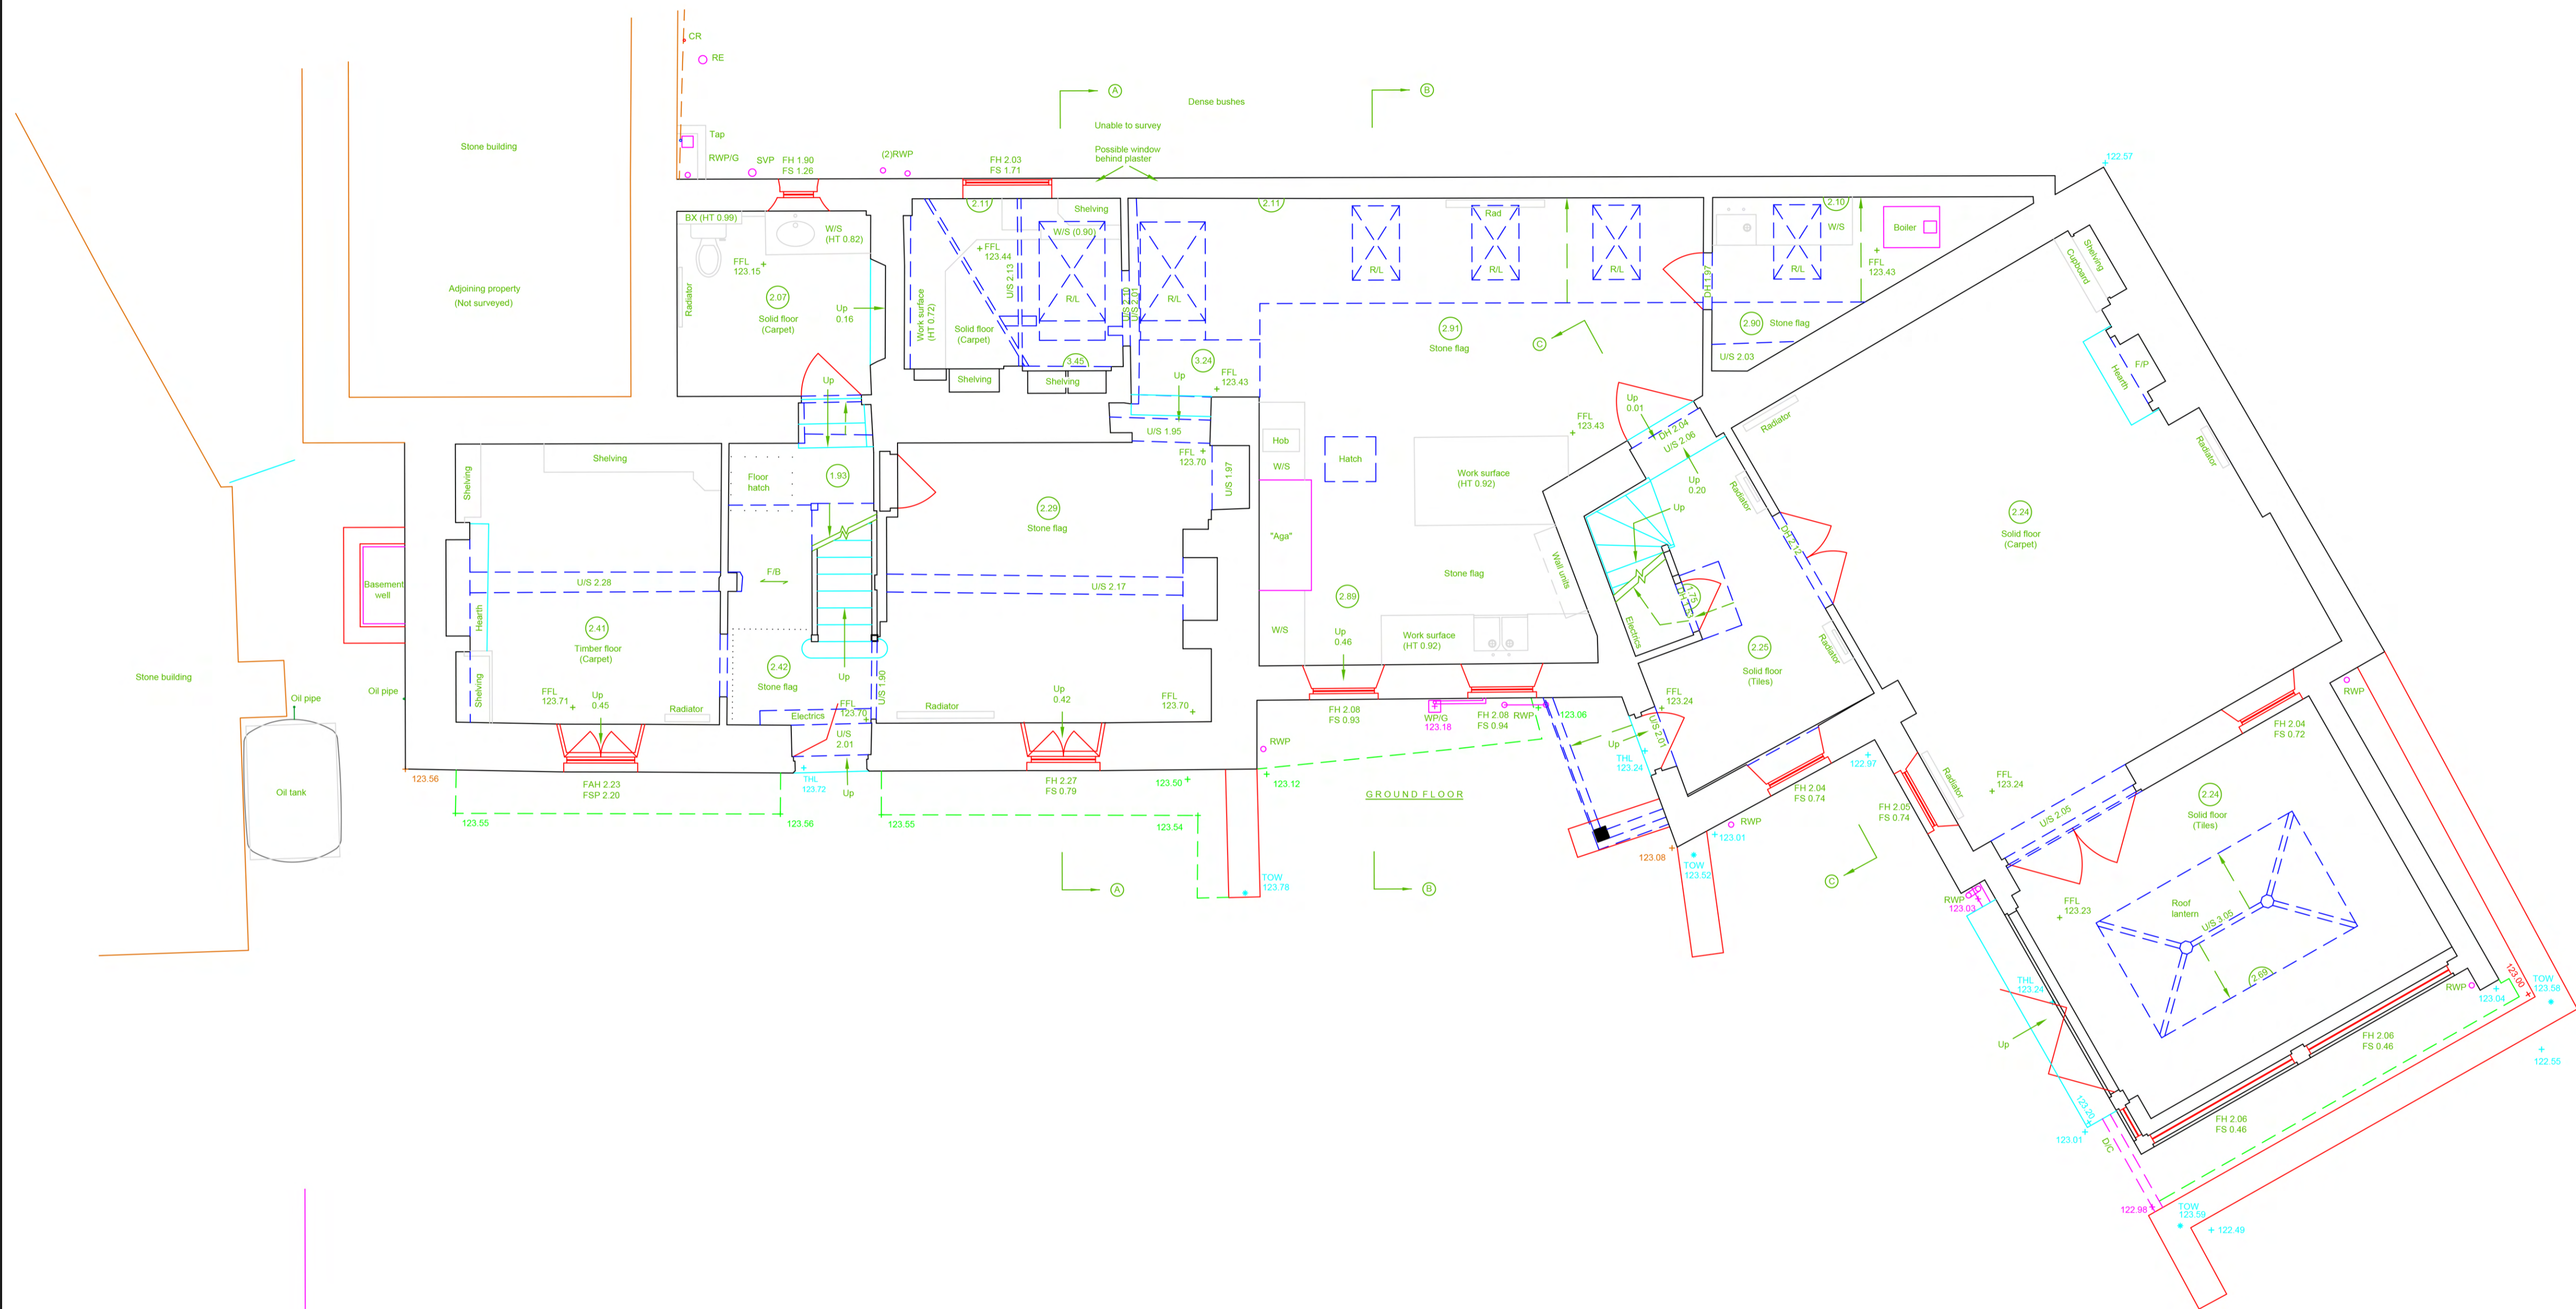

BASEMENT PLAN



 SCALE



CLIENT:	
SITE LOCATION: Blenheim Orchard Upper Oddington GL56 0XG	
SURVEYED BY: MS	DRAWING TITLE: Floor plans
DRAWING NO: P-0581-RW	DATE SURVEYED: 18-05-2022
SCALE: 1:50 @A1	SHEET NO: 2 OF 7