


NOTES


ALL LEVELS ARE IN METRES RELATED TO OSG836/10 DATUM USING LEICA GNSS RECEIVER

KEY - BUILDING

| | | | |
|-------|------------------------|------|-------------------|
| FFL | FINISHED FLOOR LEVEL | BP | BREAK GLASS POINT |
| THL | THRESHOLD LEVEL | FHR | FIRE HOSE REEL |
| FH | FLOOR TO HEAD HEIGHT | FX | FIRE EXTINGUISHER |
| FS | FLOOR TO SILL HEIGHT | S | SMOKE |
| UH | UNDERSIDE HEIGHT | SD | SMOKE DETECTOR |
| DH | DOOR HEIGHT | BN | BONDING |
| AS | ARCH HEAD HEIGHT | BA | BANK |
| SP | SPRINGING POINT HEIGHT | BS | BELL |
| RAD | RADIATOR | CS | CORNER SWITCH |
| HTR | HOT WATER TANK | SS | SINGLE SOCKET |
| BLR | BLENDER | DS | DOUBLE SOCKET |
| HWT | HOT WATER TANK | EL | EMERGENCY LIGHT |
| WC | TOILET | LF | LIGHT FITTING |
| WB | WASH BASIN | LS | LIGHT SWITCH |
| SHR | SHOWER | TV | TELEVISION POINT |
| SST | SINK | TF | TRUNK PIPE |
| UR | URINAL | SP | SPRINKLER |
| HC | HAND DRYER | WP | WASTE PIPE |
| WF | WATER FOUNTAIN | WP | WASTE PIPE |
| RL | ROOF LIGHT | AL | ALARM |
| SUS.C | SUSPENDED CEILING | AB | AIR BRICK |
| DB | DISTRIBUTION BOARD | W | WATER |
| FR | FIRE PLACE | WM | WATER METER |
| B/MTR | BLOCKED METER | AD | AIR BRICK |
| GMTR | GAS METER | BD | BLOCKED DOOR |
| 120 | ROOM HEIGHT | BW | BLOCKED WINDOW |
| 121 | FLOORBOARD & DIRECTION | BR | BRICK |
| 122 | | QT | QUARRY TILES |
| 123 | | CONC | CONCRETE |
| 124 | | TOW | TOP OF WALL |
| 125 | | V | VENT |

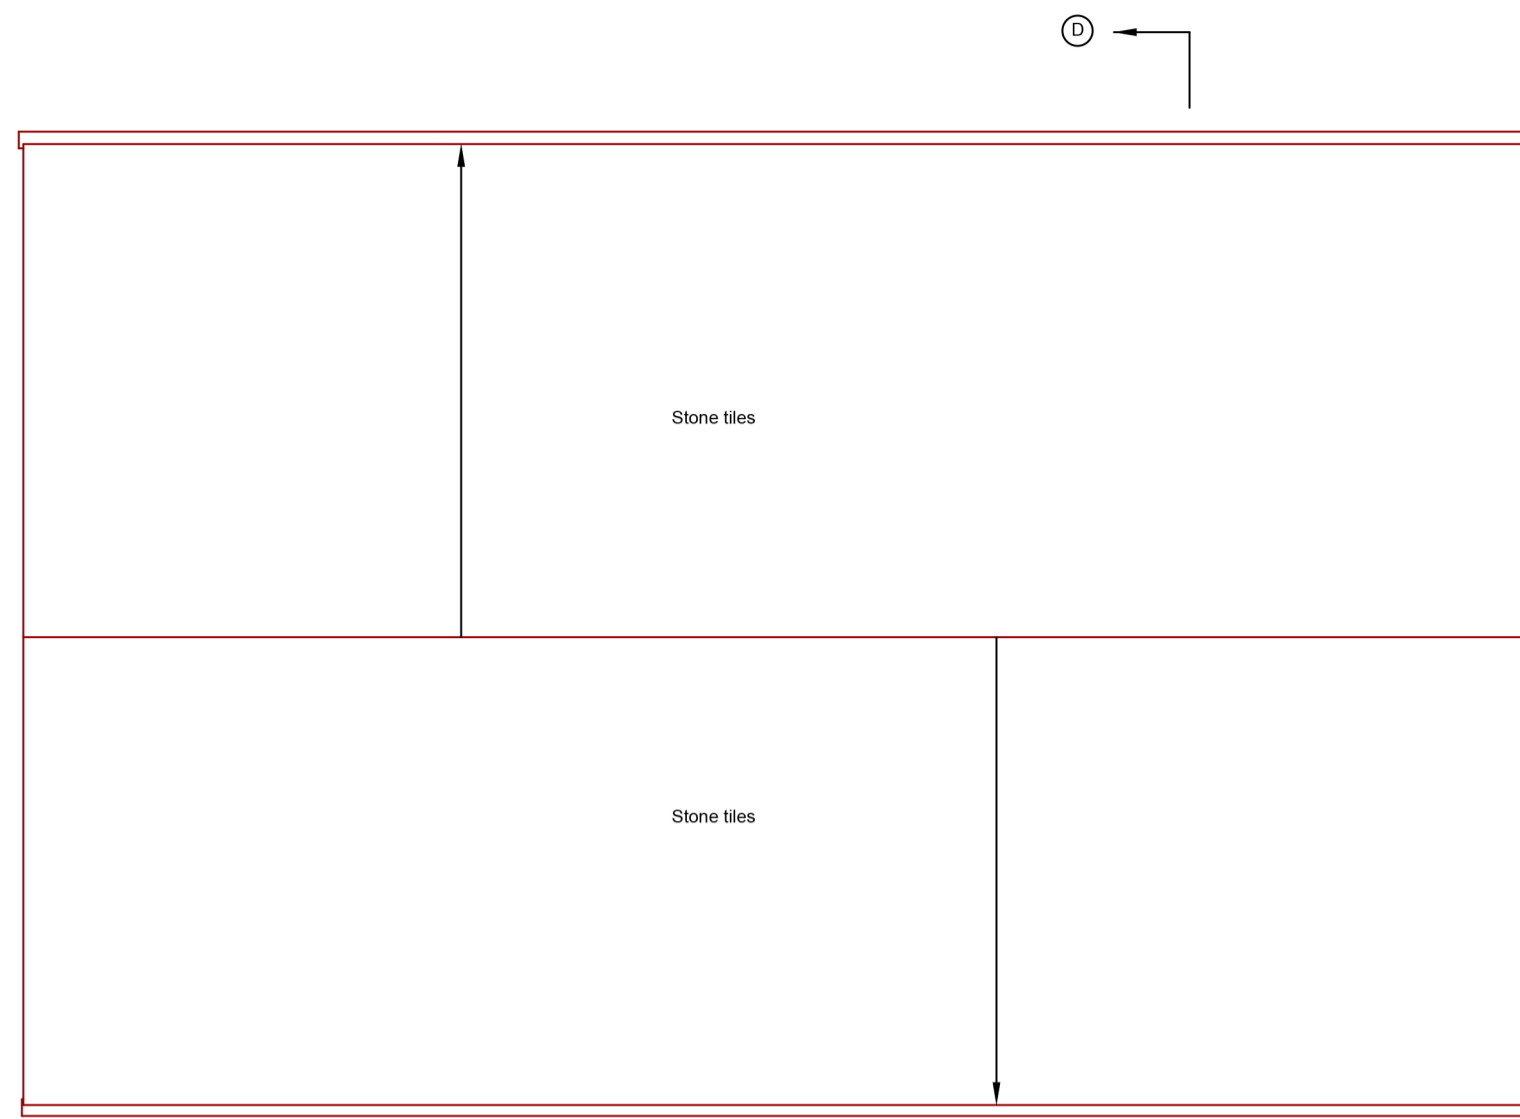


ROOF PLAN
GARAGE

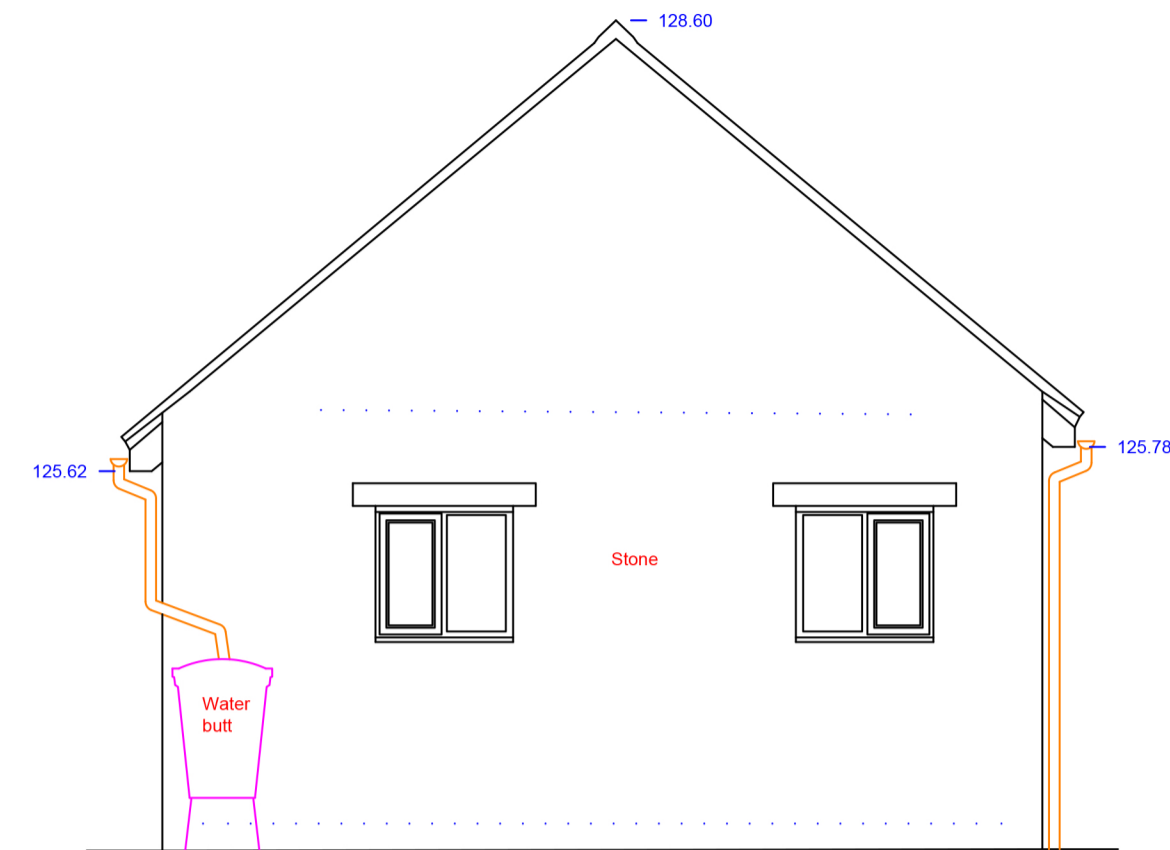


Datum 122.00m

SOUTHEAST ELEVATION

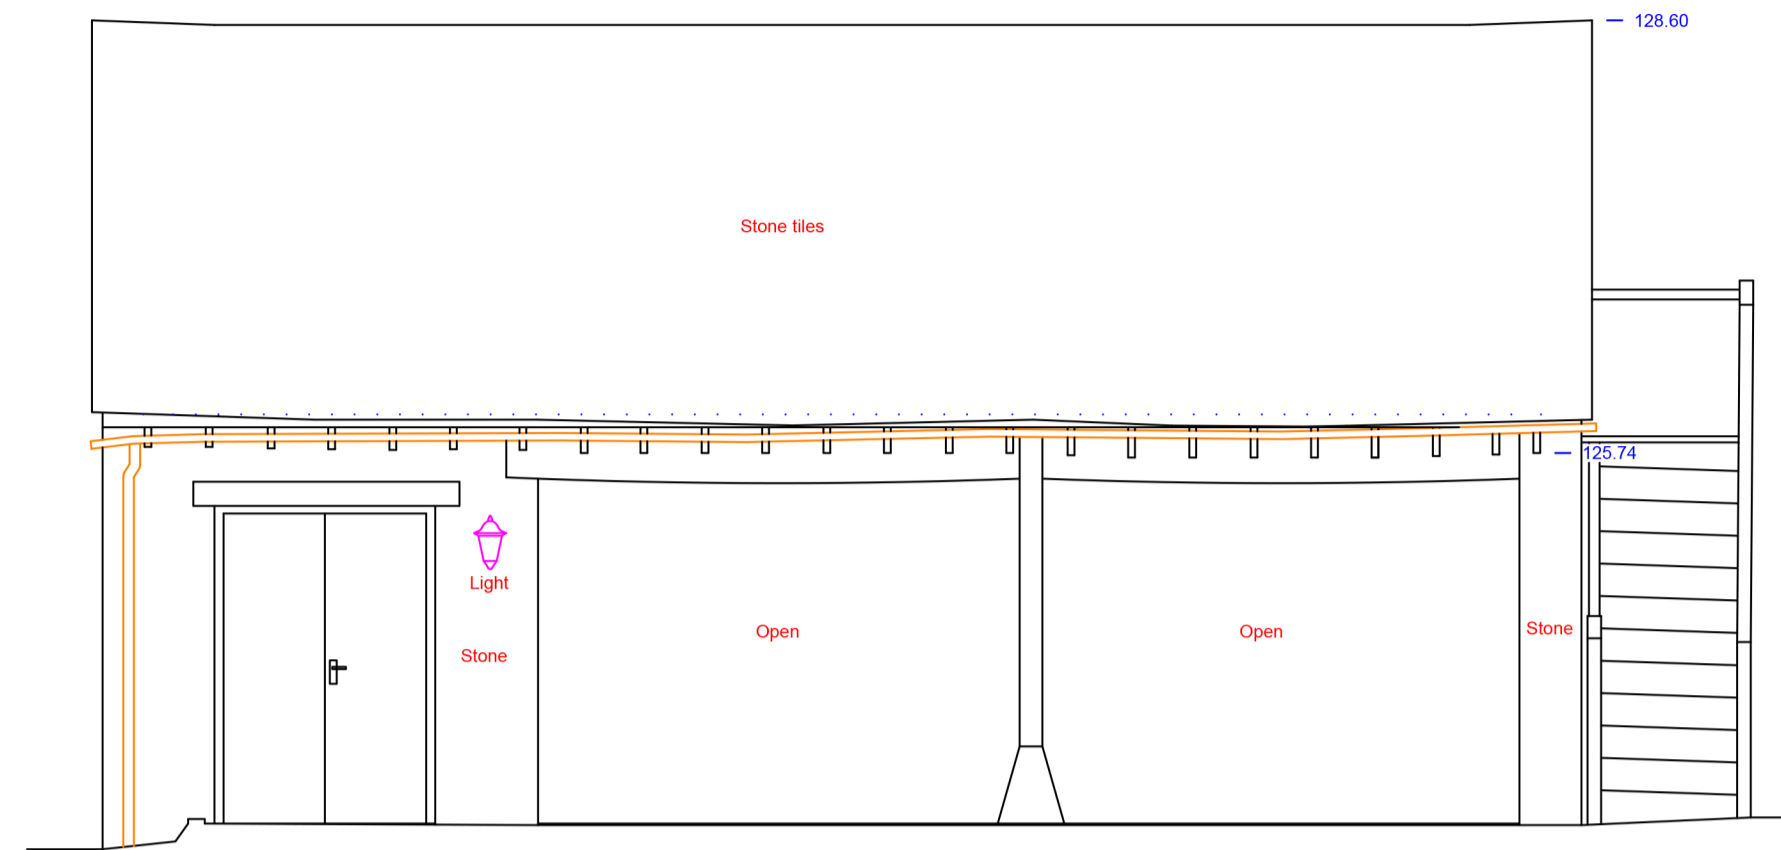


Datum 122.00m

NORTH EAST ELEVATION

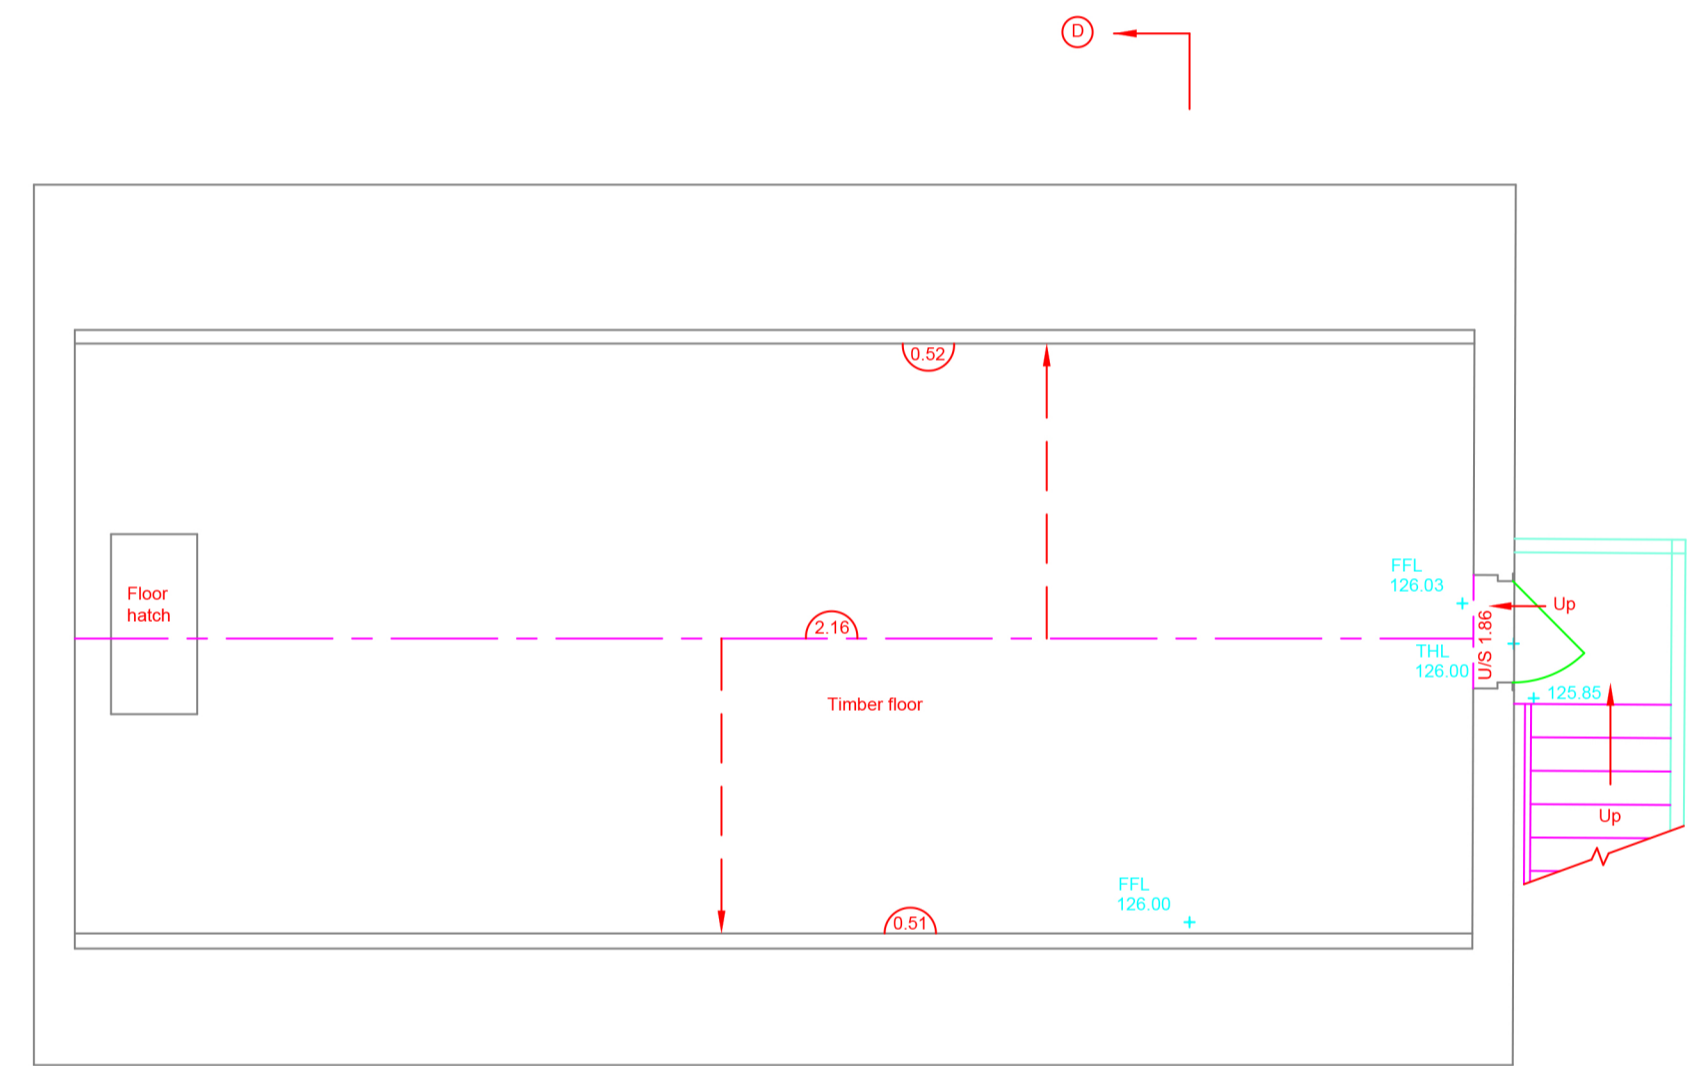


FIRST FLOOR
GARAGE

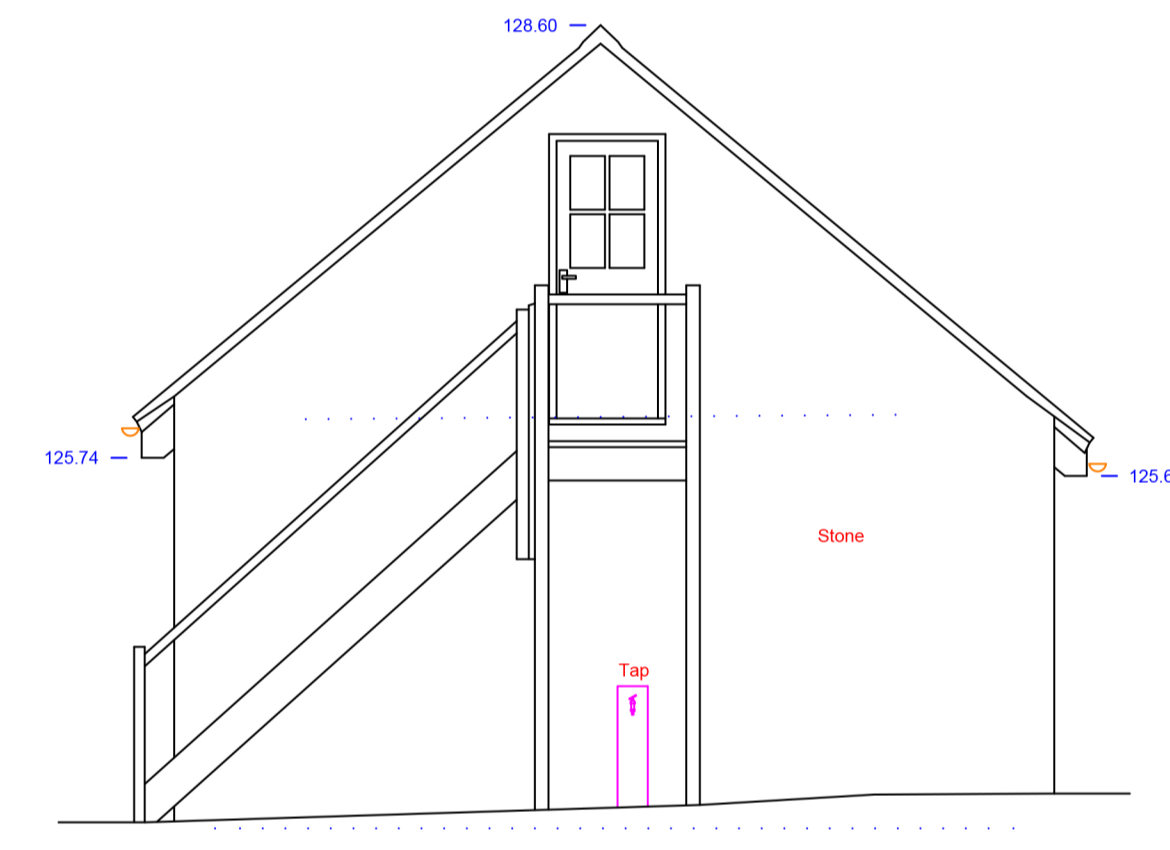


Datum 122.00m

NORTH WEST ELEVATION

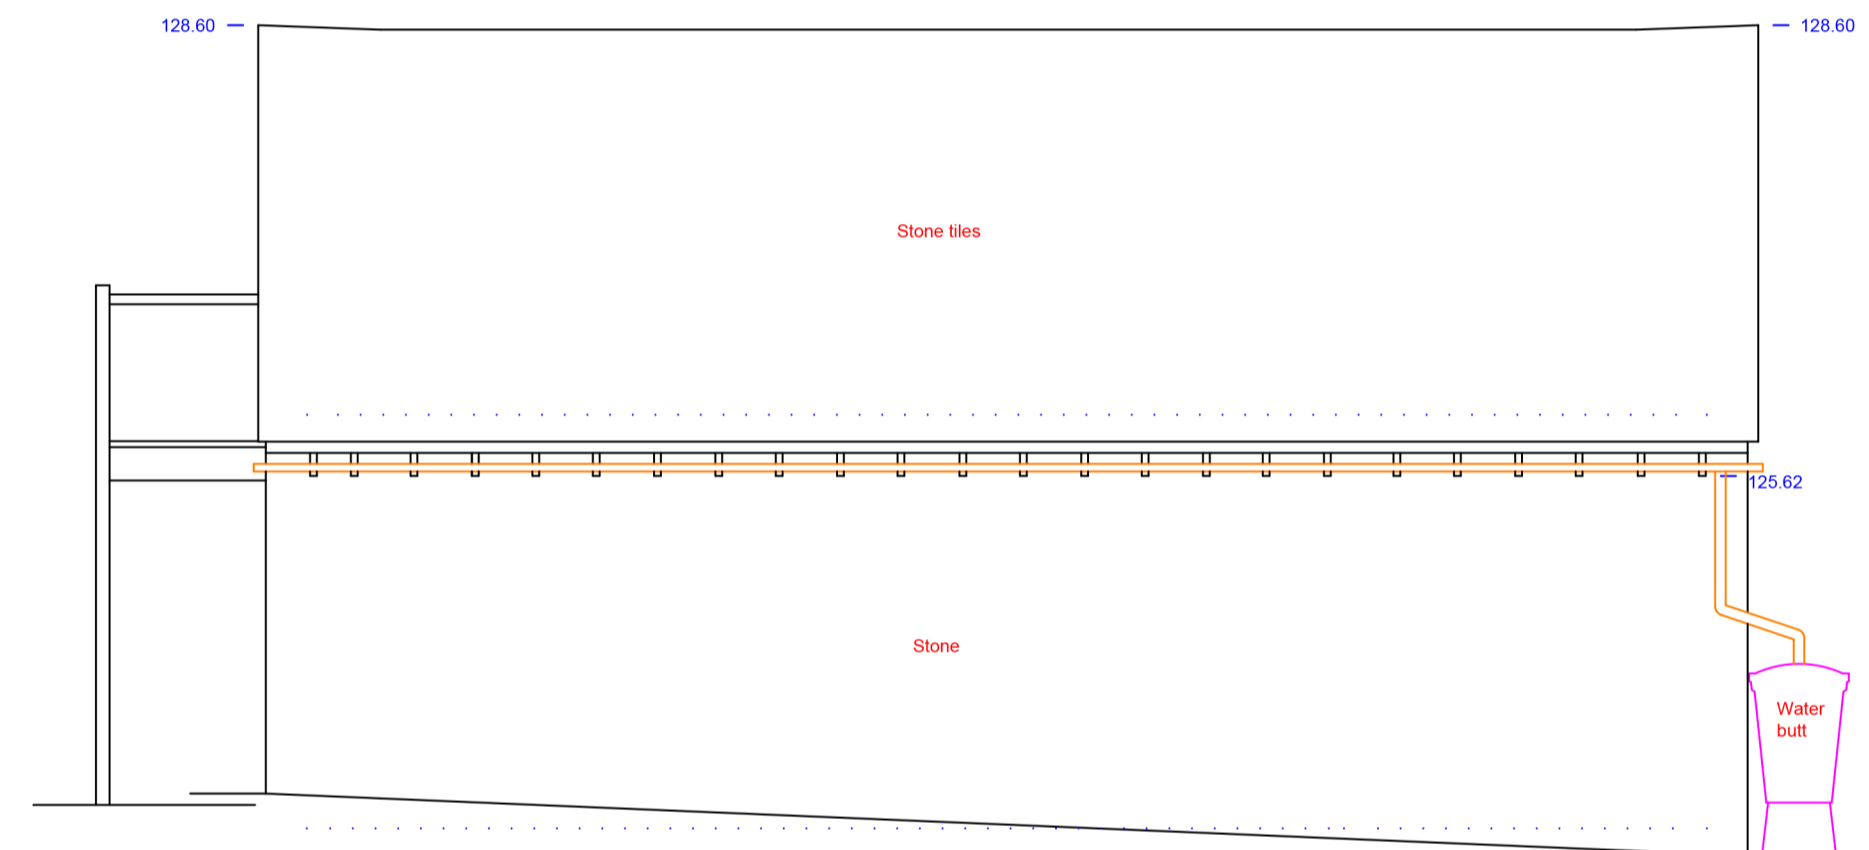


Datum 122.00m

SOUTH WEST ELEVATION

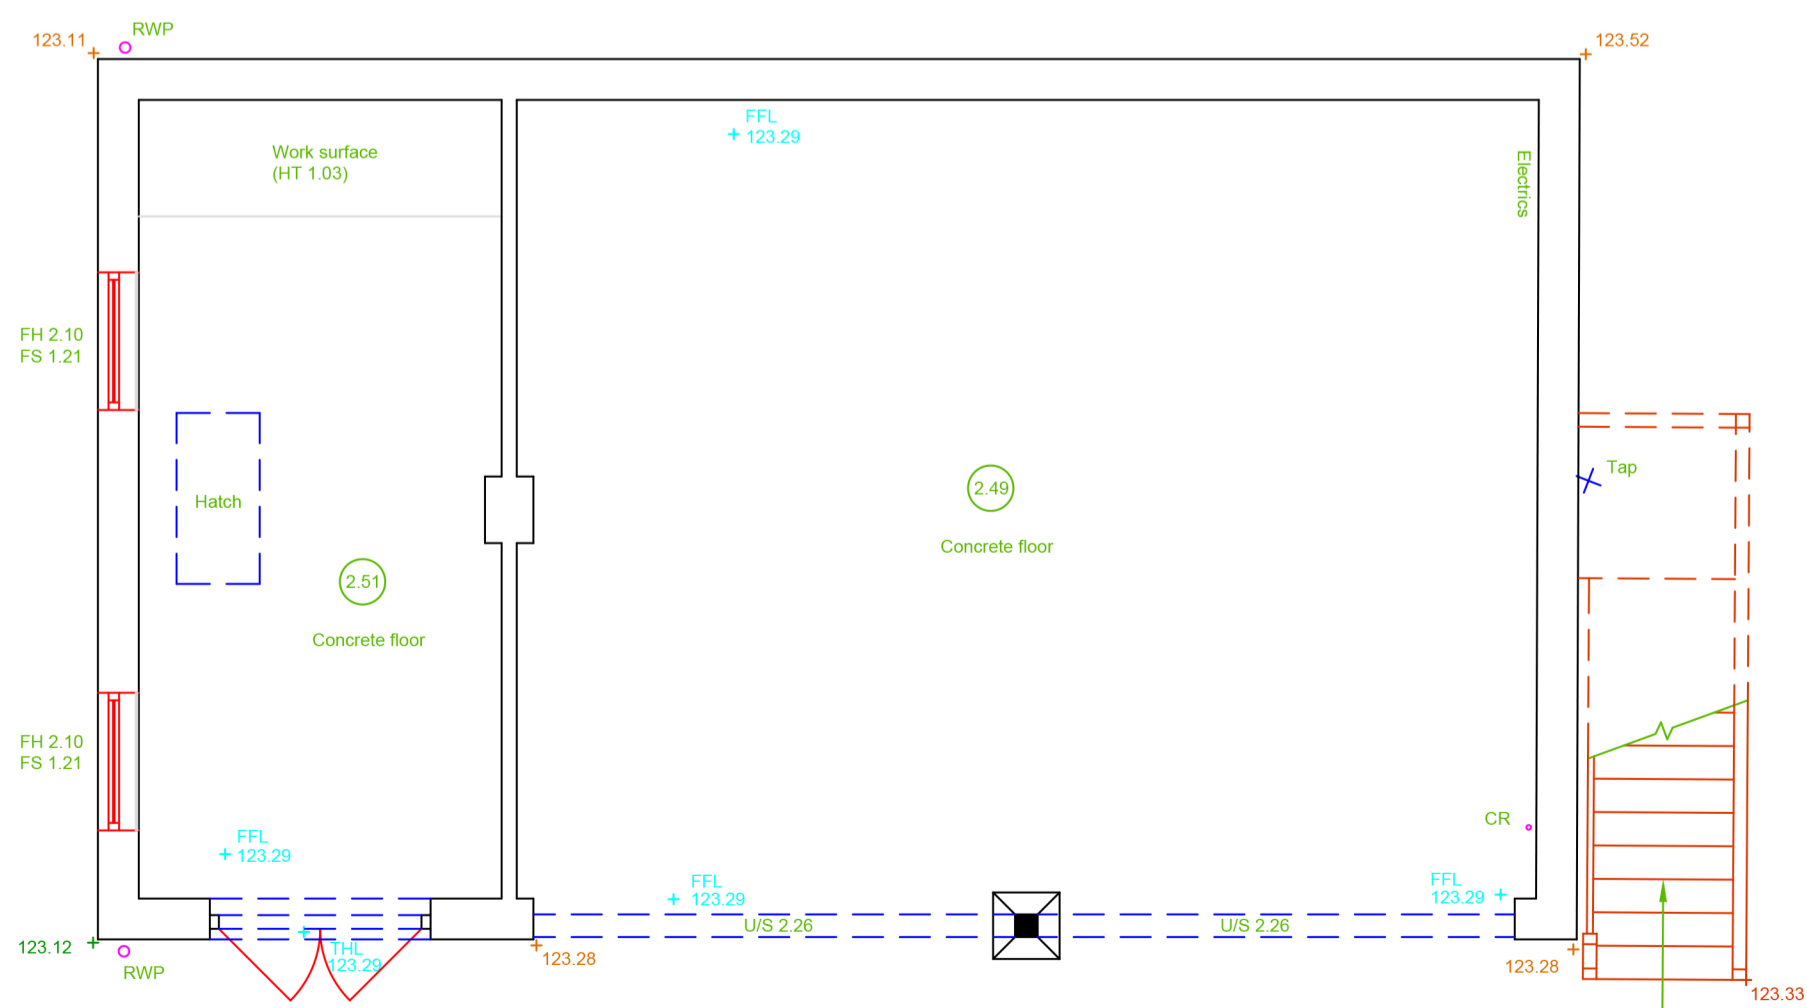

GROUND FLOOR
GARAGE

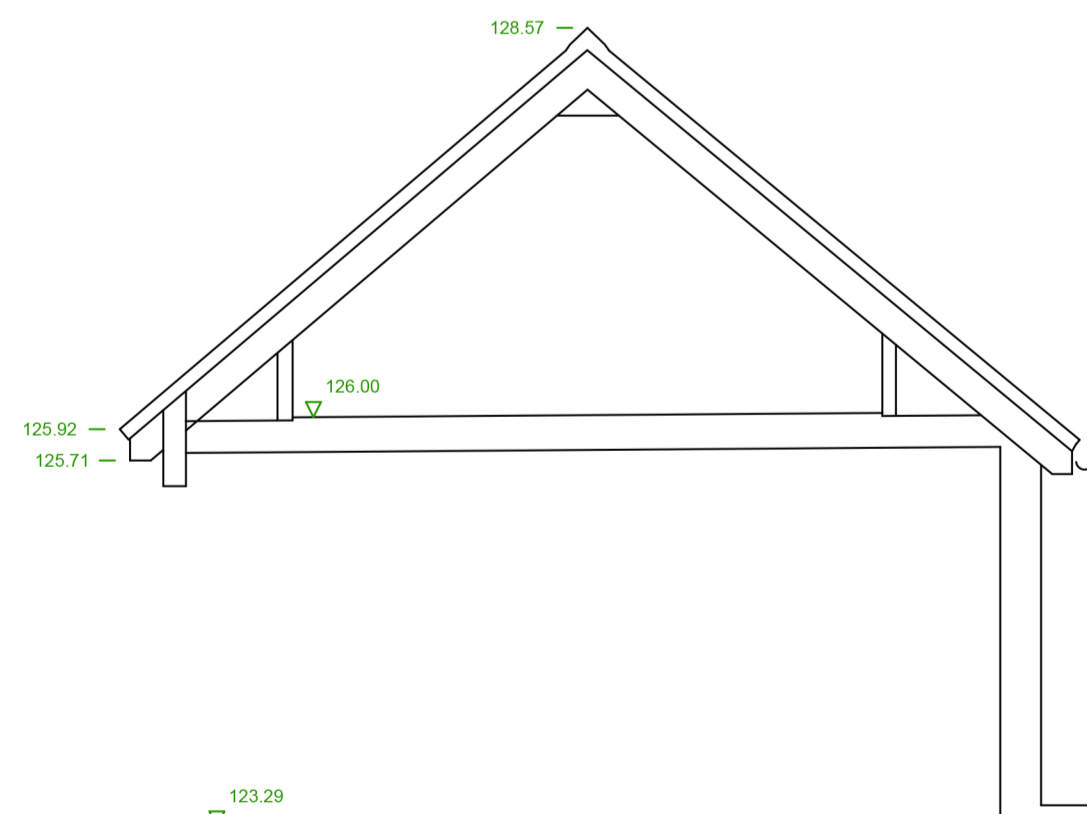

SECTION D-D



SCALE



CLIENT:

SITE LOCATION:

Blenheim Orchard
Upper Oddington
GL56 0XG

SURVEYED BY: MS

DRAWING TITLE: Outbuilding

DRAWING NO: P-0581-RW

DATE SURVEYED: 18-05-2022

SCALE: 1:50 @A1

SHEET NO: 7 OF 7