


NOTES

ALL LEVELS ARE IN METRES RELATED TO 066836/10 DATUM USING LEICA GRS5 RECEIVER


KEY - BUILDING

PFL	FINISHED FLOOR LEVEL	BP	BREAK GLASS POINT
THL	THRESHOLD LEVEL	FHR	FIRE HOSE REEL
FH	FLOOR TO HEAD HEIGHT	FX	FIRE EXTINGUISHER
FS	FLOOR TO SILL HEIGHT	S	SMOKE
US	UNDERSIDE HEIGHT	SD	SMOKE DETECTOR
DH	DOOR HEIGHT	SB	SMOKE
AH	ARCH HEAD HEIGHT	FB	FIRE BELL
SP	SPRINKLING POINT HEIGHT	CS	COORDE SWITCH
RAD	RADIATOR	SS	SINGLE SOCKET
HTR	HEATER	DS	DOUBLE SOCKET
HWT	HOT WATER TANK	EL	EMERGENCY LIGHT
BLR	BLENDER	LF	LIGHT FITTING
WC	WATER CLOSET	LS	LIGHT SWITCH
WB	WASH BASIN	TP	TELEPHONE POINT
SHR	SHOWER	TV	TELEVISION POINT
BST	BISTRETT	SP	DOWN PIPE
UR	URINAL	RWP	RAIN WATER PIPE
HD	HAND DRYER	VP	VENT PIPE
WF	WATER FOUNTAIN	WP	WASTE PIPE
RL	ROOF LIGHT	AL	ALARM
SUS.C	SUSPENDED CEILING	AB	AIR BRICK
DS	DISTRIBUTION BOARD	W	WATER
FR	FIRE PLACE	WM	WATER METER
B/MTR	BLOCKED DOOR	AD	BLOCKED DOOR
GMTR	GAS METER	BW	BLOCKED WINDOW
BRK	BRICK	BM	BRICK
QTY	QUARRY TILES	CT	CONCRETE
CONC	CONCRETE	CONC	CONCRETE
TOW	TOP OF WALL	V	VENT
F/B	FLOORBOARD & DIRECTION		

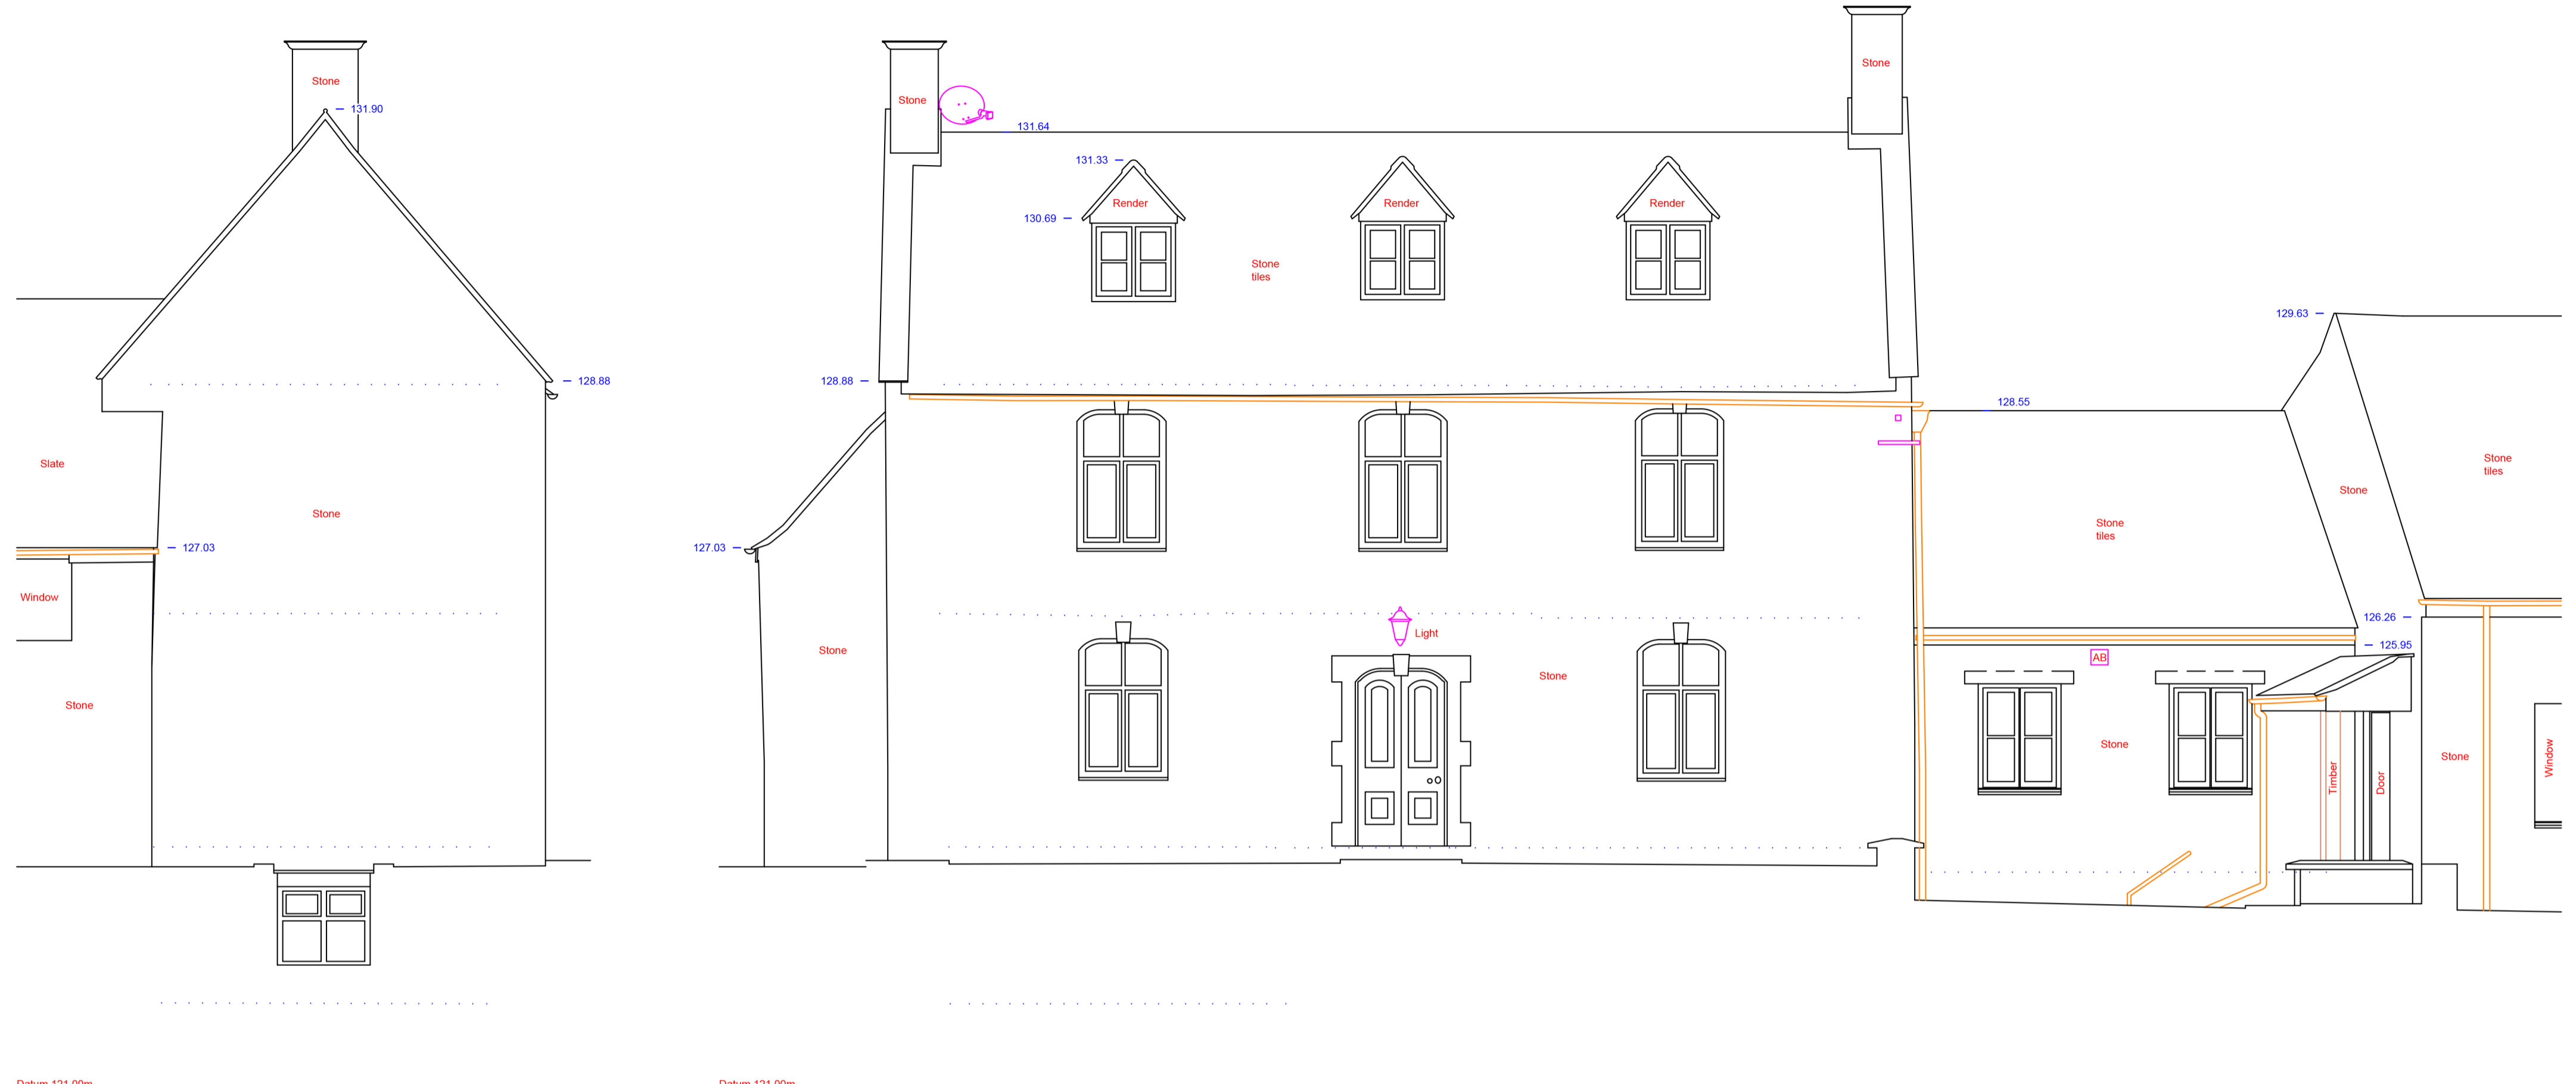

SOUTH WEST ELEVATION

SOUTH EAST ELEVATION

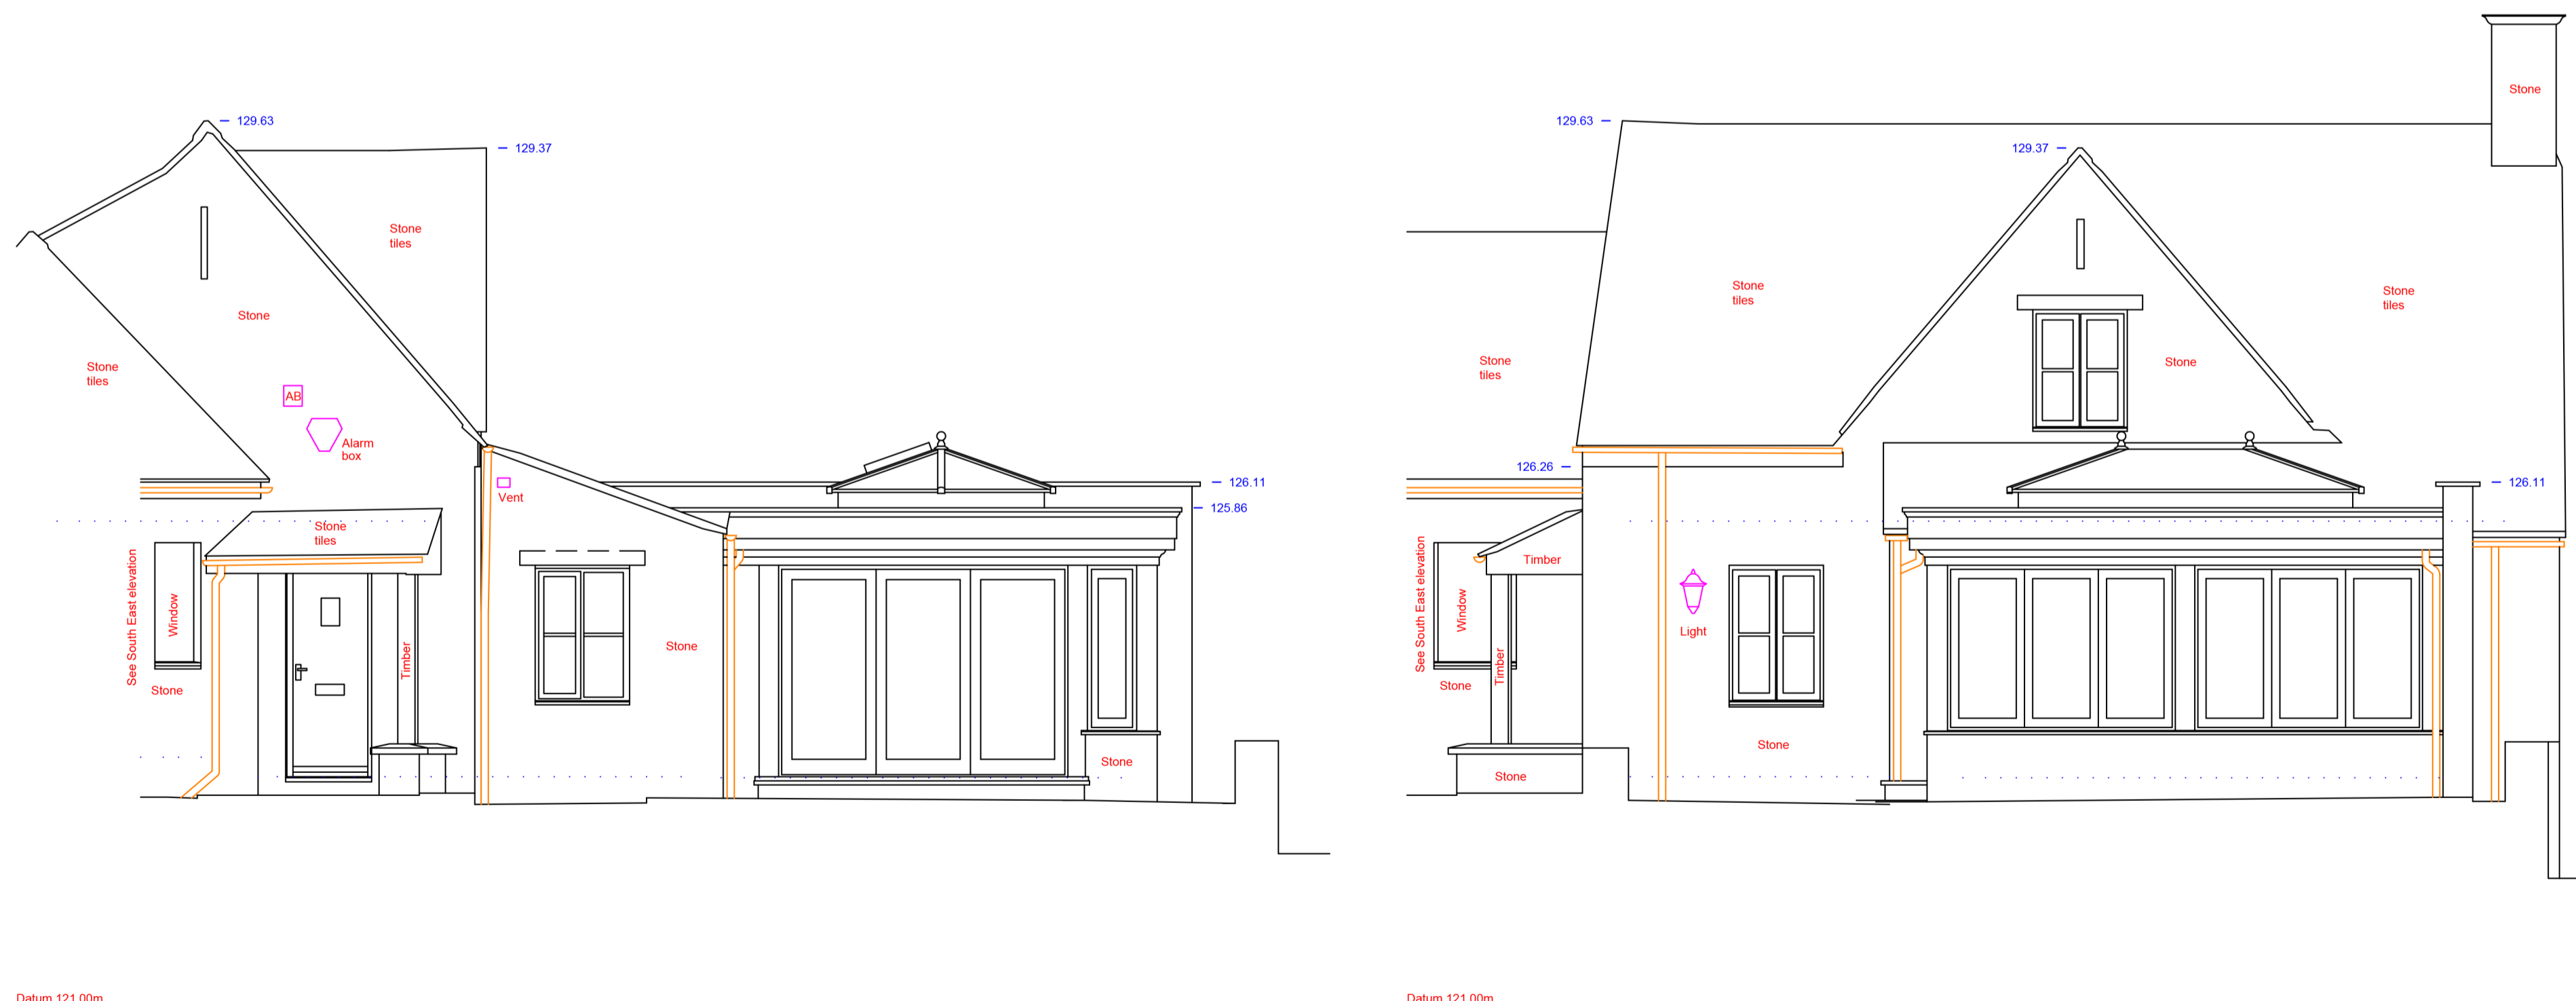

SOUTH ELEVATION

EAST ELEVATION



SCALE



CLIENT:	
SITE LOCATION: Blenheim Orchard Upper Oddington GL56 0XG	
SURVEYED BY: MS	DRAWING TITLE: Elevations
DRAWING NO: P-0581-RW	DATE SURVEYED: 18-05-2022
SCALE: 1:50 @A1	SHEET NO: 4 OF 7