


# NOTES


ALL LEVELS ARE IN METRES RELATED TO 066836/10 DATUM USING LEICA GNSS RECEIVER

## KEY - BUILDING

FFL	FINISHED FLOOR LEVEL	GGP	BREAK GLASS POINT
THL	THRESHOLD LEVEL	FHR	FIRE HOSE REEL
FH	FLOOR TO HEAD HEIGHT	FE	FIRE EXTINGUISHER
FS	FLOOR TO SILL HEIGHT	S	SMOKE
US	UNDERSIDE HEIGHT	SD	SMOKE DETECTOR
DH	DOOR HEIGHT	SB	SMOKE
AH	ARCH HEAD HEIGHT	SB	SMOKE DETECTOR
SP	SPRINKLING POINT HEIGHT	CS	COORNER SWITCH
RAD	RADIATOR	SS	SINGLE SOCKET
HTR	HEATER	DS	DOUBLE SOCKET
HWT	HOT WATER TANK	EL	EMERGENCY LIGHT
BLR	BLENDER	LF	LIGHT FITTING
WC	TOILET	LS	LIGHT SWITCH
WB	WASH BASIN	T	TELEPHONE POINT
SHR	SHOWER	TV	AERIAL POINT
BST	BICEST	UP	UP PIPE
UR	URINAL	WIP	WASTE PIPE
HD	HAND DRYER	VP	VENT PIPE
WF	WATER FOUNTAIN	AL	ALARM
RL	ROOF LIGHT	AB	AIR BRICK
SUS.C	SUSPENDED CEILING	W	WATER
DB	DISTRIBUTION BOARD	WM	WATER METER
FP	FIRE PLACE	AD	BLOCKED DOOR
EMTR	ELECTRICITY METER	BW	BLOCKED WINDOW
GMTR	GAS METER	BR	BRICK
(1.2)	ROOM HEIGHT	QT	QUARRY TILES
↑FB	FLOORBOARD & DIRECTION	CONC	CONCRETE
		TON	TOP OF WALL
		V	VENT

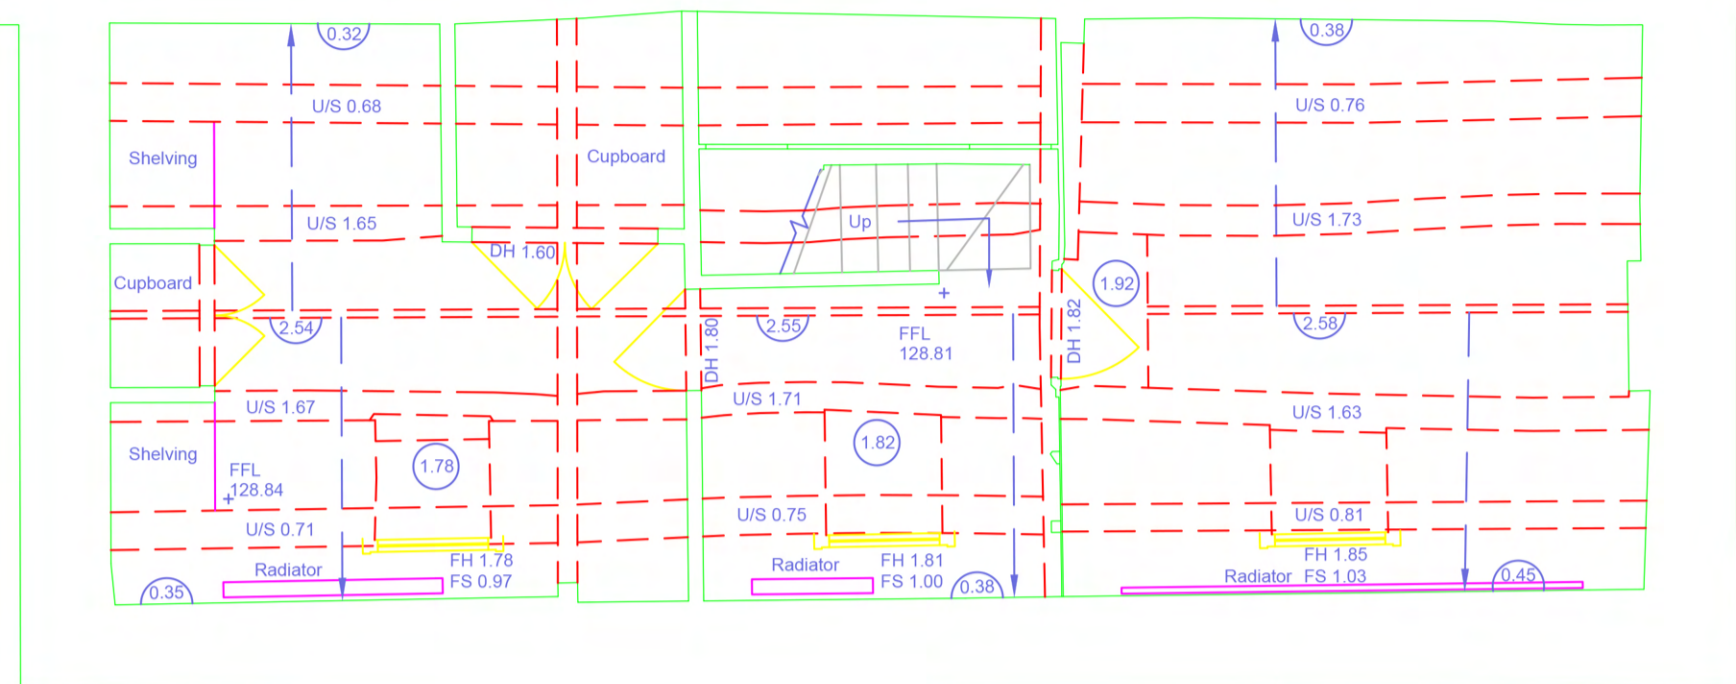


SECOND FLOOR

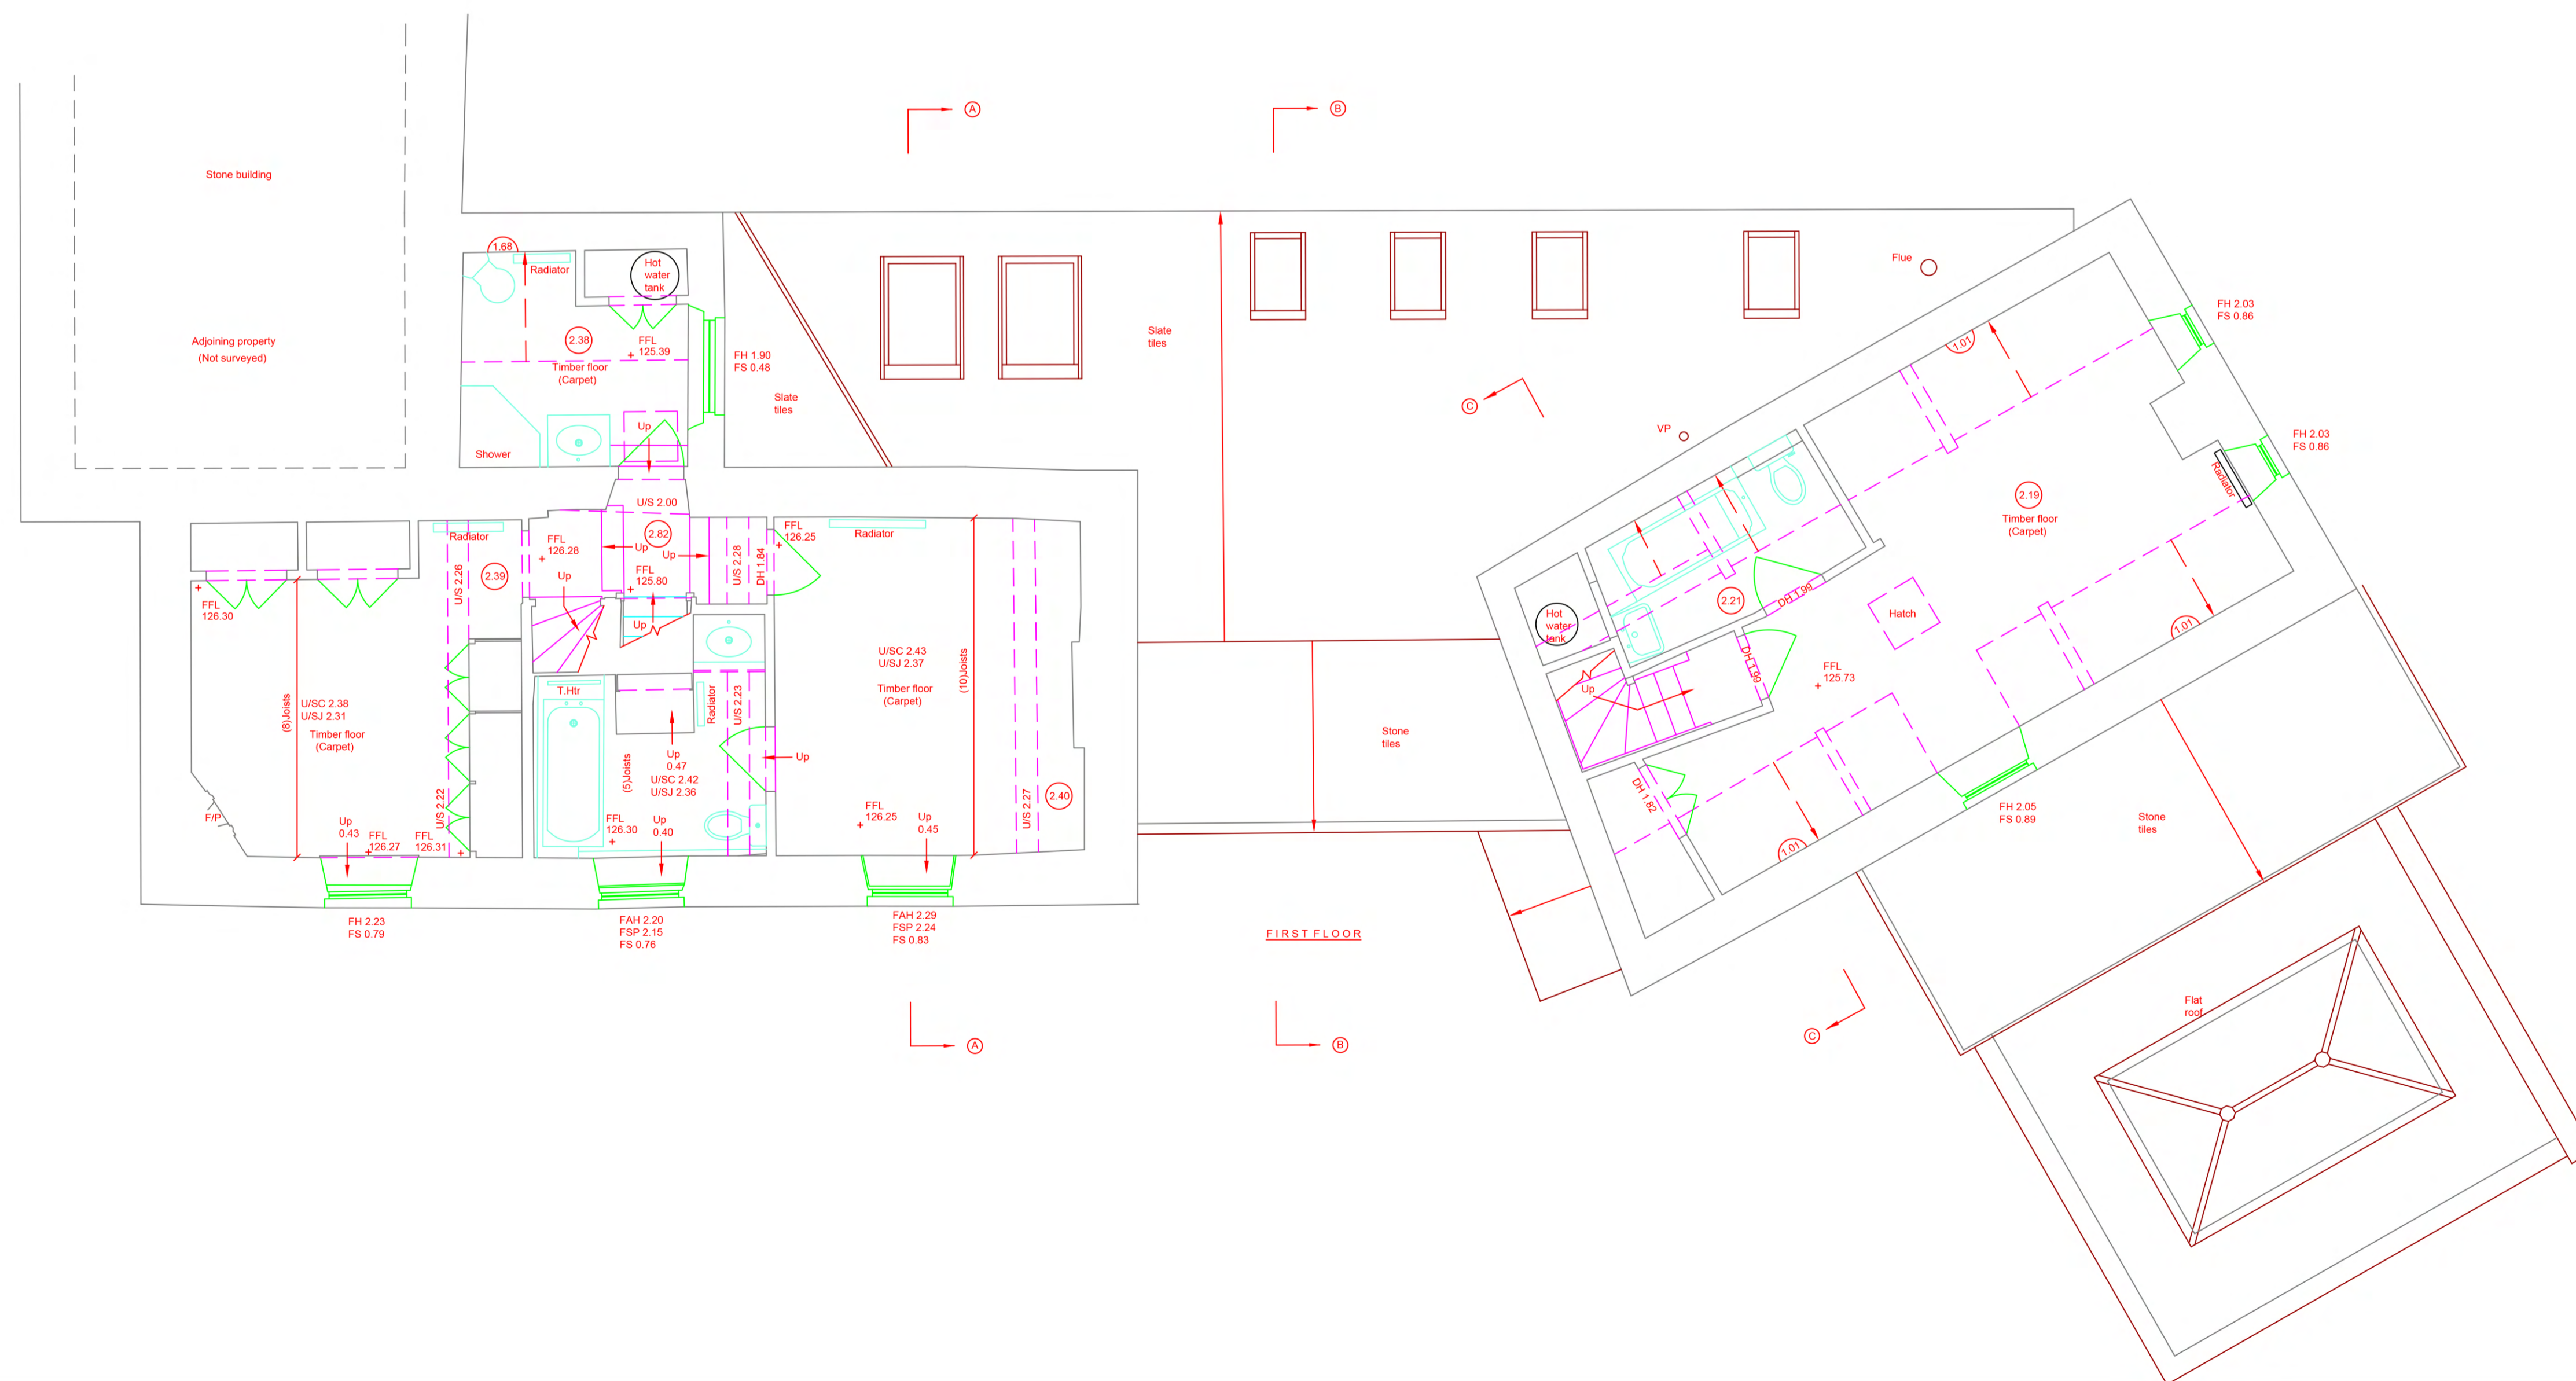

FIRST FLOOR



 SCALE



CLIENT:			
SITE LOCATION:	Blenheim Orchard Upper Oddington GL56 0XG		
SURVEYED BY:	MS	DRAWING TITLE:	Floor plans
DRAWING NO:	P-0581-RW	DATE SURVEYED:	18-05-2022
SCALE:	1:50 @A1	SHEET NO:	3 OF 7