


# NOTES


ALL LEVELS ARE IN METRES RELATED TO 066836110 DATUM USING LEICA GNSS RECEIVER

## KEY - BUILDING

PFL	FINISHED FLOOR LEVEL	BCP	BREAK GLASS POINT
THL	THRESHOLD LEVEL	FHR	FIRE HOSE REEL
FH	FLOOR TO HEAD HEIGHT	FX	FIRE EXTINGUISHER
FS	FLOOR TO SILL HEIGHT	S	SMOKE
US	UNDERSIDE HEIGHT	SD	SMOKE DETECTOR
DH	DOOR HEIGHT	SB	SMOKE
AH	ARCH HEAD HEIGHT	FB	FIRE BELL
SP	SPRINKLING POINT HEIGHT	CS	COORDE SWITCH
RAD	RADIATOR	SS	SINGLE SOCKET
HTR	HEATER	DS	DOUBLE SOCKET
HWT	HOT WATER TANK	EL	EMERGENCY LIGHT
BLR	BLENDER	LF	LIGHT FITTING
WC	TOILET	LS	LIGHT SWITCH
WB	WASH BASIN	TF	TELEPHONE POINT
SHR	SHOWER	TV	AERIAL POINT
SST	SIEVE	DF	DRAIN PIPE
UR	URINAL	RP	RAIN WATER PIPE
HD	HAND DRYER	VP	VENT PIPE
WF	WATER FOUNTAIN	WP	WASTE PIPE
RL	ROOF LIGHT	AL	ALARM
SUS.C	SUSPENDED CEILING	AB	AIR BRICK
DE	DISTRIBUTION BOARD	W	WATER
FP	FIRE PLACE	WM	WATER METER
B.MTR	ELECTRICITY METER	AD	BLOCKED DOOR
GMTR	GAS METER	BW	BLOCKED WINDOW
120	ROOM HEIGHT	BR	BRICK
↑ FIB	FLOORBOARD & DIRECTION	QT	QUARRY TILES
		CONC	CONCRETE
		TOW	TOP OF WALL
		V	VENT

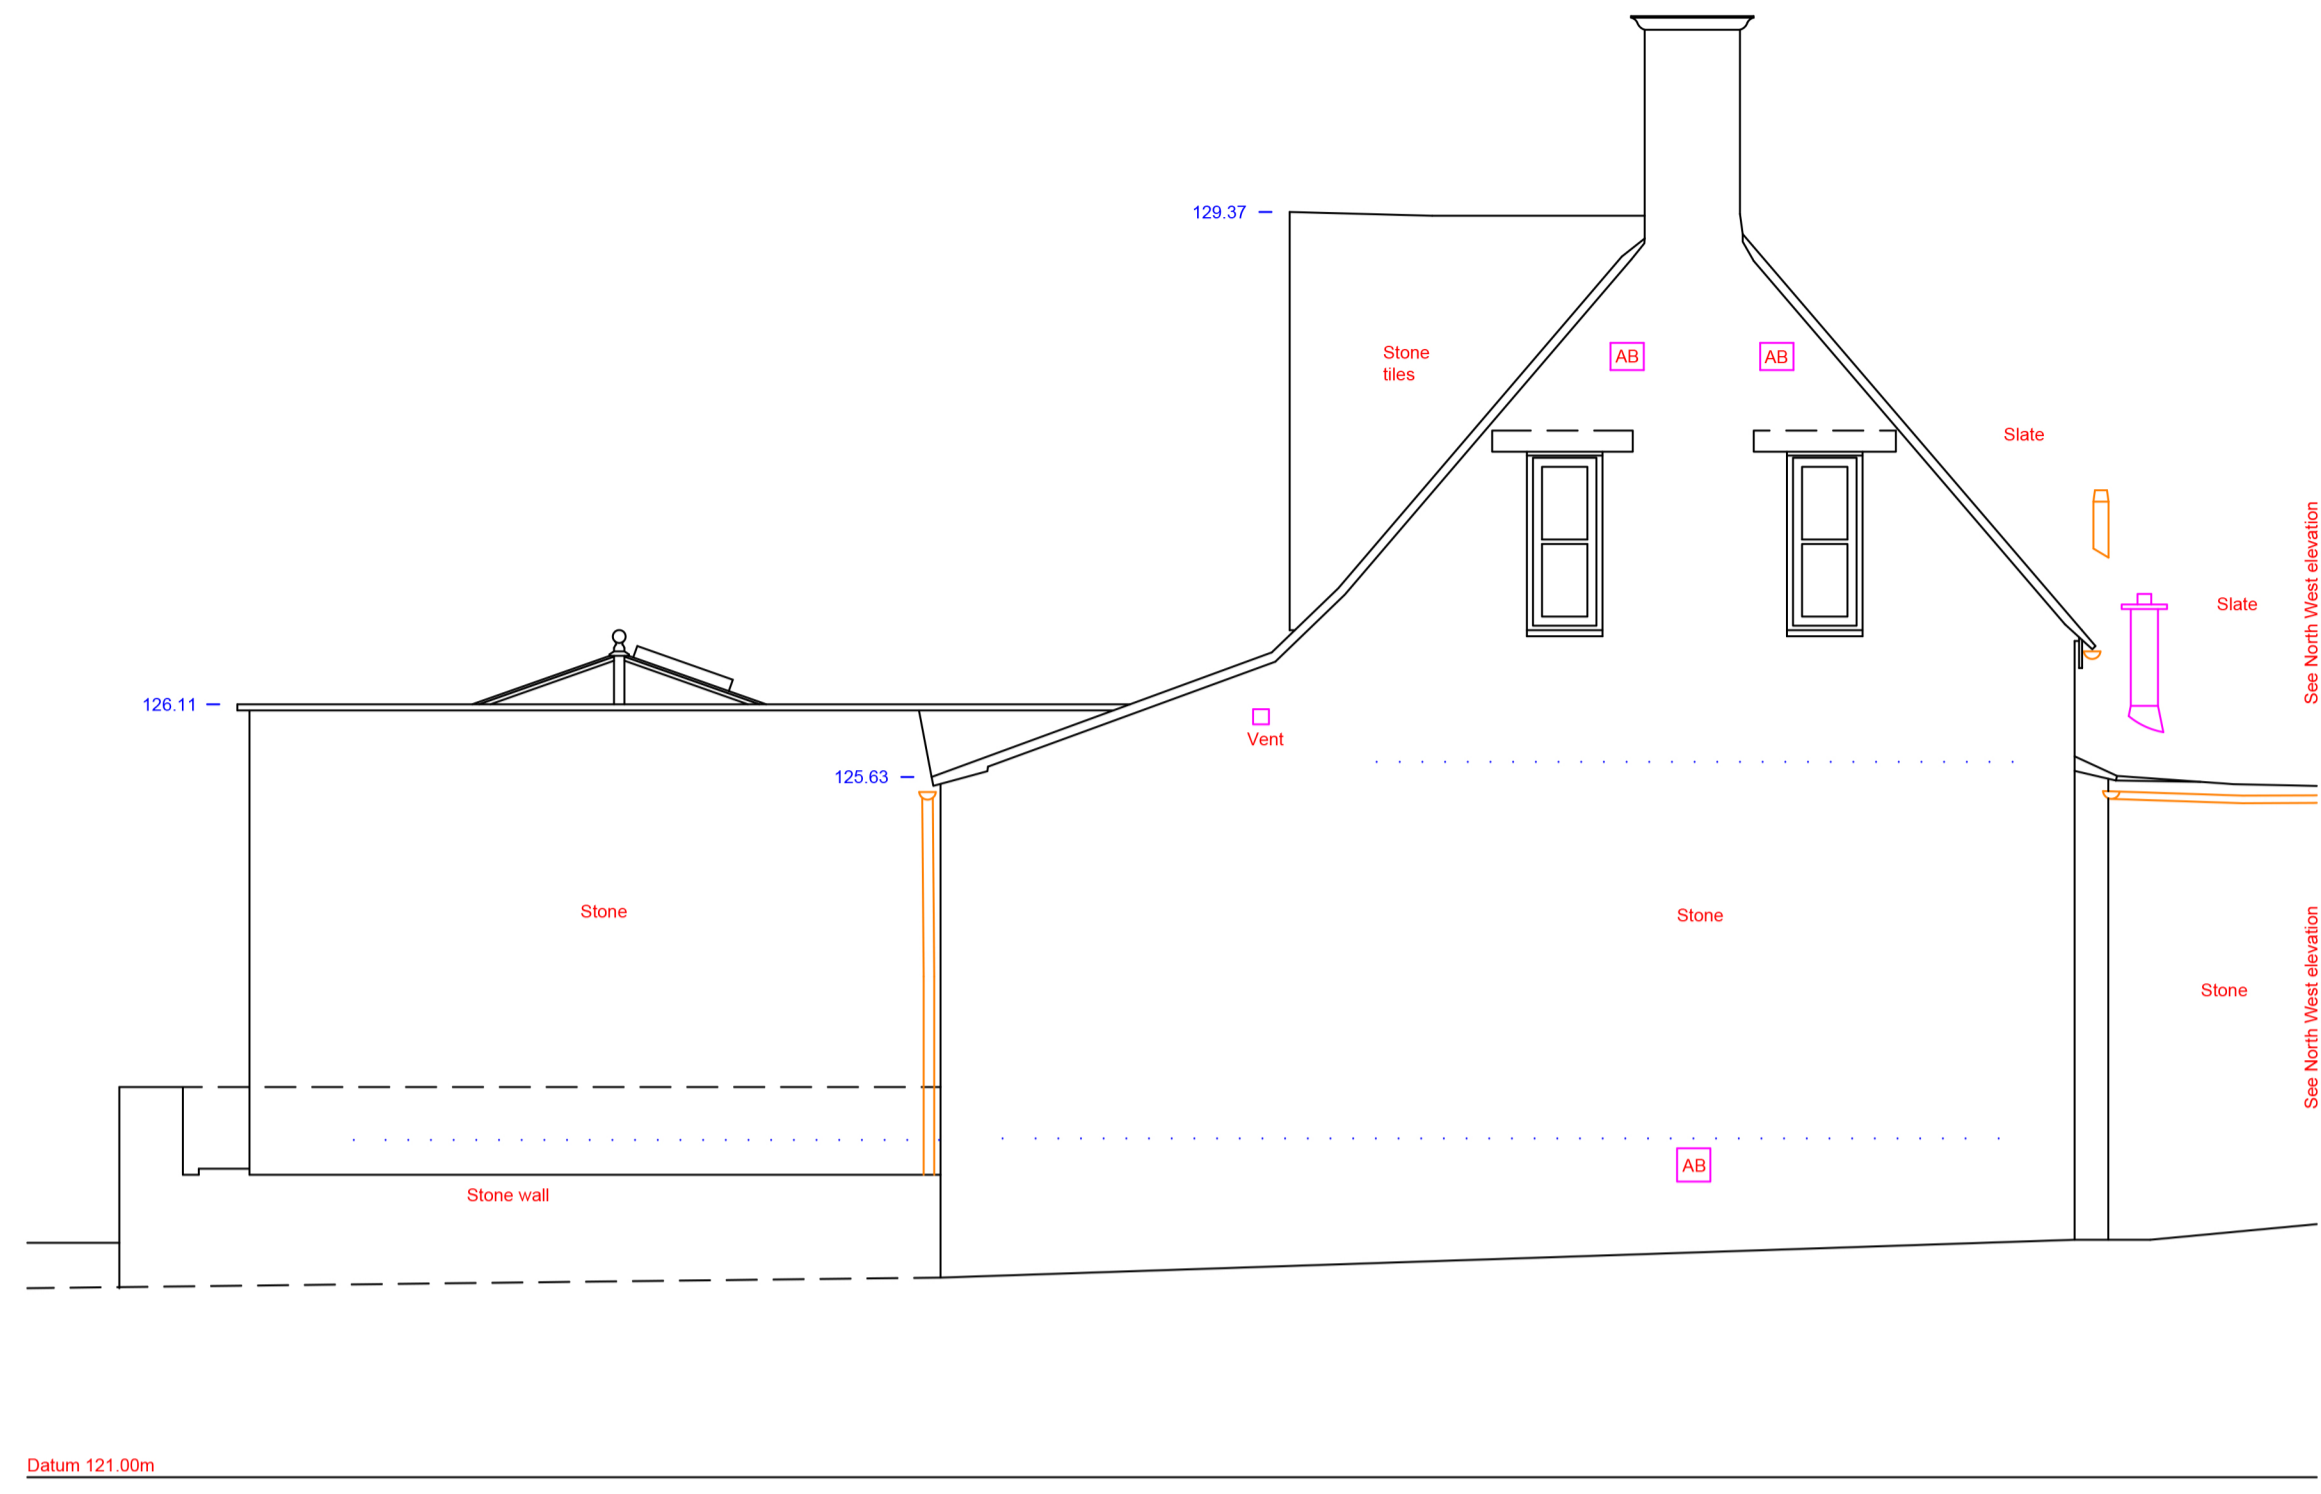

NORTH ELEVATION

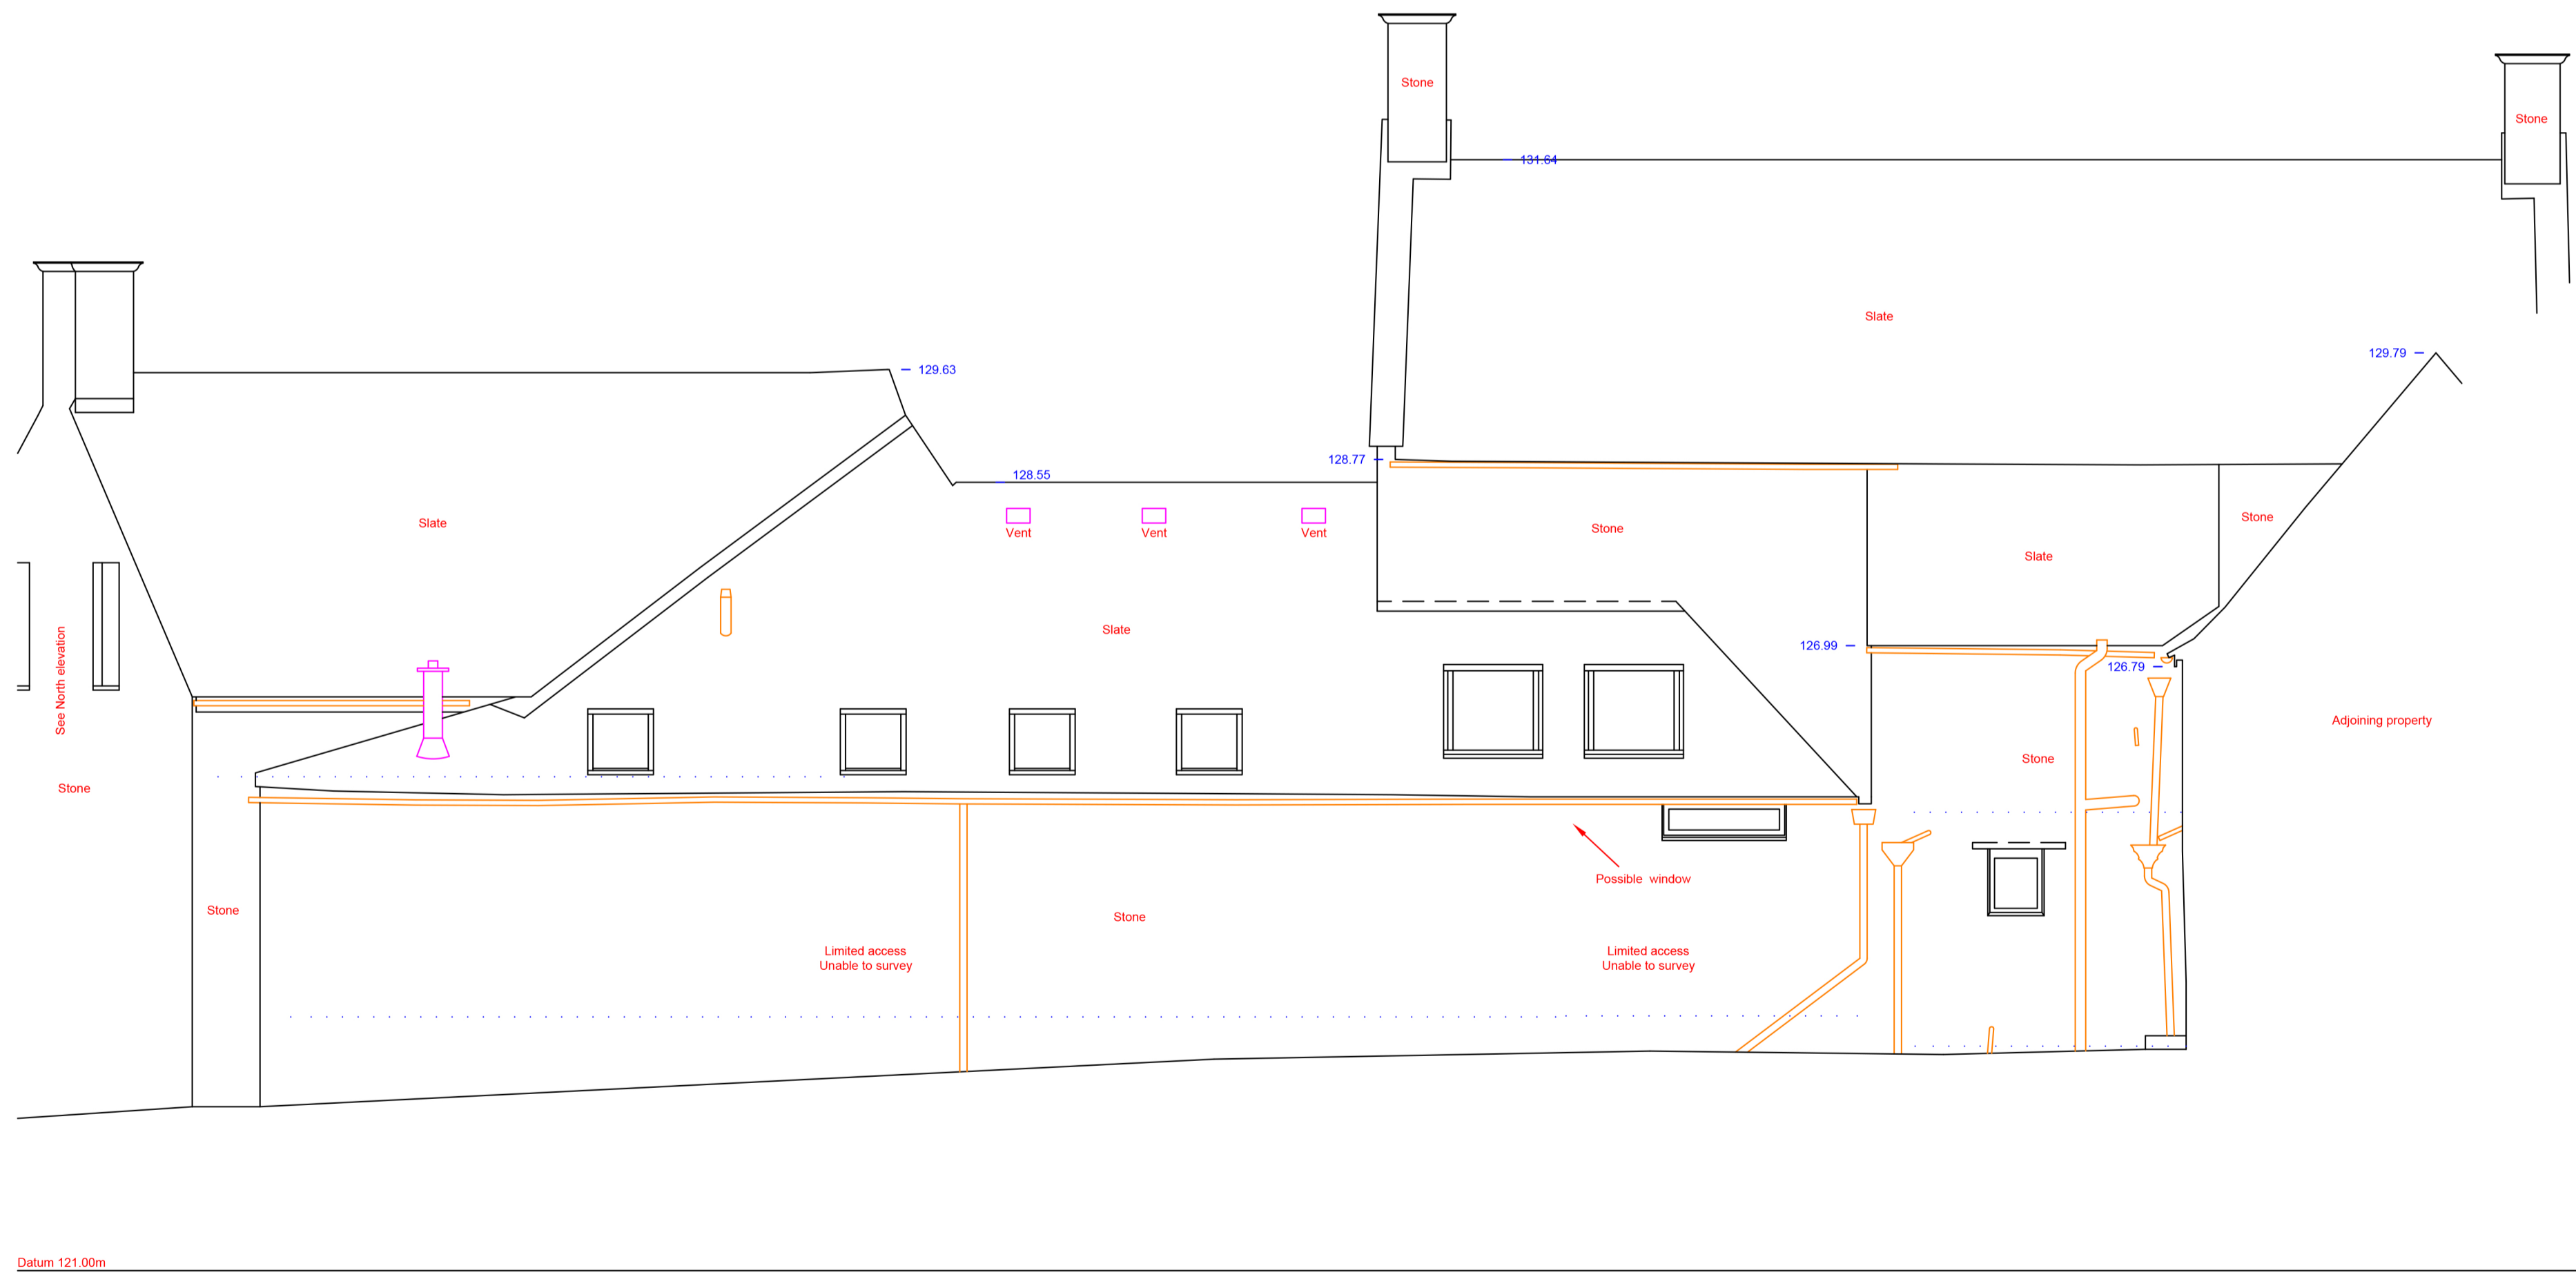

NORTH WEST ELEVATION



SCALE



CLIENT:	
SITE LOCATION: Blenheim Orchard Upper Oddington GL56 0XG	
SURVEYED BY: MS	DRAWING TITLE: Elevations
DRAWING NO: P-0581-RW	DATE SURVEYED: 18-05-2022
SCALE: 1:50 @A1	SHEET NO: 5 OF 7