


Existing fuel oil line from oil tank to boiler runs below ground adjacent to existing building and rises to service valve, and automatic fire cut off valve, before being ducted underground below boiler plinth. This to be removed after new oil line connected to keep boiler operational.

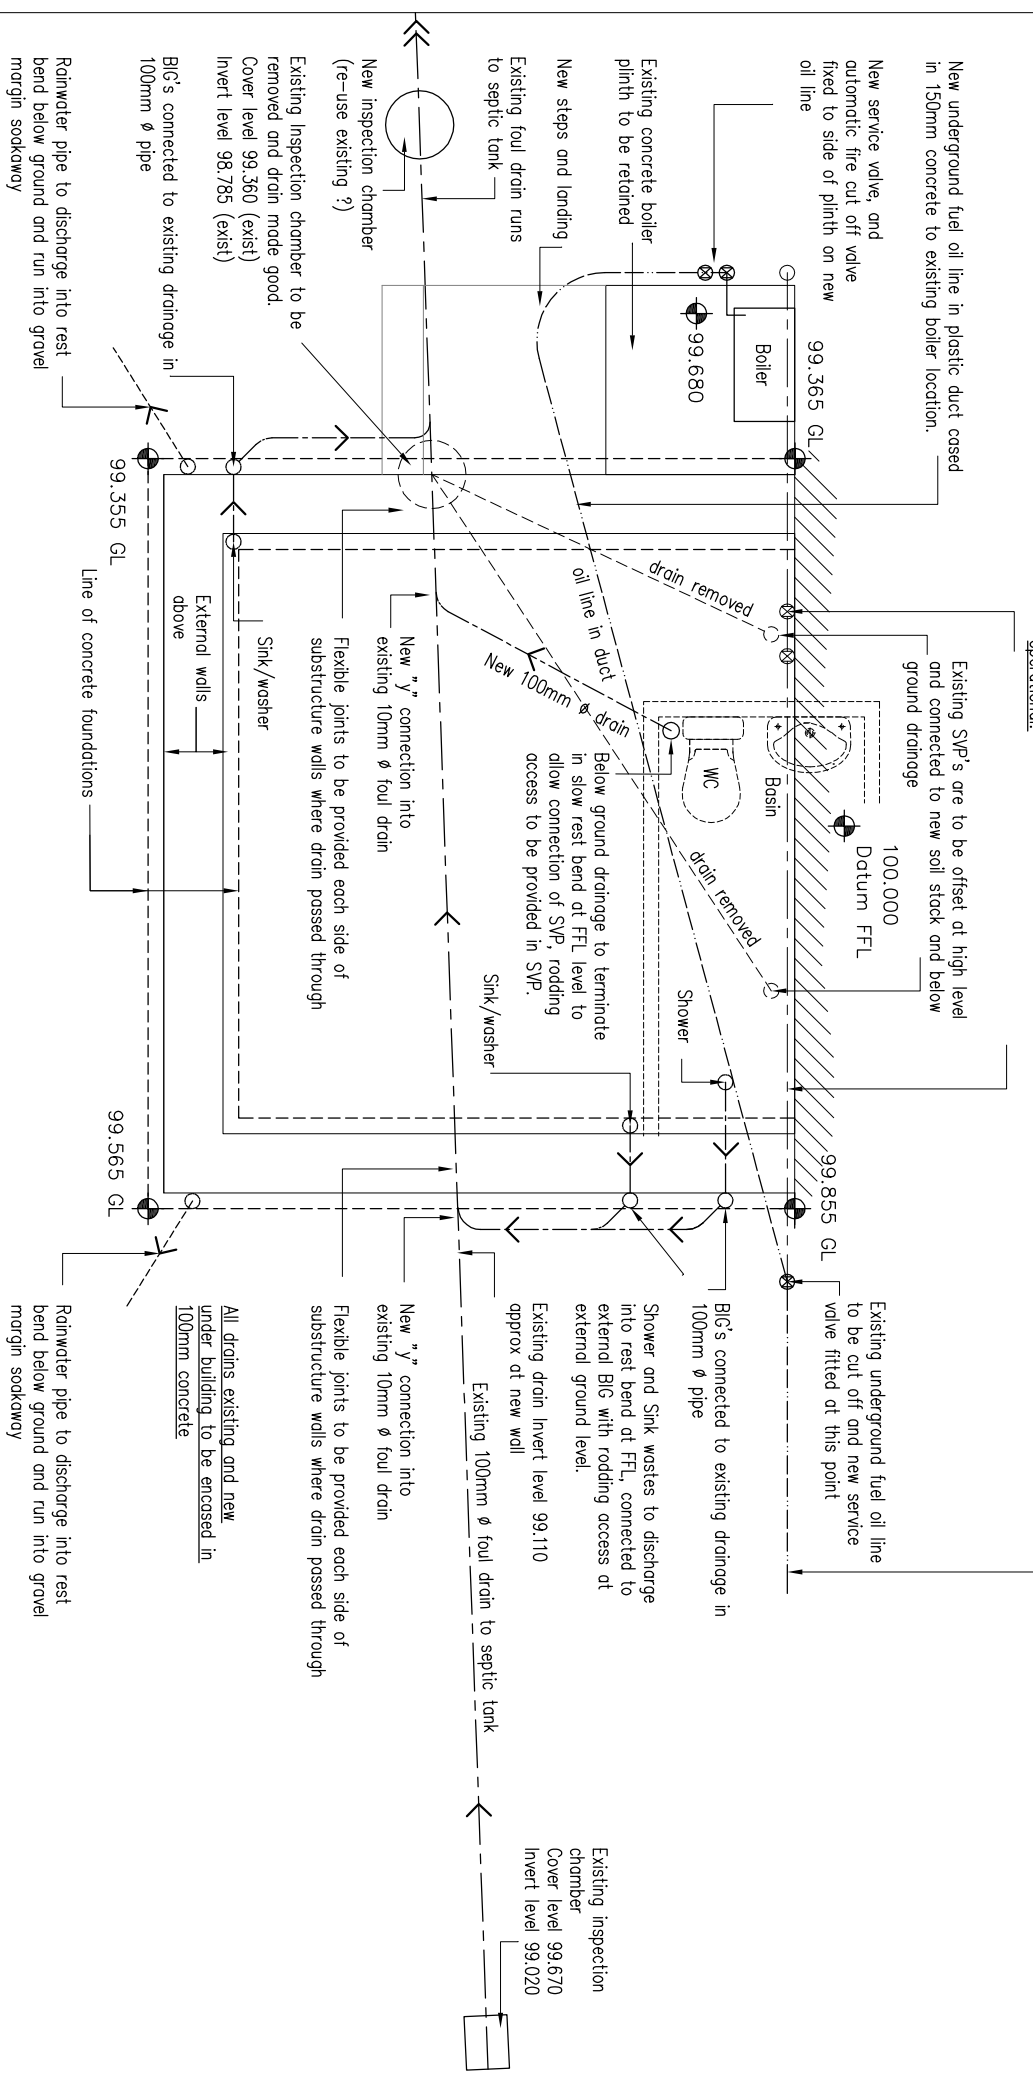

NOTE
 This drawing is to be read in conjunction with the Building Regulation
 Compliance notes related to this project dated 28 March 2023

Revisions
 A-10/04/23-Minor amendments for Building Regulation application

Proposed Utility Room Extension
Dr and Mrs R Kandler
 Low Wood, Braithwaite Lane, Dacre, Harrogate HG3 4AS.

Underground Drainage layout
 Date 28 Mar 2023

Scale 1:50@A4
 Drg No **07** /A