
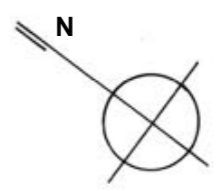


- KEY**
- SOIL DRAINAGE
 - SOIL MANHOLES; 1,2,3,4.....
 - ▣ RAIN WATER RODDING EYES
 - SURFACE WATER DRAINAGE
 - ⊕ SVP's 1,2,3,4.....
 - RWP's 1,2,3,4.....
 - FINAL INSPECTION MANHOLE
 - ⊕ FINAL RAINWAR INSPECTION

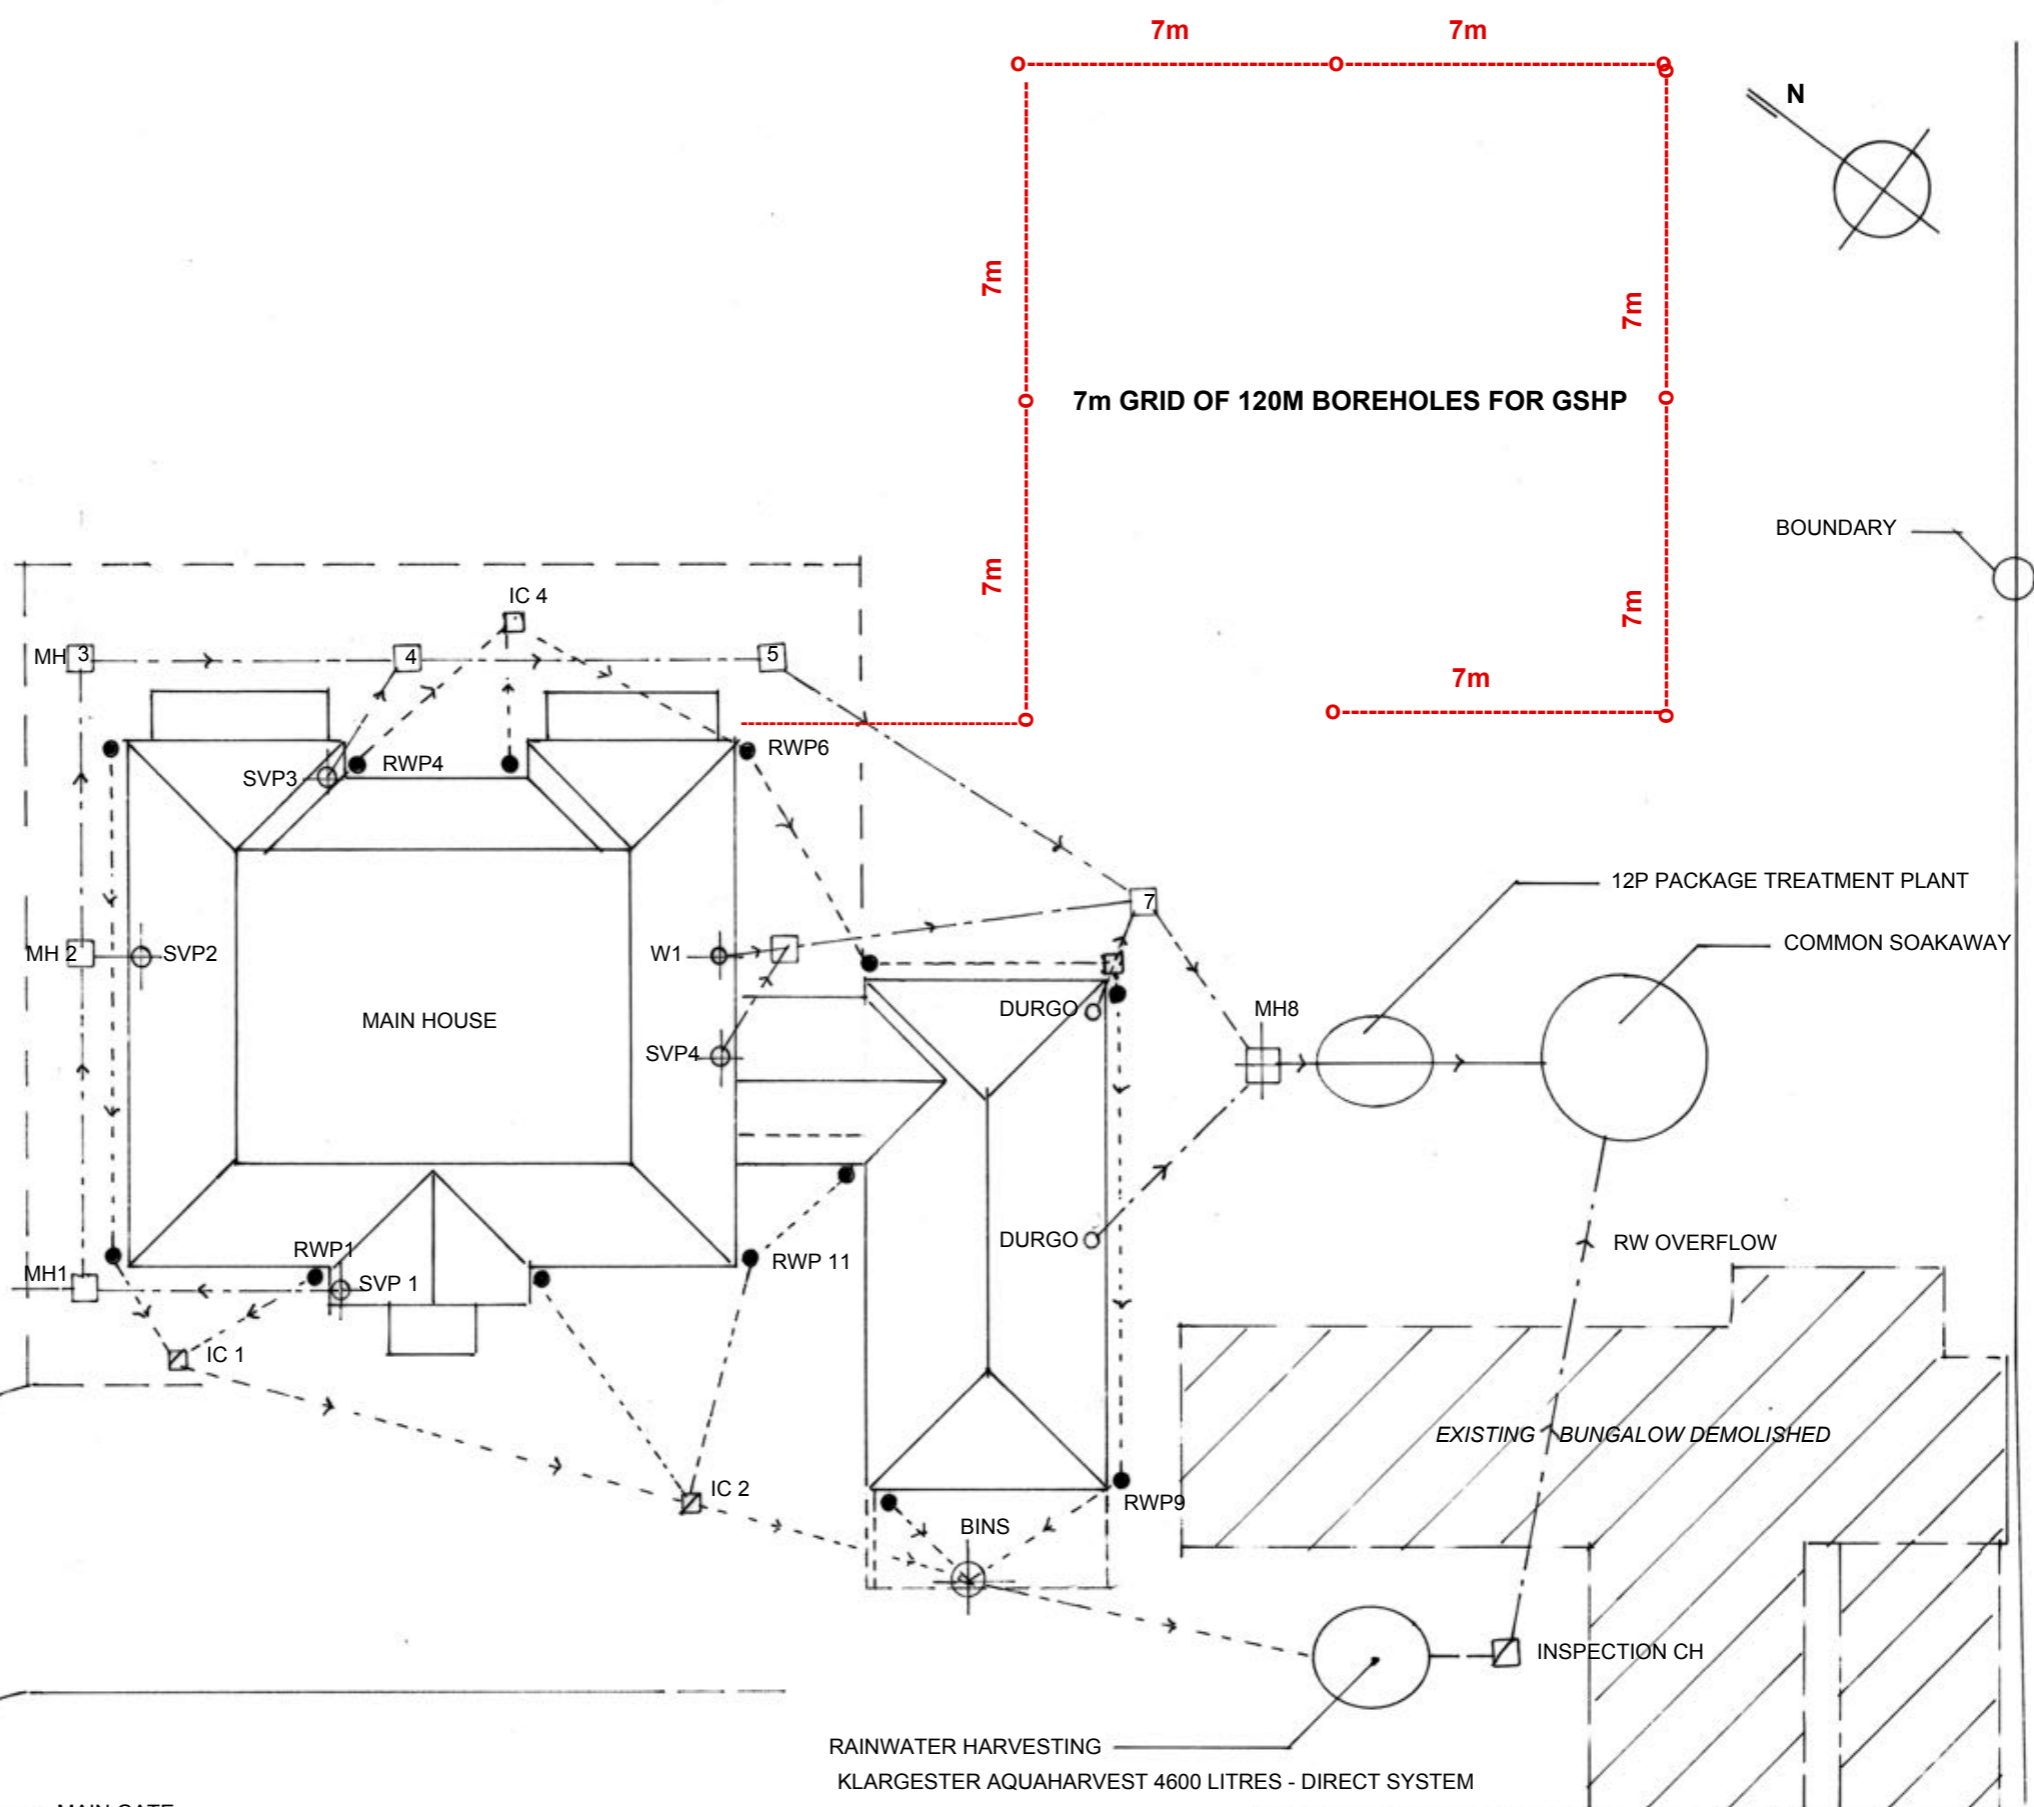

HIGHFIELDS WHEMPSTEAD ROAD WHEMPSTEAD – WARE – SG12 0PG	ALP ARIKOGLU RIBA Chartered Architect	
PROPOSED REPLACEMENT DWELLING WD's PLUMBING AND DRAINAGE SITE PLAN	Kimpton Mill Codicote Hertfordshire SG4 8ST	Tel 07973 221 618 email alp@arikoglu.co.uk
SCALE: 1:200 @ A3	JOB: 2022021	4.00