


NOTE




Not within Scope of Works

New Build Show Bar
Not within Scope of Works


Building location on site plan TBC

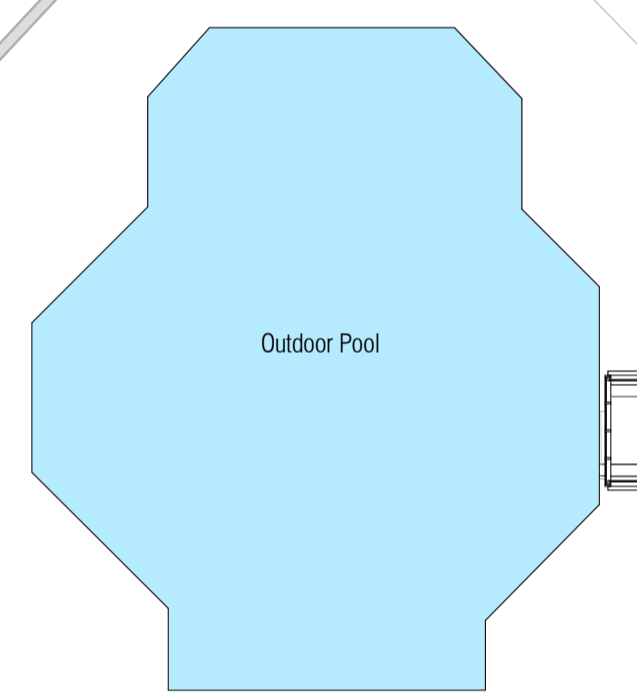


Outdoor Pool

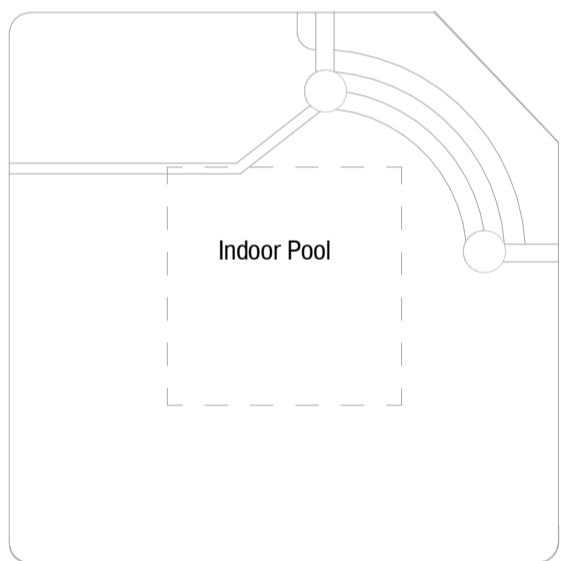

Indoor Pool

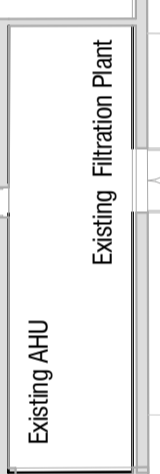

Existing Filtration Plant

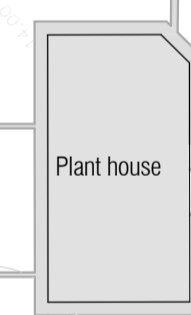

Plant house




Cold Store



Sub Station

Revision	Date	Description	By/Ch
P 01	11/05/2023	Issued for Planning	

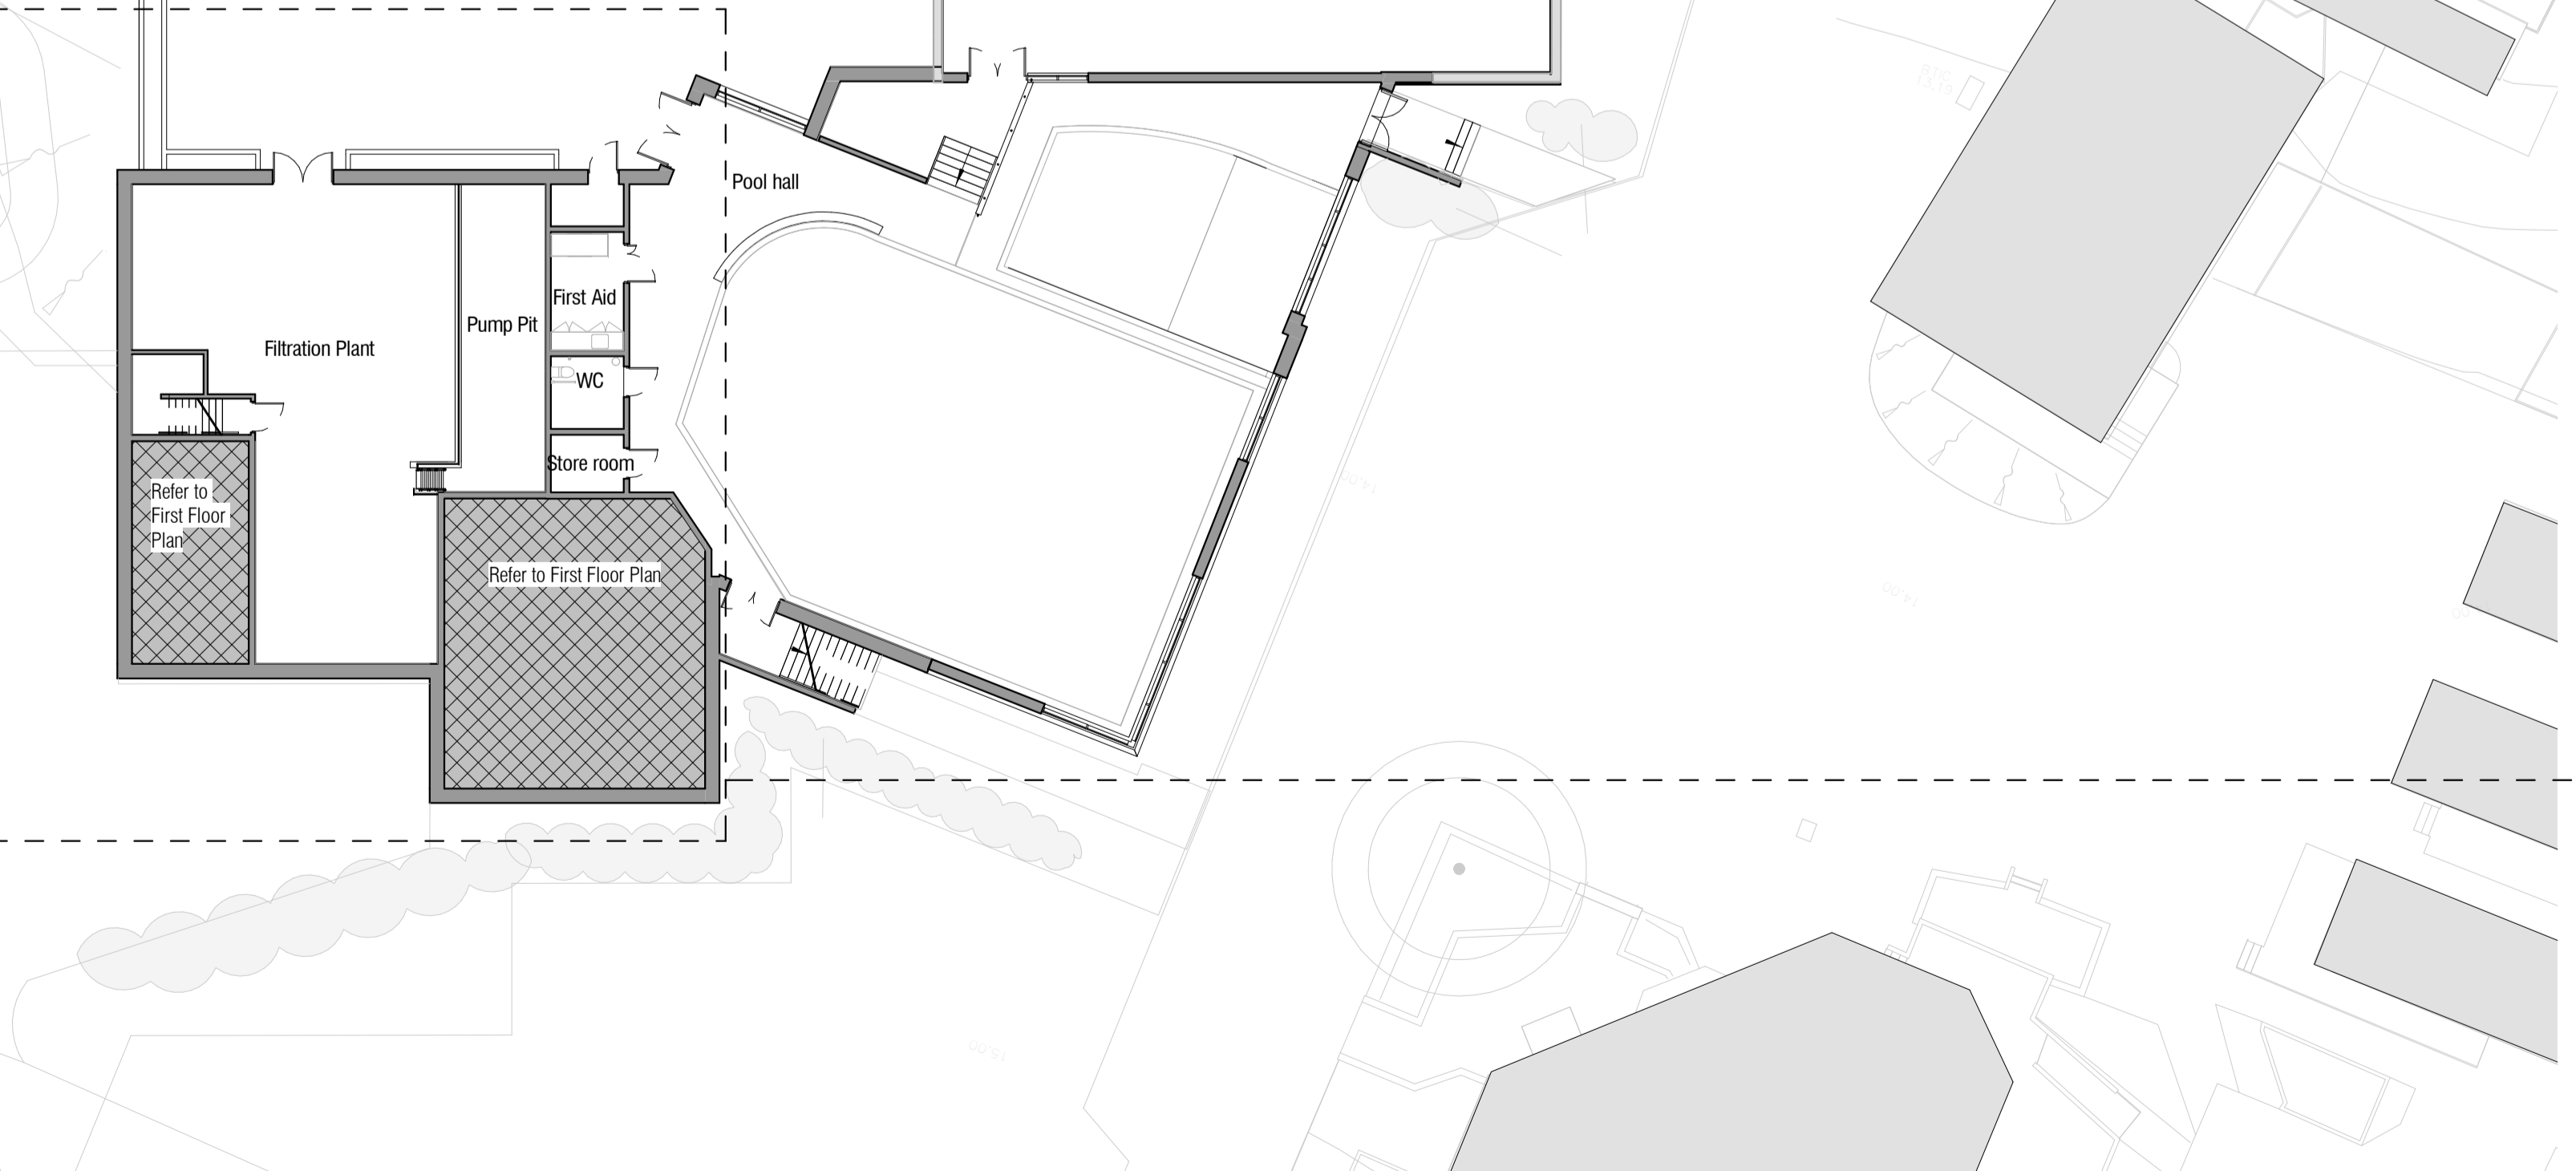

Filtration Plant

Pump Pit

First Aid


WC

Store room

Pool hall

Refer to First Floor Plan

Refer to First Floor Plan

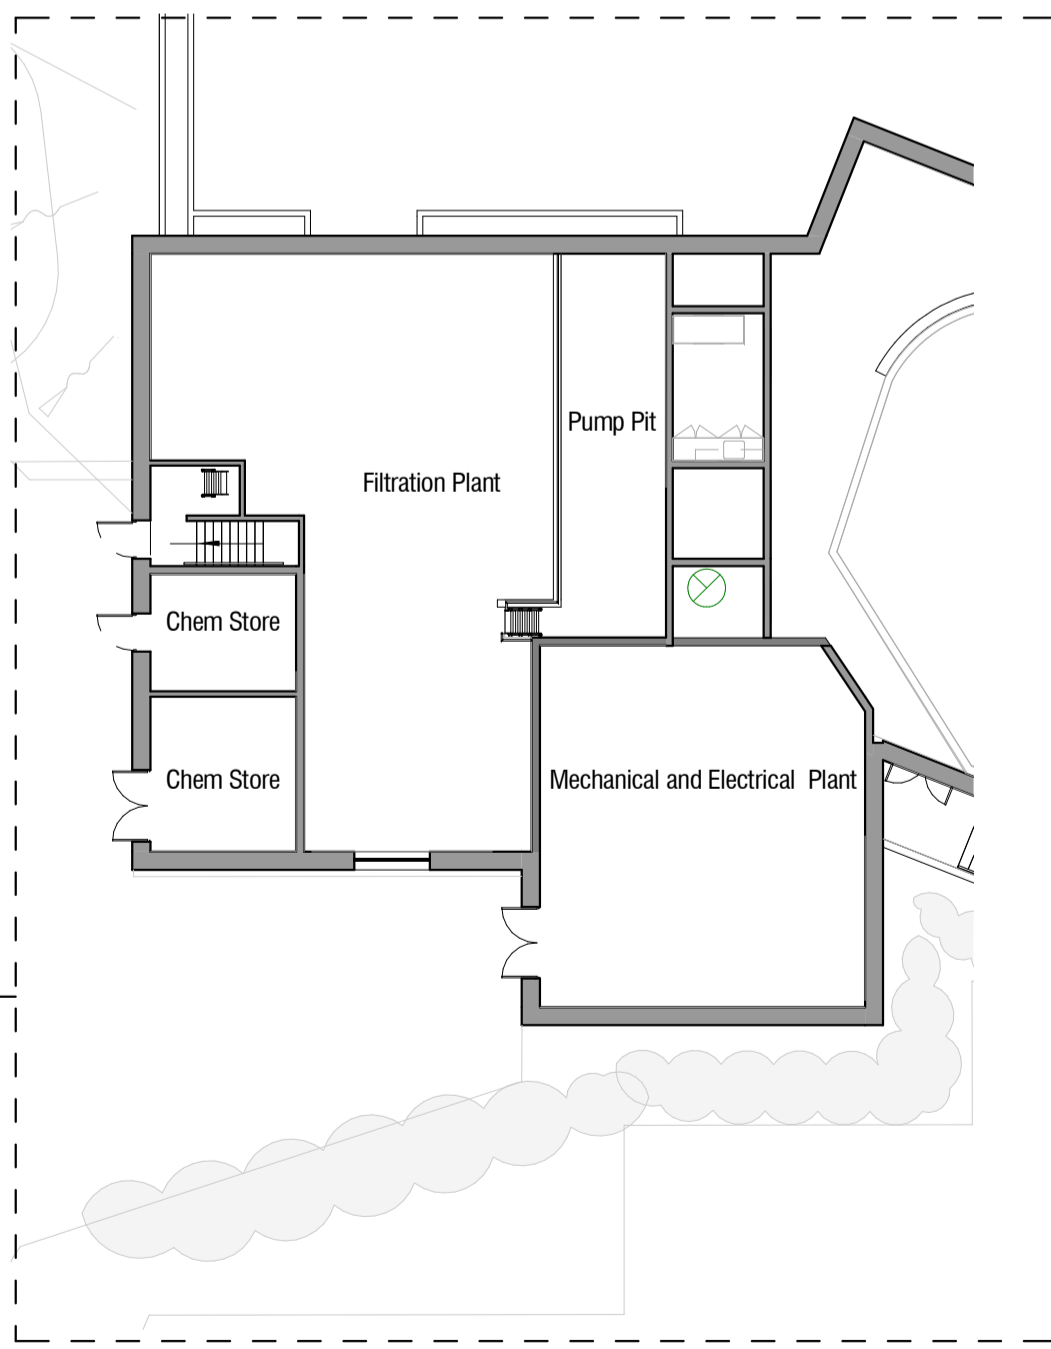

Filtration Plant

Pump Pit


Chem Store

Chem Store

Mechanical and Electrical Plant

Level 1 Plant GA Plan

1 : 200

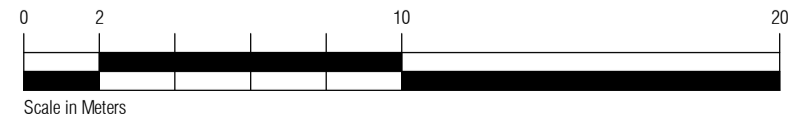

Ground Floor - Proposed Plan

1 : 200

CLIENT
Haven Leisure Ltd.



+44 800 909 8008 answers@space-place.com www.space-place.com

SUITABILITY
ISSUED FOR PLANNING

PROJECT
Haven Holiday Parks
Allhallows

DRAWING
GA Building Plan Proposed

SCALE 1 : 200 SHEET SIZE A1 DRAWN BY JW CHECKED BY S&P DATE 28/04/23

DRAWING NO. REVISION
3893 - ASP - B1 - 00 - DR - A - 0831 - P 01

This drawing must not be reproduced in whole or part without written consent. Do not scale this drawing. All dimensions in millimetres. Written dimensions to be checked on site. Electronic issue to be controlled by space place only. ©SPACE PLACE. All Rights Reserved.