


NOTES

1. Do not scale this drawing.
2. All dimensions are in millimetres unless stated otherwise.
3. This drawing to be read in conjunction with all other relevant drawings and specifications.
4. All proprietary items to be installed in strict compliance with manufacturers instructions and recommendations.

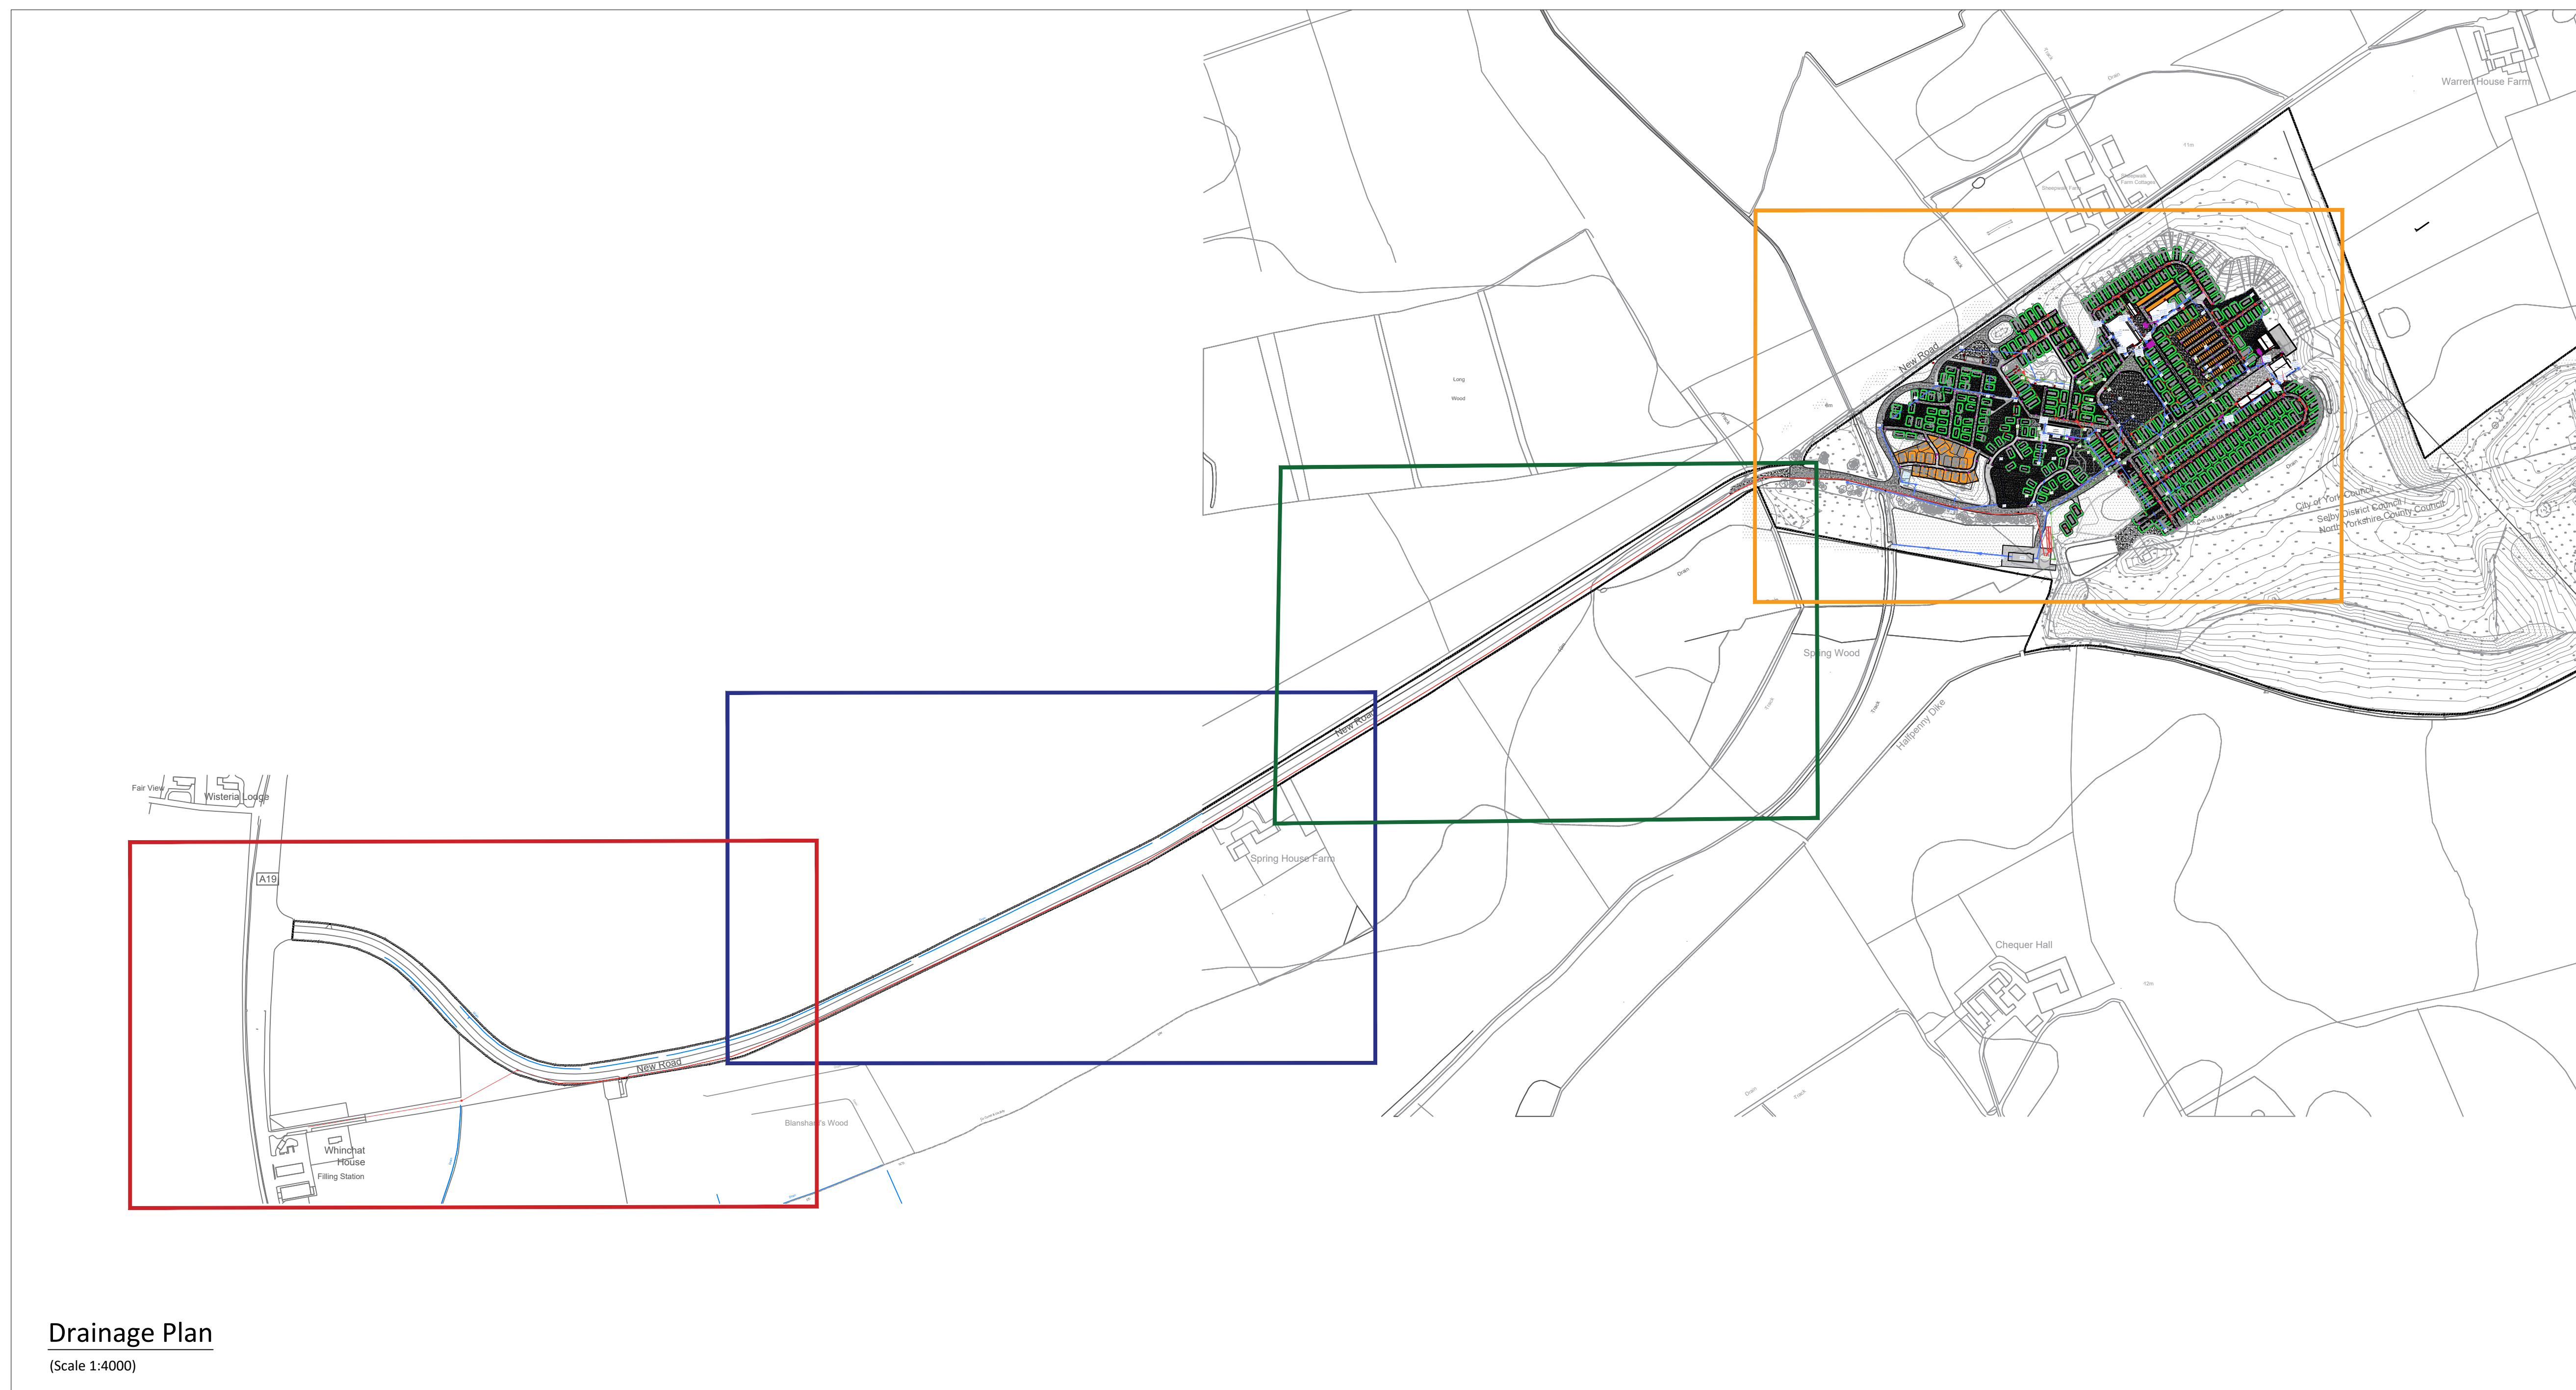

Drainage Plan

(Scale 1:4000)

CONSTRUCTION DESIGN AND MANAGEMENT REGULATIONS 2015
 THE CONTRACTORS ATTENTION IS DRAWN TO THE ABNORMAL RISKS IDENTIFIED BELOW, ANNOTATED ON THE DRAWING AND EXPLAINED IN THE ASSOCIATED DESIGN RISK REGISTERS

LEGEND

- YOU MUST NOT DO
- HAZARD OR DANGER
- YOU MUST DO
- CAUTION

ABNORMAL RISKS IDENTIFIED:

P02 Amended Drawing Key EP 03-01-23

Client
Regent Parks

Project
Selby Park

Title
Key plan

Job No
22121

Drawing No **22121-001** Rev **P02**

Status
Preliminary

Scale **1:4000@A1** Date **20-10-2022**

Project Engineer **TBP** Drawn By **KP**
 Checked By **TBP**
 Approved By

Key

EF-EDGING OF FOOTPATH	Proposed Private Surface Water Pipeline
Existing Impermeable Area	Existing Private Foul Water Manhole
Proposed Permeable Paving	Existing Private Foul Water Pipeline
Proposed Grass Area	Proposed Private Foul Water Manhole
Proposed Gravel Strip Area	Proposed Private Foul Water Pipeline
Tarmac Access Road	Proposed Pumping Station
Existing Private Storm Water Manhole	
Existing Private Surface Water Pipeline	
Proposed Soakaway System	



Providing engineering solutions for the Built Environment
 4 Angel House, Eastgate, Whittlesey, Peterborough, PE7 1SE
 07961 783825
www.parsonsenvironment.co.uk