



Do not scale and use specified dimensions only. All levels, dimensions and measurements are to be checked on site prior to commencement of works. Any discrepancies must be brought immediately to the architect's attention. This drawing is the property of WellSpace Architects Ltd. Copyright and design right are reserved by them. This drawing is issued on the condition that it is not copied either wholly or in part without the written consent of WellSpace Architects Ltd. No liability will be accepted for amendments made by any other persons. This drawing is to be read in conjunction with all relevant drawings, specifications and consultants' information and comply to updated UK legislation. All temporary works are to be the responsibility of the Contractor.

Notes

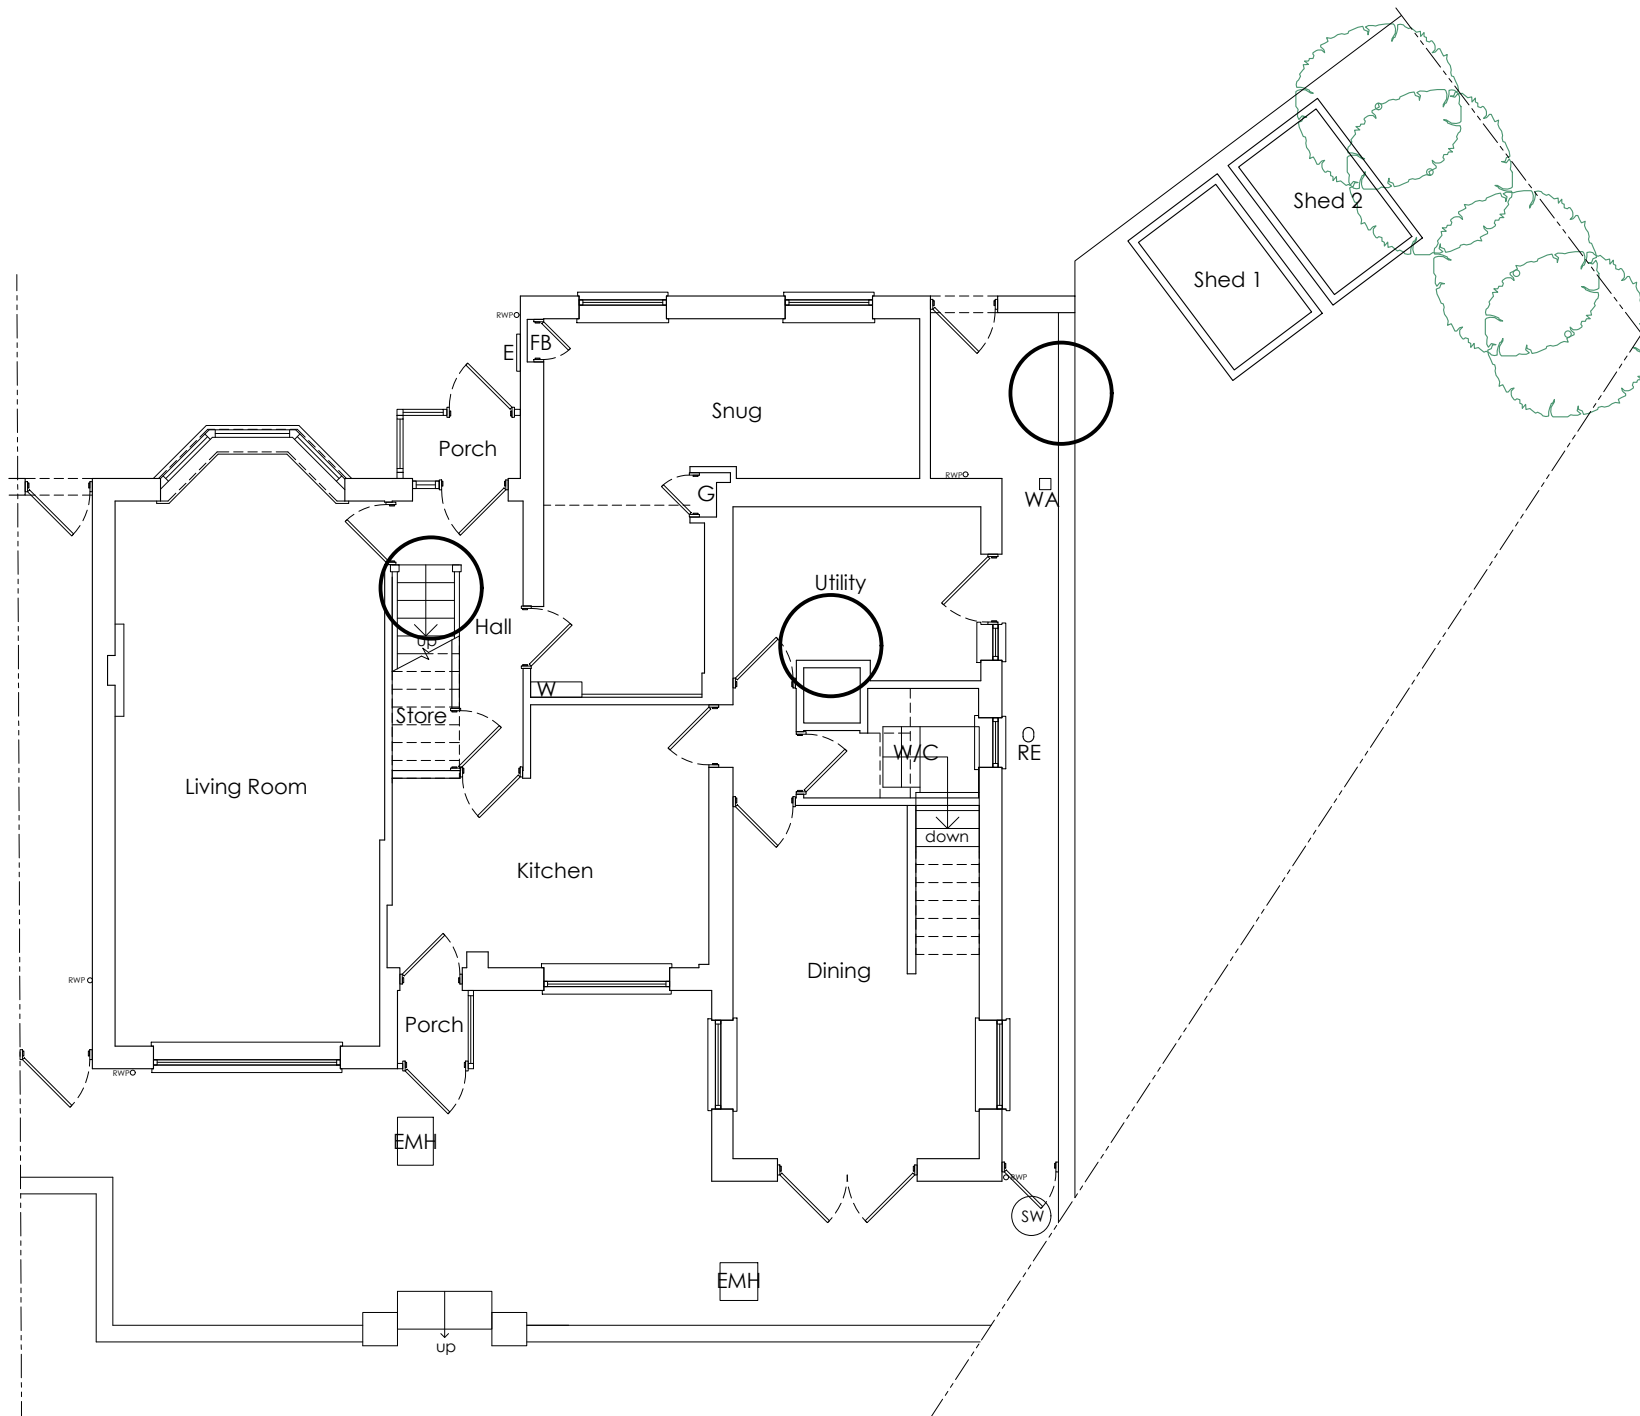


EXISTING GROUND FLOOR

 Scale 1:100



Legend

- EMH Existing Manhole
- SW Storm Water
- E Electricity Meter
- G Gas Meter
- W Water Meter
- B Boiler
- FB Fuse Board
- WA Water Access
- RE Rodding Eye

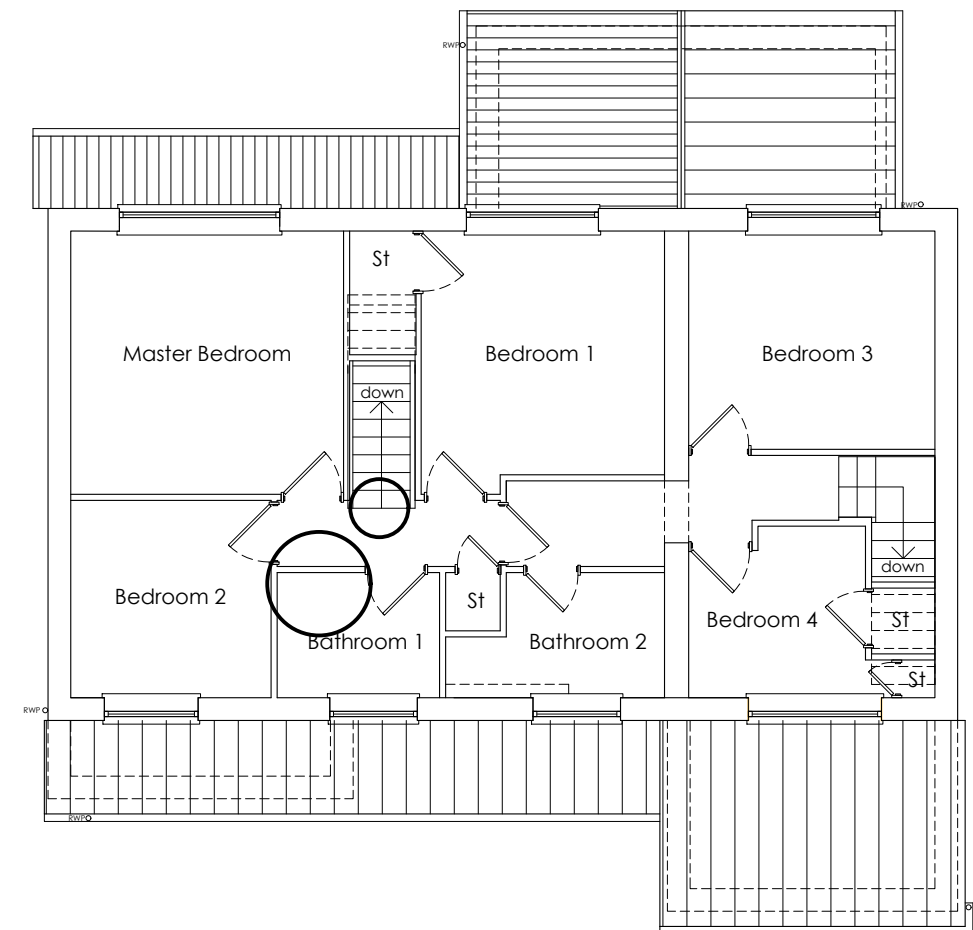

EXISTING FIRST FLOOR

Revision	Description	Date
Client	Louise Panayides	
Project	23 Lindhurst Drive Hockley Heath Soliuhull B94 6QD	
Title	Existing Floor Plans	
Drawn	BD	Checked MP
Status	PLANNING	Date 02/09/2022
Job No.	22011	Drwg No. A-P100 Rev XX Scale 1:100@A3

**DESIGN WELL
LIVE BETTER**

WellSpace Architects Ltd.
Suite 2A Blackthorne House, St Paul's
Square, Birmingham, B3 1RL
0121 751 8183
hello@wellspacearchitects.com
www.wellspacearchitects.com